


1 MAIN FLOOR PLAN - SERVICE BAY, B-SECTION AND TRACK 1-12 - DEMOLITION - ELECTRICAL
 SCALE: 1/8" = 1'-0"

GENERAL NOTES

- A. ELECTRICAL SUBCONTRACTOR TO VISIT SITE DURING BID AND VERIFY ALL EXISTING SERVICES ON SITE PRIOR TO SUBMITTING BID. REPORT ANY DISCREPANCIES TO CONTRACT ADMINISTRATOR DURING BID PERIOD.
- B. FOR ALL EXISTING ELECTRICAL DEVICES, EQUIPMENT, ETC. THAT ARE TO BE REMOVED, REMOVE EXISTING CONDUIT, WIRING, CONTROL PANEL, MOTOR STARTER, ETC. BACK TO SOURCE UNLESS OTHERWISE NOTED. TURN BREAKER OFF. MARK AS SPARE. UPDATE PANEL DIRECTORY AND LABELLING. FOR CONDUITS EMBEDDED IN FLOOR SLAB, REMOVE WIRING, CUT CONDUIT AT FLOOR LEVEL AND SEAL CONDUIT.
- C. EXISTING EQUIPMENT TO BE OFFERED TO THE CITY UPON REMOVAL. DISPOSE OF EQUIPMENT UPON THE CITY'S REQUEST.
- D. COORDINATE WITH THE CITY PRIOR TO SHUT-DOWN OR REMOVAL OF EQUIPMENT.
- E. ALL MENTIONED EQUIPMENT AND SERVICES WITHIN AREA OF WORK SHALL BE REMOVED.
- F. THIS BUILDING MAY CONTAIN ASBESTOS. REFER TO FRONT END SPECIFICATIONS FOR FURTHER INFORMATION.
- G. FIRE STOP ALL PENETRATIONS LEFT BY DEMOLITION OF CABLE/CONDUITS.
- H. ELECTRICAL SUBCONTRACTOR TO VERIFY ALL EXISTING CIRCUITING ON SITE PRIOR TO DISCONNECTION OF LOADS.

DEMOLITION NOTES

- 1. DISCONNECT EXISTING INFRA RED HEATER TO BE DEMOLISHED BY MECHANICAL. REMOVE CONDUIT, WIRE, ETC. BACK TO SOURCE. RETAIN SECTION OF WIRING/CONDUIT FEEDING IH-64 (TO REMAIN). REFER TO KEY NOTE 3.
- 2. DISCONNECT EXISTING INFRA RED HEATER TO BE DEMOLISHED BY MECHANICAL. REMOVE CONDUIT, WIRE, ETC. BACK TO SOURCE. PRIOR TO REMOVAL, INSPECT AND PERFORM INSULATION RESISTANCE (MEGGER) TEST ON EXISTING WIRING. IF WIRING FAILS TEST AND INSPECTION, PROVIDE CASH CREDIT FOR WIRE REMOVAL AND NEW WIRING (REFER TO E2.2 KEY NOTE 8). CREDIT TO BE ACCEPTED AT THE DISCRETION OF THE CITY.
- 3. EXISTING INFRA RED HEATER TO REMAIN. RETAIN SECTION OF WIRING IN EXISTING CIRCUIT. EXTEND WIRING/CONDUIT AS REQUIRED.

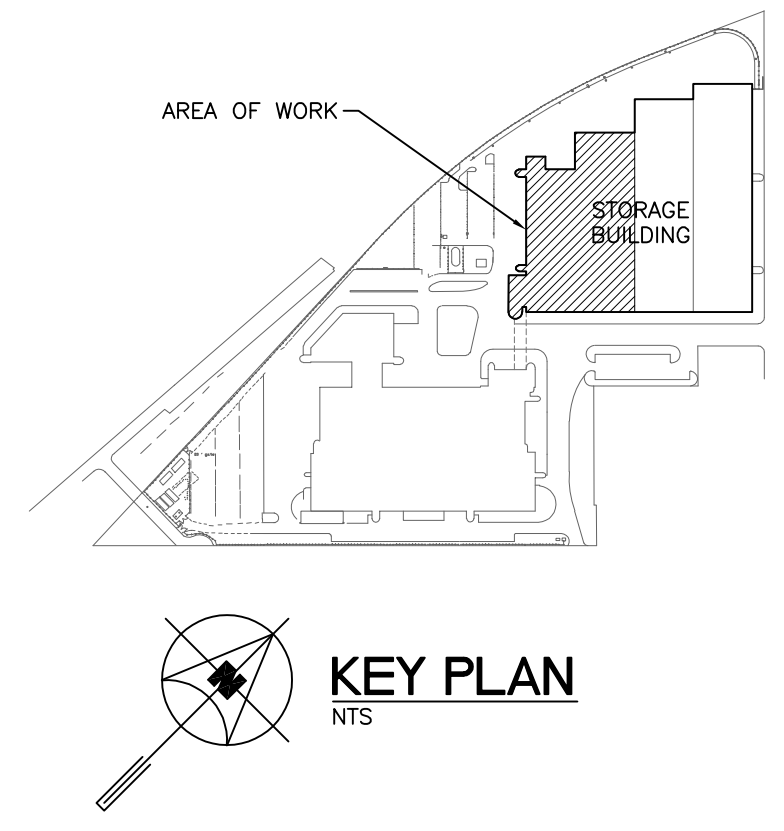

KEY PLAN

0	ISSUED FOR CONSTRUCTION	VEK	09/11/18
NO.	Description	BY	EDM/MTY



770 Bradford Street
 Winnipeg, Canada
 T 204 775 0291
 SMSeng.com

Project Title
CITY OF WINNIPEG FORT ROUGE TRANSIT BASE - STORAGE TRACK 13-24 - MECHANICAL UPGRADE

WINNIPEG MANITOBA
MAIN FLOOR - SERVICE BAY, B-SECTION, TRACK 1-12 - DEMOLITION - ELECTRICAL

Drawn By	RD	Checked By	VEK	Approved By	VEK
Scale	AS NOTED	Date	NOVEMBER 2018	Project No.	18-245-011
Revision Number	0	Drawing Number	E1.2	Sheet Order	2 OF 5