


1 MAIN FLOOR PLAN - TRACK 13-24 - DEMOLITION - VENTILATION  
SCALE: 1/8" = 1'-0"

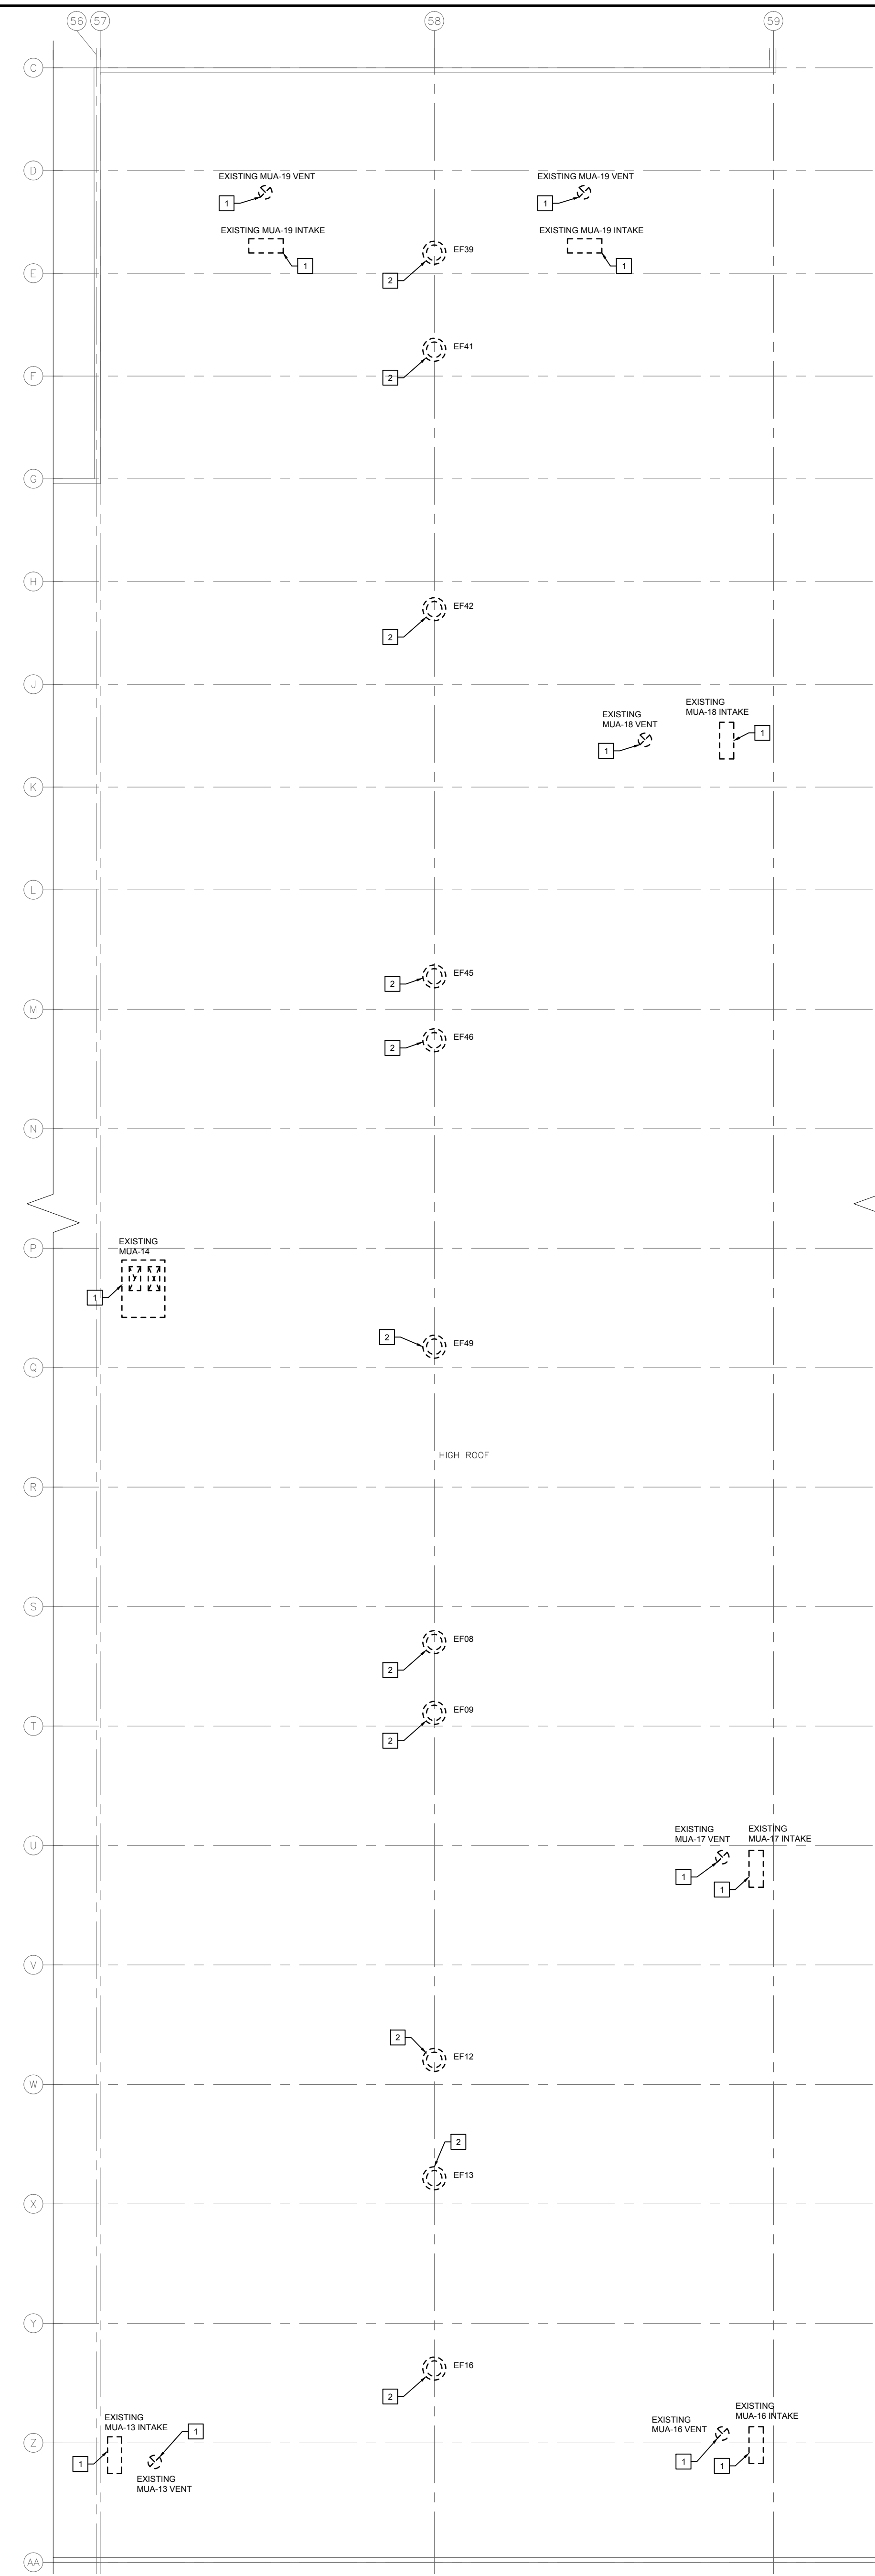


2 ROOF PLAN - TRACK 13-24 - DEMOLITION - VENTILATION  
SCALE: 1/8" = 1'-0"

**GENERAL NOTES**

- A. ALL ABANDONED EQUIPMENT AND SERVICES WITHIN AREA OF WORK SHALL BE REMOVED.
- B. THIS BUILDING MAY CONTAIN ASBESTOS. REFER TO FRONT END SPECIFICATIONS FOR FURTHER INFORMATION.
- C. REFER TO ROOF DETAILS AND SPECIFICATIONS FOR ALL NEW AND CAPPED OPENINGS.

**DEMOLITION KEY NOTES**

1. DEMOLISH AND REMOVE EXISTING MUAS AND ASSOCIATED DUCTWORK, VENTING AND INTAKES. REPAIR AND SEAL ROOF OPENING REFER TO STRUCTURAL AND ROOFING SPECIFICATION (DETAIL S). REMOVE EXISTING CONTROLLERS AND RETURN TO OWNER FOR SPARES. REMOVE DEMOLISHED UNITS FROM BAS.
2. DEMOLISH AND REMOVE EXISTING EXHAUST FANS. REPAIR AND SEAL ROOF OPENING REFER TO STRUCTURAL AND ROOFING SPECIFICATION (DETAIL S). REMOVE DEMOLISHED FAN FROM BAS.
3. DEMOLISH AND REMOVE EXISTING GRILLES AND DUCTWORK.
4. REMOVE EXISTING GRILLES AND DAMPERS AND CAP OFF OPENING. EXISTING DUCTWORK TO REMAIN.
5. REFER TO STRUCTURAL FOR DETAIL FOR INFILLING EXISTING OPENING IN BLOCK WALL TO MAINTAIN FIRE RATING.
6. EXISTING ABANDONED UNDERFLOOR VENTILATION SYSTEM CURB TO BE REMOVED. REFER TO STRUCTURAL.
7. EXISTING SUPPLY FAN TO MCC TO REMAIN.
8. EXISTING FIRE DAMPER TO REMAIN.
9. EXISTING ABANDONED UNDERFLOOR VENTILATION SYSTEM CURB TO REMAIN.

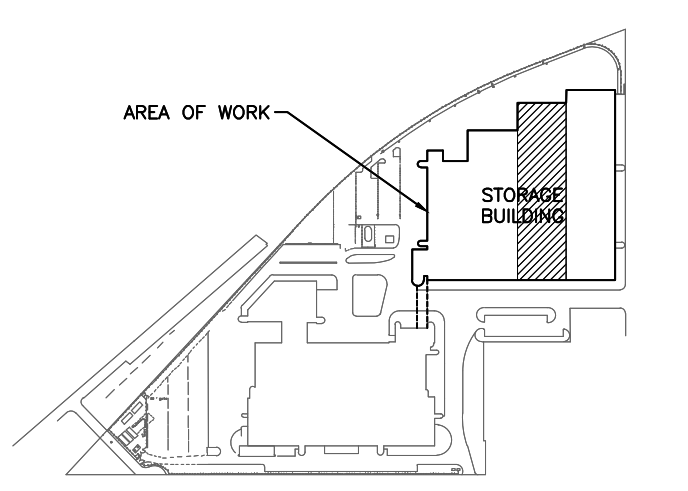

KEY PLAN  
NTS

NO.	Description	BY	DATE
0	ISSUED FOR CONSTRUCTION	JH	09/11/18

770 Bradford Street  
 Winnipeg, Canada  
 T 204 775 0352  
 SMSeng.com

Project Title  
**CITY OF WINNIPEG FORT ROUGE TRANSIT BASE - STORAGE TRACK 13-24 - MECHANICAL UPGRADE**  
 WINNIPEG MANITOBA  
 Drawing Title  
**MAIN FLOOR AND ROOF PLAN - TRACK 13-24 - DEMOLITION - VENTILATION**

Drawn By	Checked By	Approved By
JC/AS	XZ	JH
Scale	Date	Project No.
AS NOTED	NOVEMBER, 2018	18-240-01
Revision Number	Drawing Number	Sheet Order
0	M1.4	4 OF 12