



SUPERSEDED BY DRAWING
1-0640M-E0032 AND
1-0640M-E0034

SUPERSEDED BY DRAWING
1-0640M-E0036

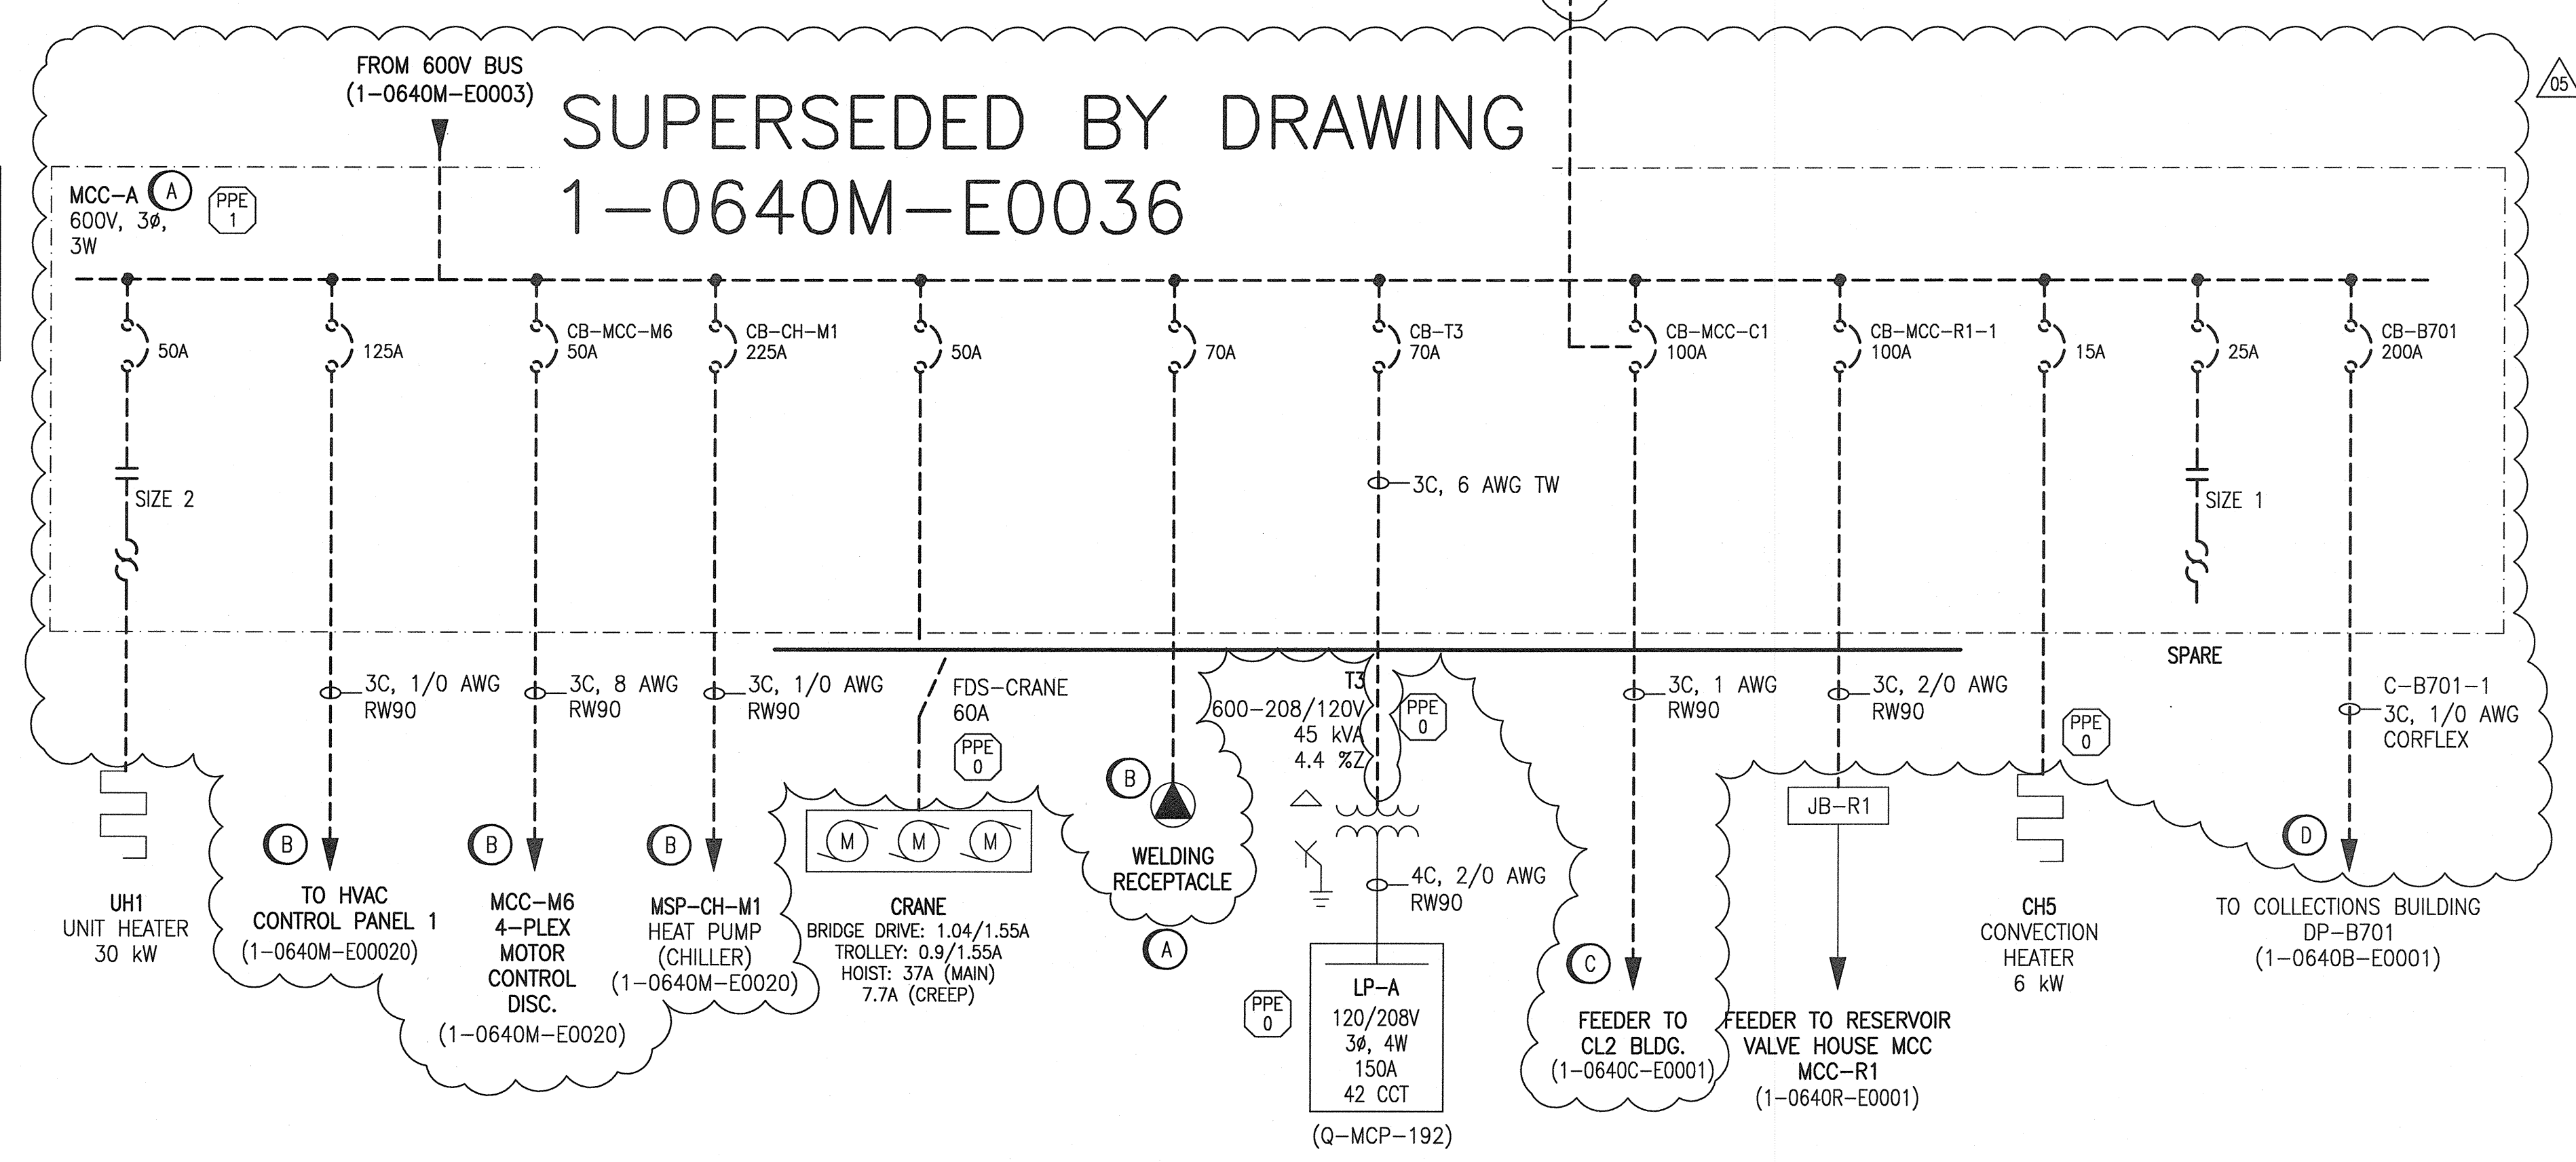

SUPERSEDED BY DRAWING
1-0640M-E0036

- NOTES:**
- THIS DRAWING SUPERSEDES DRAWING Q-MCP-191 AND PART OF DRAWING Q-MCP-192.
 - THIS DRAWING CONTAINS INFORMATION FROM EXISTING CITY OF WINNIPEG DOCUMENTATION.
 - THIS DRAWING IS SUPERSEDED BY 1-0640M-E0032, 1-0640M-E0034 AND 1-0640M-E0036.
 - CLOUDED PORTIONS OF THIS DRAWING INDICATE WORK TO BE COMPLETED. EITHER REMOVALS OR ADDITION AS INDICATED. REFER TO DEMOLITION AND CONSTRUCTION

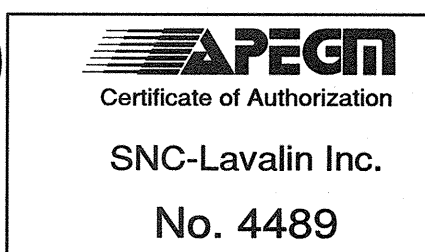

NO.	REVISIONS	DATE	DESIGN	CHECK
05	ISSUED FOR TENDER AND CONSTRUCTION	2019/10/18	VE	KS
04	UPDATED IDENTIFICATION	2017/08/01	BJC	BJC
03	UPDATED AS PER EXISTING	2013/07/23	-	CJR
02	ISSUED FOR REVIEW	2011/11/01	BC	CJR
01	MODIFIED FOR UPS UPGRADES	2009/03/14	CJR	-
00	ISSUED FOR CITY USE	2007/08/28	YM	-

SNC-LAVALIN INC.
148 Nature Park Way
Winnipeg, MB, Canada R3P 0X7
204-786-8080


DESIGNED BY: EXISTING
CHECKED BY: CJR

DRAWN BY: DEB
APPROVED BY: CJR

SCALE: NTS
RELEASED FOR CONSTRUCTION BY: A. WEISS

DATE: 2005/10/25
DATE: 2019/10/18

CONSULTANT NO.: 113292-0005-47DD-0004

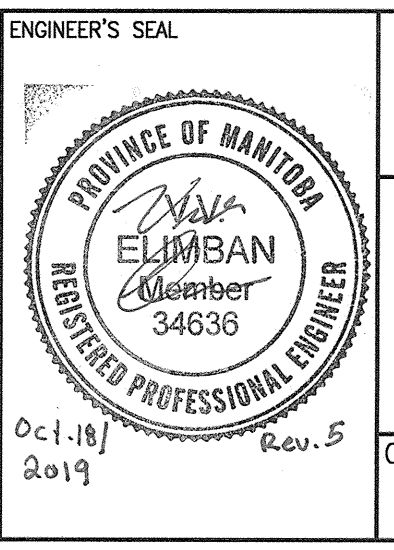

THE CITY OF WINNIPEG
WATER AND WASTE DEPARTMENT

MCPHILLIPS PUMPING STATION

ELECTRICAL SINGLE LINE DIAGRAM
600V DISTRIBUTION

CITY DRAWING NUMBER: 1-0640M-E0004
SHEET: 001
REV: 05
SIZE: A1