



TRUCK SCALE No.1
1:50

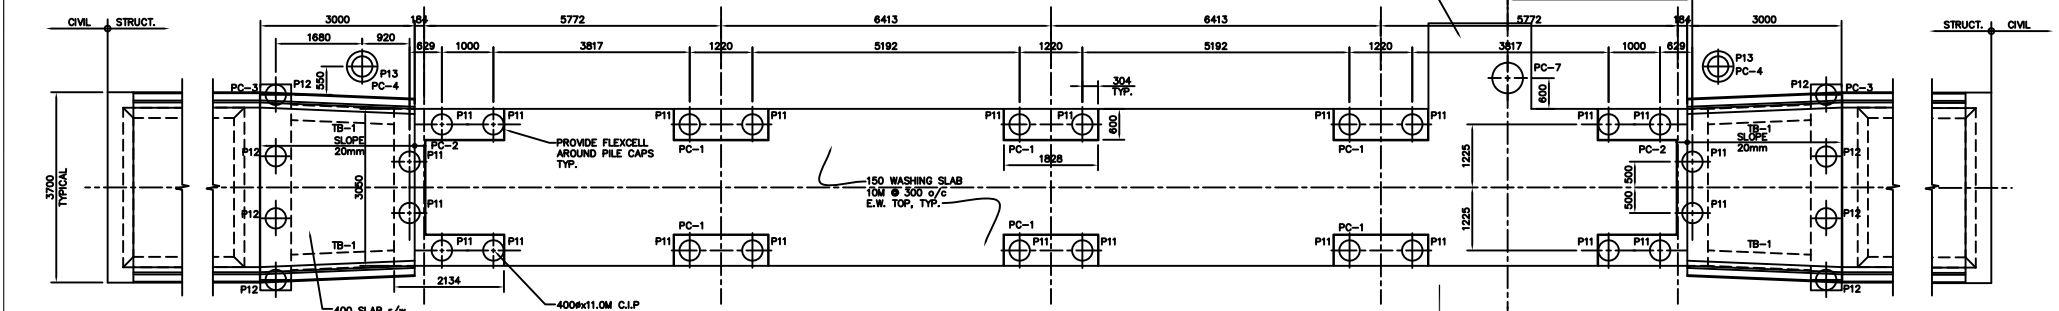

TRUCK SCALE No.2
1:50

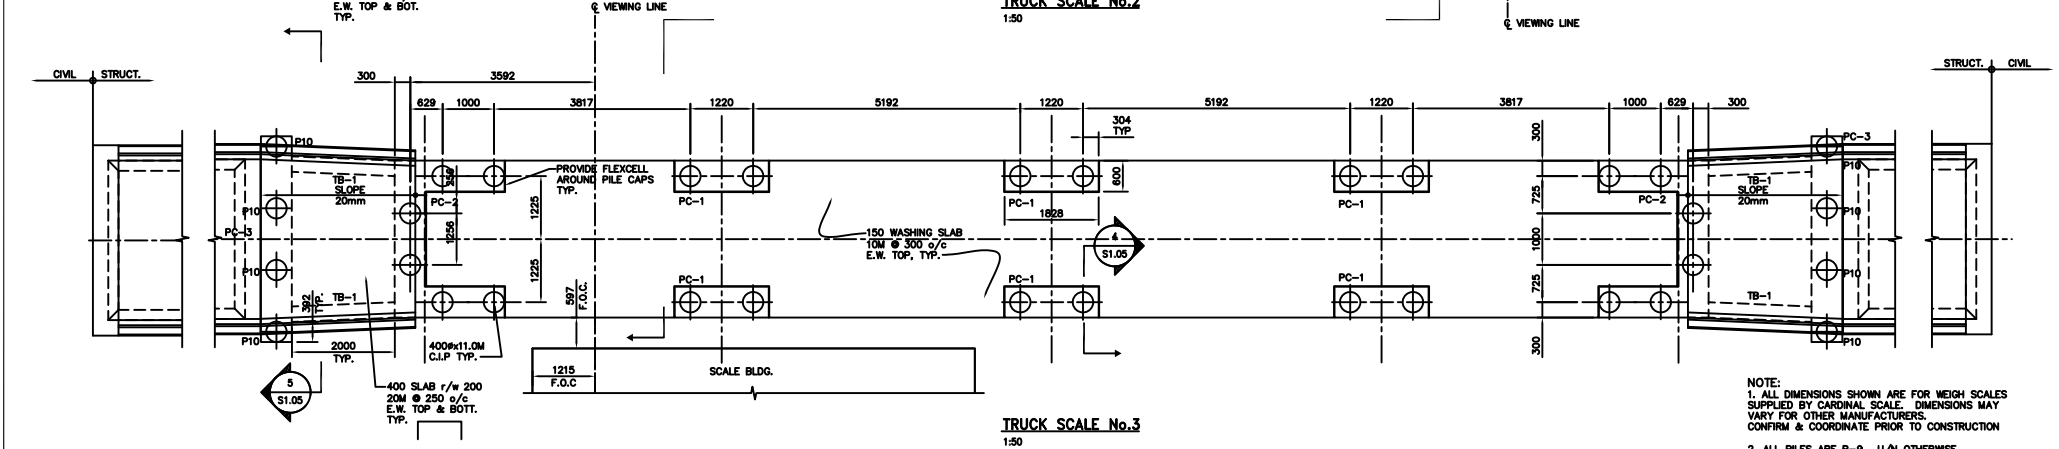

TRUCK SCALE No.3
1:50

NOTE:
1. CONSTRUCTION DRAWING FOR INFORMATION ONLY
2. CONTRACTOR MUST VERIFY ALL FIELD MEASUREMENTS PRIOR TO FABRICATION OF SCALES

NOTE:
1. ALL DIMENSIONS SHOWN ARE FOR WEIGH SCALES SUPPLIED BY CARDINAL SCALE. DIMENSIONS MAY VARY FOR OTHER MANUFACTURERS. CONFIRM & COORDINATE PRIOR TO CONSTRUCTION
2. ALL PILES ARE P-9, U/N OTHERWISE.

 Certificate of Authorization Earth Tech Canada Inc. No. 730	B.M. ELEV.	DESIGNED BY LLR/GGP DRAWN BY KK	CHECKED BY GGP APPROVED BY TGS	ENGINEER'S SEAL ORIGINAL SIGNED BY M. KLASSEN 2007/07/20	 THE CITY OF WINNIPEG WATER AND WASTE DEPARTMENT SOLID WASTE SERVICES DIVISION BRADY RD. LANDFILL NEW ENTRANCE AND SCALE FACILITY STRUCTURAL TRUCK SCALE FOUNDATION PLANS	CITY FILE NUMBER
	02 ISSUED FOR CONSTRUCTION 07/06/07 LAE 01 357-2007 ADDENDUM 1 07/07/07 CMF	SCALE: AS NOTED	RELEASED FOR CONSTRUCTION BY: V. JEANCART	SHEET OF		
	NO. REVISIONS	DATE BY	DATE 2006/07/24	DATE 2007/07/20		CITY DRAWING NUMBER
	CONSULTANT DRAWING NO. S1.04	S1.04	S1.04	S1.04		S1.04