

KEY NOTES


- 1 EXISTING WATER METER TO BE REMOVED COMPLETE WITH INCOMING SERVICE MAIN BACK TO OUTSIDE BUILDING. COORDINATE WITH CIVIL.
- 2 EXISTING INCOMING SERVICE MAIN FROM CITY SERVICE TO BE REMOVED.
- 3 EXISTING FIXTURE SHALL BE REMOVED. CONNECTIONS TO REMAIN FOR RECONNECTION TO NEW FIXTURE. REFER TO RENOVATION PLANS.
- 4 DEMOLISH EXISTING SANITARY STACK AT HIGH LEVEL TO ACCOMMODATE RELOCATION IN RENO WORK.

PUBLICCITY


Public City Architecture Inc
 11-600 Clifton Street
 Winnipeg, Manitoba
 R3G 2X6 204 475 9323
 publiccityarchitecture.com

Rev. No. Date Revision Notes

0 19-11-06 Issued for Construction

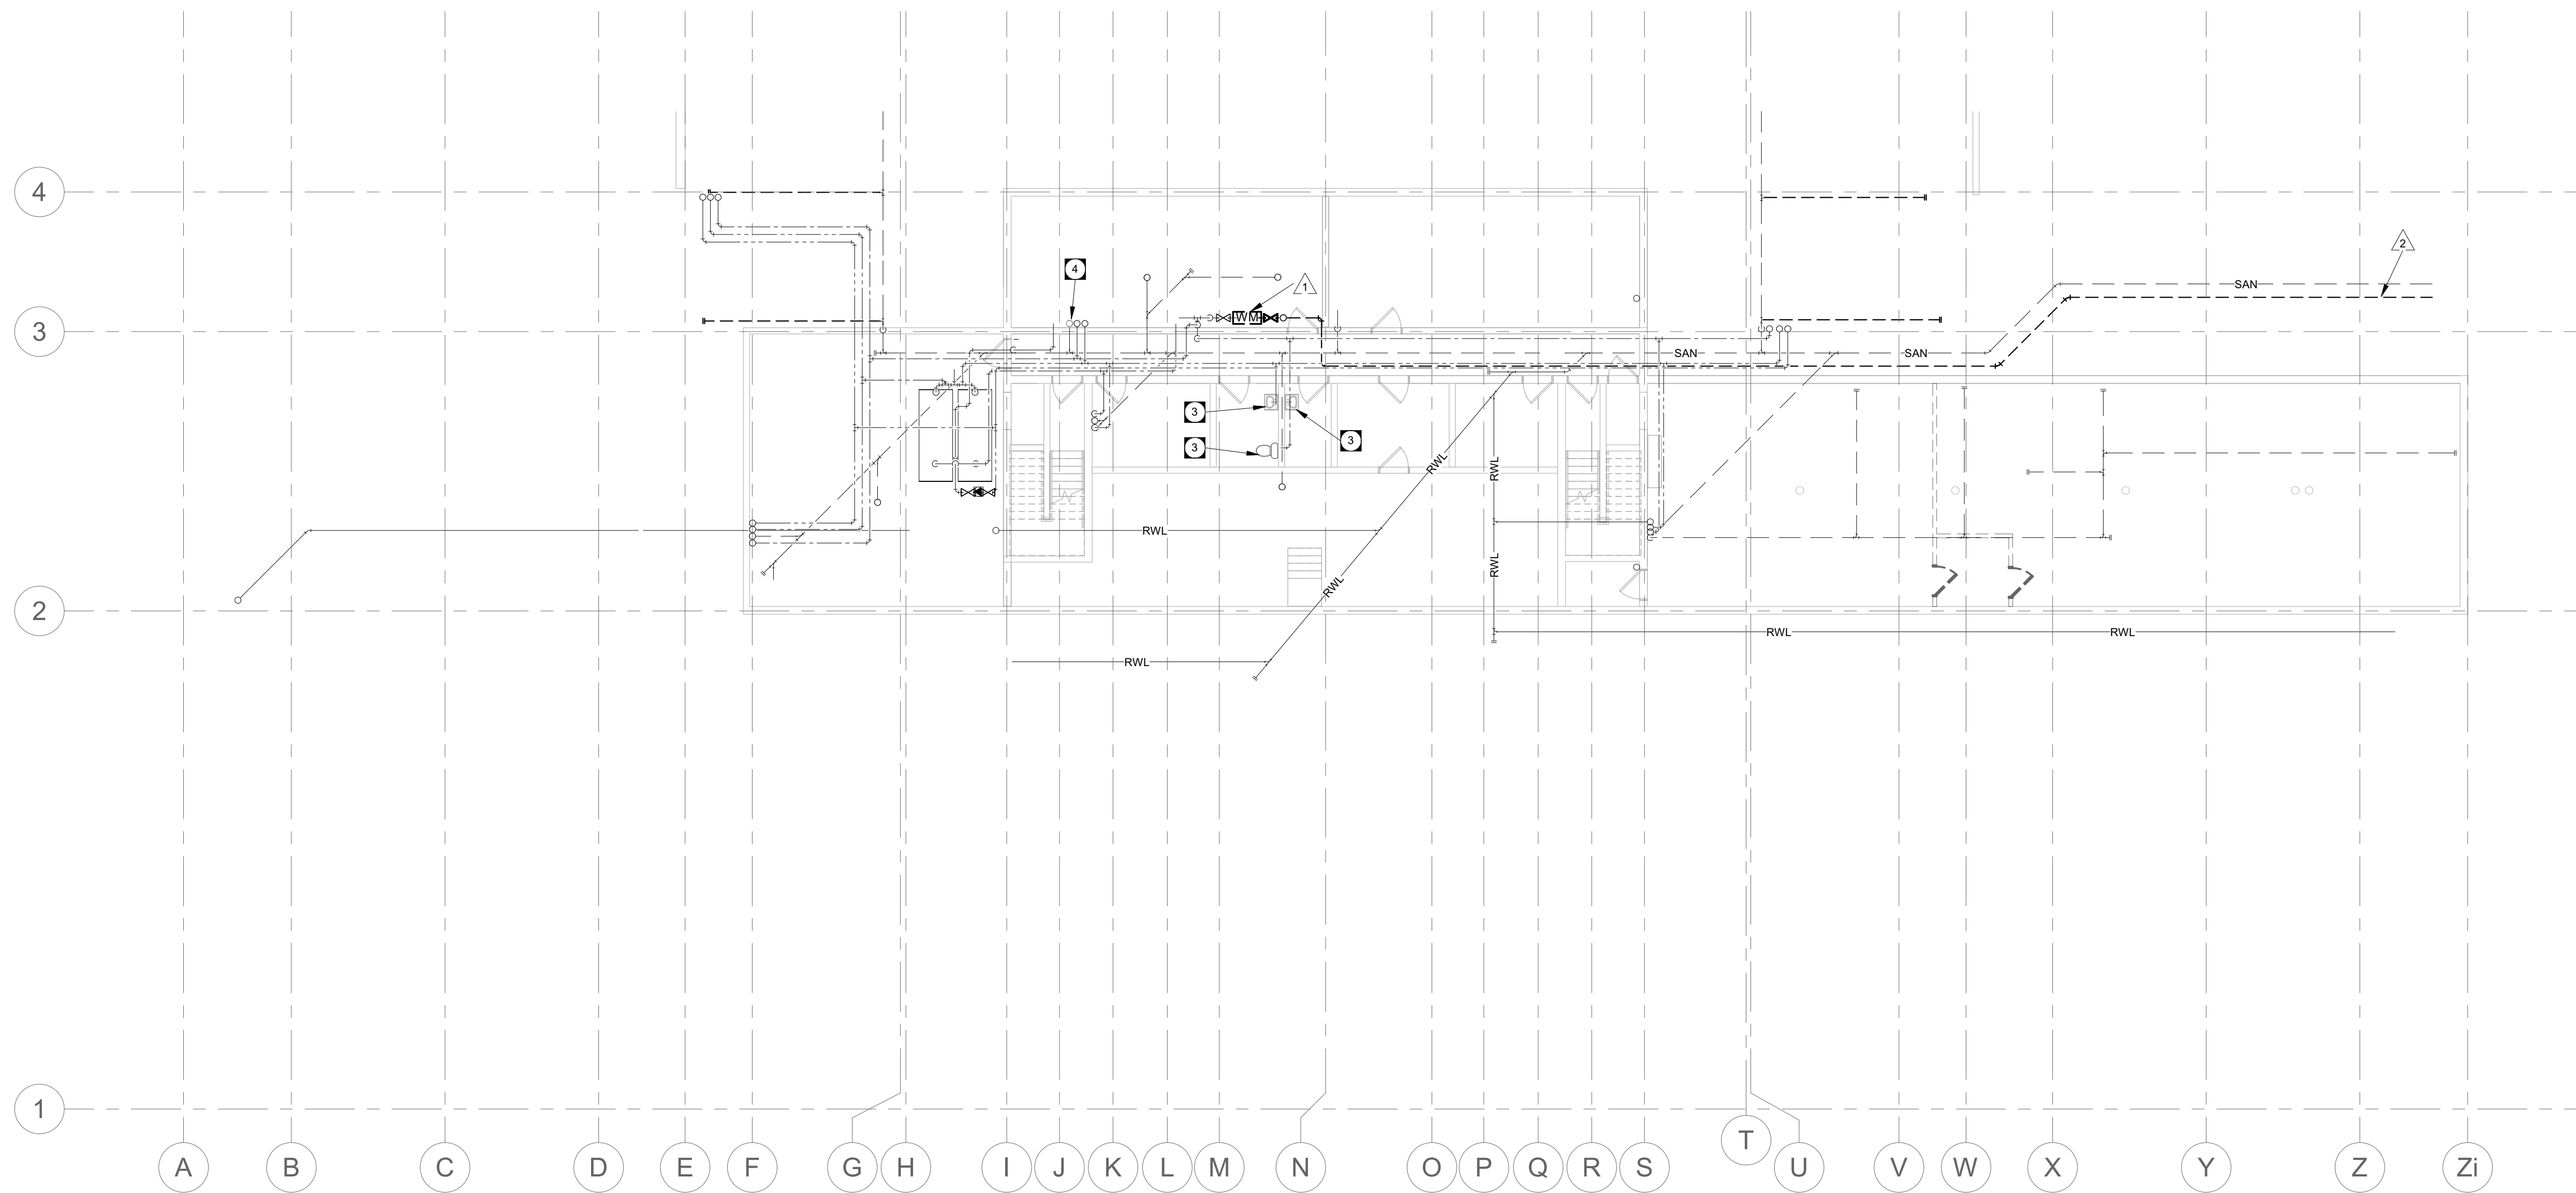


BASEMENT - PLUMBING DEMOLITION 1
 3/32" = 1'-0" MP2.0

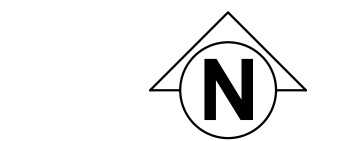

APEGM
 Certificate of Authorization
 Epp Siepmann Engineering Inc.
 No. 4035

This is a print of a document that has been electronically authenticated with technology authorized by the APEGM. The original is in electronic form.

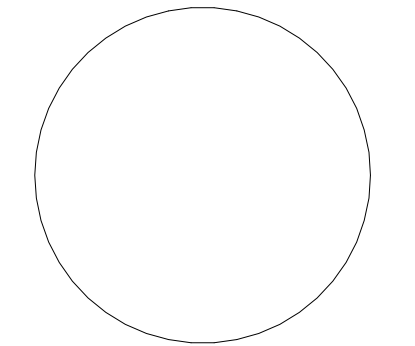

This drawing must not be scaled. The contractors shall verify all dimensions and other data on site prior to commencement of work. Discrepancies, errors, and omissions are to be reported to Public City Architecture Inc. prior to proceeding with the Work.
 Drawings and specifications as instruments of service are the property of Public City Architecture Inc. the copyright in the same being reserved.
 No reproduction or revision to these drawings may be made without the permission of Public City Architecture Inc., and when made, must bear their name. All prints to be returned to Public City Architecture Inc. upon request.

Project
ST. JAMES CIVIC CENTRE

Drawing
BASEMENT DEMOLITION - PLUMBING PLAN

Drawn By: DK Review By: JS
 Scale: 3/32" = 1'-0" Tender No: 1176-2019
 Date: 11/06/19
 Sheet: **MP2.0**