

KEY NOTES


- 1 EXISTING FIXTURES TO BE DEMOLISHED COMPLETE WITH PIPING BACK TO MAINS.
- 2 EXISTING FIXTURES TO BE REMOVED. PIPING CONNECTIONS TO REMAIN FOR REUSE BY NEW FIXTURES.
- 3 EXISTING PLUMBING MAINS TO REMAIN.
- 4 EXISTING PLUMBING PIPING TO REMAIN.
- 5 EXISTING RWL DOWN FROM BASEMENT.
- 6 EXISTING SANITARY AND DOMESTIC RISERS TO REMAIN.
- 7 DISCONNECT ARENA RECIRCULATION PIPING AT THIS LOCATION. CAP OPEN ENDS.
- 8 DEMOLISH EXISTING SANITARY STACK ABOVE MAIN FLOOR LEVEL TO ACCOMMODATE RELOCATION IN RENO WORK.

PUBLICCITY



Public City Architecture Inc
 11-600 Clifton Street
 Winnipeg, Manitoba
 R3G 2X6 204 475 9323
 publiccityarchitecture.com

Rev. No. Date Revision Notes

0 19-11-06 Issued for Construction

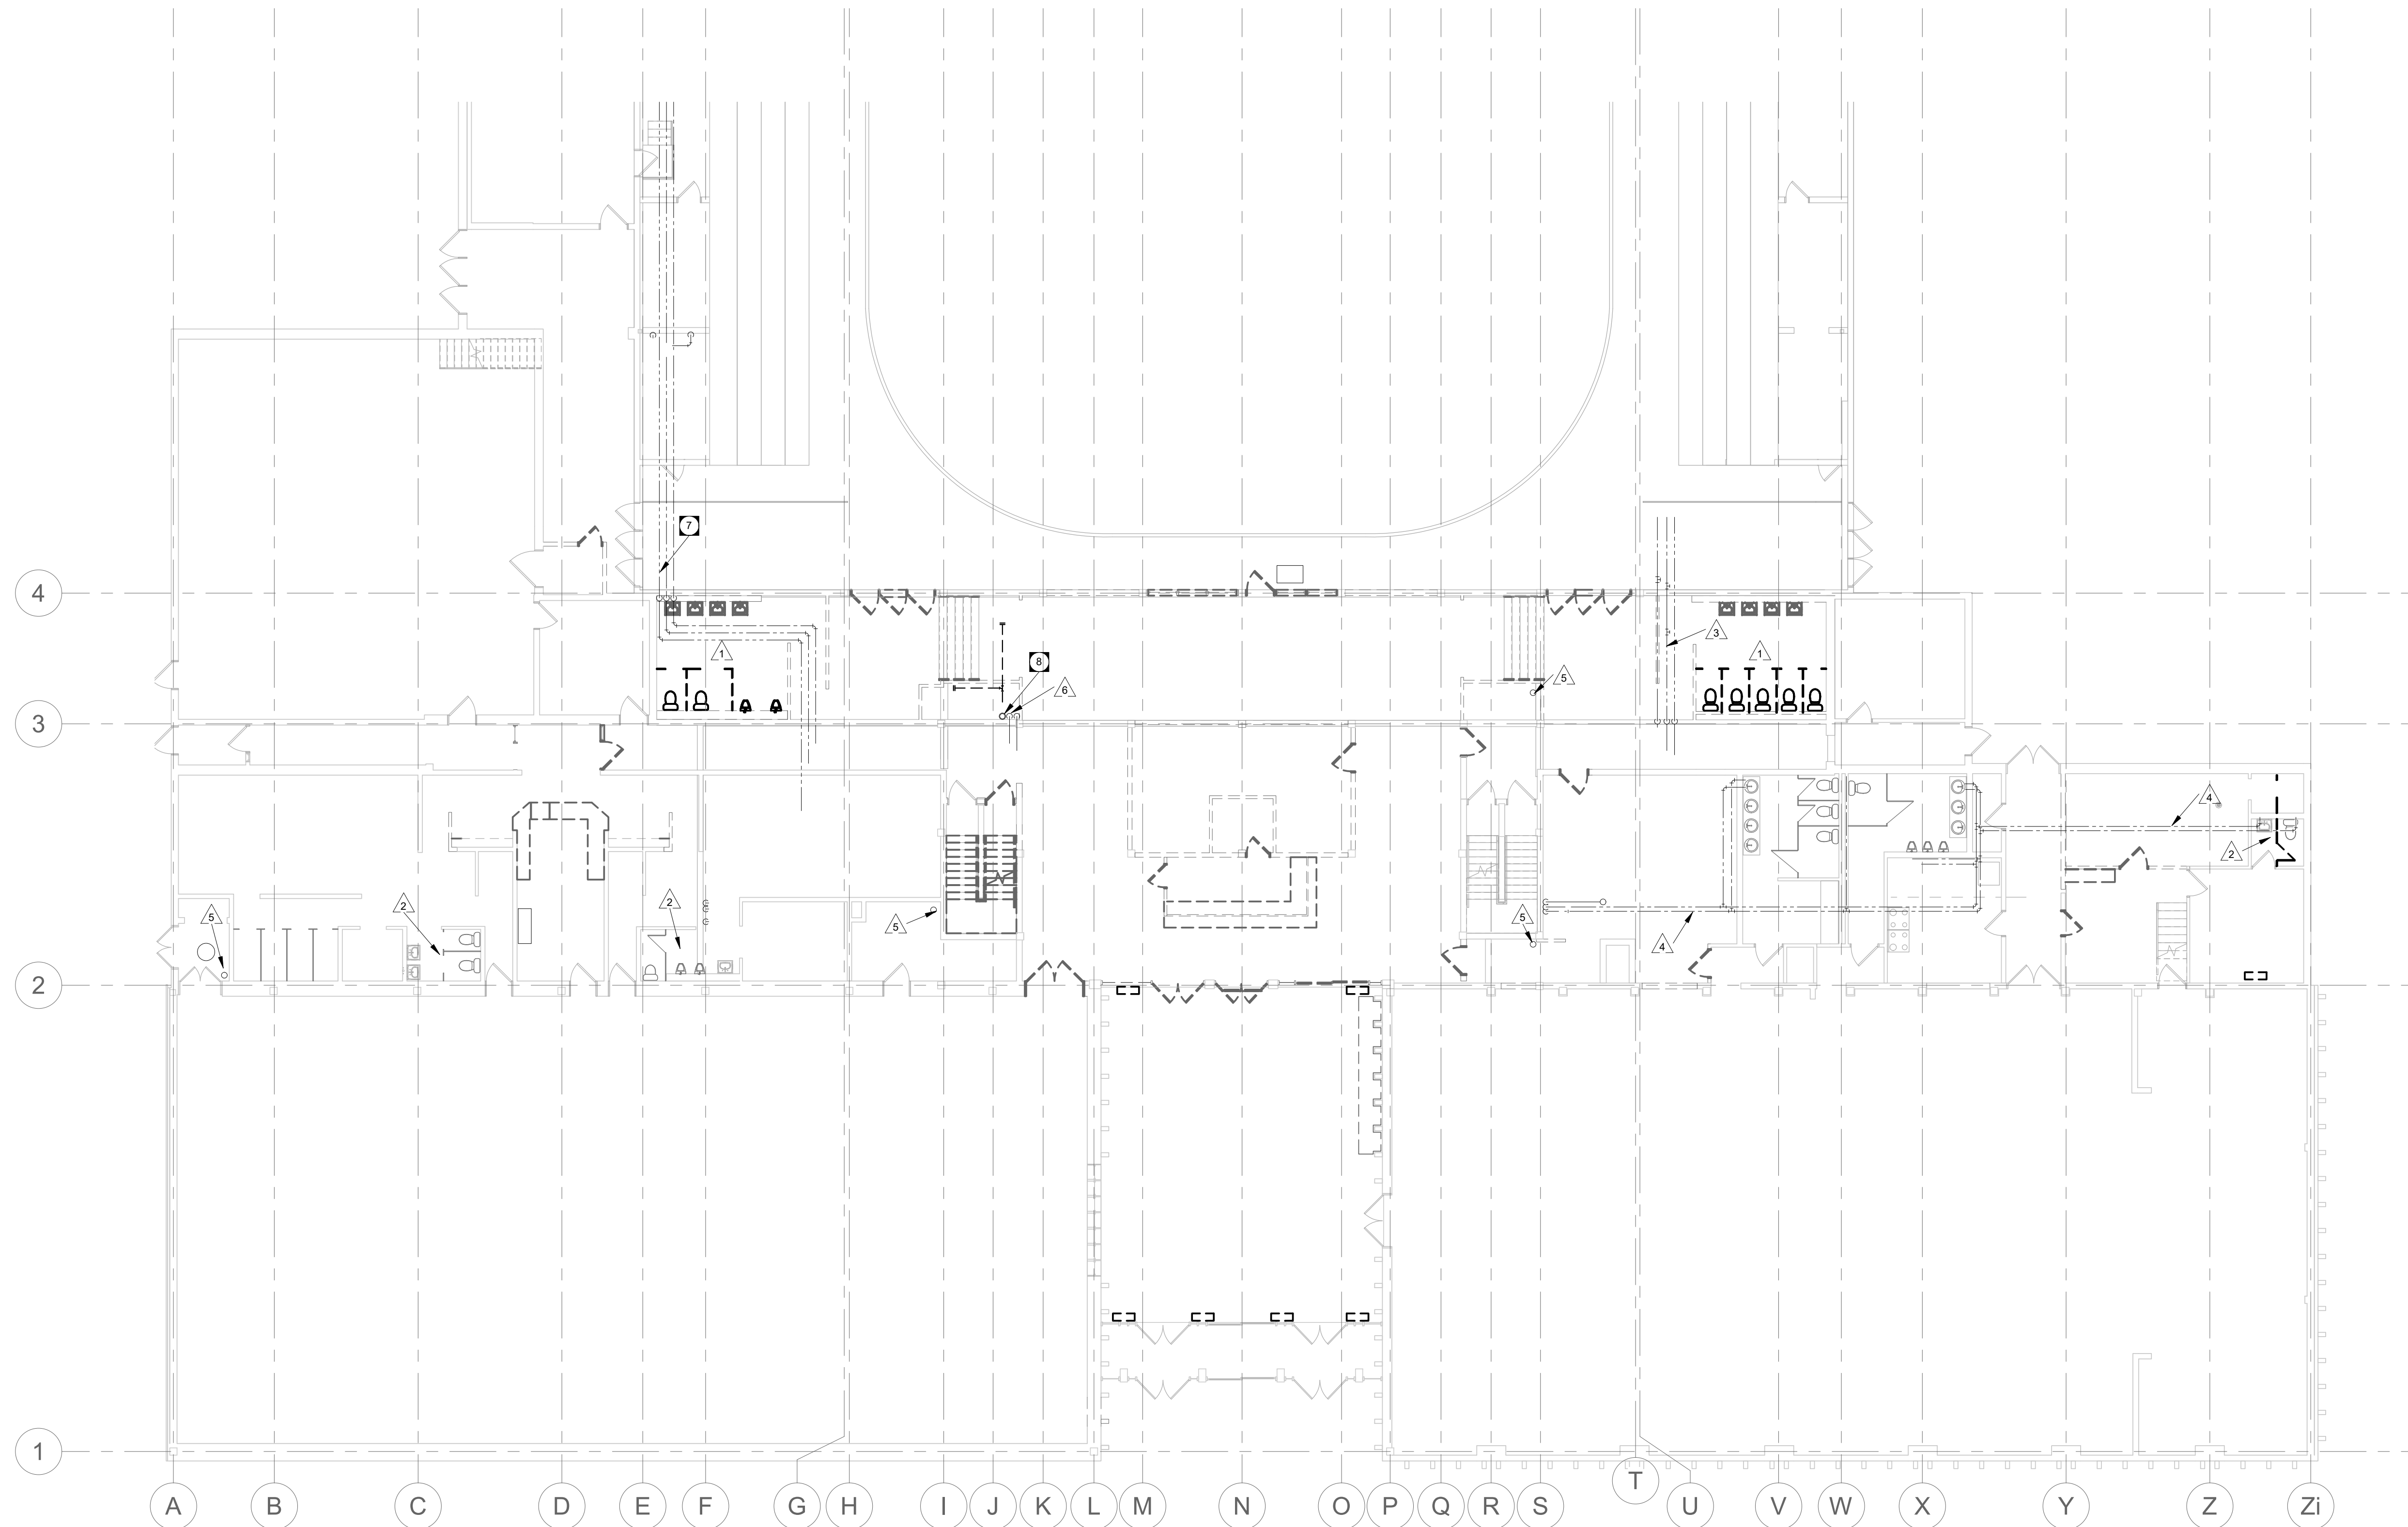

LEVEL 1 - PLUMBING DEMOLITION 1
 3/32" = 1'-0" MP2.1

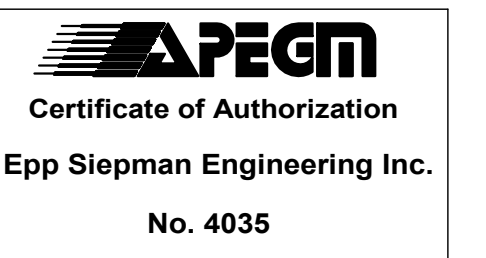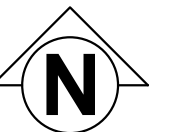

This is a print of a document that has been electronically authenticated with technology authorized by the APEGM. The original is in electronic form.



This drawing must not be scaled. The contractors shall verify all dimensions and other data on site prior to commencement of work. Discrepancies, errors, and omissions are to be reported to Public City Architecture Inc. prior to proceeding with the Work.

Drawings and specifications as instruments of service are the property of Public City Architecture Inc. the copyright in the same being reserved. No reproduction or revision to these drawings may be made without the permission of Public City Architecture Inc. and when made, must bear their name. All prints to be returned to Public City Architecture Inc. upon request.

Project
ST. JAMES CIVIC CENTRE

Drawing
LEVEL 1 DEMOLITION - PLUMBING PLAN

Drawn By:	DK	Review By:	JS
Scale:	3/32" = 1'-0"	Tender No:	1176-2019
Date:	11/06/19		
Sheet:			

MP2.1