


ELECTRICAL SYMBOL LEGEND		ELECTRICAL DRAWING LIST
NOTE: NOT ALL SYMBOLS SHOWN ON THIS LEGEND ARE NECESSARILY USED ON THIS PROJECT.		
<p>LIGHTING</p> <p>— LINEAR LED LUMINAIRE, TYPE 'A' AS SPECIFIED.</p> <p>⊙ BOLLARD MOUNTED LUMINAIRE, TYPE 'A' AS SPECIFIED</p> <p>⊙ WALL MOUNTED LUMINAIRE, TYPE 'A' AS SPECIFIED</p> <p>EQUIPMENT CONNECTIONS AND CONTROLS</p> <p>⊙ DIRECT CONNECTION - 120 OR 208V C/W UNFUSED DISCONNECT SWITCH AS SPECIFIED</p> <p>⊙ DIRECT CONNECTION - 120 OR 208V</p> <p>□ UNFUSED DISCONNECT SWITCH</p> <p>SP SURFACE MOUNTED ELECTRICAL PANEL - 'SP' DENOTES PANEL DESIGNATION</p> <p>COMMUNICATIONS</p> <p>▽ COMMUNICATION DROP</p>	<p>MISCELLANEOUS</p> <p>⊙^E INDICATES EXISTING DEVICE TO REMAIN</p> <p>⊙^{MV} INDICATES EXISTING DEVICE TO BE MOVED</p> <p>⊙^R INDICATES EXISTING DEVICE IN RELOCATED POSITION</p> <p>⊙^D INDICATES EXISTING DEVICE TO BE DEMOLISHED</p> <p>--- INDICATES CONDUIT</p> <p>⊙ (TYP.) ELECTRICAL DRAWING NOTES</p> <p>ABBREVIATIONS</p> <p>C - CONDUCTOR</p> <p>CNDT - CONDUIT</p> <p>D - DELETE</p> <p>DB - DIRECT BURIED</p> <p>DP - DISTRIBUTION PANEL</p> <p>E - EXISTING</p> <p>MV - EXISTING TO BE MOVED</p> <p>NTS - NOT TO SCALE</p> <p>PDU - POWER DISTRIBUTION UNIT</p> <p>PNL - PP POWER PANEL</p> <p>R - RELOCATE(D)</p> <p>TYP - TYPICAL</p> <p>V - VOLT</p> <p>W - WALL MOUNTED</p> <p>WP - WEATHERPROOF</p>	<p>1 SITE PLAN - ELECTRICAL DEMOLITION LAYOUT E1.0</p> <p>2 SITE PLAN - ELECTRICAL RENOVATION LAYOUT E2.0</p>

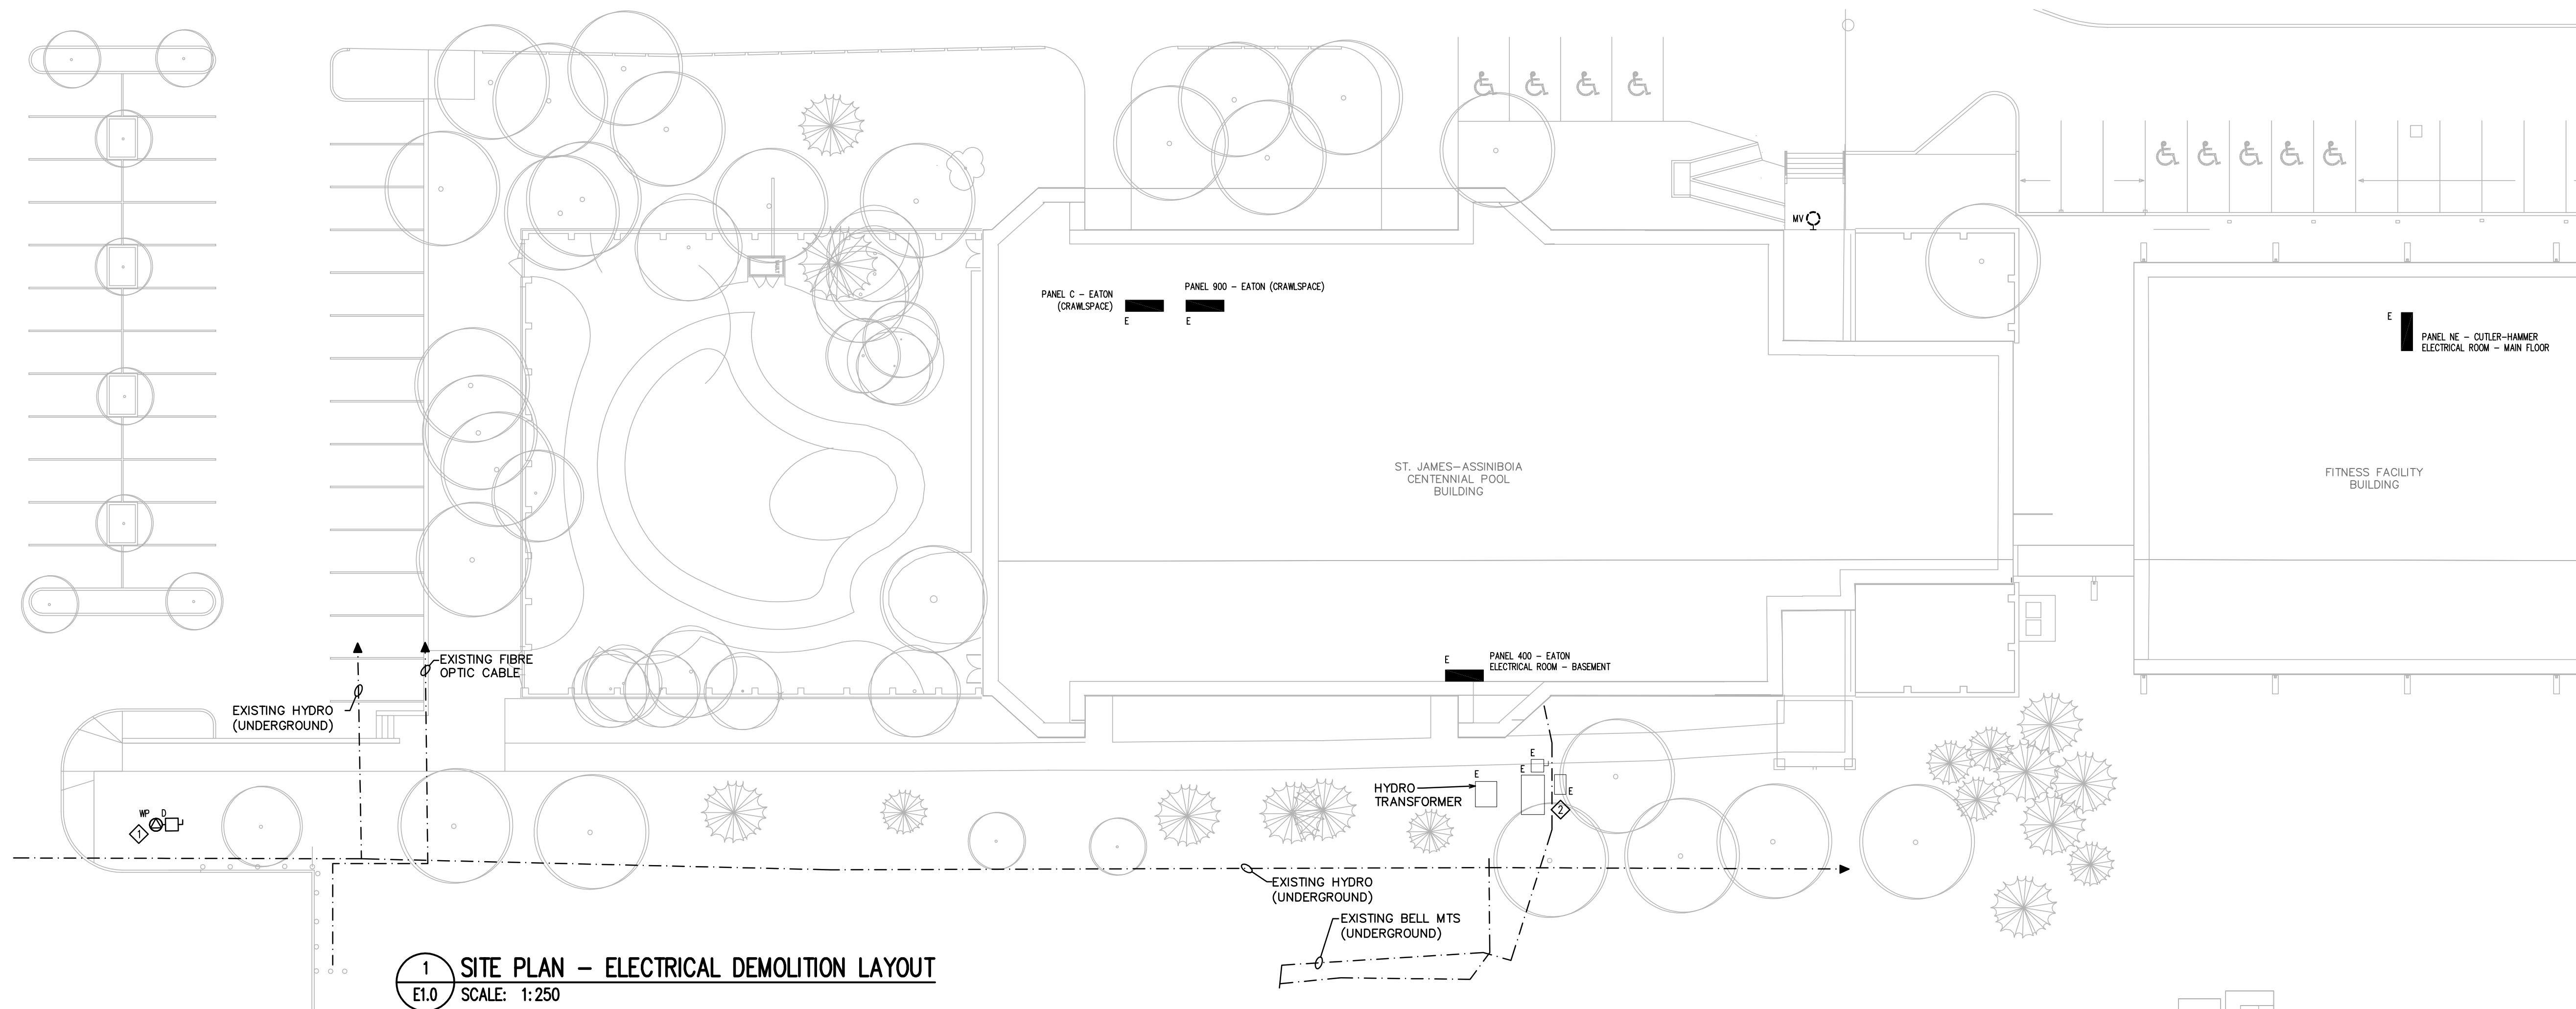

1 SITE PLAN - ELECTRICAL DEMOLITION LAYOUT
E1.0 SCALE: 1:250

- NOTES:**
- ⊙ DISCONNECT EXISTING SIGNAGE & REMOVE ASSOCIATED BACK TO SOURCE. CUT CONDUIT BELOW GRADE & PERMANENTLY SEAL.
 - ⊙ EXISTING OUTDOOR ELECTRICAL DISTRIBUTION TO REMAIN. PROTECT DURING CONSTRUCTION.

LEGEND



ISSUE NOTES	DATE
ISSUED FOR TENDER	15 NOV. 2019
ISSUED FOR 99% REVIEW	19 JULY 2019

THIS DRAWING MUST NOT BE SCALED.
THE GENERAL CONTRACTOR SHALL VERIFY ALL DIMENSIONS, DATUMS AND LEVELS PRIOR TO COMMENCEMENT OF WORK. ALL ERRORS AND OMISSIONS TO BE REPORTED IMMEDIATELY TO THE LANDSCAPE ARCHITECT.

VARIATIONS & MODIFICATIONS TO WORK SHOWN ON THESE DRAWINGS SHALL NOT BE CARRIED OUT WITHOUT WRITTEN PERMISSION FROM THE LANDSCAPE ARCHITECT.
THIS DRAWING IS THE EXCLUSIVE PROPERTY OF THE LANDSCAPE ARCHITECTS AND CAN BE REPRODUCED ONLY WITH THE PERMISSION OF THE LANDSCAPE ARCHITECTS. IN WHICH CASE THE REPRODUCTION MUST BEAR THEIR NAME AS LANDSCAPE ARCHITECTS.

PROFESSIONAL SEALS



PROJECT TITLE
ST. JAMES - ASSINIBOIA CENTENNIAL POOL WAYFINDING PHASE I
644 PARKDALE ST., WINNIPEG, MANITOBA

SHEET TITLE
SITE PLAN - ELECTRICAL DEMOLITION LAYOUT

DRAWN KG	REVIEWED AJ	DRAWING NO. E1.0
SCALE AS NOTED	PROJECT No. 18-069	REV

DATE PRINTED 7/8/2019 3:46 PM

PRELIMINARY - NOT FOR CONSTRUCTION