

A1 SIZE 23.4" x 33.1" (594mm x 841mm)



THE CITY OF WINNIPEG

PUBLIC WORKS DEPARTMENT


ENGINEERING DIVISION

CITY OF WINNIPEG


FLEET MANAGEMENT AUTHORITY:

552 PLINGUET STREET REFUELING STATION PAVEMENT AND EQUIPMENT REHABILITATION

BID OPPORTUNITY NO. 380-2019


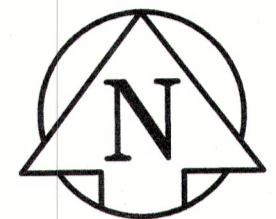


DRAWING NO.	DRAWING NAME/TITLE
CT-00	COVER PAGE AND LOCATION PLAN
CT-01	SITE PLAN
CT-02	PAVEMENT AND EQUIPMENT REHABILITATION PLAN
CS-03	CONCRETE SLAB FOR FUELING FACILITY

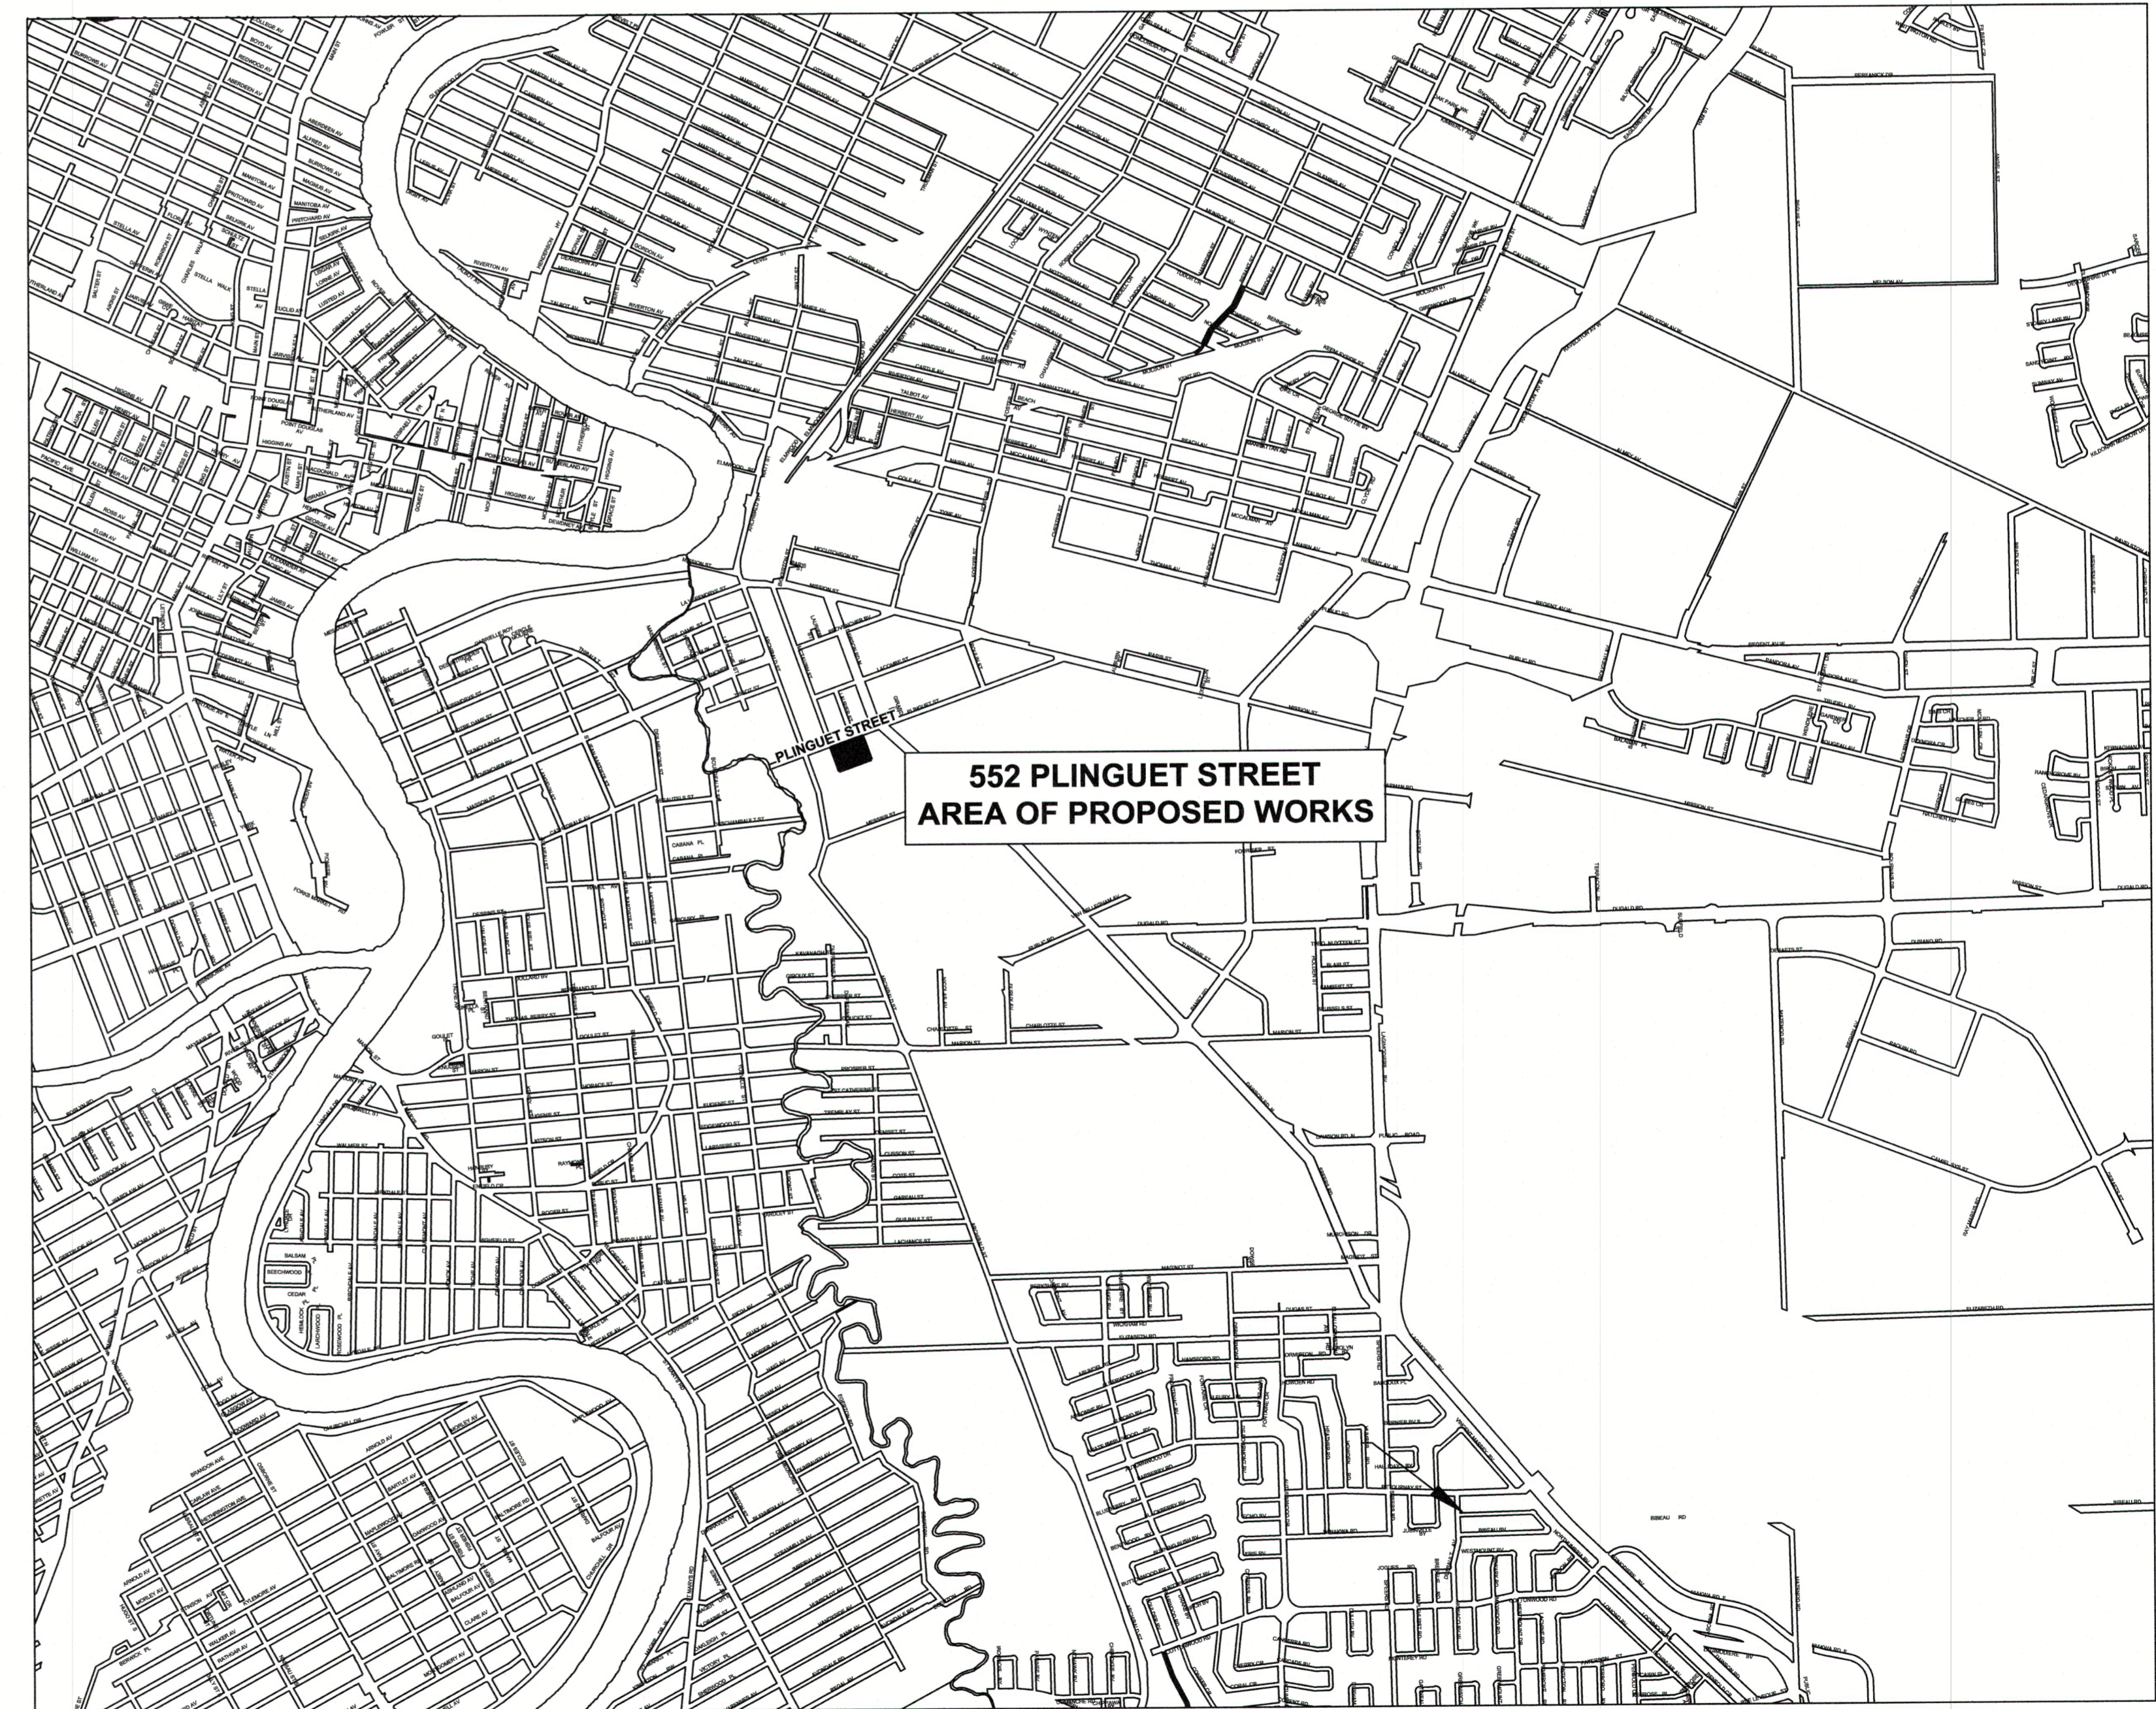

PLOT: 26/04/2019 2:06:30 PM By: jasper.andan

AECOM FILE NAME: CT-00_60586893-Plinguet.dwg Saved By: jasper.andan

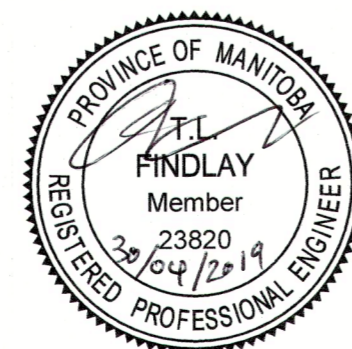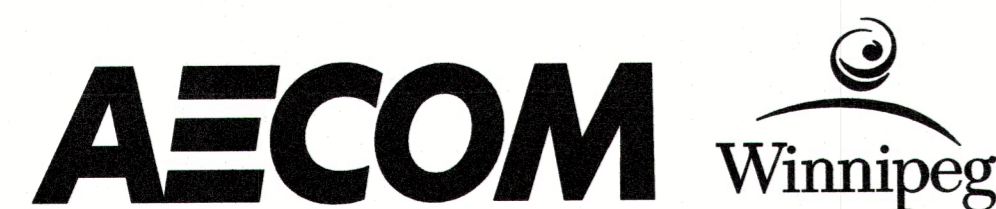

**ENGINEERS
GEOLOGISTS
MANITOBA**
Certificate of Authorization
AECOM Canada Ltd.
No. 4671 Date: 20/04/2019

RELEASED FOR CONSTRUCTION BY:

STREETS PROJECT COORDINATOR

DATE

COVER SHEET AND LOCATION PLAN	
CITY DRAWING NO.	REV
N/A	1
CONSULTANT NO. CT-00.dwg	