


LIST OF DRAWINGS

- ARCHITECTURAL**
- A-1 PLAN & SECTION
 - A-2 ELEVATIONS & SECTIONS
 - A-3 SECTIONS & DETAILS
- STRUCTURAL**
- S-1 FLOOR & ROOF FRAMING PLANS
 - S-2 SECTIONS & DETAILS
 - S-3 SECTION & DETAILS
- MECHANICAL**
- M-1 MECHANICAL PLAN - WALKWAY #1
- ELECTRICAL**
- E-1 ELECTRICAL LAYOUT & DETAILS

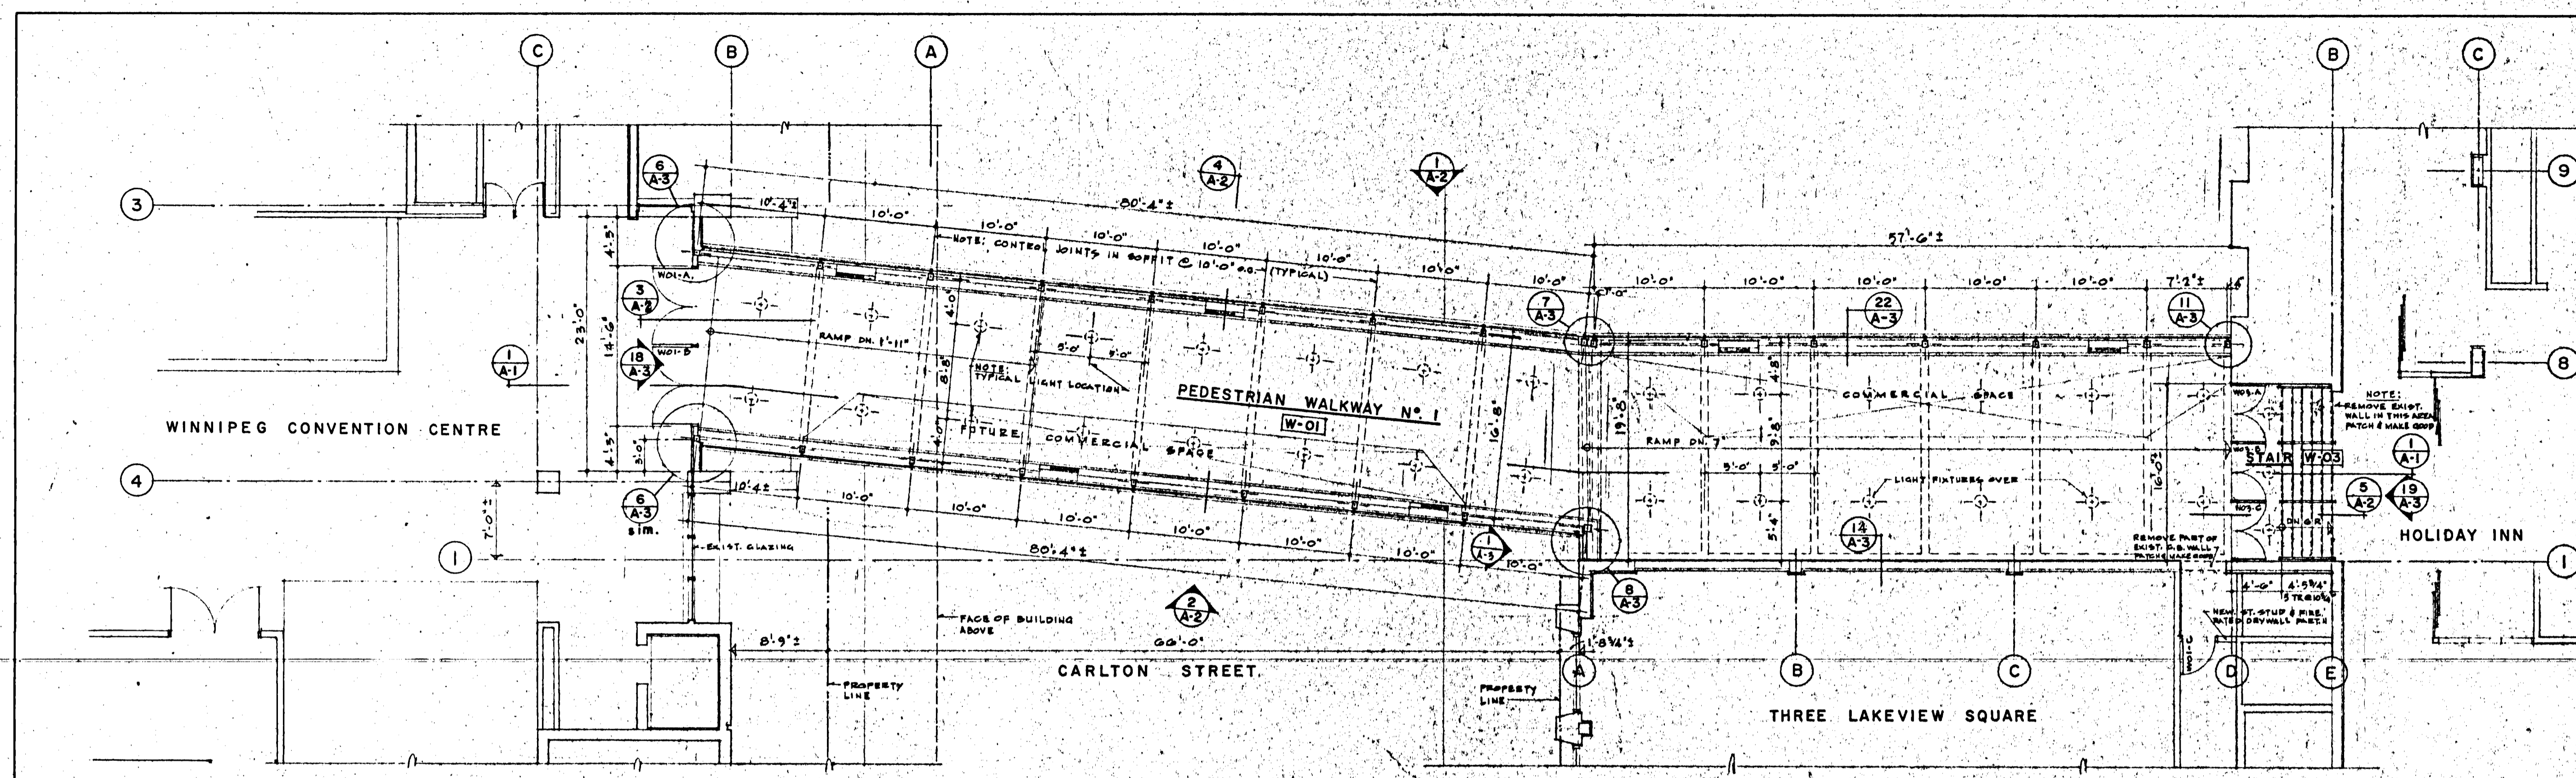

HARDWARE SCHEDULE	
2 PR. DOORS W01-A & B TYPE	CONCOURSE 208 LHPB FROM WALKWAY ACTIVE
3 PR. DOORS W03-A, B & C	STAIR W-03 LHPB FROM WALKWAY ACTIVE
15 PR. BUTTS	FPB 168 4 1/2 x 4 C10B FMS
2 SETS PANIC BOLTS	5537 x 5534 TP (LESS CYL) C10B TMS
2 CYLINDERS	900 10B
10 DOOR CLOSERS	4023-P x 4020-184 KPD C10B TMS
10 O.H. DOOR STOPS	1-331 C10B TMS
10 HIC-PLATES	5000 ENPD 10" x 32 1/2" 10B
5 CO-ORDINATORS	1237 C10B TMS
1 5GL. DOOR W01-C TYPE	HALL FROM WALKWAY LHPB
1/2 PR. BUTTS	FPB 168 4 1/2 x 4 C10B FMS
1 PANIC BOLT	5534 TP (LESS CYL) C10B TMS
1 CYLINDER	900 10B
1 HIC-PLATE	5000 ENPD 10" x 32 1/2" 10B
1 O.H. DOOR STOP	1-331 30" DS. C10B TMS
1 DOOR CLOSER	4013-B KPD C10B TMS

PLAN SCALE: 1/8" = 1'-0"

ROOM FINISH SCHEDULE																	
ROOM NO.	ROOM NAME	FLOOR		BASE		N. WALL		S. WALL		E. WALL		W. WALL		CEILING		REMARKS	
		MATL.	FIN.	MATL.	FIN.	MATL.	FIN.	MATL.	FIN.	MATL.	FIN.	MATL.	FIN.	HT.	MATL.		FIN.
W-01	WALKWAY NO. 1	CARPET	-	CARPET	-	CARPET	-	CARPET	-	CARPET	-	CARPET	-	8'-6"	STEEL DECK	P.	4" RUBBER BASE AT G.D. WALLS ONLY
W-03	STAIR	CARPET	-	4" RUBBER	-	PLASTER	P.	PLASTER	P.	F.P.D.	P.	-	-	-	F.P.D.	P.	-

DOOR SCHEDULE											
DOOR NO.	WIDTH	HEIGHT	THICK.	TYPE	MATERIAL		FRAME		LINTEL TYPE	REMARKS	
					MATL.	FIN.	MATL.	FIN.			
W01-A	2'-3'-6"	6'-10"	1 1/4"	GLAZED	H.M.	P.	5 1/4"	H.M.	P.	STEEL □	ALL DOORS TO HAVE CLASS 10 U.L. LABEL SEE ELEV. 10/A-3
W01-B	2'-3'-6"	6'-10"	1 1/4"	GLAZED	H.M.	P.	5 1/4"	H.M.	P.	STEEL □	SEE ELEV. 10/A-3
W01-C	3'-0"	7'-0"	1 1/4"	GLAZED	H.M.	P.	5 1/4"	H.M.	P.	STEEL STUD	-
W03-A	2'-2'-6 3/4"	7'-0"	1 1/4"	GLAZED	H.M.	P.	5 1/4"	H.M.	P.	STEEL STUD	SEE ELEV. 19/A-3
W03-B	2'-2'-6 3/4"	7'-0"	1 1/4"	GLAZED	H.M.	P.	5 1/4"	H.M.	P.	STEEL STUD	SEE ELEV. 19/A-3
W03-C	2'-2'-6 3/4"	7'-0"	1 1/4"	GLAZED	H.M.	P.	5 1/4"	H.M.	P.	STEEL STUD	SEE ELEV. 19/A-3

NOTE:
DIMENSIONS GIVEN AS ± SHALL BE VERIFIED BY ON SITE MEASUREMENT BEFORE PROCEEDING WITH MANUFACTURE.

DATE	DR	REVISION

THIS DRAWING MUST NOT BE SCALED.
THE GENERAL CONTRACTOR SHALL VERIFY ALL DIMENSIONS, DATUMS AND LEVELS PRIOR TO COMMENCEMENT OF WORK. ALL ERRORS AND OMISSIONS TO BE REPORTED IMMEDIATELY TO THE ARCHITECT.
VARIATIONS & MODIFICATIONS TO WORK SHOWN ON THESE DRAWINGS SHALL NOT BE CARRIED OUT WITHOUT WRITTEN PERMISSION FROM THE ARCHITECT.
THIS DRAWING IS THE EXCLUSIVE PROPERTY OF THE ARCHITECTS AND CAN BE REPRODUCED ONLY WITH THE PERMISSION OF THE ARCHITECTS. IN WHICH CASE THE REPRODUCTION MUST BEAR THEIR NAME AS ARCHITECTS.

DOWNTOWN WINNIPEG ARCHITECTS
THE URBAN ARCHITECTURAL GROUP
THE KENNEDY TEN ARCHITECTURAL GROUP
ARCHITECTS
1500 BROADVIEW AVE. WINNIPEG, R3M 1G9
PHONE (204) 942-2346

ASSOCIATE ARCHITECT

CONSULTING ENGINEER

ARCH. SEAL
PROVINCE OF MANITOBA
MICHIENER, FRIESEN, KINRADE
REGISTERED ARCHITECTS

PROJECT
PEDESTRIAN WALKWAY NO. 1
FROM
THE WINNIPEG CONVENTION CENTRE
TO
THE HOLIDAY INN

SHEET TITLE
PLAN & SECTION


DRAWN BY
D.C.

DATE
AUG 28 1974

CHECKED BY
PROJECT NO.

SHEET NO.
A-1

FILE NO.

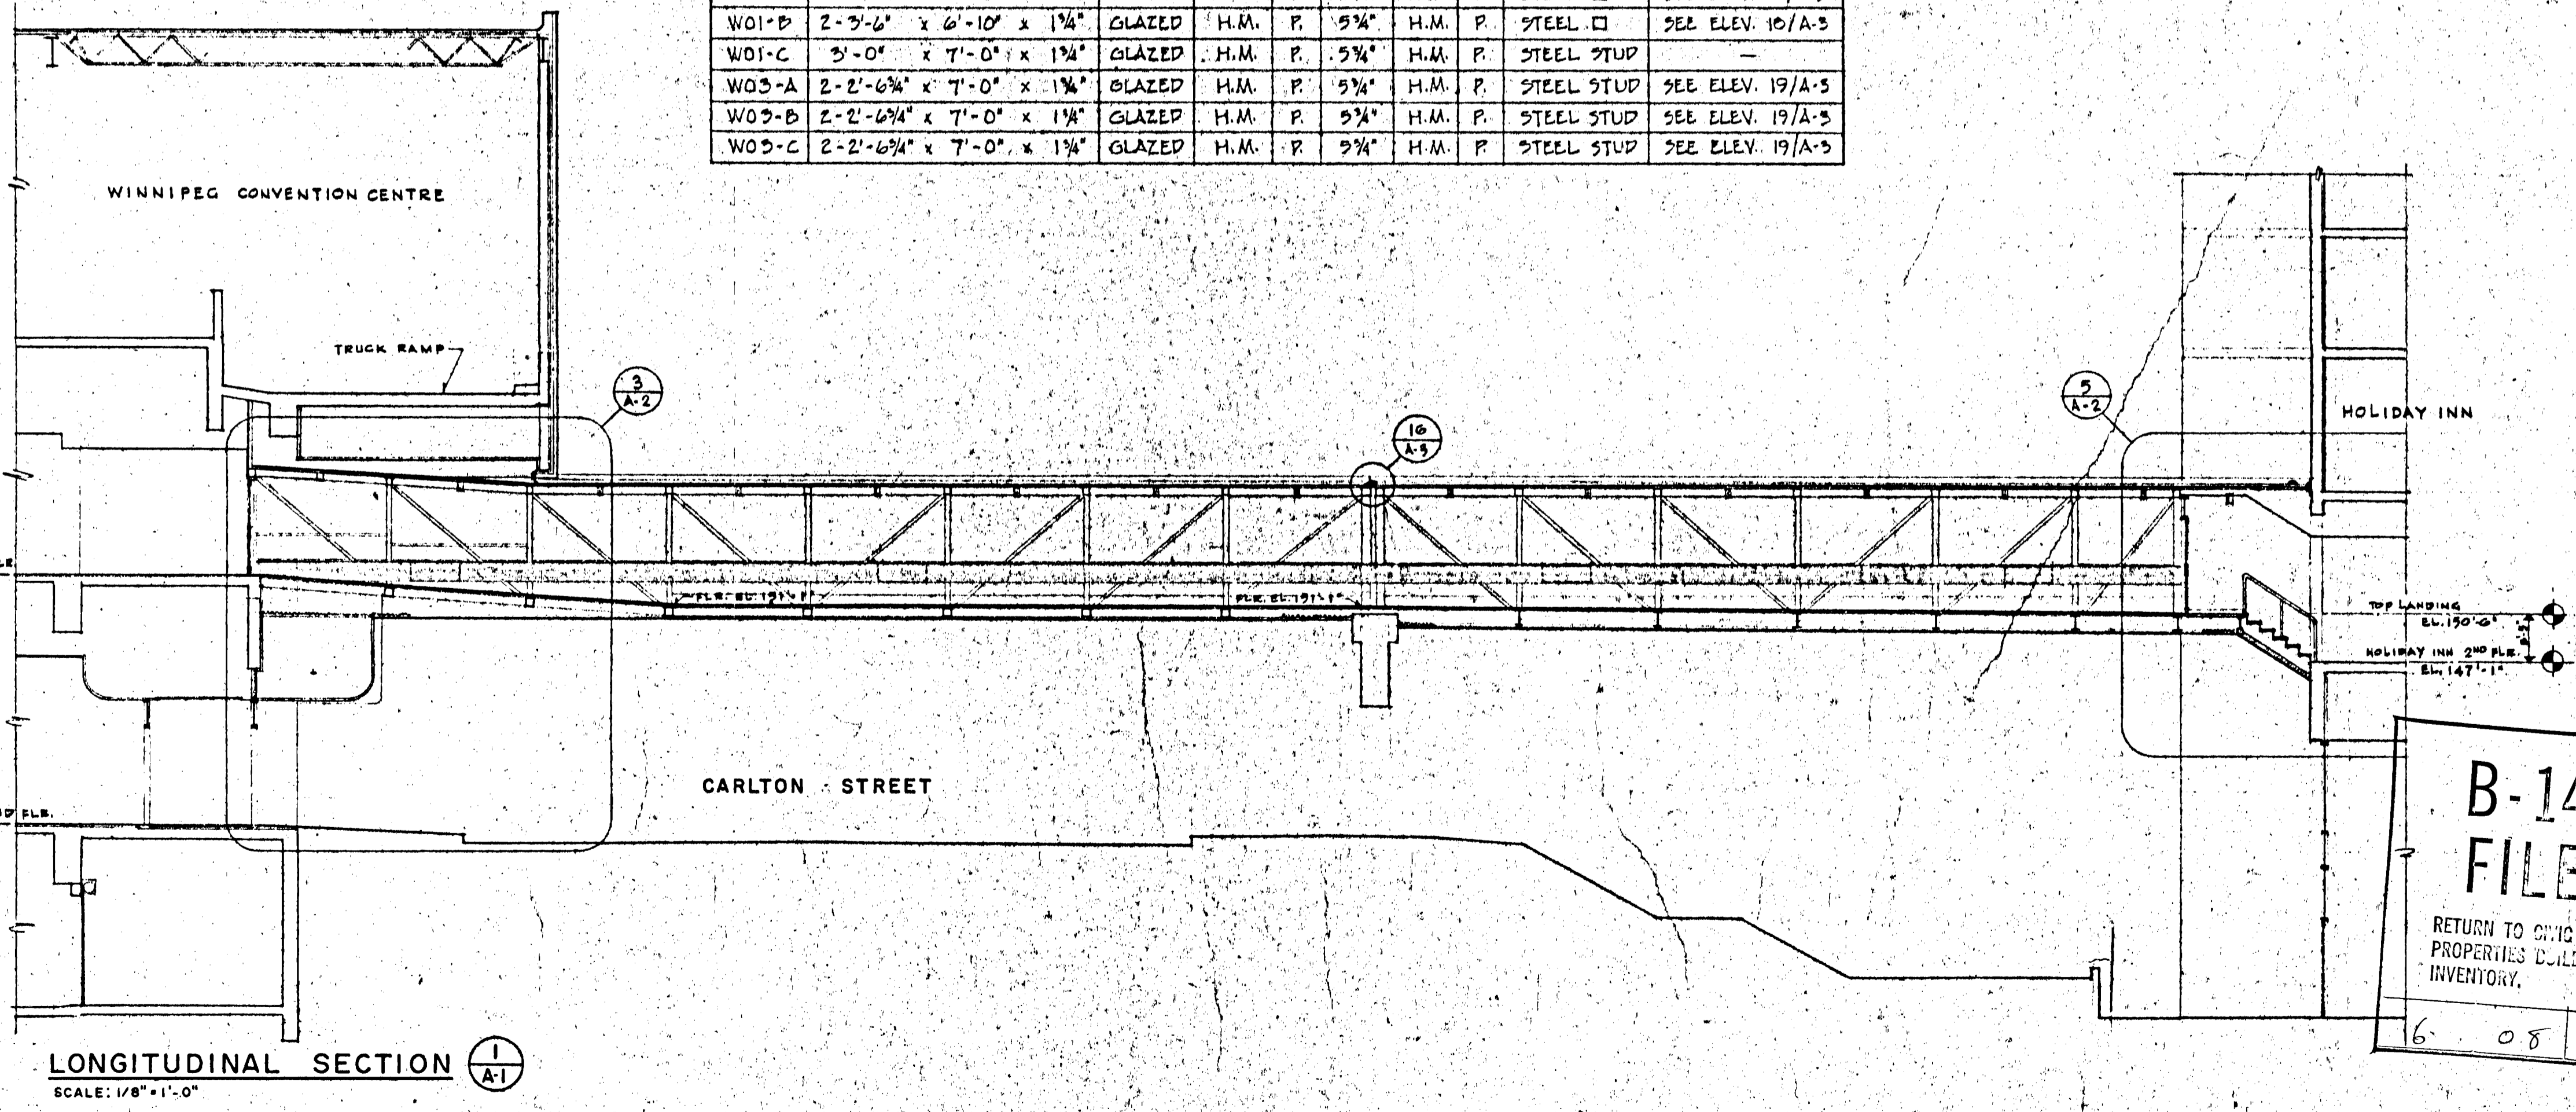

LONGITUDINAL SECTION SCALE: 1/8" = 1'-0"

B-14 FILE
RETURN TO CIVIC PROPERTIES BUILDING INVENTORY.

#22