
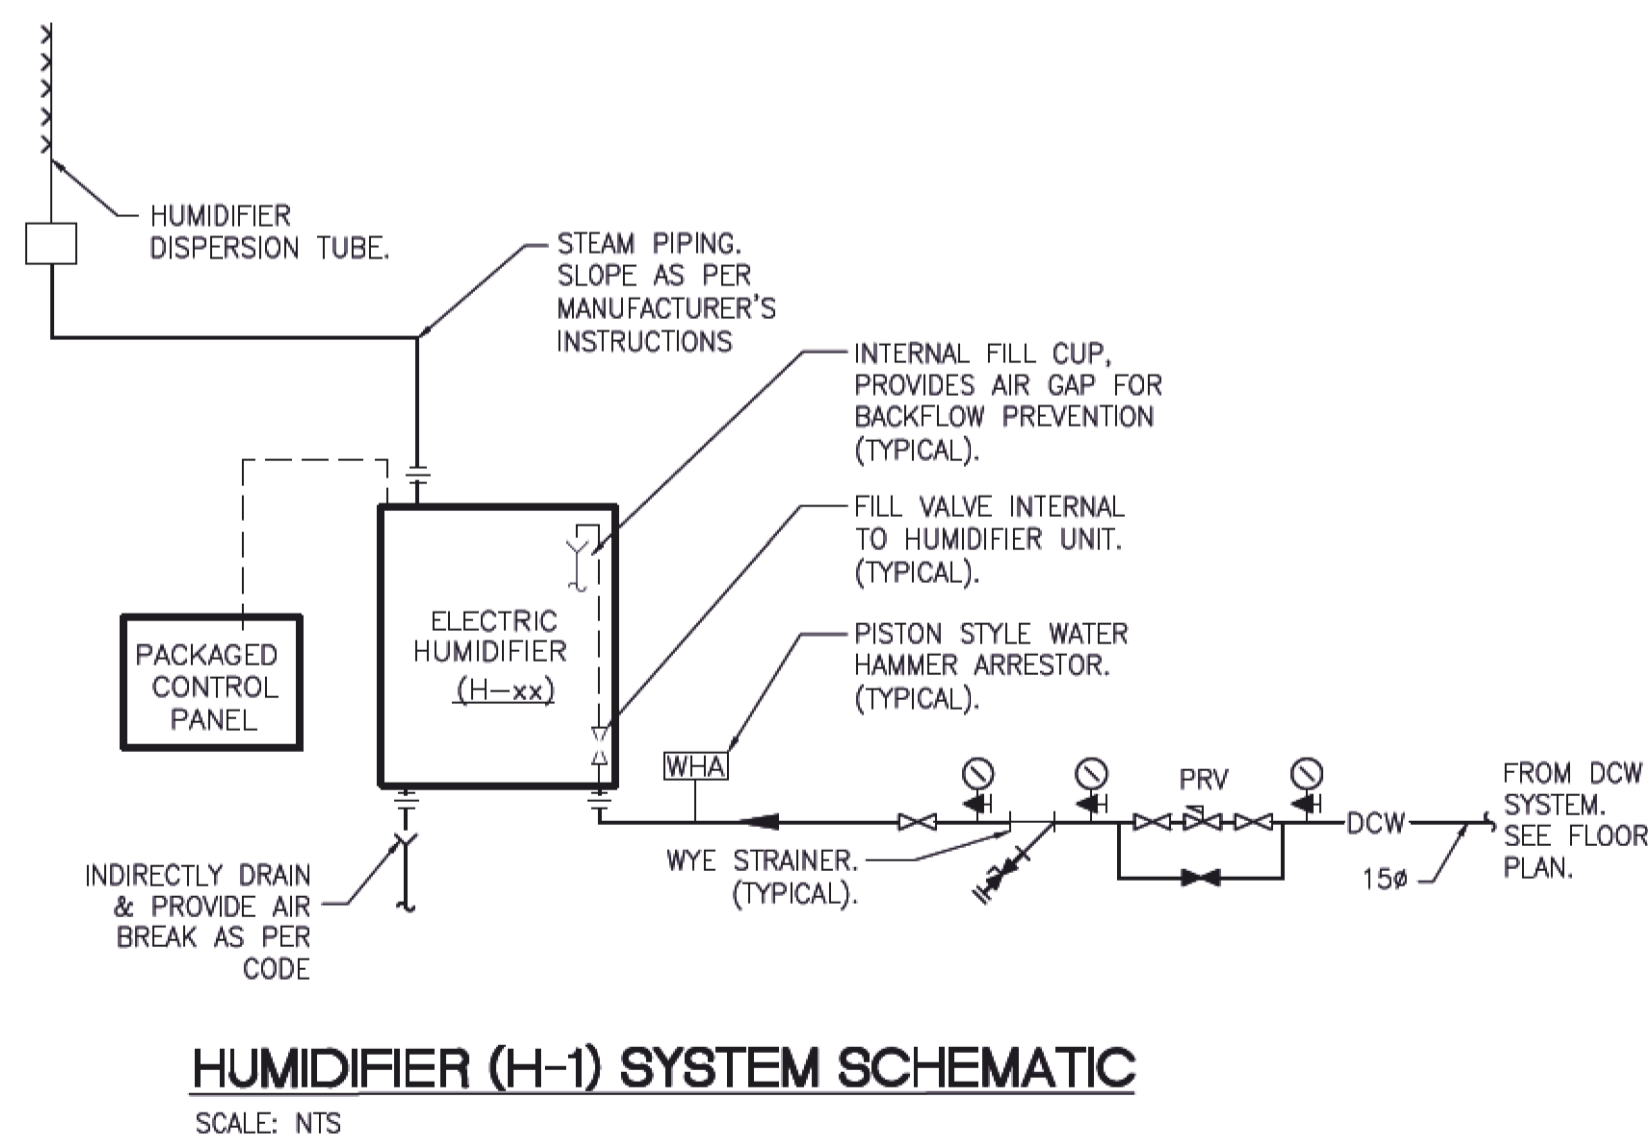


PLUMBING VENT DETAIL
SCALE: N.T.S.

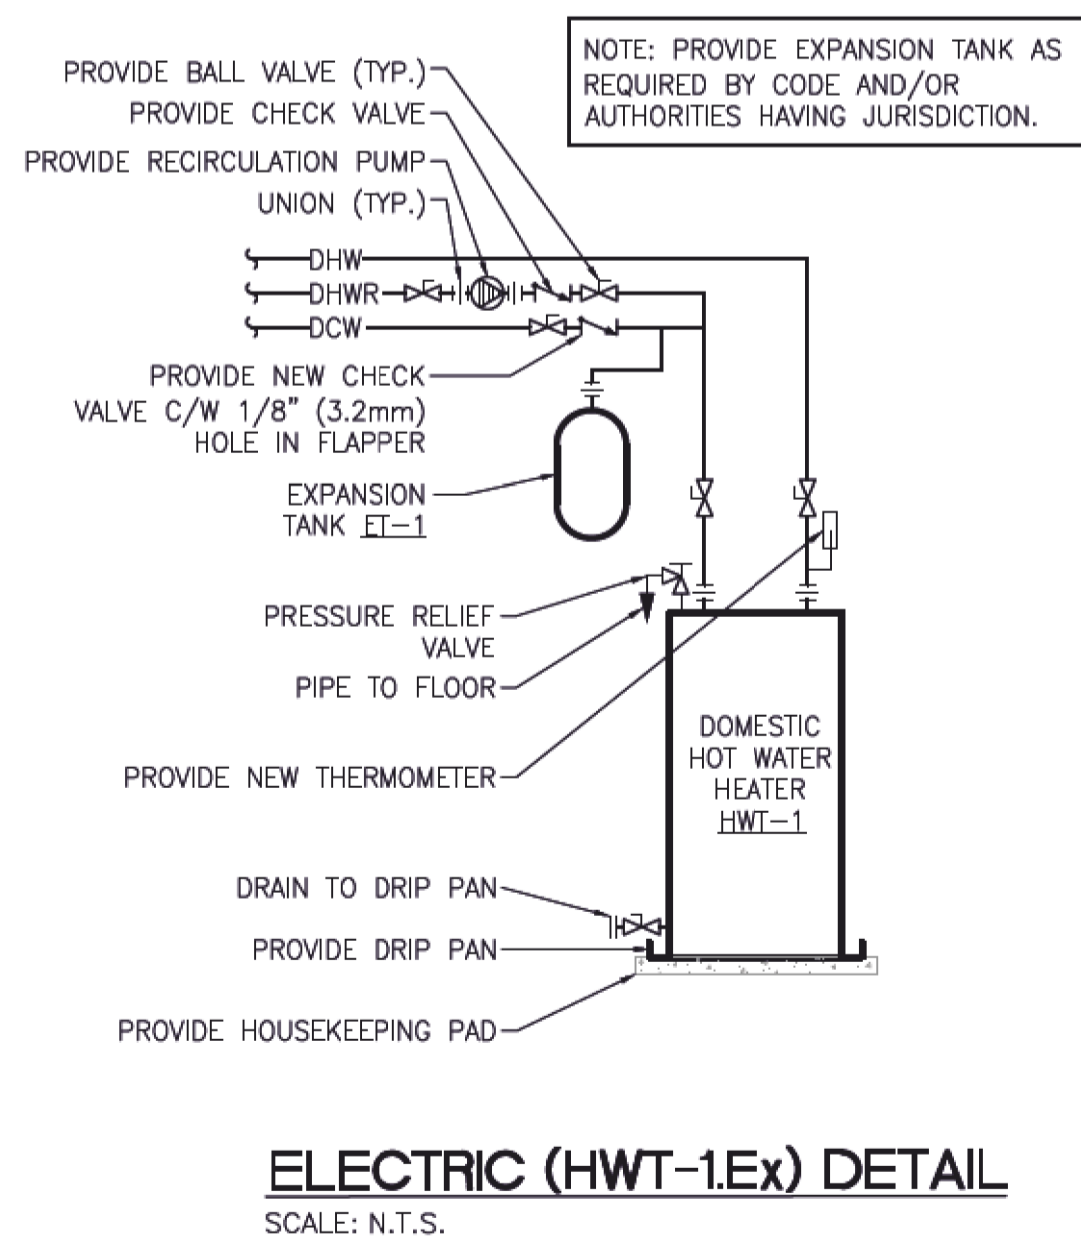

TOWER PROJECT NO.: 181335

TOWER ENGINEERING GROUP
UNIT 1-1140 WAVERLEY ST. WINNIPEG, MB R3T 0P4
TEL: (204) 925-1150 FAX: (204) 925-1155
EMAIL: towereng@towereng.ca WEB: www.towereng.ca
• WINNIPEG • CALGARY

These design documents are prepared solely for the use by the party with whom the design professional has entered into a contract and those are no representation of any kind made by the design professional to any party with whom the design professional has not entered into a contract. Any use of the drawings, data or electronic data without the expressed written permission of Tower Engineering Inc. is strictly prohibited. The contractor is responsible to verify all dimensions with conditions on the site and report discrepancies to Tower Engineering for adjustment. All joints to be related.

500-136 Market Ave
Winnipeg, Manitoba
Canada R3B 0P4
t: (204) 942-0681
f: (204) 943-8676
www.lm-architects.com

LM Architectural Group

No.	Date	Issue / Revision	By
1	July 08, 2019	Issued For Construction	JAC

Drawn By: JRodriguez
Printing Date: July 16, 2019

APEGM
Certificate of Authorization
Tower Engineering Group
No. 4156 Expiry: April 30, 2020

PROFESSEUR DE MANIPULATION
CHIMKO
Member
23356
PROFESSEUR PROFESSIONNEL EN INGENIERIE

Bill and Helen Norrie Library
Project No.: 2017-082
Tender No.: 542-2019
Address: 15 Poseidon Bay, Winnipeg, MB.

MECHANICAL PLUMBING DETAILS

Comm. No.: 1847
Sheet: **M1.3**