

NOTES


1. Drawings Not to Scale (NTS).

LEGEND



KEYNOTE LEGEND

- | | |
|---------------------|---------------------------|
| 1. CORE SAMPLE | 24. DOWN SPOUT |
| 2. CHIMNEY | 25. BACK SLOPE |
| 3. A/C UNIT | 26. CANT |
| 4. SIGN SUPPORT | 27. SLOPE TO DRAIN |
| 5. VENTILATOR | 28. CRICKET |
| 6. VENT PIPE | 29. PARAPET/WIDE FLASHING |
| 7. ROOF DRAIN | 30. SAFETY LINE ANCHOR |
| 8. SKYLIGHT | 31. LIGHT POLES |
| 9. EAVESTROUGH | 32. GARAGE EXHAUST FAN |
| 10. PLUMBING STACK | 33. KITCHEN EXHAUST FAN |
| 11. ANTENNA | |
| 12. LADDER | |
| 13. ATTIC VENT | |
| 14. ROOF HATCH | |
| 15. SCUPPER | |
| 16. PITCH BOX | |
| 17. HVAC UNIT | |
| 18. CAPPED CURB | |
| 19. FLAG POLE | |
| 20. ELECTRICAL MAST | |
| 21. COOLING TOWER | |
| 22. SPLASH PAD | |
| 23. SPLASH PAN | |

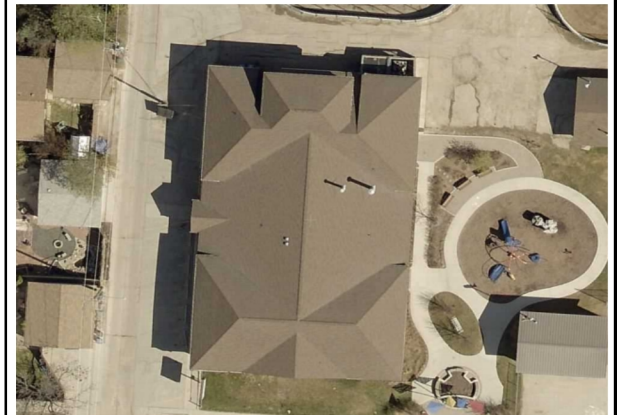

QCA Building Envelope Ltd.

1295 Pembina Highway Winnipeg, MB R3T 2B0
Tel: (204) 371-0996


Project DEERLODGE COMMUNITY CENTRE
323 BRUCE AVENUE WINNIPEG, MB R3J 2C3

Client City of Winnipeg

Dwg. No. A1-RO

Date Nov 10, 2018 Scale N.T.S.

This drawing is the property of QCA Building Envelope Ltd.
It may not be reproduced without consent.

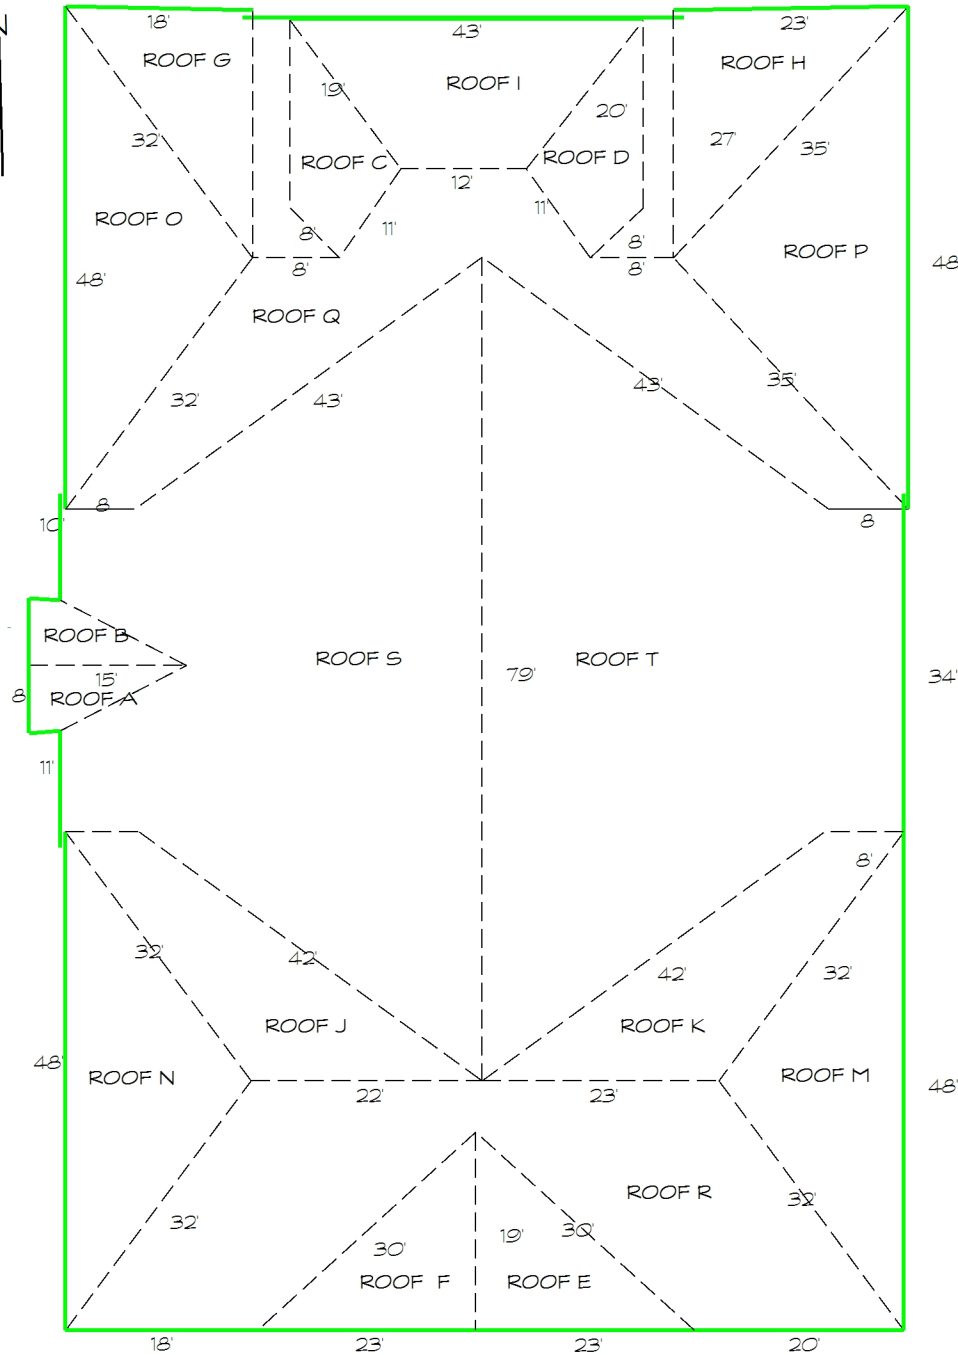

BUILDING ROOF PLAN