


CONSTRUCTION NOTES:
 1 INSTALL NEW ELECTRICAL FITTINGS AND CONNECTIONS FOR THE HAZARDOUS LOCATION.

04

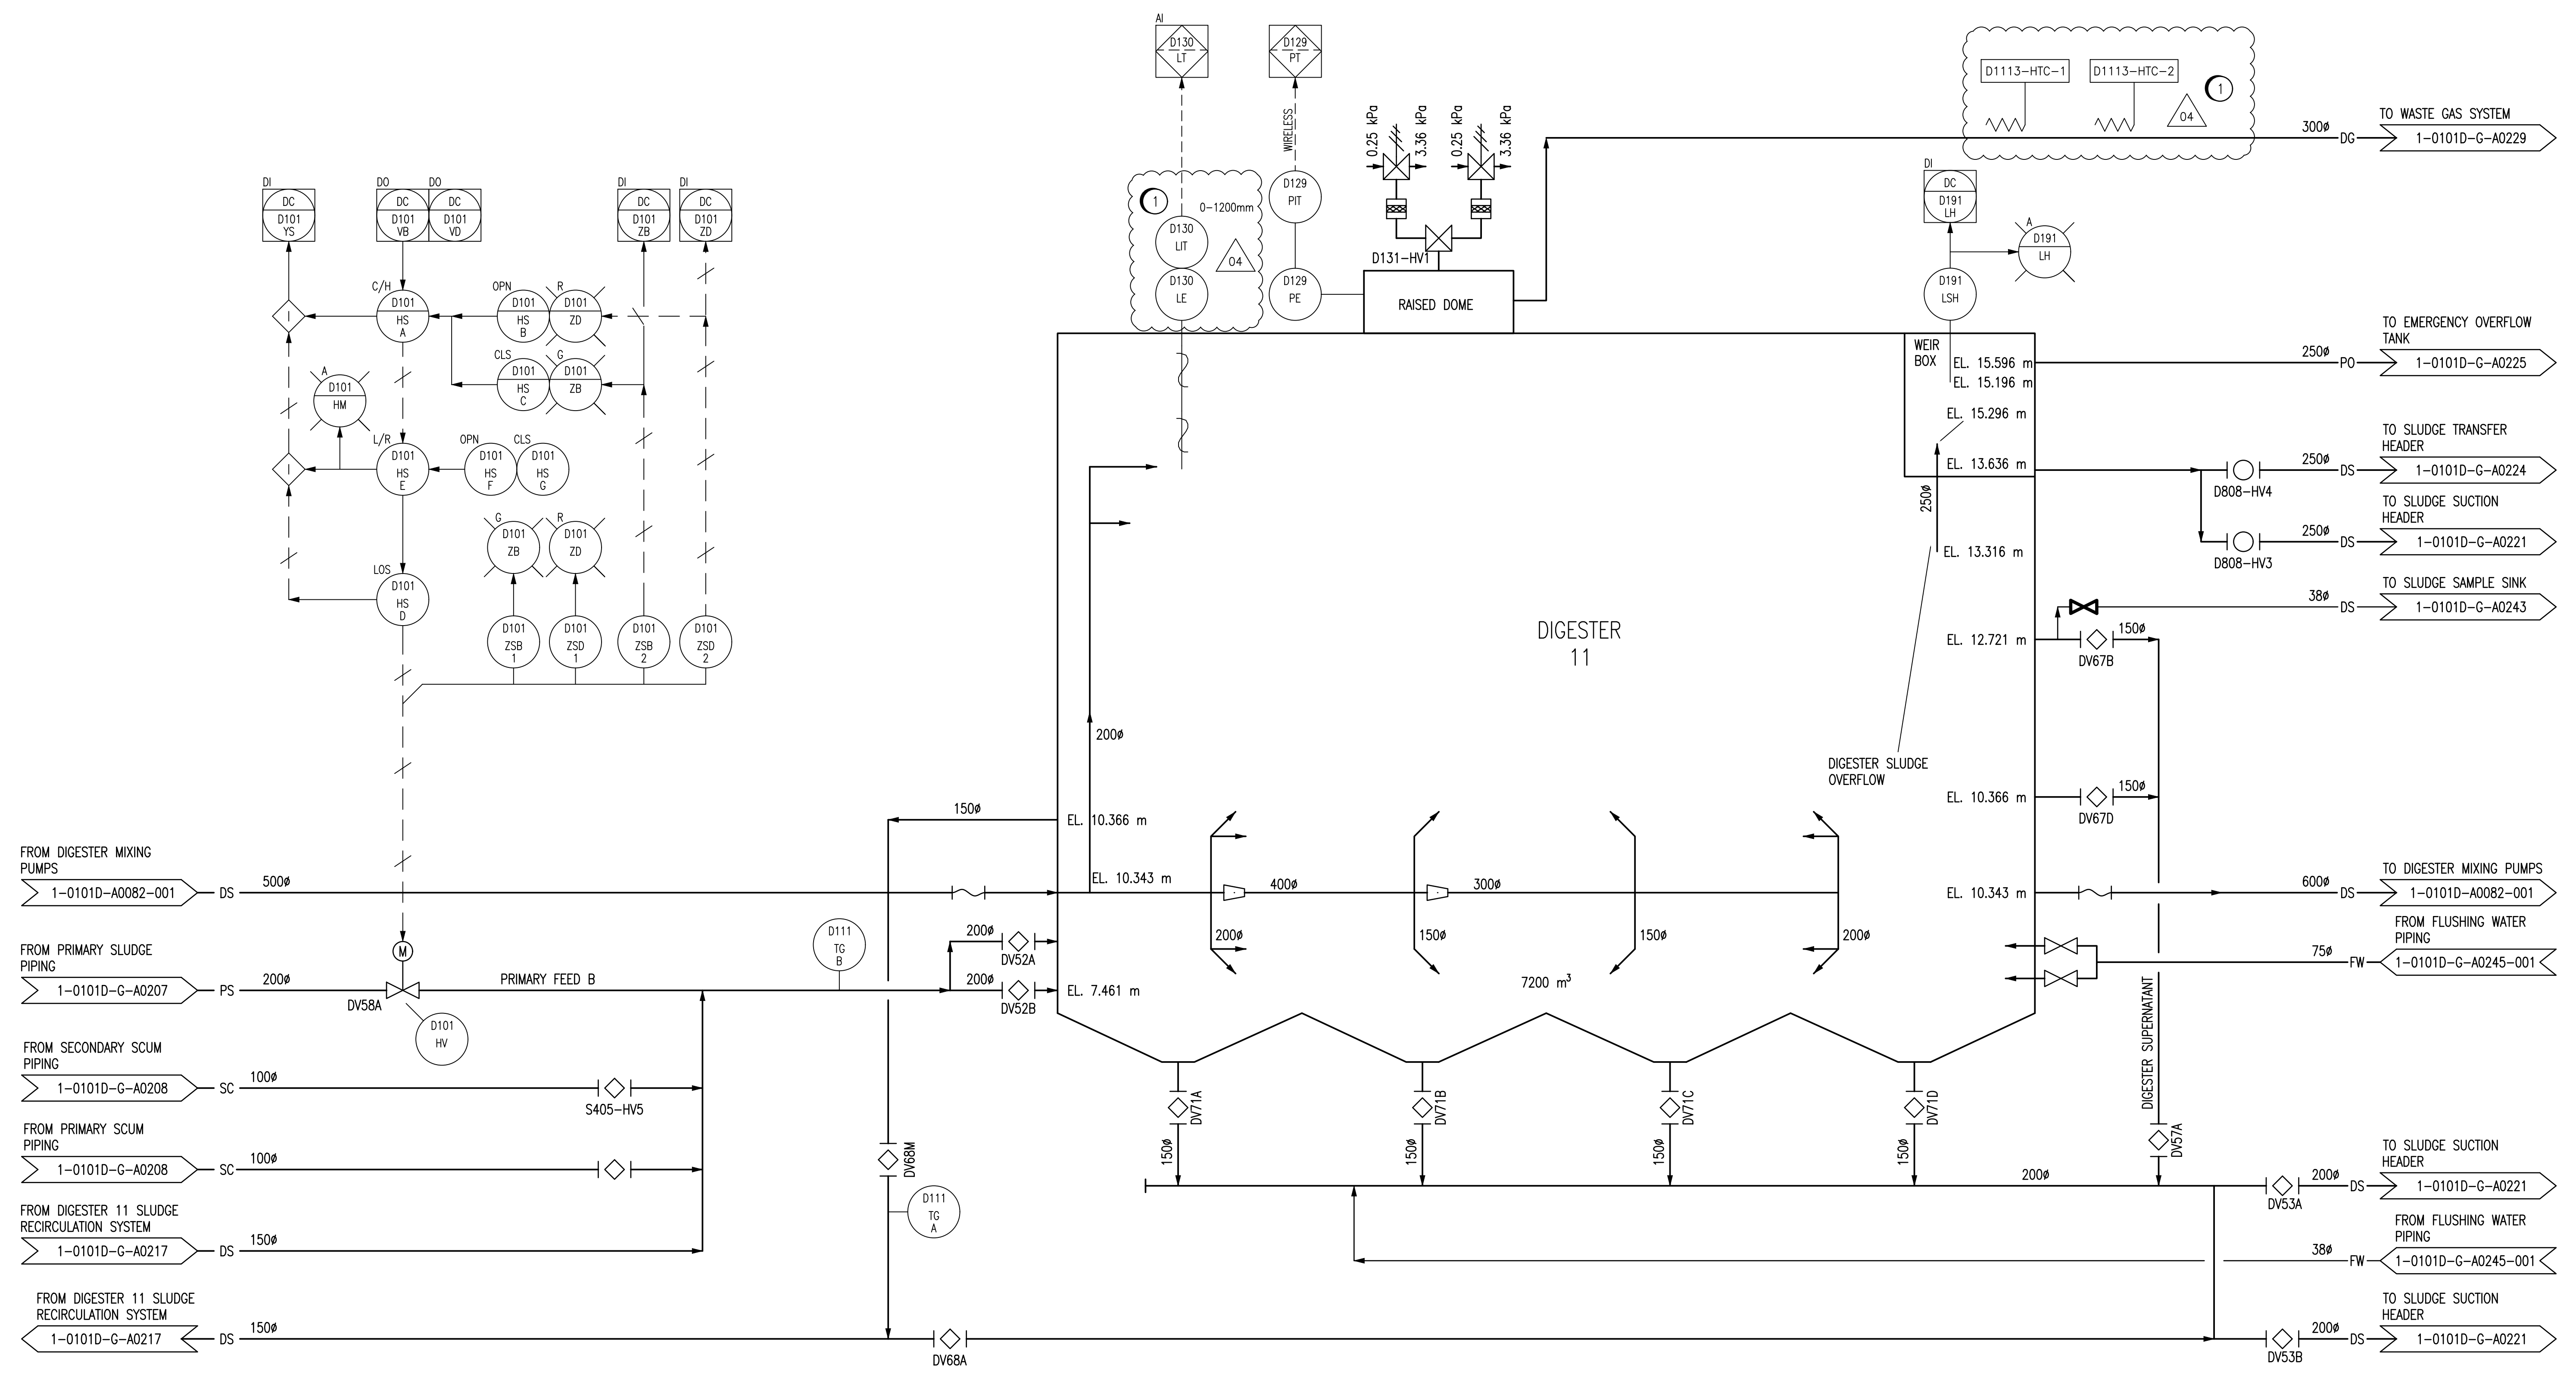

REVISION 04
 THE ENGINEER'S DESIGN RESPONSIBILITIES ARE LIMITED TO THE CHANGES INDICATED IN THE CLOUDED WORK

DESIGNED BY: C. REIMER	CHECKED BY: C. REIMER
DRAWN BY: S. FUNK	APPROVED BY: C. REIMER
DATE: 2019-08-01	

METRIC
 WHOLE NUMBERS INDICATE MILLIMETRES
 DECIMALIZED NUMBERS INDICATE METRES

ENGINEERS GEOSCIENTISTS MANITOBA
 Certificate of Authorization
CENGYS Ltd.
 No. 6983

LOCATION APPROVED UNDERGROUND STRUCTURES

SUPV. U/G STRUCTURES DATE COMMITTEE

NOTE:
 LOCATION OF UNDERGROUND STRUCTURES AS SHOWN ARE BASED ON THE BEST INFORMATION AVAILABLE BUT NO GUARANTEE IS GIVEN THAT ALL EXISTING UTILITIES ARE SHOWN OR THAT THE GIVEN LOCATIONS ARE EXACT. CONFIRMATION OF EXISTENCE AND EXACT LOCATION OF ALL SERVICES MUST BE OBTAINED FROM THE INDIVIDUAL UTILITIES BEFORE PROCEEDING WITH CONSTRUCTION.

NO.	REVISIONS	DATE	BY
04	ISSUED FOR CONSTRUCTION	2019-08-01	SLF
3	REVISED TO ASBUILT	2017-11-01	K.R.
2	ISSUED FOR TENDER	2012-11-01	D.K.G.
1	ISSUED FOR 60% REVIEW	2012-07-25	D.K.G.

Stantec Consulting Ltd.
 905 Waverley Street, Winnipeg, Manitoba
 Tel 204-489-5900 Fax 204-453-9012

DESIGNED BY: B.S.J
 CHECKED BY: S.T.
 DRAWN BY: D.K.G.
 APPROVED BY: S.K.B.

HOR. SCALE: NTS
 VERTICAL: DATE 2012.01.10

ENGINEER'S SEAL

BID OPPORTUNITY NO. 630-2019

THE CITY OF WINNIPEG
 WATER AND WASTE DEPARTMENT

Winnipeg

NORTH END WATER POLLUTION CONTROL CENTRE
 REHABILITATION OF DIGESTER No. 11, SLUDGE HOLDING TANKS No. 5 AND No. 7

DIGESTER No. 11 GAS COLLECTION SYSTEM P&ID

CITY DRAWING NUMBER 1-1010D-A0106-001

SHEET 17 OF 44