


- CONSTRUCTION NOTES:**
- 1 REPLACE EXISTING MOTOR WITH NEW EXPLOSION-PROOF MOTOR.
 - 2 DISCONNECT AND SALVAGE DISCONNECT SWITCH. REMOVE AUXILIARY CONTACT WIRING CURRENTLY INTEGRATED INTO E-STOP CIRCUIT.
 - 3 INSTALL NEW EXPLOSION-PROOF EMERGENCY STOP SWITCH. RE-WIRE AS SHOWN.
 - 4 RUN NEW CABLE AND CONNECT THERMISTOR WIRING AS SHOWN.
 - 5 MODIFY VFD CABINET AS SHOWN. INSTALL DIN RAIL AND WIRING DUCT AS REQUIRED. SET VFD PARAMETERS AS REQUIRED AND COMMISSION.
 - 6 REMOVE EXISTING NON-HAZARDOUS RATED JUNCTION BOXES. INSTALL NEW HAZARDOUS RATED JUNCTION BOX WITH TERMINALS TO EXTEND WIRING.
 - 7 INSTALL NEW JUNCTION BOX WITH 200A RATED TERMINALS AND APPROPRIATELY SIZED FOR CABLE BEND RADIUS. LOCATE IN CEILING SPACE OF GALLERY BELOW THE EAST GAS ROOM.
 - 8 PROVIDE WARNING LAMACOID IN ACCORDANCE WITH E14.

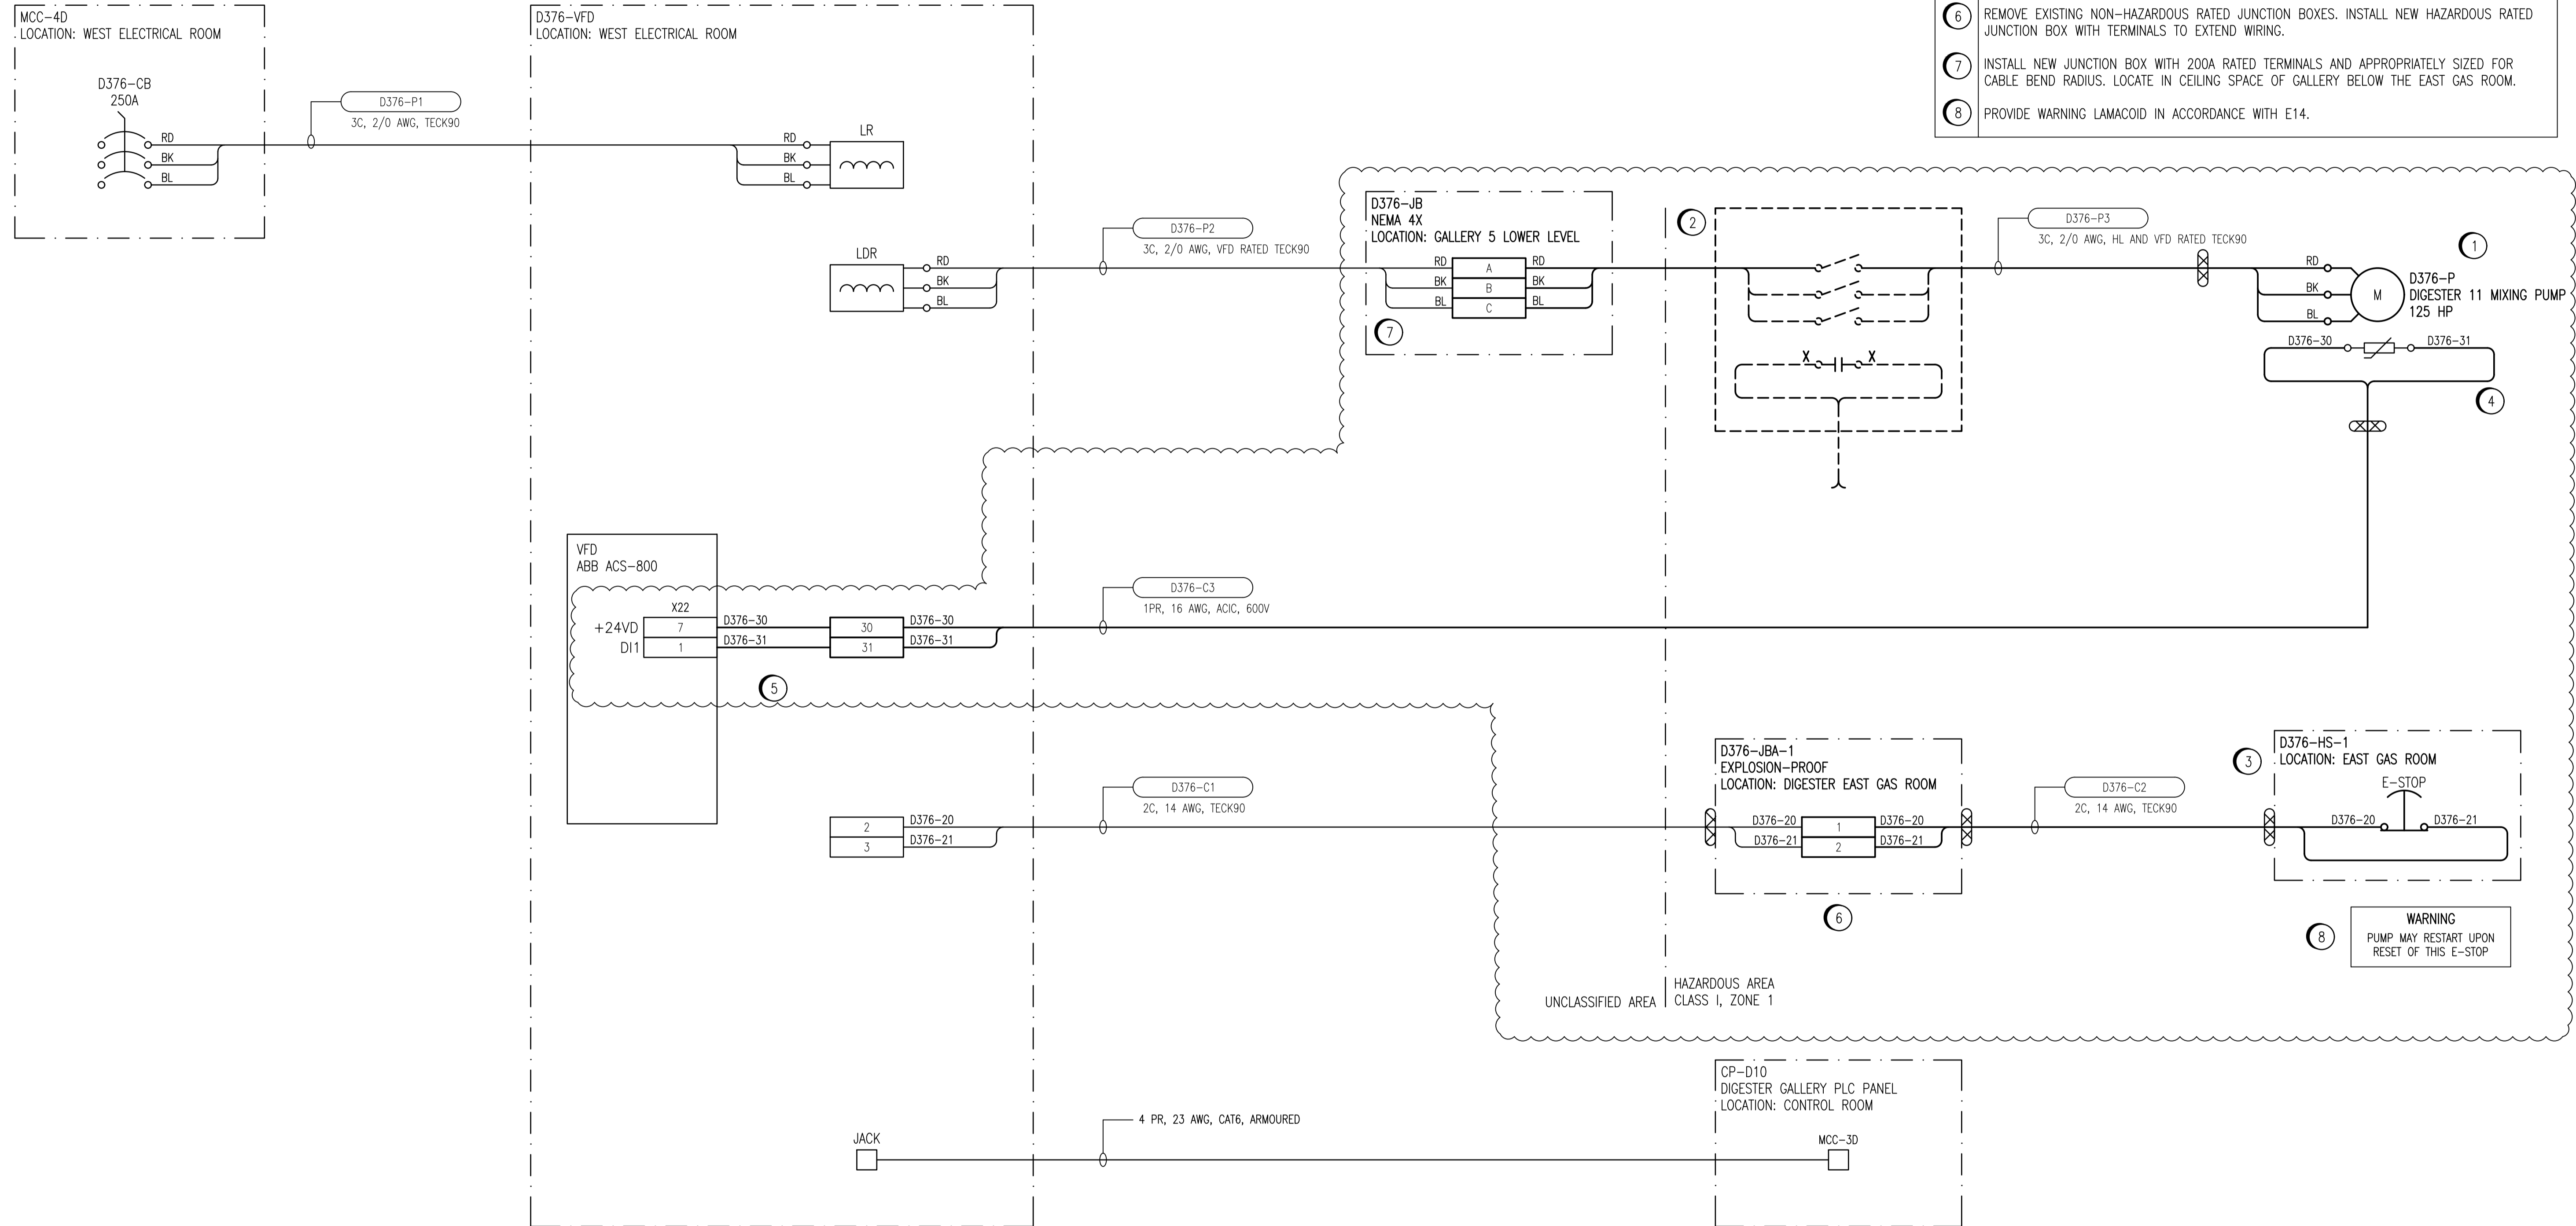

LEGEND
 HAZARDOUS RATED SEAL

NOTES:
 1. THIS DRAWING IS BASED UPON SHOP DRAWING 14384C-D376

REVISION 00
 THE ENGINEER'S DESIGN RESPONSIBILITIES ARE LIMITED TO THE CHANGES INDICATED IN THE CLOUDED WORK

DESIGNED BY: C. REIMER	CHECKED BY: -
DRAWN BY: S. FUNK	APPROVED BY: -
DATE: 2019-06-17	



LOCATION APPROVED UNDERGROUND STRUCTURES

SUPV. U/G STRUCTURES COMMITTEE	DATE

NOTE:
 LOCATION OF UNDERGROUND STRUCTURES AS SHOWN ARE BASED ON THE BEST INFORMATION AVAILABLE BUT NO GUARANTEE IS GIVEN THAT ALL EXISTING UTILITIES ARE SHOWN OR THAT THE GIVEN LOCATIONS ARE EXACT. CONFIRMATION OF EXISTENCE AND EXACT LOCATION OF ALL SERVICES MUST BE OBTAINED FROM THE INDIVIDUAL UTILITIES BEFORE PROCEEDING WITH CONSTRUCTION.

B.M. ELEV.	
NO.	REVISIONS
DATE	BY
2019-08-01	SLF
2019-05-20	

CENGYS

DESIGNED BY: C. REIMER	CHECKED BY: C. REIMER
DRAWN BY: S. FUNK	APPROVED BY: C. REIMER
HOR. SCALE: -	RELEASED FOR CONSTRUCTION: K. SCHIMKE
VERTICAL: -	DATE: 2019-08-01

ENGINEER'S SEAL

BID OPPORTUNITY NO. 630-2019

THE CITY OF WINNIPEG
 WATER AND WASTE DEPARTMENT

NORTH END SEWAGE TREATMENT PLANT

CONNECTION DIAGRAM
 VFD-D376
 MIXING PUMP

CITY DRAWING NUMBER: 1-0101D-E0026-001

SHEET 11 OF 44

1-0101D-A0113-002	INSTRUMENT LOCATION PLAN - EAST GAS ROOM
1-0101D-E0020-001	WEST ELECTRICAL ROOM LAYOUT
1-0101D-E0023-001	ELECTRICAL PLAN LAYOUT - EAST GAS ROOM
REFERENCE DRAWING	DESCRIPTION