


**CRAWLSPACE POWER PLAN**  
1:20

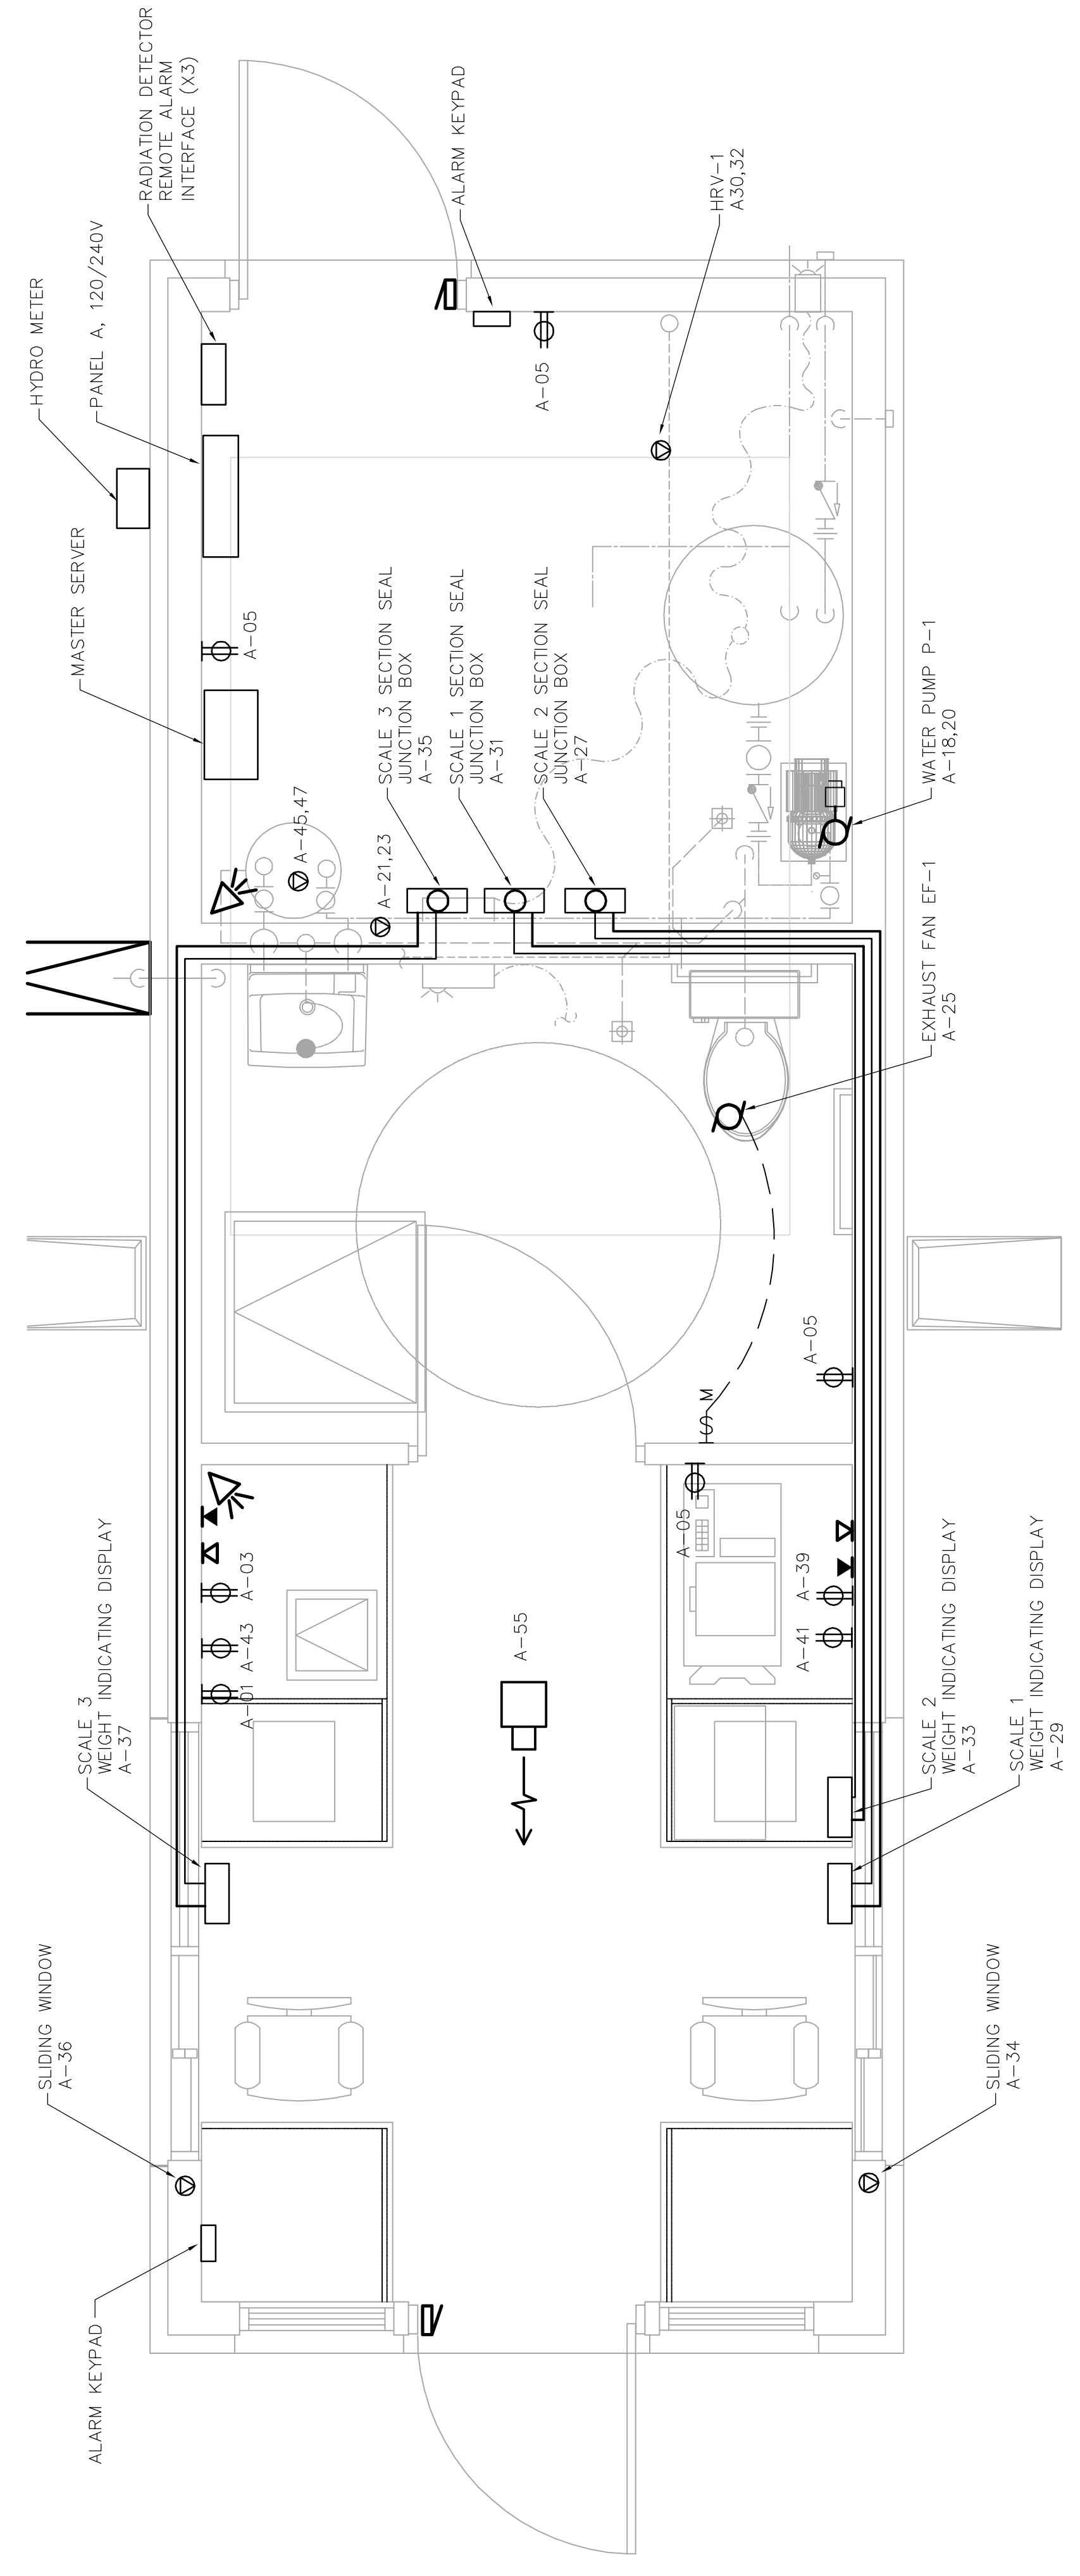

**MAIN FLOOR POWER PLAN**  
1:20

<b>EarthTech</b> <small>A Division of</small> <b>Frederickson Cooper</b> <small>ARCHITECTS</small>		DESIGNED BY: GSN DRAWN BY: ERC SCALE: ERC CHECKED BY: BLM APPROVED BY: RELEASED FOR CONSTRUCTION BY:	DATE: 2006/08/31 DATE: 06/09/27 DATE: 06/09/27
B.M. ELEV.	NO. REVISIONS	DATE	BY
A	1	06/09/27	ERC

**THE CITY OF WINNIPEG**  
**WATER AND WASTE DEPARTMENT**  
**Engineering Division**  
 BRADY RD. LANDFILL  
 NEW ENTRANCE AND  
 SCALE FACILITY  
 ELECTRICAL  
 CRAWLSPACE AND MAIN FLOOR  
 POWER PLAN

ENGINEER'S SEAL  
**PRELIMINARY**  
 NOT FOR CONSTRUCTION  
 CONSULTANT DRAWING NO. E1.04

CITY FILE NUMBER  
 SHEET OF  
 CITY DRAWING NUMBER