


**1** CLIFTON LIFT STATION - EXISTING SINGLE LINE DIAGRAM  
SCALE: N.T.S.

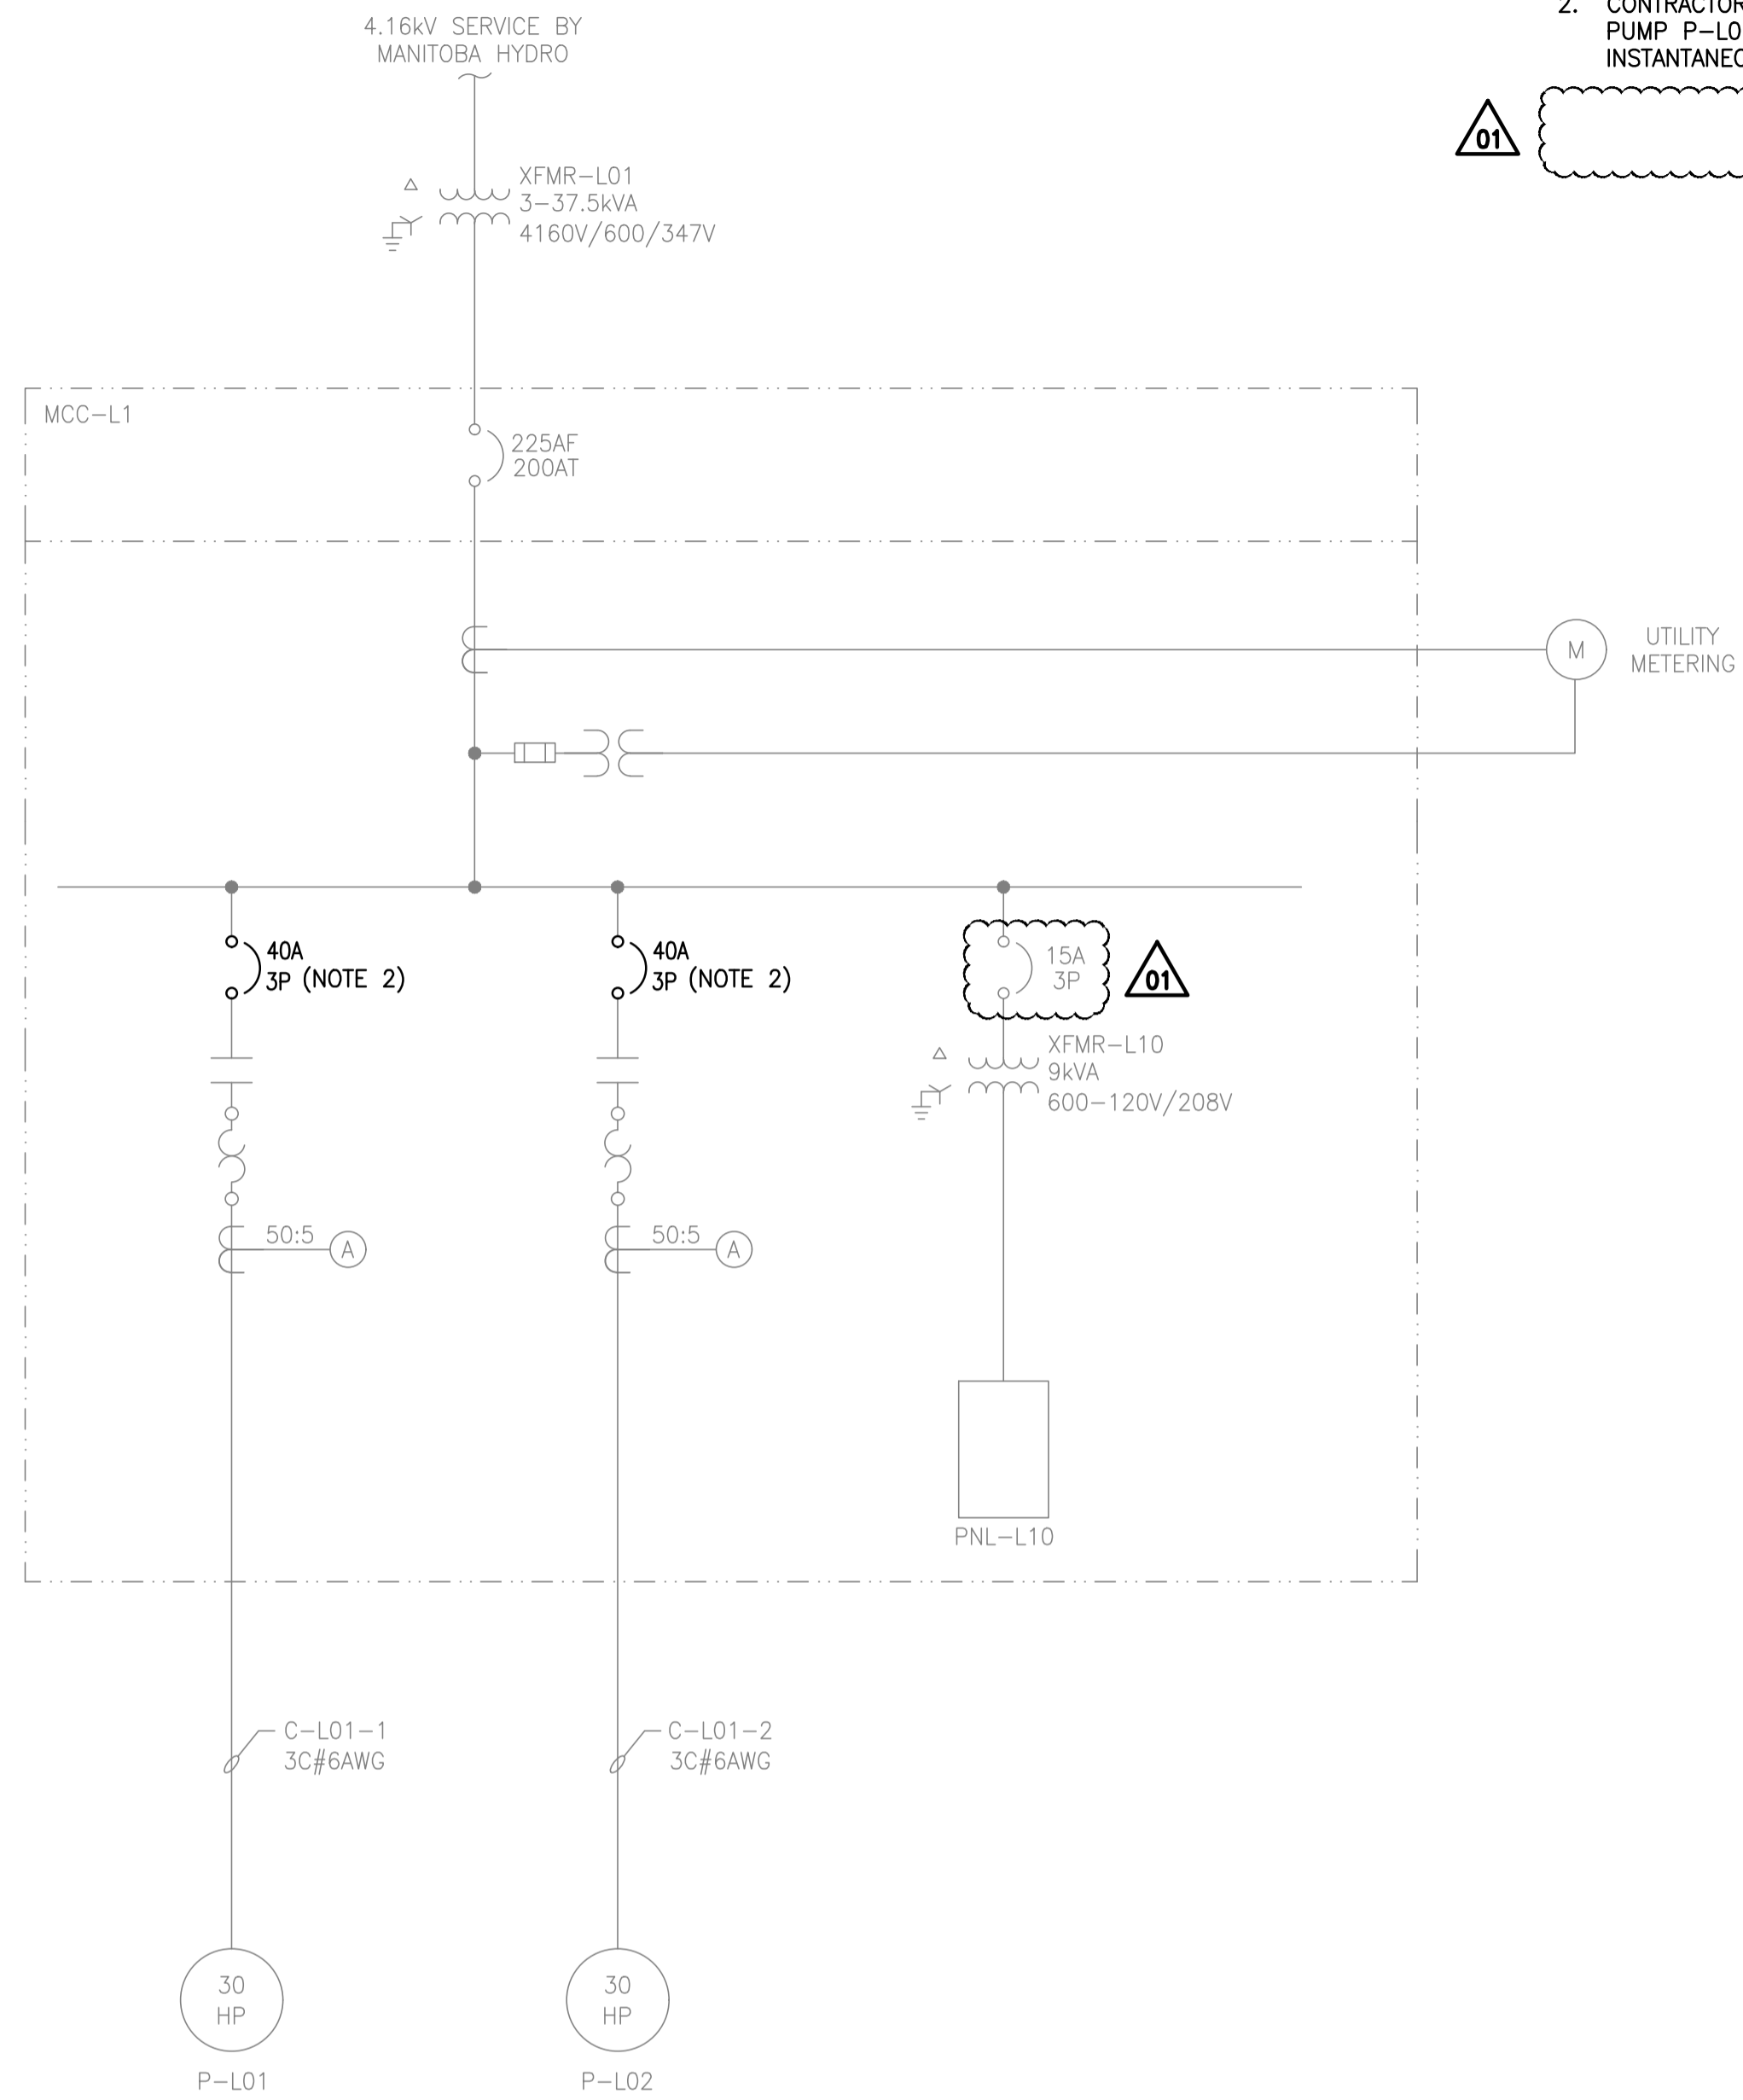

**2** CLIFTON LIFT STATION - PROPOSED SINGLE LINE DIAGRAM  
SCALE: N.T.S.

**NOTES:**

1. GREY ITEMS DENOTES EXISTING EQUIPMENT.
2. CONTRACTOR SHALL REPLACE THE MOTOR CIRCUIT PROTECTOR FOR LIFT PUMP P-L01 AND P-L02 WITH 40A RATED MODELS THAT HAVE AN INSTANTANEOUS SETTING OF 320A.



B.M.	-				
ELEV.	-				
01	RE-ISSUED FOR TENDER AND CONSTRUCTION	2019/08/01	LU	JAB	
00	ISSUED FOR TENDER AND CONSTRUCTION	2019/07/12	LU	JAB	
NO.	REVISIONS	DATE	DESIGN	CHECK	

<b>KGS GROUP</b> CONSULTING ENGINEERS	
DESIGNED BY: L. UPPAL	CHECKED BY: J. BOUCHARD
DRAWN BY: J. deLEON	APPROVED BY: J. BOUCHARD
SCALE: AS NOTED	ISSUED FOR CONSTRUCTION BY: DATE:
DATE: 2019/07/12	DATE:
CONSULTANT NO.: 19-0107-002_E24	

ENGINEER'S SEAL
-----------------

 THE CITY OF WINNIPEG WATER AND WASTE DEPARTMENT		
CLIFTON FLOOD PUMPING STATION UPGRADES  ELECTRICAL CLIFTON LIFT STATION SINGLE LINE DIAGRAM		
CITY DRAWING NUMBER 1-0125F-E0030-001	SHEET 01	REV. 01
	SIZE A1	