


NOTES:

- 1. CLOUDED ITEMS DENOTES EQUIPMENT TO REMAIN.

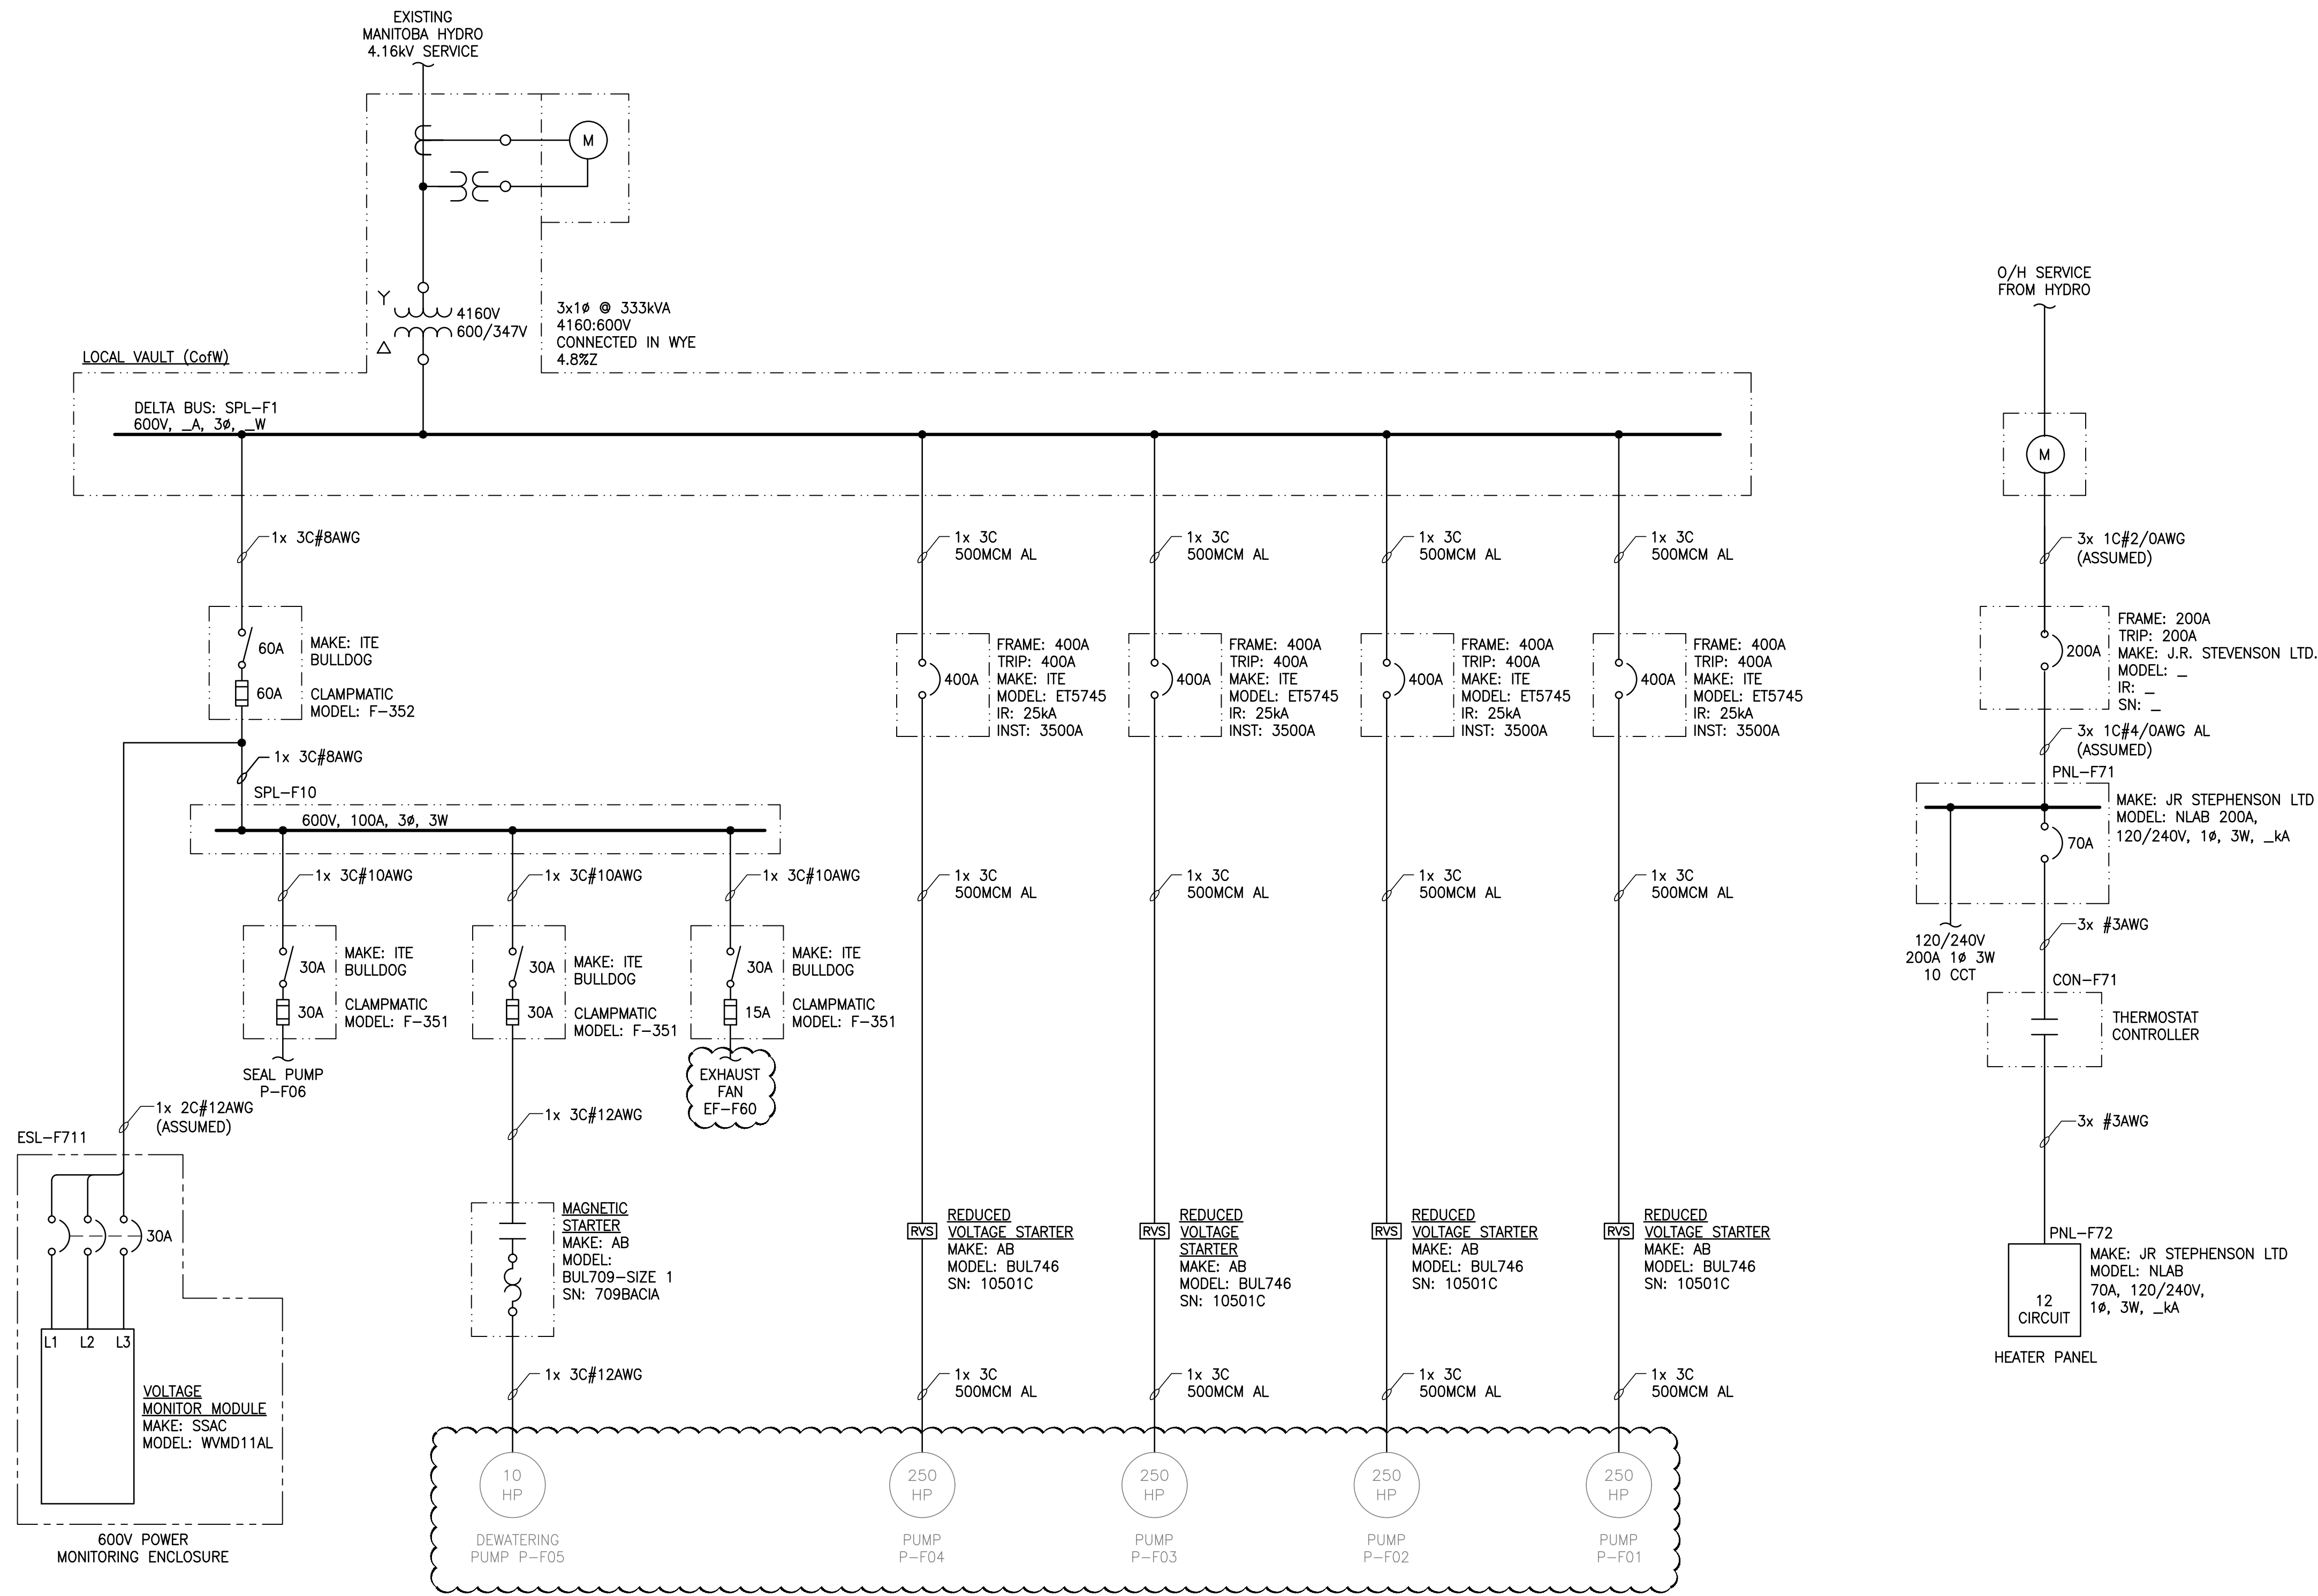

B.M.	-
ELEV.	-
NO.	REVISIONS
00	ISSUED FOR TENDER AND CONSTRUCTION
DATE	2019/07/12
DESIGN	LU
CHECK	JAB



KGS GROUP CONSULTING ENGINEERS	
DESIGNED BY: L. UPPAL	CHECKED BY: J. BOUCHARD
DRAWN BY: J. deLEON	APPROVED BY: J. BOUCHARD
SCALE: AS NOTED	ISSUED FOR CONSTRUCTION BY: DATE:
DATE: 2019/07/12	DATE:
CONSULTANT NO.: 19-0107-002_E02	

ENGINEER'S SEAL

THE CITY OF WINNIPEG
WATER AND WASTE DEPARTMENT

CLIFTON FLOOD PUMPING STATION UPGRADES

**ELECTRICAL
SINGLE LINE DIAGRAM
DEMOLITION**

CITY DRAWING NUMBER 1-0125F-E0003-001	SHEET 00	REV. 00	SIZE A1
---	--------------------	-------------------	-------------------