


NOTES:
 1. GREY ITEMS DENOTES EXISTING STRUCTURES AND EQUIPMENT.

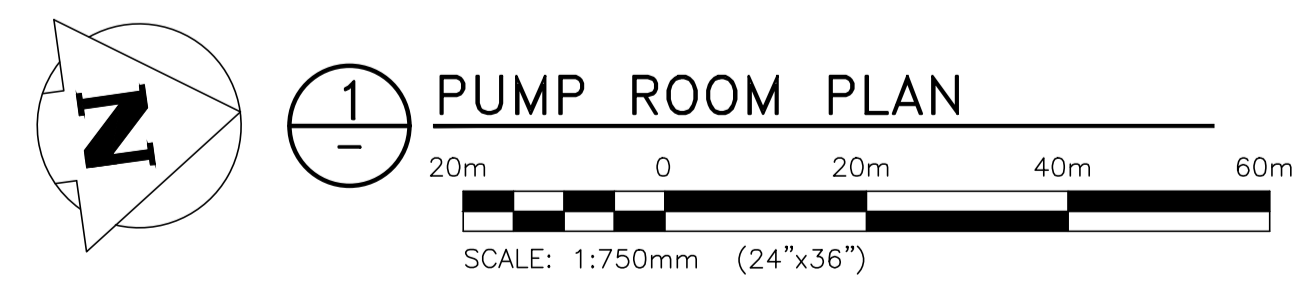

ENGINEERS
 GEOSCIENTISTS
 MANITOBA
 Certificate of Authorization
 KGS Group
 No. 245

NO.	REVISIONS	DATE	DESIGN	CHECK
01	RE-ISSUED FOR TENDER AND CONSTRUCTION	2019/07/17	LU	JAB
00	ISSUED FOR TENDER AND CONSTRUCTION	2019/07/12	LU	JAB

KGS GROUP CONSULTING ENGINEERS	
DESIGNED BY: L. UPPAL	CHECKED BY: J. BOUCHARD
DRAWN BY: G. NELSON	APPROVED BY: J. BOUCHARD
SCALE: AS NOTED	ISSUED FOR CONSTRUCTION BY: DATE:
DATE: 2019/07/12	
CONSULTANT NO.: 19-0107-002_E08	

ENGINEER'S SEAL

THE CITY OF WINNIPEG
 WATER AND WASTE DEPARTMENT

CLIFTON FLOOD PUMPING STATION UPGRADES

**ELECTRICAL
 PUMP ROOM
 POWER AND LIGHTING PLAN**

CITY DRAWING NUMBER 1-0125F-E0009-001	SHEET 01	REV. 01	SIZE A1
---	--------------------	-------------------	-------------------