


1

LIFT STATION

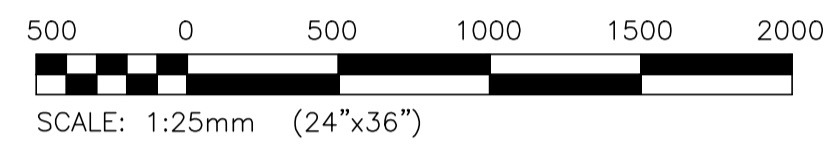

NOTES:

- 1. GREY ITEMS DENOTES EXISTING EQUIPMENT.

B.M. - ELEV. -				ENGINEER'S SEAL				
						CLIFTON FLOOD PUMPING STATION UPGRADES ELECTRICAL CLIFTON LIFT STATION POWER PLAN		
		DESIGNED BY: L. UPPAL	CHECKED BY: J. BOUCHARD			CITY DRAWING NUMBER		
		DRAWN BY: J. deLEON	APPROVED BY: J. BOUCHARD			1-0125F-E0031-001		
		SCALE: AS NOTED	ISSUED FOR CONSTRUCTION BY:			SHEET	REV.	SIZE
		DATE: 2019/07/12	DATE:			00	00	A1
00		ISSUED FOR TENDER AND CONSTRUCTION	2019/07/12	LU	JAB	CONSULTANT NO.: 19-0107-002_E25		
NO.	REVISIONS	DATE	DESIGN	CHECK				