

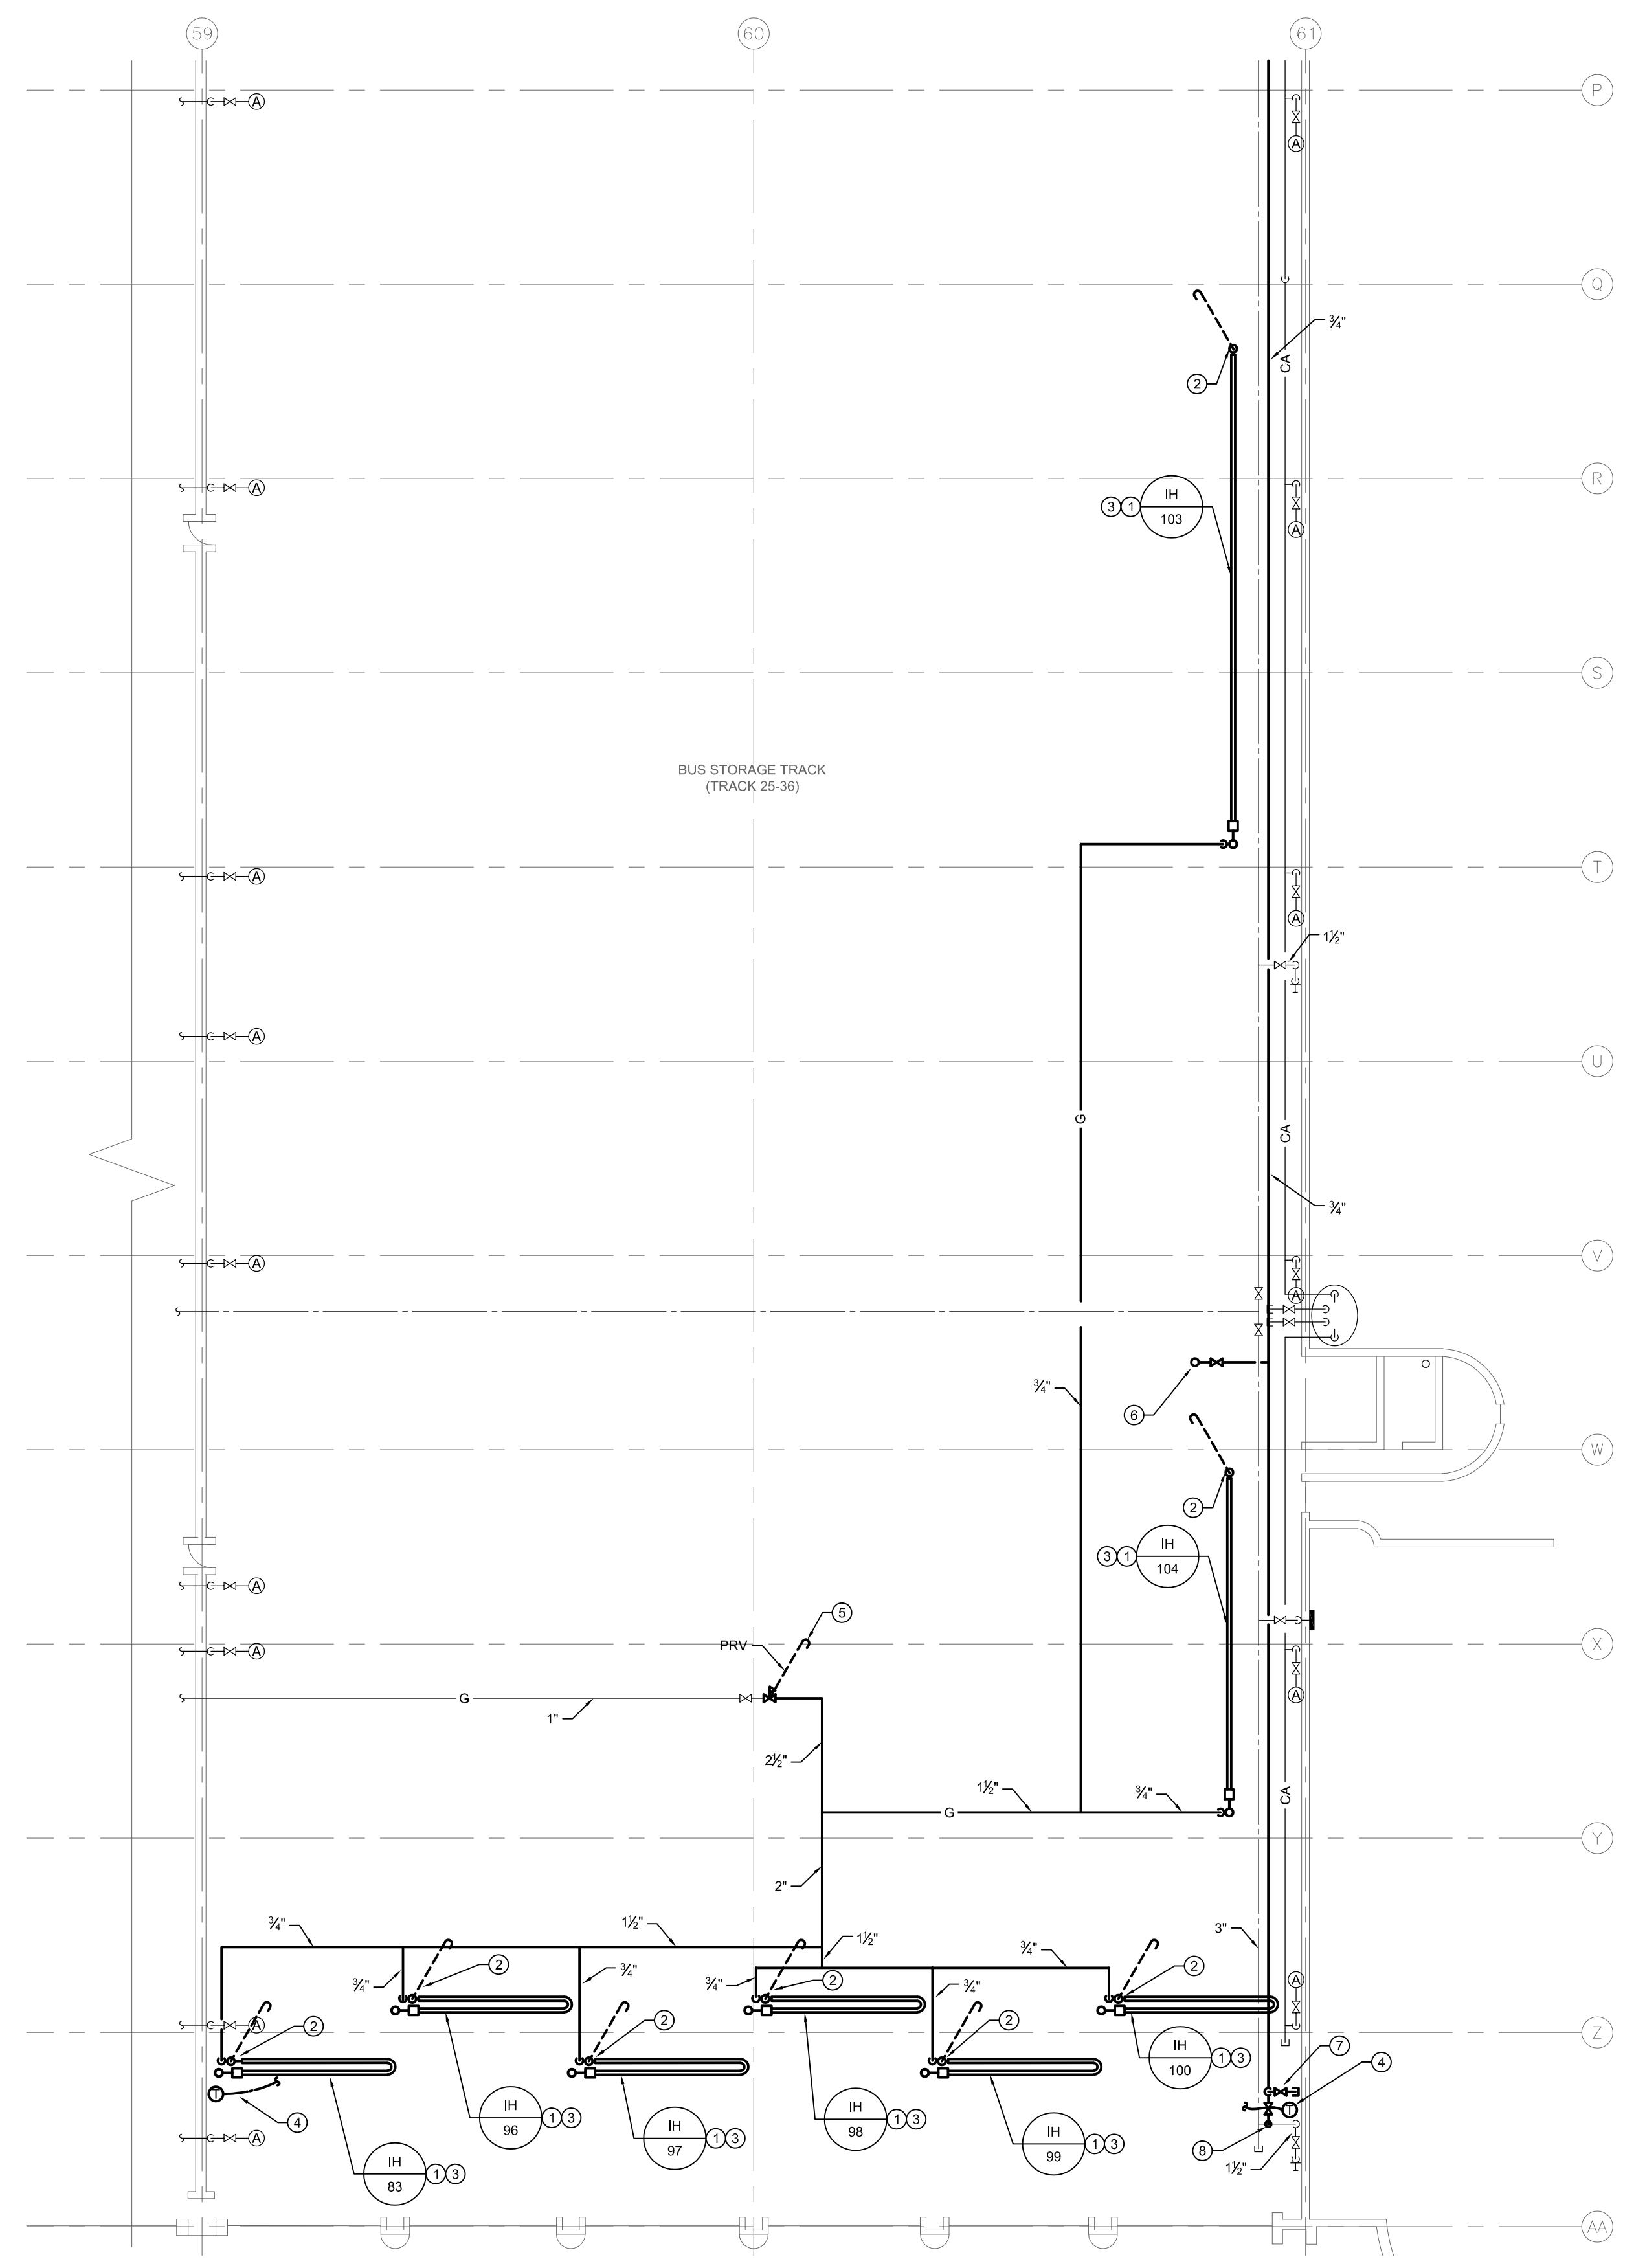


1 MAIN FLOOR PLAN - TRACK 25-36 - PLUMBING - NEW CONSTRUCTION (GRID LINES A-P)
 M2.1 SCALE: 1/16" = 1'-0"

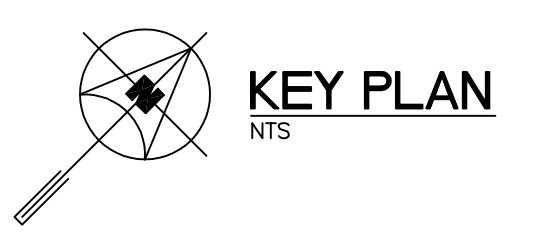

2 MAIN FLOOR PLAN - TRACK 25-36 - PLUMBING - NEW CONSTRUCTION (GRID LINES P-AA)
 M2.1 SCALE: 1/16" = 1'-0"

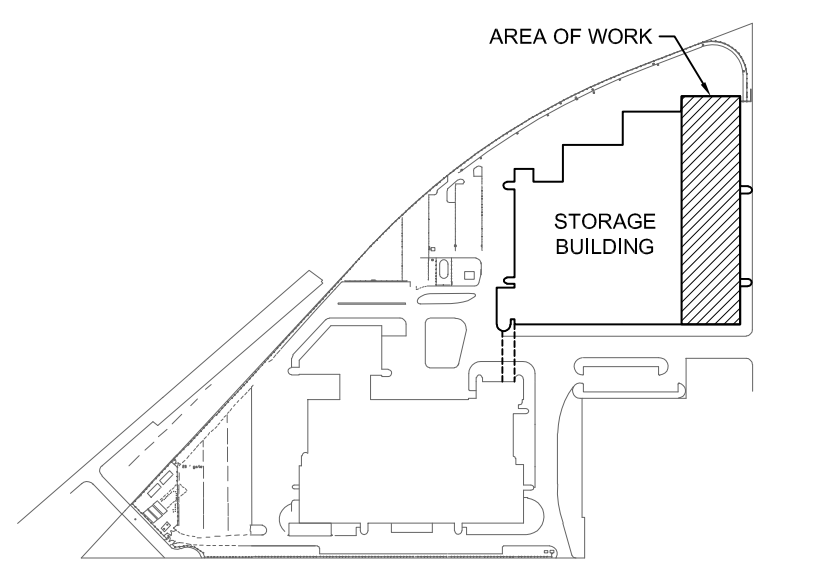

GENERAL NOTES

- A. ALL ABANDONED EQUIPMENT AND SERVICES WITHIN AREA OF WORK SHALL BE REMOVED.
- B. THIS BUILDING MAY CONTAIN ASBESTOS. REFER TO FRONT END SPECIFICATIONS FOR FURTHER INFORMATION.
- C. REFER TO ROOF DETAILS AND SPECIFICATIONS FOR ALL NEW AND CAPPED OPENINGS.

KEY NOTES


- 1. PROVIDE NEW GAS FIRED INFRARED HEATER. INSTALL AS HIGH AS POSSIBLE BUT AT LEAST 5' ABOVE HEIGHT OF BUS. PROVIDE MAXIMUM ALLOWANCE STACKING HEIGHT SIGNS AND OTHER SIGNS REQUIRED BY MANUFACTURER. PROVIDE LOWER RADIANT SHIELD TO BURNER. INSTALL IN ACCORDANCE WITH MANUFACTURER REQUIREMENTS.
- 2. INSTALL FLUE VENT IN ACCORDANCE WITH MANUFACTURER REQUIREMENTS.
- 3. COMBUSTION AIR INTAKE THROUGH ROOF. PROVIDE WEATHER TIGHT SEAL IN ACCORDANCE WITH ROOF DETAIL. CONTRACTOR TO CONFIRM EXACT LOCATION ON SITE. REFER TO DETAIL 4M6.1.
- 4. PROVIDE NEW THERMOSTAT AND WIRE TO BLACK BULB SENSOR MOUNTED BETWEEN UNITS. INSTALL IN ACCORDANCE WITH MANUFACTURER REQUIREMENTS.
- 5. PRV VENT THROUGH THE ROOF. PROVIDE WEATHER TIGHT SEAL. CONTRACTOR TO CONFIRM THE EXACT LOCATION ON SITE.
- 6. CONNECT TO ROOF HYDRANT ABOVE ROOF. NEW ROOF HYDRANT LOCATED BESIDE BOTTOM OF ACCESS PLATFORM STAIR. COORDINATE FINAL LOCATION ON SITE.
- 7. REFER TO 5/M6.1 FOR DETAILS OF NEW ROOF HYDRANT SYSTEM.
- 8. CONNECT TO EXISTING WATER LINE. CONTRACTOR TO CONFIRM ON SITE. PROVIDE HOT TAP FOR TIE-IN TO AVOID SHUTTING DOWN DOMESTIC WATER SERVICE.

NO.	Description	BY	DATE
0	ISSUED FOR CONSTRUCTION	JH	16/01/20

**ENGINEERS
GEOSCIENTISTS
MANITOBA**
 Certificate of Authorization
SMS Engineering Ltd.
 No. 166



770 Bradford Street
 Winnipeg, Canada
 T 204 775 0291
 SMSeng.com

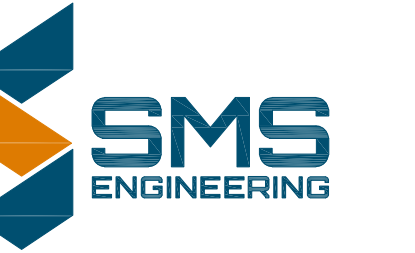

Project Title
**CITY OF WINNIPEG FORT ROUGE
 TRANSIT BASE - STORAGE
 TRACK 25-36 - MECHANICAL
 UPGRADE**
 WINNIPEG MANITOBA

Drawing Title
**MAIN FLOOR PLAN -
 TRACK 25-36 -
 PLUMBING -
 NEW CONSTRUCTION**

Drawn By	Checked By	Approved By
IE	XZ	JH
Scale	Date	Project No.
AS NOTED	JANUARY, 2020	19-332-02
Revision Number	Drawing Number	Sheet Order
0	M2.1	7 OF 14

FILE NAME AND PATH: C:\PROJETS\1918\332\Transit\Track 25-36\Mechanical\Upgrade\02_Civil\Rev03.1\Main\02_Command\1918_02_PL_1_L1.dwg
 LAYOUT: M2.1
 LAST SAVED BY: zml
 DATE PLOTTED: Monday, October 7, 2019 12:02:07 PM