




File Name: U:\PMS\19-0107-005\19-0107-005_S03.dwg - Tab: S03 Plotted By: Fvalencia 07/22/2020 [Wed 2:50pm]

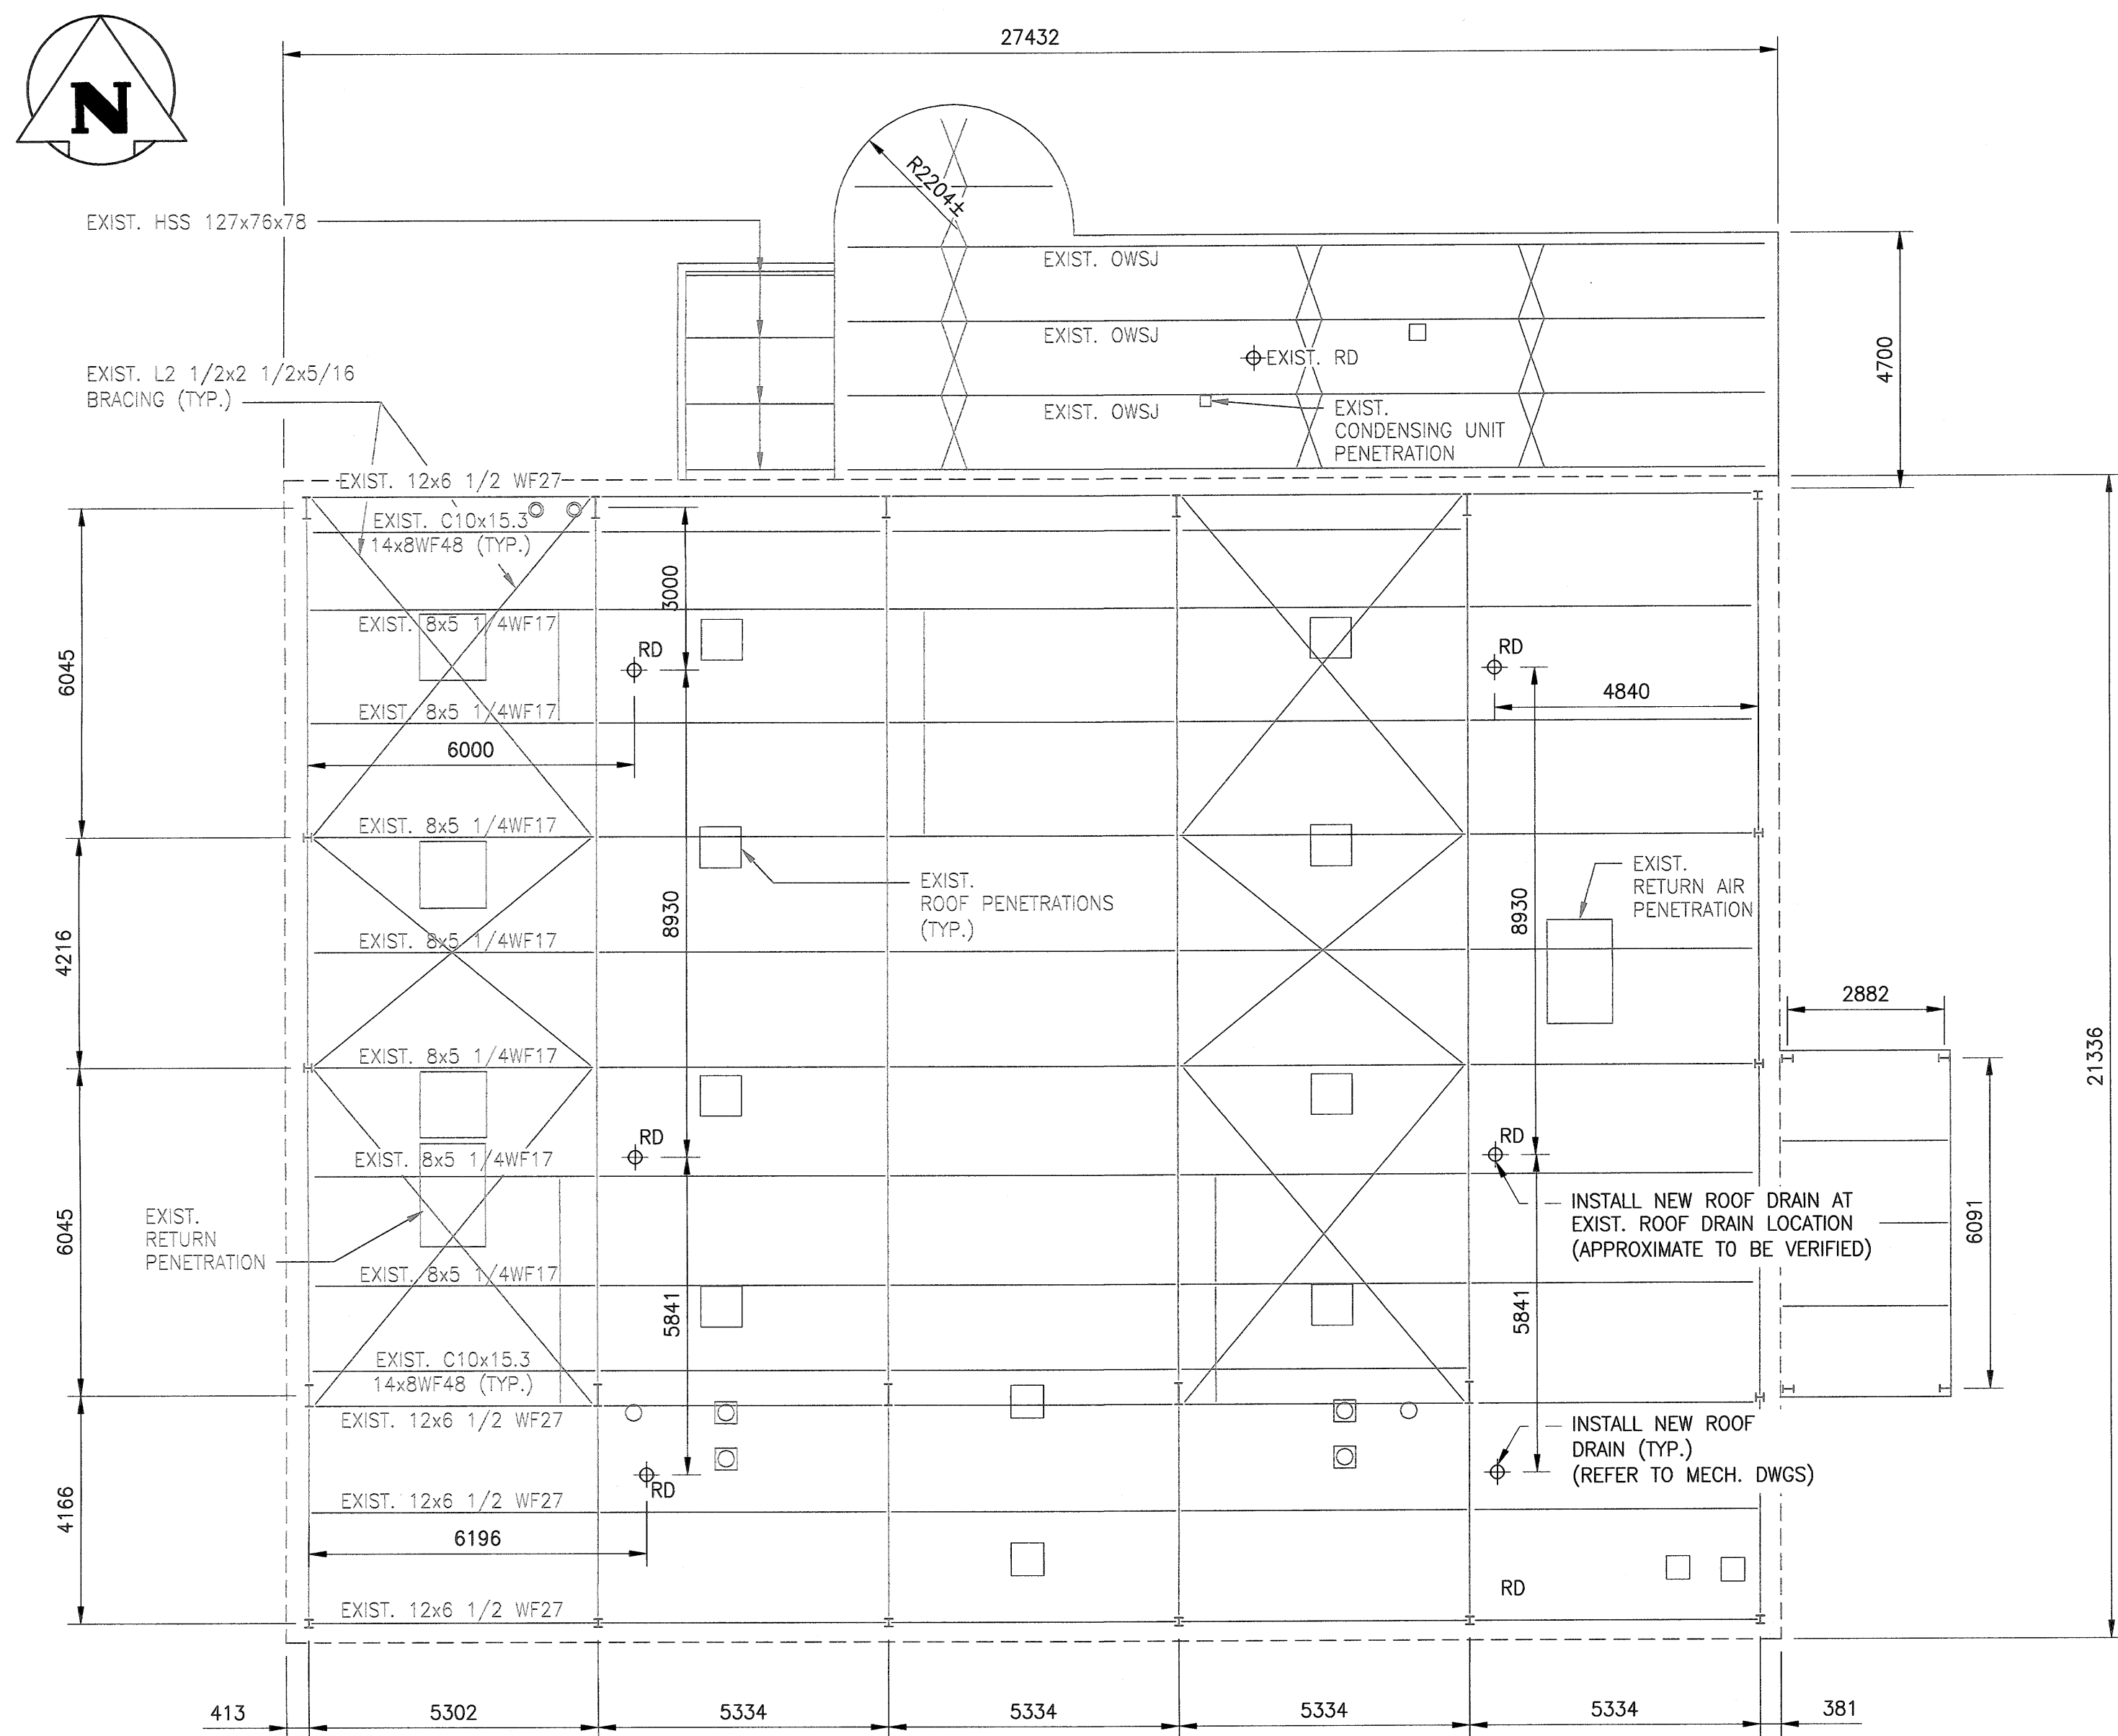


ROOF FRAMING PLAN
SCALE: 1:100

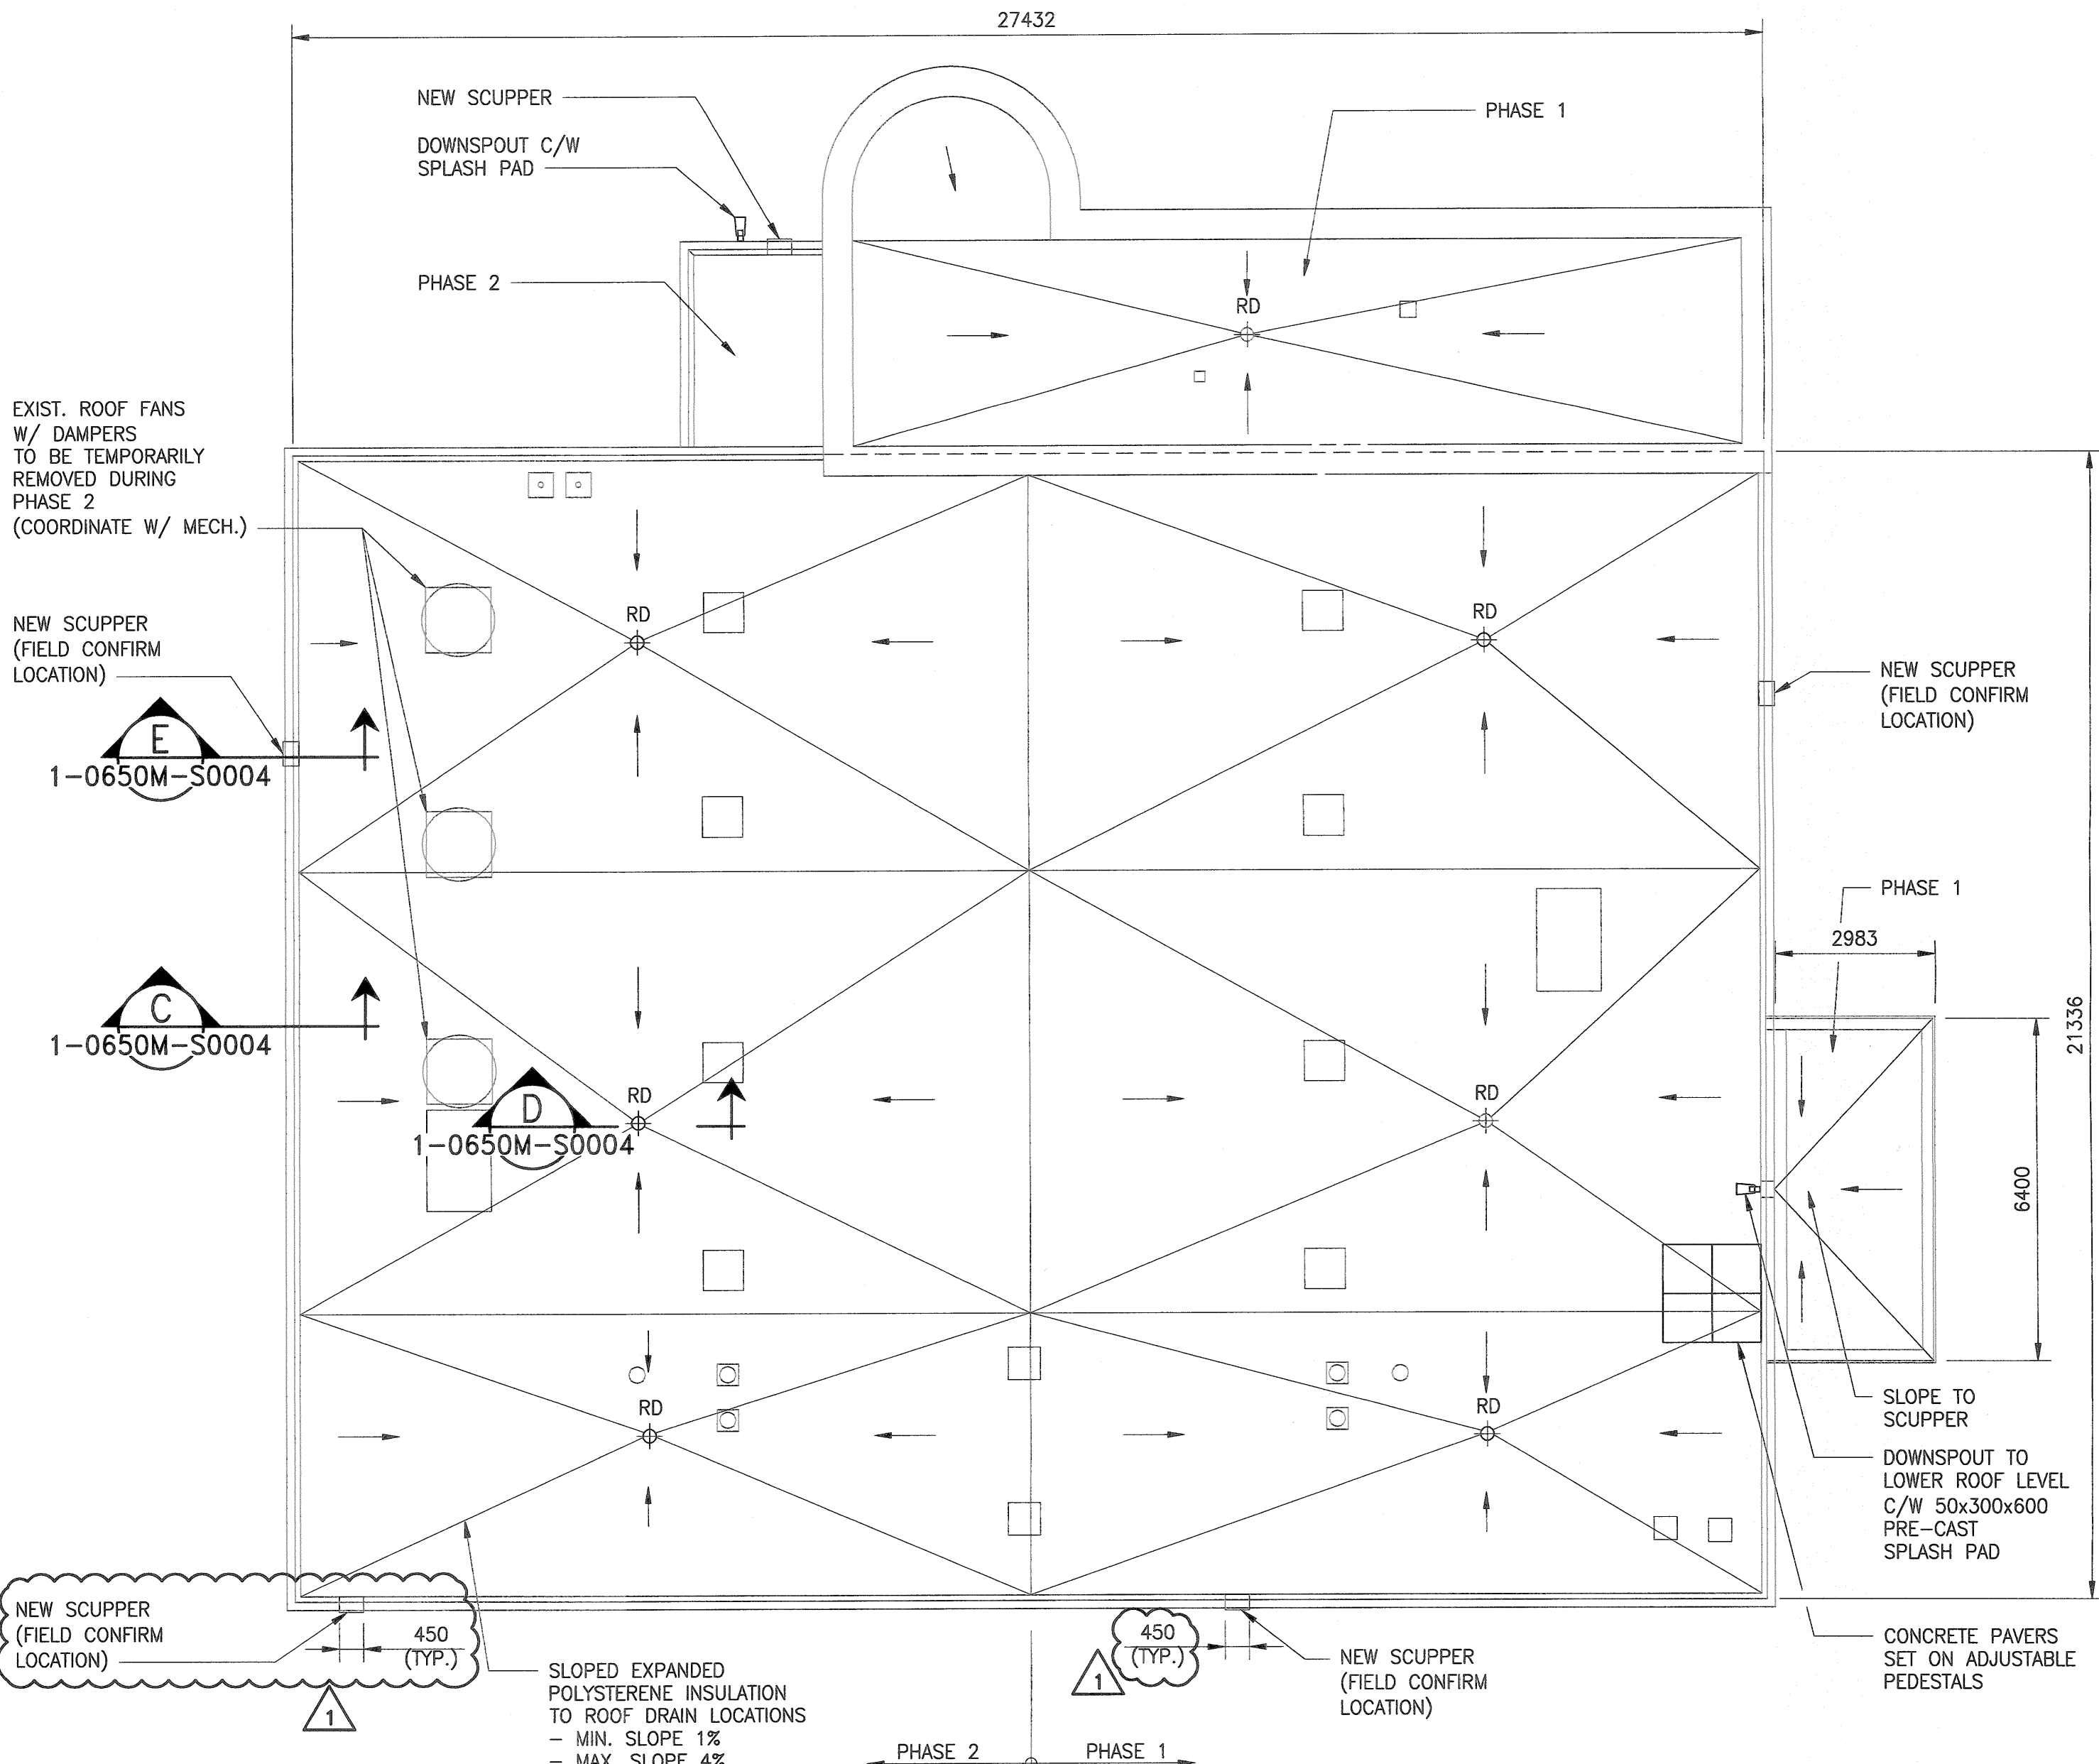

ROOF PLAN
SCALE: 1:100

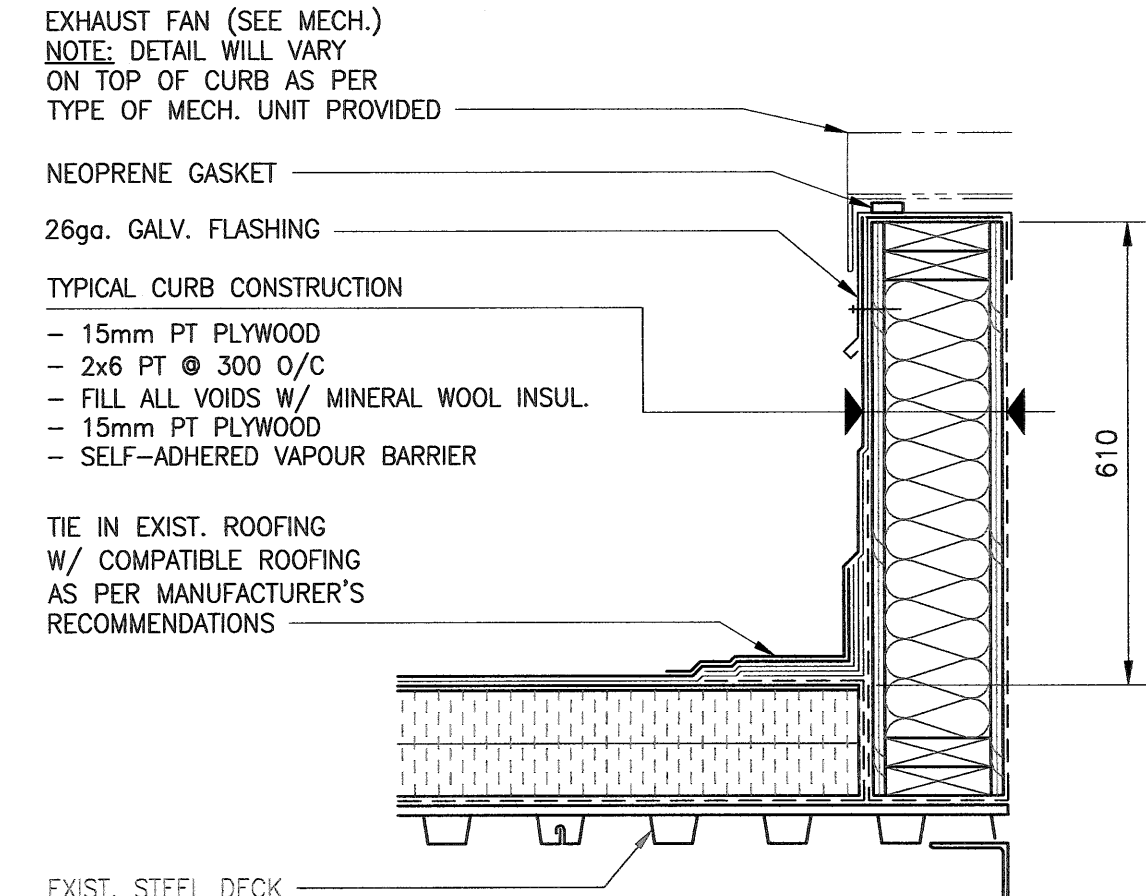

DETAIL - TYPICAL FAN CURB
SCALE: 1:10

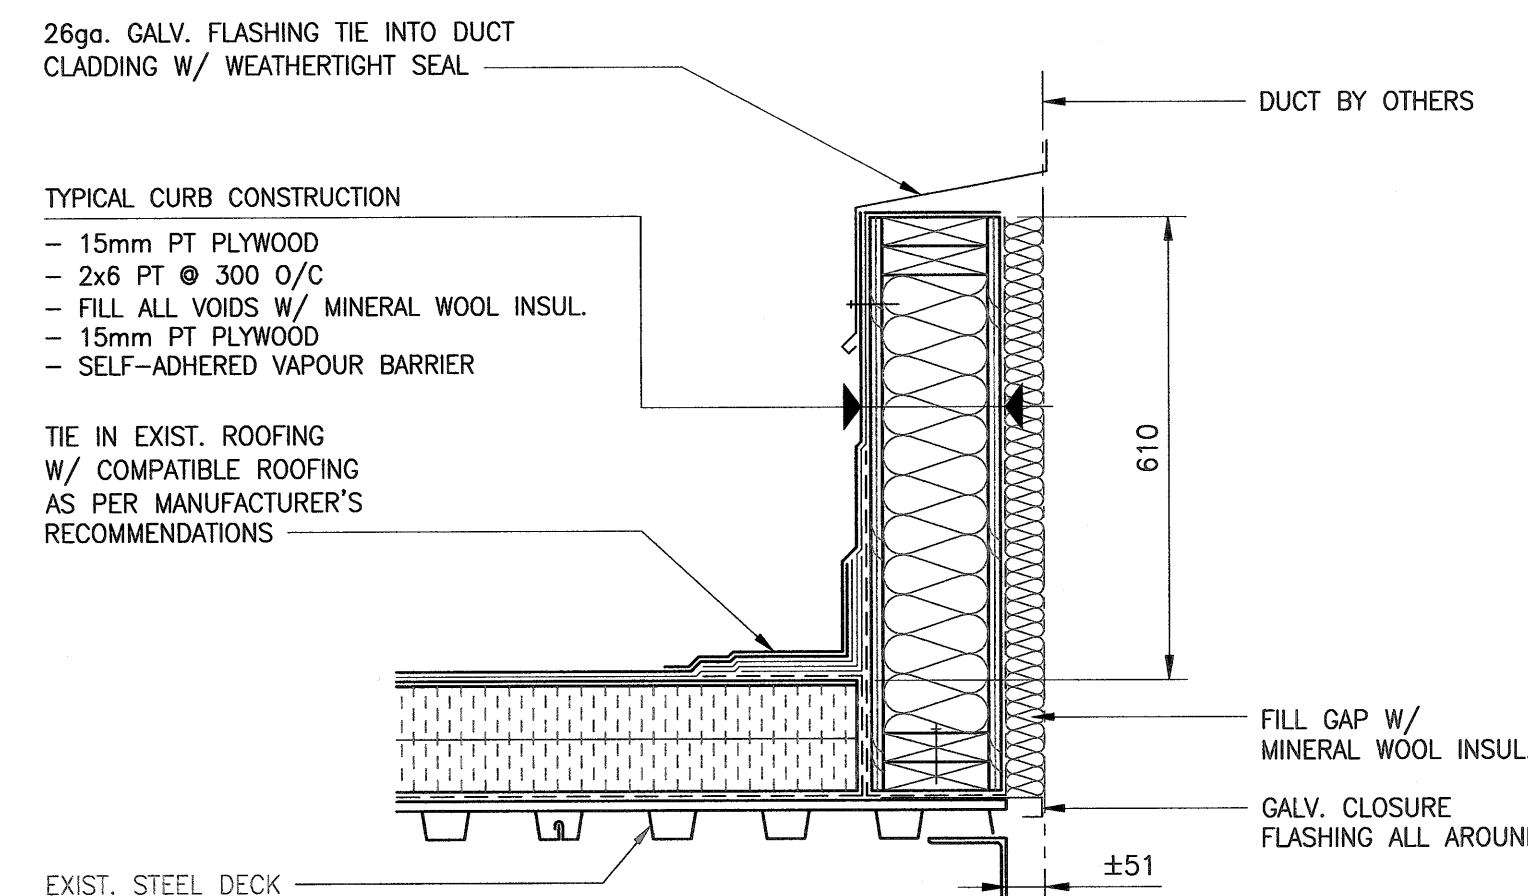

DETAIL - TYPICAL DUCT PENETRATION
SCALE: 1:10

NOTES:

- ROOFING TO BE COMPLETED IN 2 SEPARATE PHASES

LEGEND:


- RD - ROOF DRAIN (NEW)
- HSS - HOLLOW STRUCTURAL SECTION
- WF - WIDE FLANGE BEAM
- OWSJ - OPEN WEB STEEL JOIST
- L - STRUCTURAL ANGLE

METRIC

WHOLE NUMBERS INDICATE MILLIMETRES
DECIMALIZED NUMBERS INDICATE METRES

10		
9		
8		
7		
6		
5		
4		
3		
2	1-0650A-D0001-001	COVER SHEET
1	1-0650M-S0004-001	STRUCTURAL - ROOFING - SECTION AND DETAILS
NO.	DRAWING NUMBER	REFERENCE DRAWING TITLE

REFERENCE DRAWINGS

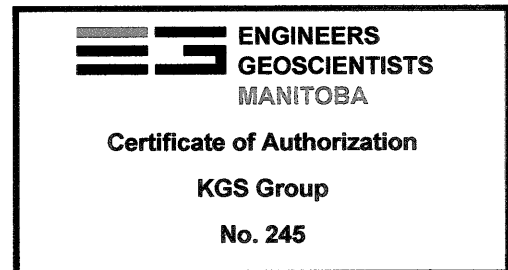

B.M. -	ELEV. -	KGS GROUP DESIGNED BY: L. MILUS-ALPHONSE CHECKED BY: C. SIEPMAN DRAWN BY: F. VALENCIA APPROVED BY: C. SIEPMAN SCALE: AS NOTED DATE: 2019/04/30 CONSULTANT NO.: 19-0107-005_S03	ENGINEER'S SEAL 	THE CITY OF WINNIPEG WATER AND WASTE DEPARTMENT HURST PUMPING STATION STRUCTURAL REPAIRS AND DRAINAGE BUILDING UPGRADES STRUCTURAL PUMP STATION ROOFING PLAN AND DETAILS		
1	RE-ISSUED FOR CONSTRUCTION				2020/07/21	LMA CMS
0	ISSUED FOR CONSTRUCTION				2020/06/18	LMA CMS
NO.	REVISIONS				DATE	DESIGN CHECK

CITY DRAWING NUMBER	SHEET	REV.	SIZE
1-0650M-S0003	001	1	A1