


A1 SIZE - 594mm x 841mm

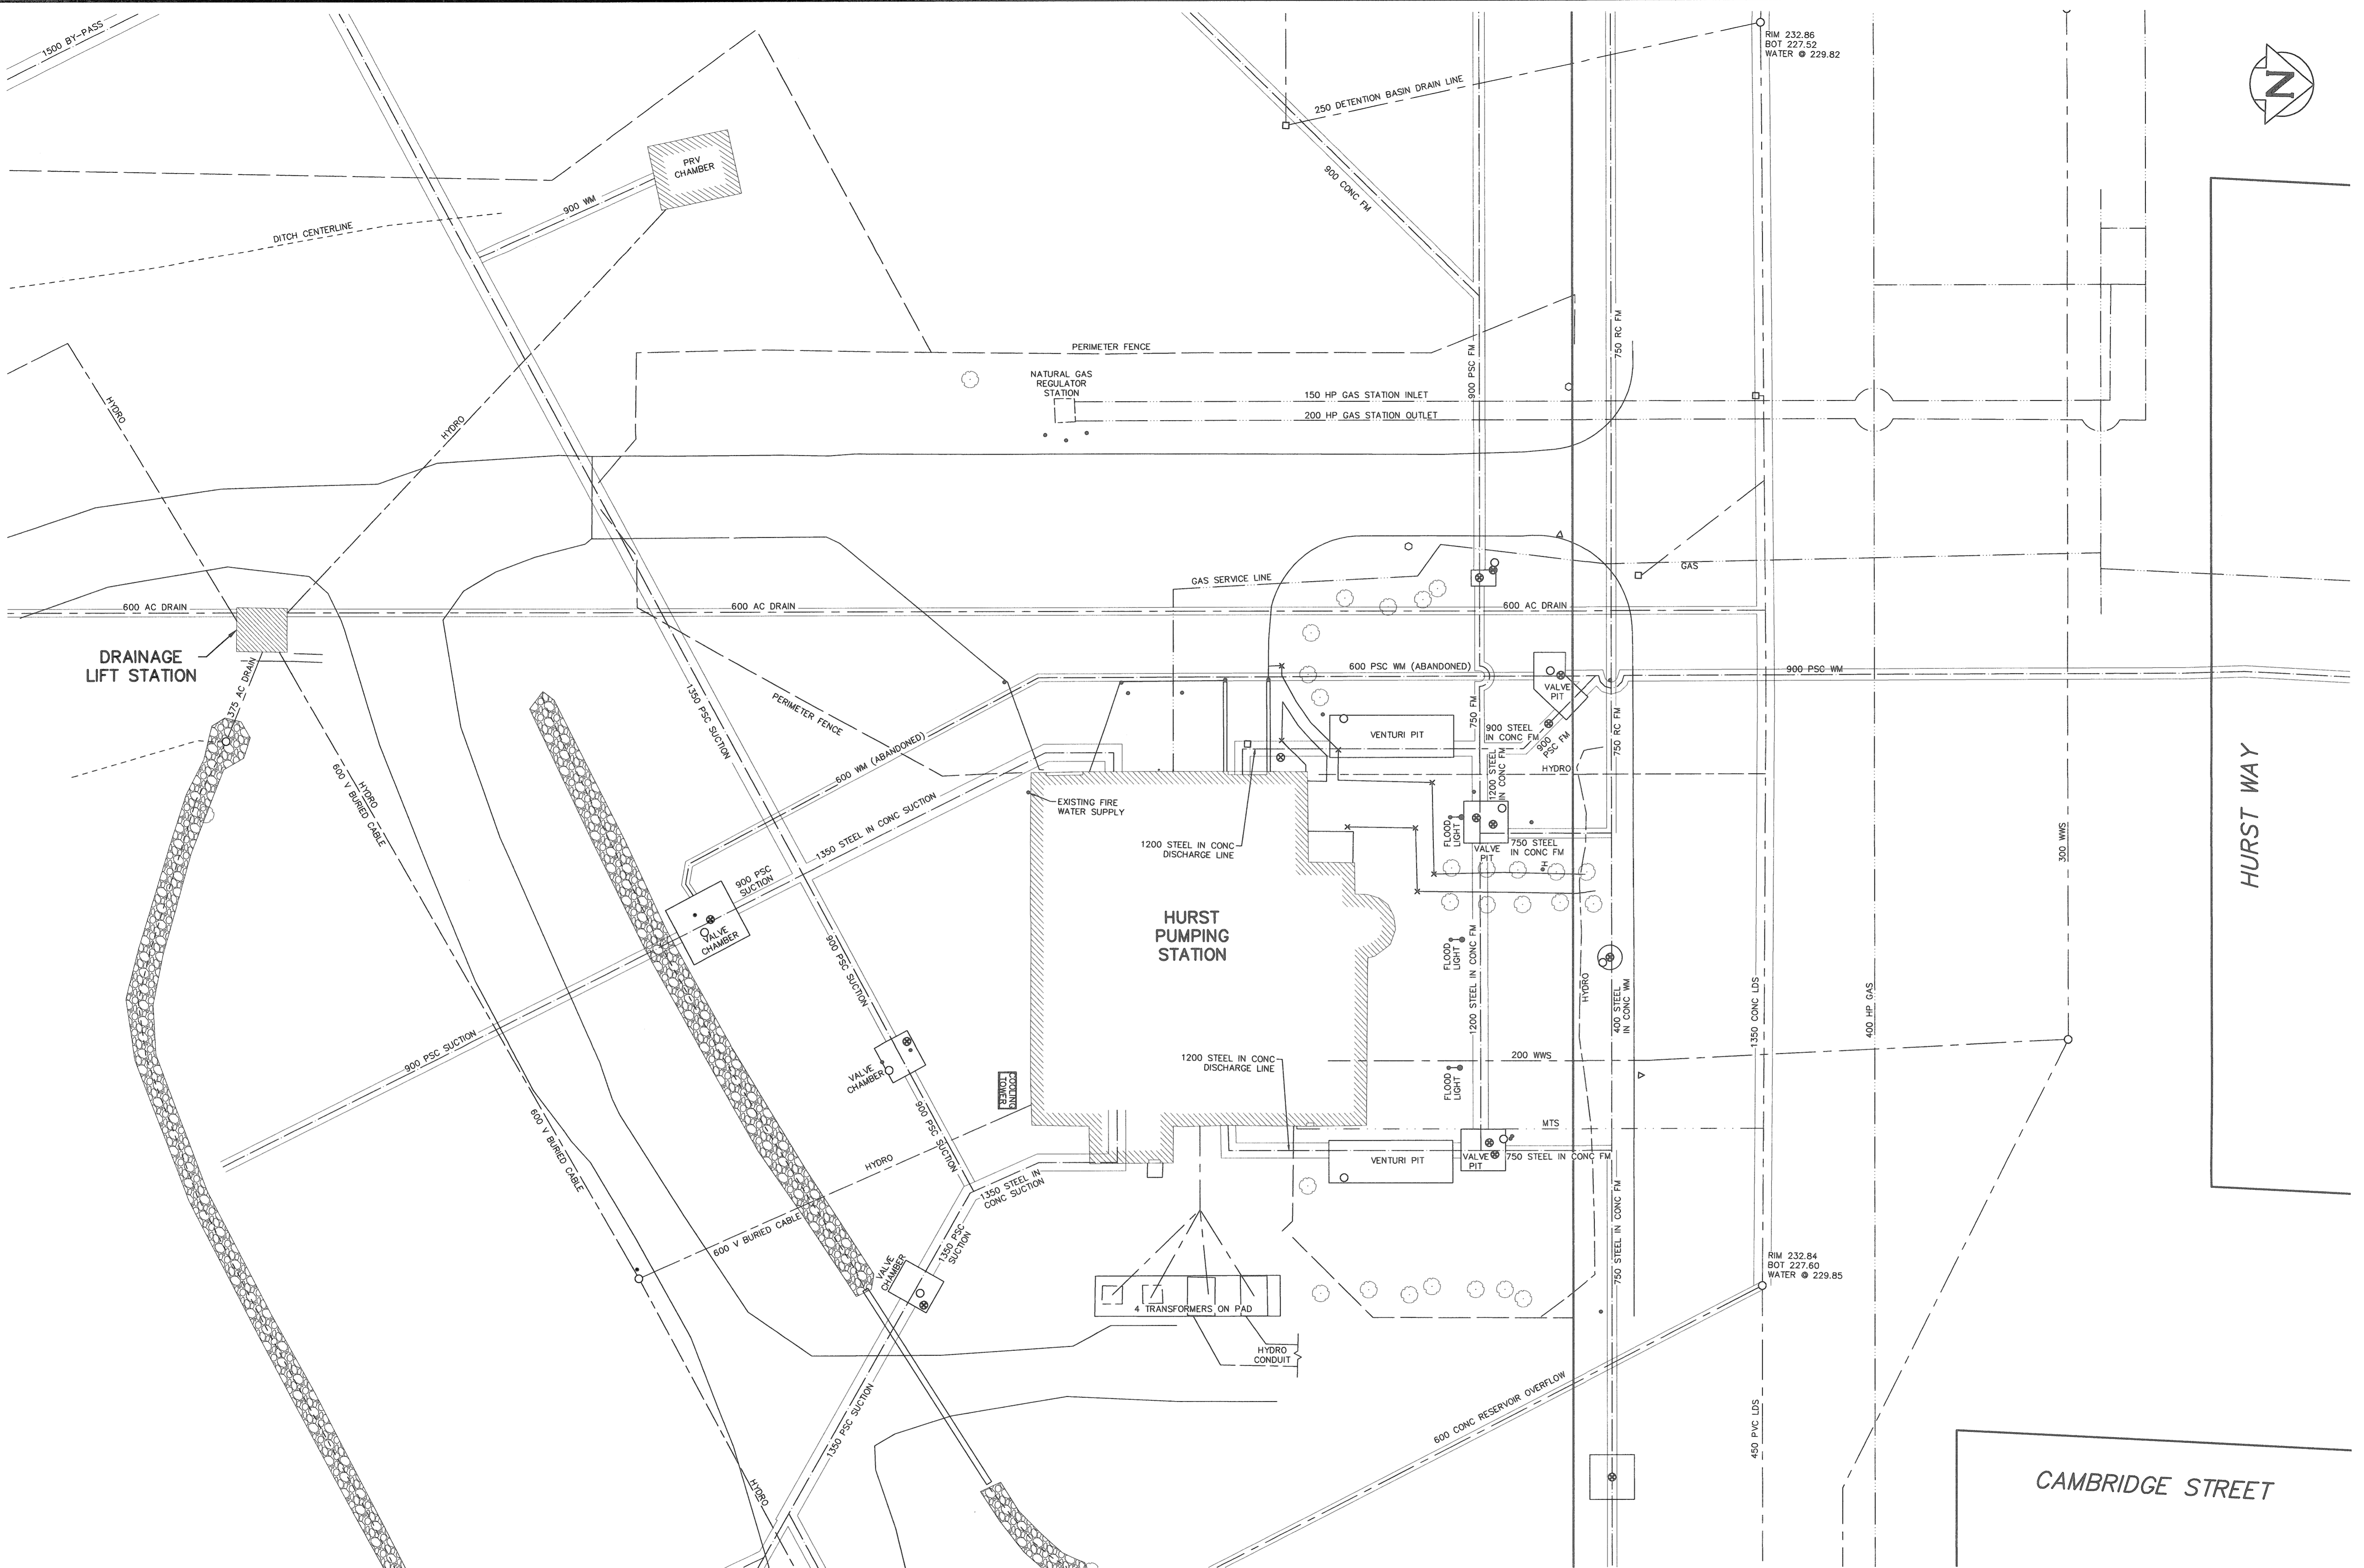

1-0650A-00001-001	COVER SHEET
DRAWING NUMBER	REFERENCE DRAWINGS

METRIC
WHOLE NUMBERS INDICATE MILLIMETRES
DECIMALIZED NUMBERS INDICATE METRES

NOTE: ALL VALVES INSTALLED
COUNTERCLOCKWISE TO CLOSE

**ENGINEERS
GEOSCIENTISTS
MANITOBA**

Certificate of Authorization
KGS Group
No. 245

NO.	REVISIONS	DATE	DESIGN CHECK
0	ISSUED FOR CONSTRUCTION	2020/06/18	AK RSO

KGS GROUP

DESIGNED BY: A. KIAYEE
DRAWN BY: G. LOEWEN
SCALE: 1:250
DATE: 2019/07/05
CONSULTANT NO.: 19-0107-005_C01

CHECKED BY: R. OFFMAN
APPROVED BY: R. OFFMAN
ISSUED FOR CONSTRUCTION
DATE:

ENGINEER'S SEAL

PROVINCE OF MANITOBA
REGISTERED PROFESSIONAL ENGINEER
K. KIAYEE
Member 43145, Reg. No. 22718

THE CITY OF WINNIPEG
Winnipeg
WATER AND WASTE DEPARTMENT

HURST PUMPING STATION
STRUCTURAL REPAIRS AND DRAINAGE BUILDING UPGRADES
MUNICIPAL
SITE PLAN

CITY DRAWING NUMBER: 1-0650A-C0001
SHEET: 001
REV: 0
SIZE: A1