

A1 SIZE - 594mm x 841mm
File Name: P:\Projects\2019\19-0107-005\Drawings\Struct\19-0107-005_001.dwg - Tab: D01 Plotted By: DDeroche 06/19/2020 [Fri 1:11pm]




THE CITY OF WINNIPEG

WATER AND WASTE DEPARTMENT

TENDER NO. 224 - 2020

Hurst Pumping Station

Structural Repairs and Drainage Building Upgrades

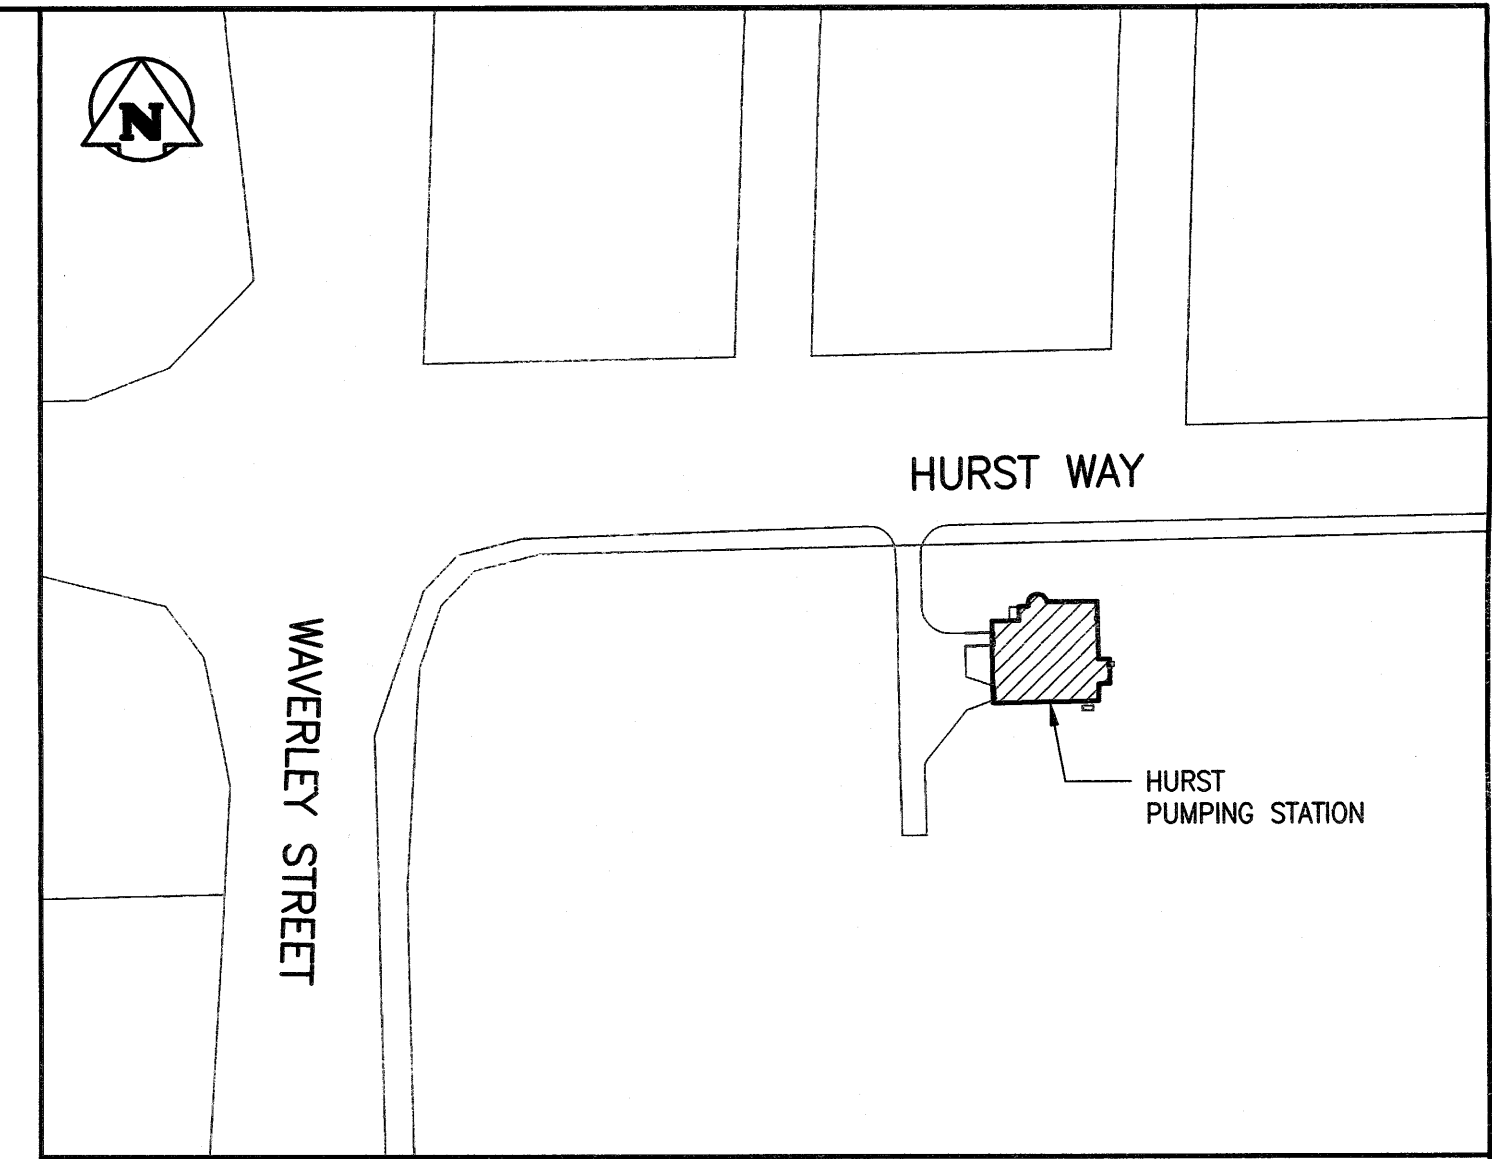

MUNICIPAL				ELECTRICAL				MECHANICAL			
City of Winnipeg DWG No.	KGS Group DWG No.	DESCRIPTION	REV.	City of Winnipeg DWG No.	KGS Group DWG No.	DESCRIPTION	REV.	City of Winnipeg DWG No.	KGS Group DWG No.	DESCRIPTION	REV.
1-0650A-D0001-001	D01	COVER SHEET		1-0650A-E0001-001	E01	LEGEND	0	1-0650M-M0001-001	M10	PUMP STATION PUMP FLOOR PLUMBING PLAN	0
1-0650A-C0001-001	C01	SITE PLAN	0	1-0650A-E0002-001	E08	NETWORK DIAGRAM	0	1-0650M-M0002-001	M11	PUMP STATION MEZZANINE PLUMBING PLAN	0
1-0650A-C0002-001	C02	GRADING PLAN	0	1-0650A-E0003-001	E12	PARTIAL SITE PLAN	0	1-0650M-M0003-002	M12	PUMP STATION ROOF PLUMBING PLAN - NEW	0
1-0650A-C0003-001	C03	SENSITIVE INFRASTRUCTURE PROTECTION PLAN	0	1-0650C-E0003-001	E09	PUMP STATION CP-C800 SCHEMATIC AND CONNECTION DIAGRAM	0	1-0650M-M0004-001	M13	PUMP STATION ROOF HVAC PLAN - DEMOLITION	0
1-0650M-S0001-001	S11	PUMP STATION CHLORINE ROOM EGRESS PARTIAL PLAN, SECTION AND DETAILS	0	1-0650C-E0004-001	E10	PUMP STATION MS-EFF-1 SCHEMATIC AND CONNECTION DIAGRAM	0	1-0650M-M0005-001	M14	PUMP STATION ROOF HVAC PLAN - NEW	0
1-0650M-S0001-001	S01	LEGENDS & GENERAL NOTES	0	1-0650M-E0003-001	E02	PUMP STATION SINGLE LINE DIAGRAM	0	1-0650M-M0006-001	M20	PUMP STATION DETAILS (1 OF 2)	0
1-0650M-S0002-001	S02	PUMP STATION ROOFING DEMOLITION PLAN AND SECTIONS	0	1-0650M-E0018-001	E13	SINGLE LINE DIAGRAM PNL-EE	0	1-0650M-M0006-002	M21	PUMP STATION DETAILS (2 OF 2)	0
1-0650M-S0003-001	S03	PUMP STATION ROOFING PLAN AND DETAILS	0	1-0650M-E0023-001	E04	PUMP STATION MAIN AND PUMP LEVEL POWER PLAN	0	1-0650Y-M0001-001	M01	DRAINAGE LIFT STATION EQUIPMENT AND PIPING PLAN, SECTION AND DETAILS	0
1-0650M-S0004-001	S04	PUMP STATION ROOFING SECTIONS AND DETAILS	0	1-0650M-E0024-001	E05	PUMP STATION ROOF POWER PLAN	0	1-0650Y-M0001-002	M03	DRAINAGE LIFT STATION EQUIPMENT AND PIPING PLAN, SECTION & DETAILS	0
1-0650M-S0005-001	S05	PUMP STATION CRAWLSPACE MODIFICATIONS PARTIAL PLAN AND SECTIONS	0	1-0650Y-E0001-001	E03	DRAINAGE LIFT STATION SINGLE LINE DIAGRAM	0	1-0650Y-M0002-001	M02	DRAINAGE LIFT STATION HVAC - PLAN, ELEVATIONS AND SECTION	0
1-0650M-S0006-001	S06	PUMP STATION CRAWLSPACE MODIFICATIONS SECTIONS AND DETAILS	0	1-0650Y-E0003-001	E06	DRAINAGE LIFT STATION POWER AND INSTRUMENT PLAN AND DETAILS	0				
1-0650M-S0007-001	S07	PUMP STATION CORK INSULATION ENCAPSULATION SECTIONS AND DETAILS	0	1-0650Y-E0004-001	E07	DRAINAGE LIFT STATION PANEL BOARD SCHEDULE	0				
1-0650M-S0008-001	S08	PUMP STATION ASBESTOS REMEDIATION REFLECTED CEILING PLAN AND DETAILS	0	1-0650Y-E0005-001	E11	DRAINAGE LIFT STATION CP-Y800 SCHEMATIC AND CONNECTION DIAGRAM	0				
1-0650M-S0009-001	S09	PUMP STATION EXTERIOR CLADDING REPAIRS SECTIONS	0								
1-0650M-S0010-001	S10	PUMP STATION EXTERIOR CLADDING REPAIRS SECTIONS AND DETAILS	0								
1-0650M-S0011-001	S12	PUMP STATION HANDRAIL REPLACEMENT PLAN, SECTION AND DETAILS	0								
1-0650Y-S0001-001	S13	DRAINAGE LIFT STATION PLAN, SECTION AND SCHEDULE	0								



THE CITY OF WINNIPEG
 WATER AND WASTE DEPARTMENT
HURST PUMPING STATION
 STRUCTURAL REPAIRS AND DRAINAGE BUILDING UPGRADES
 COVER SHEET