




A1 SIZE - 594mm x 841mm

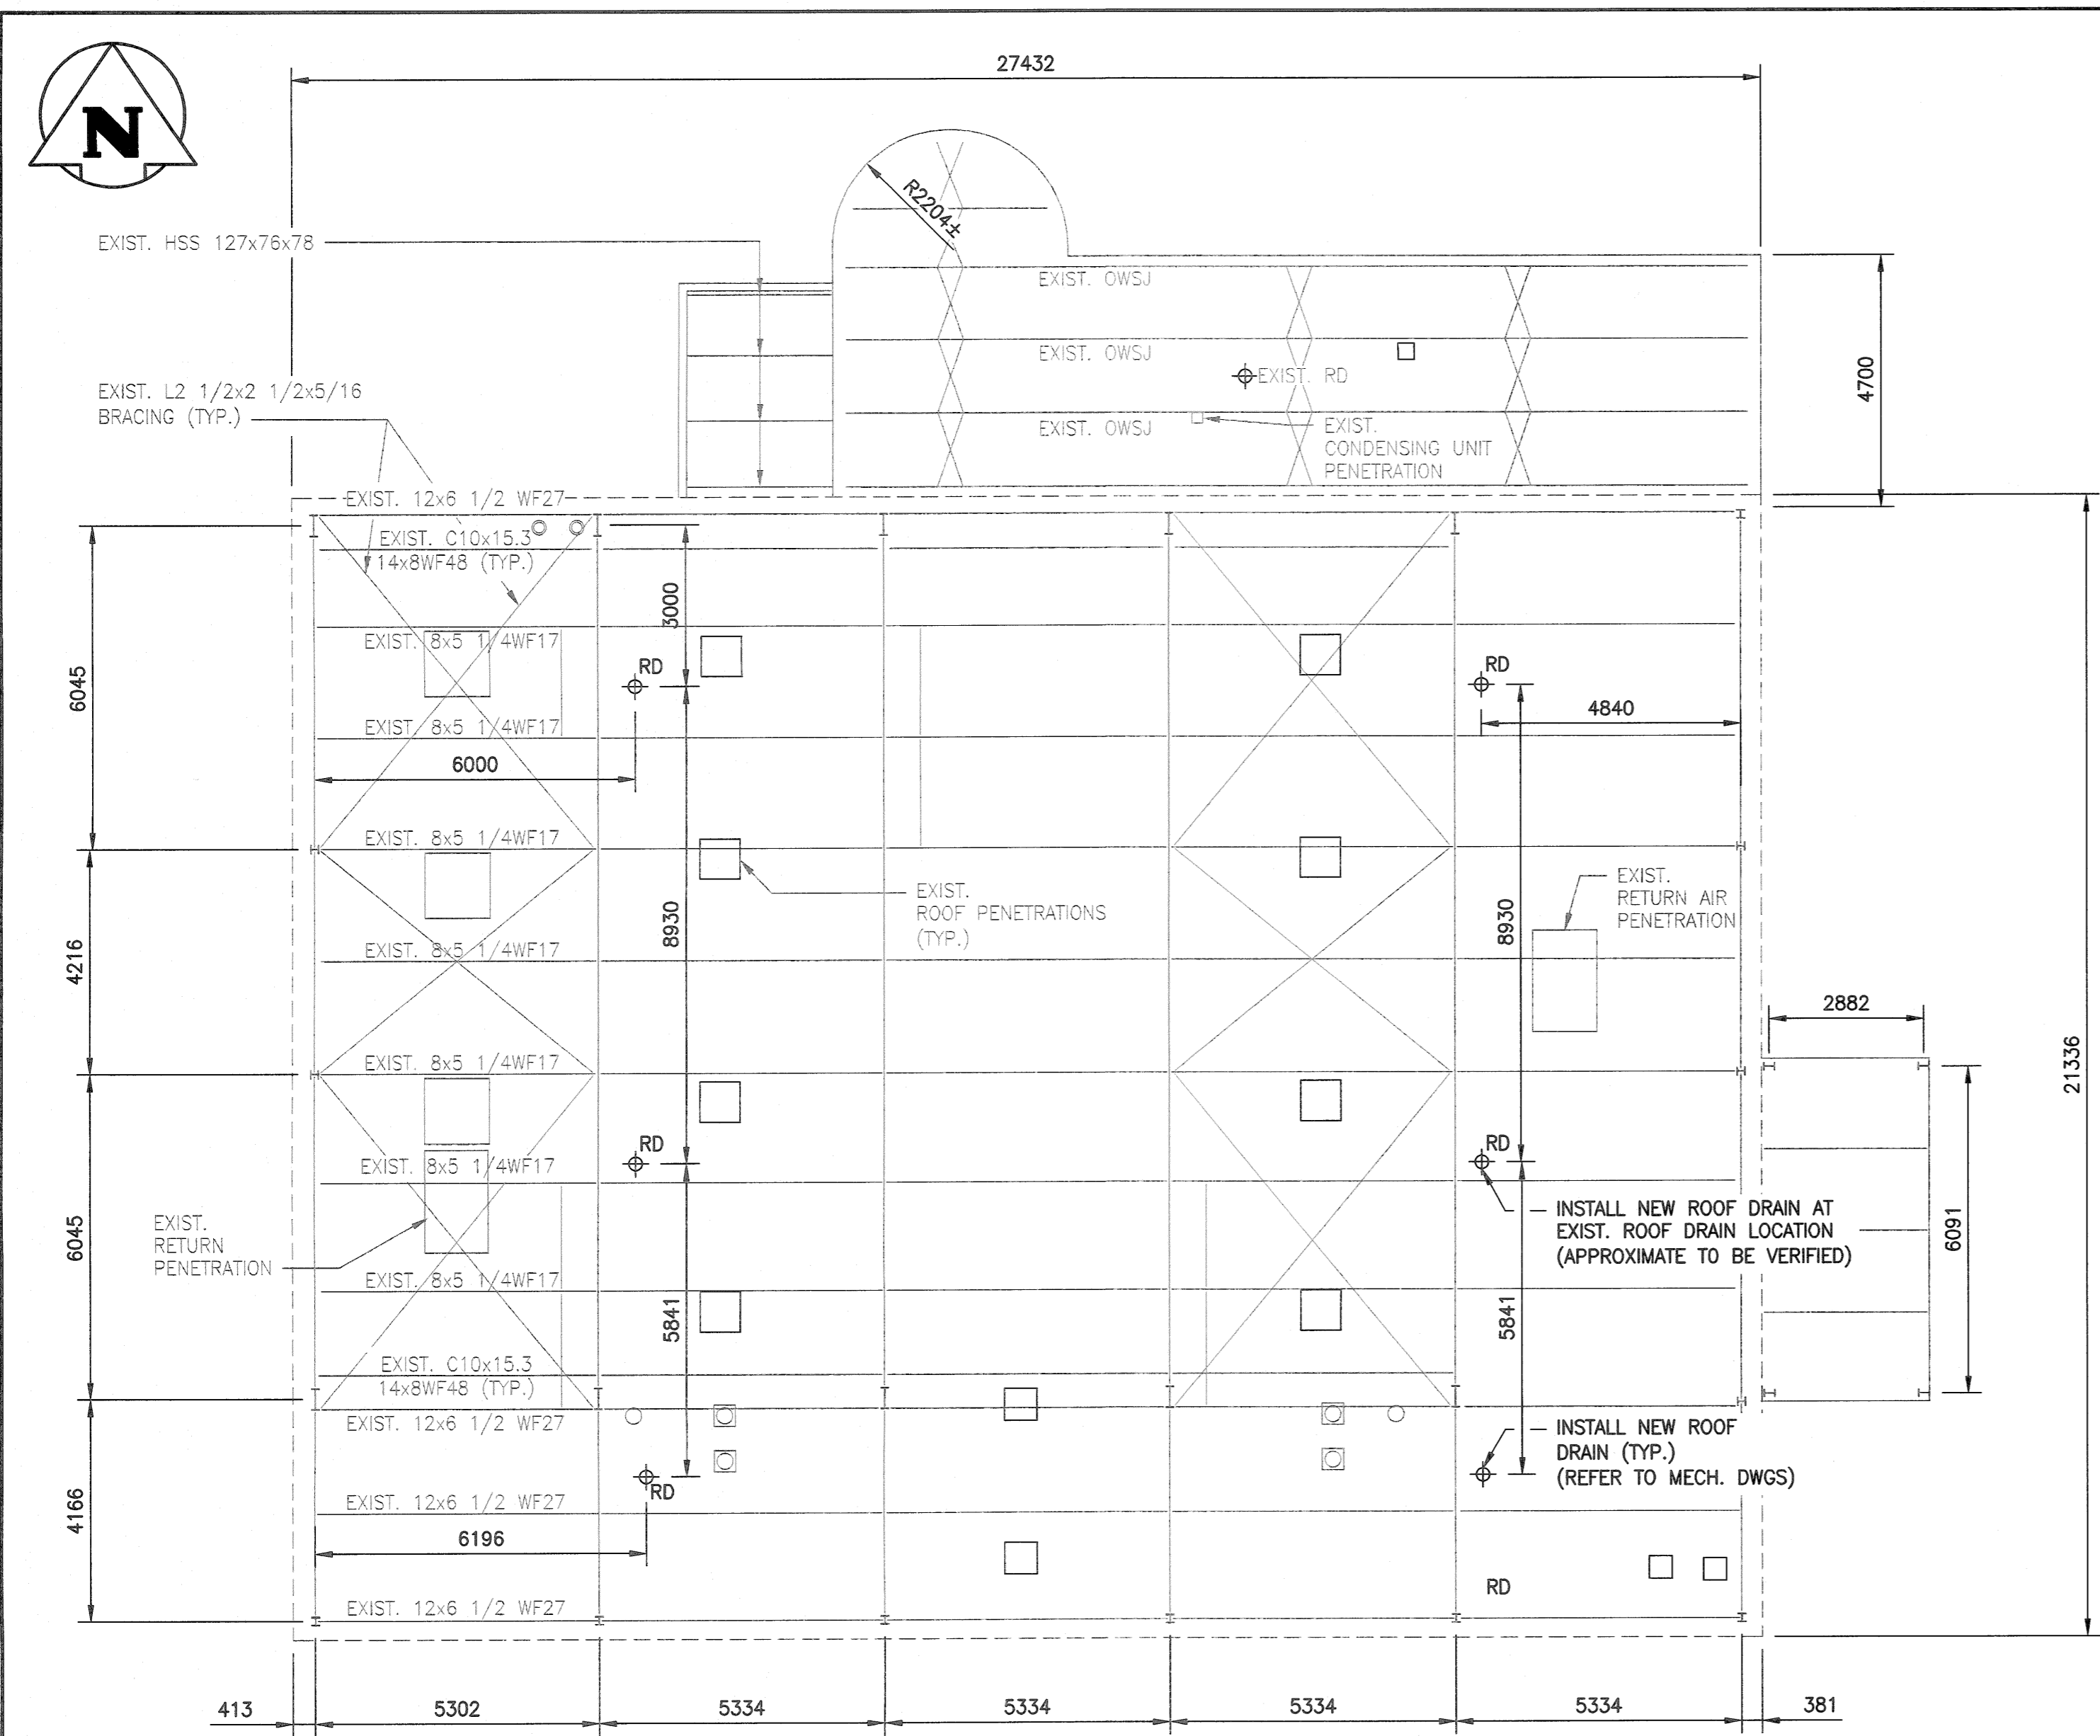


ROOF FRAMING PLAN
SCALE: 1:100

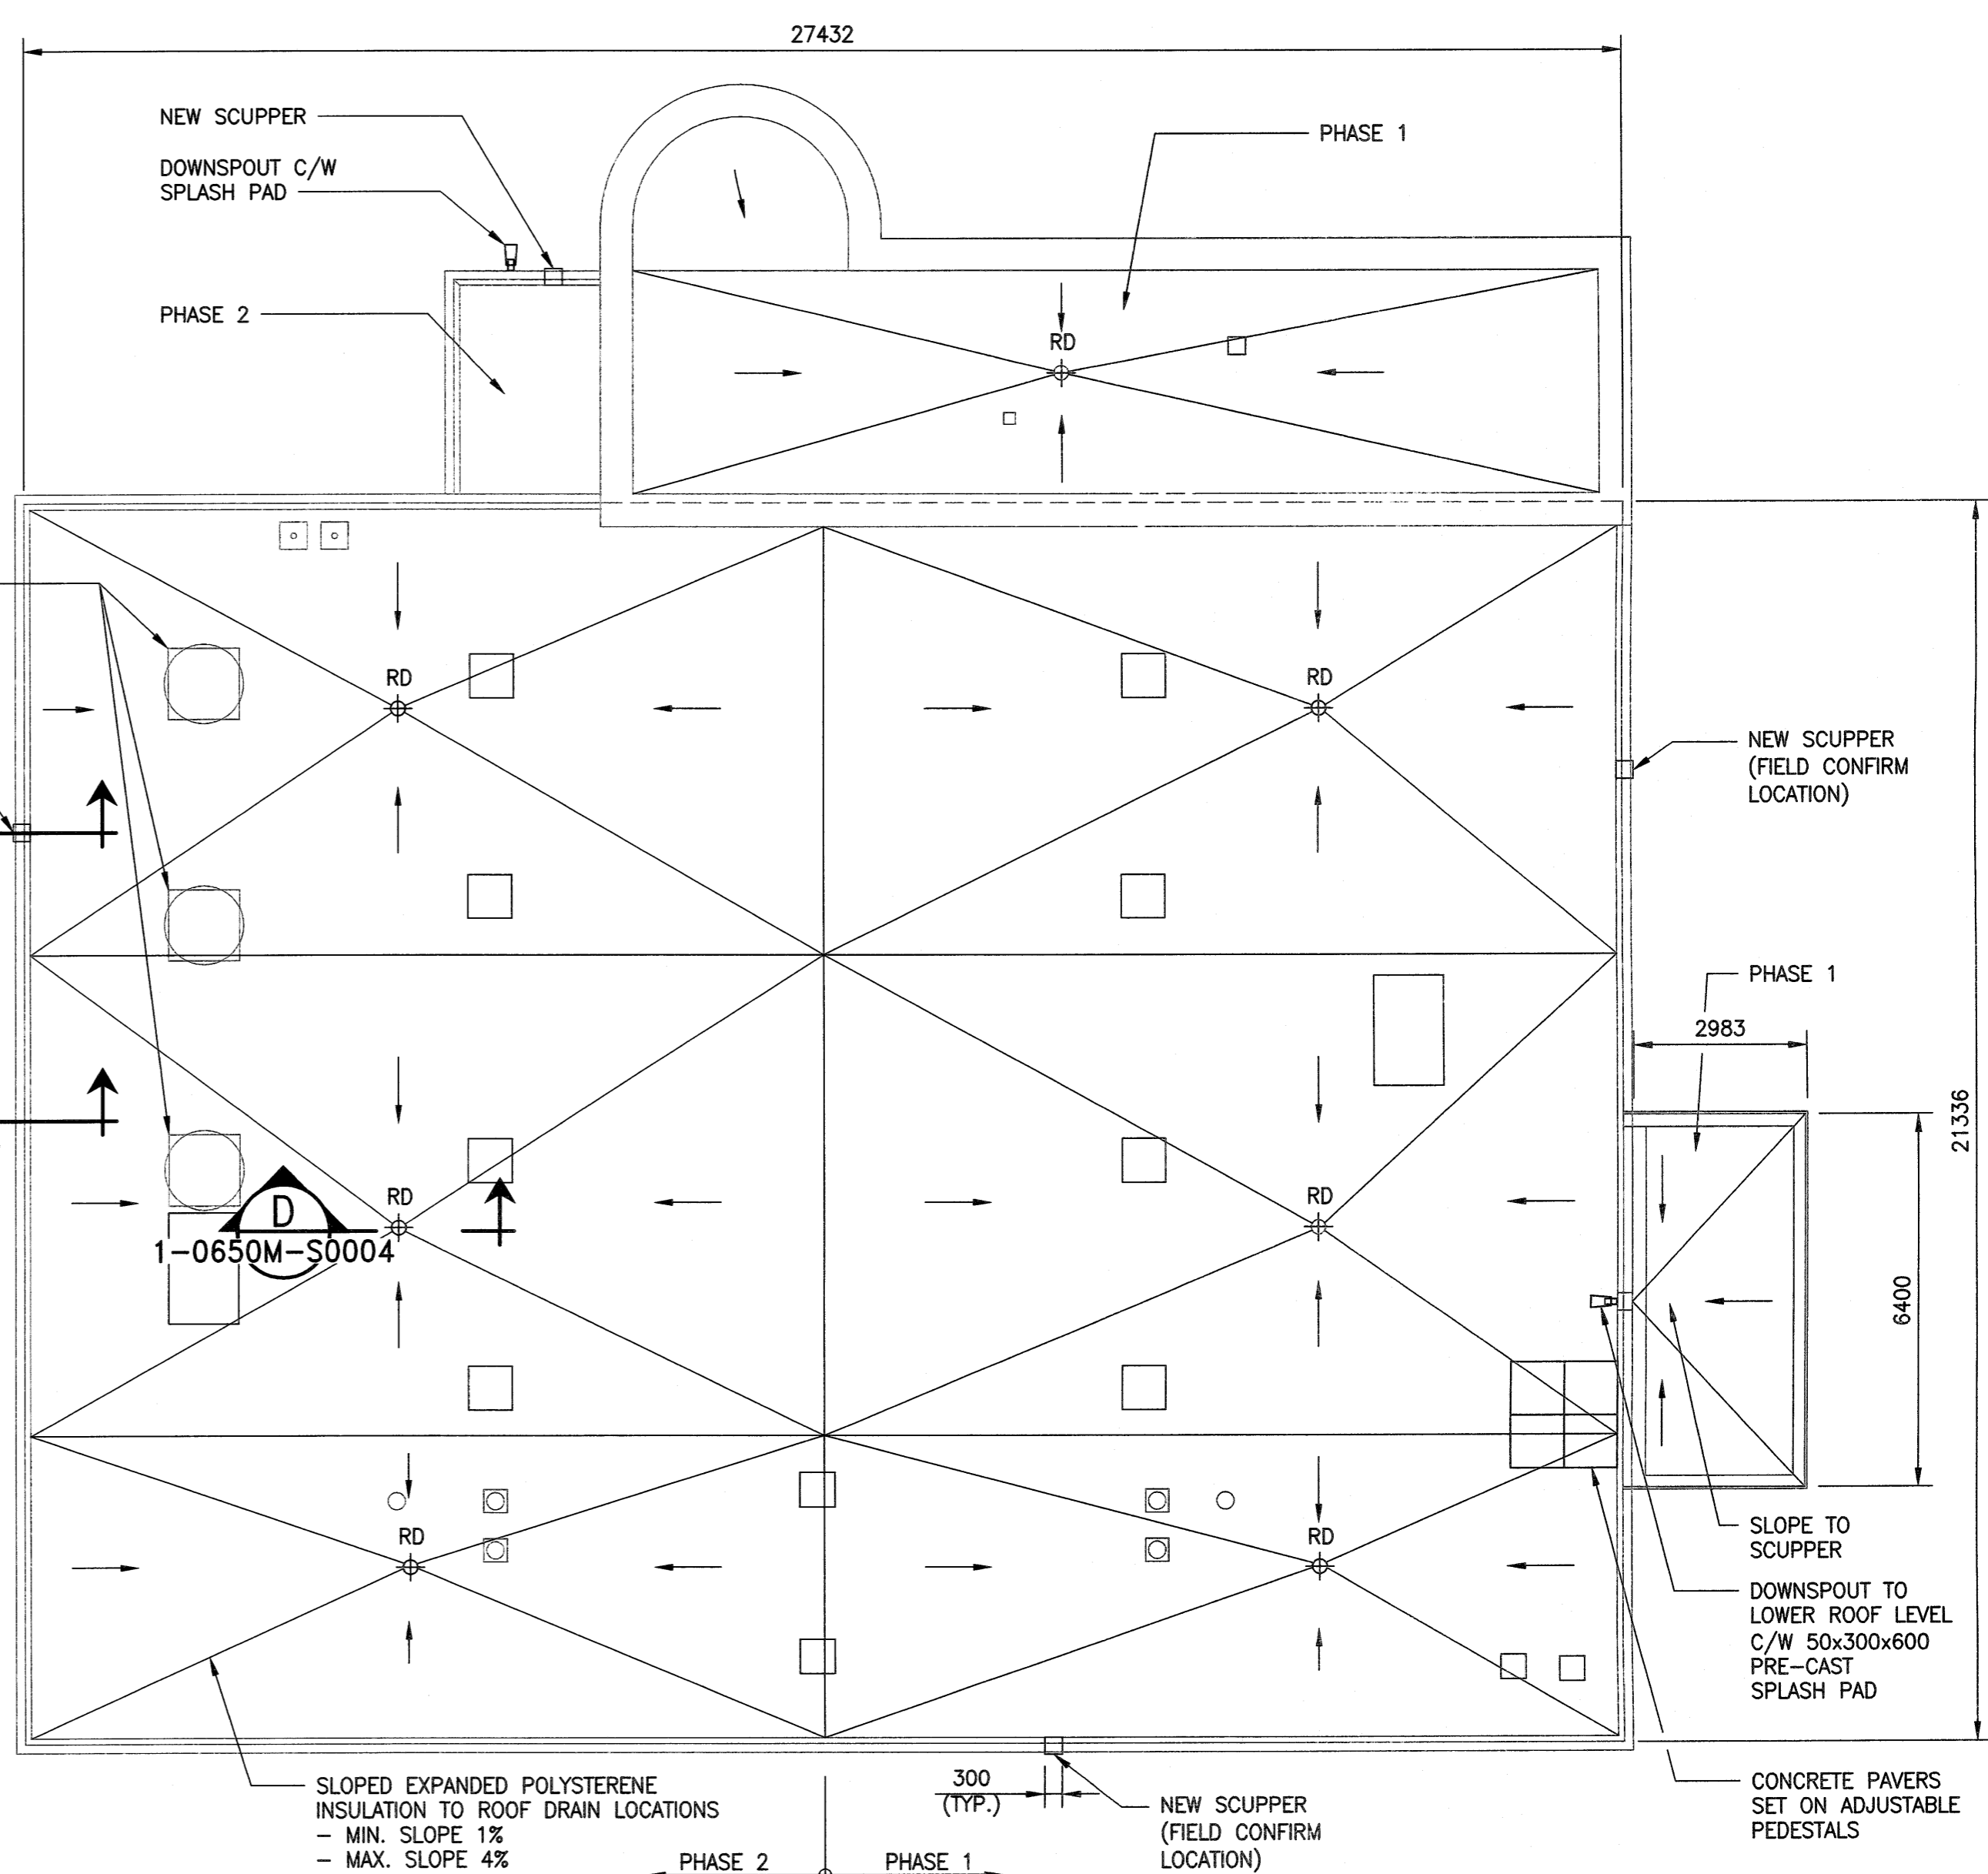

ROOF PLAN
SCALE: 1:100

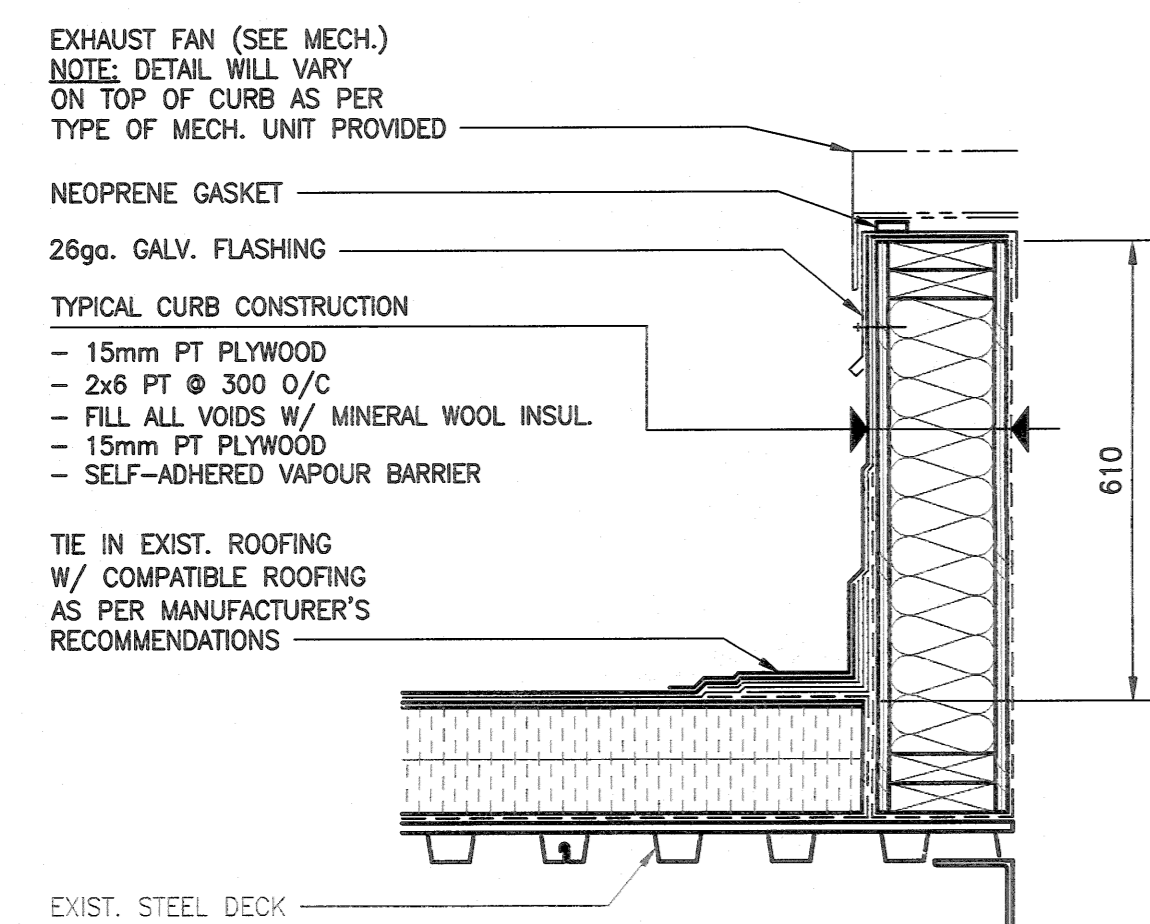

DETAIL - TYPICAL FAN CURB
SCALE: 1:10

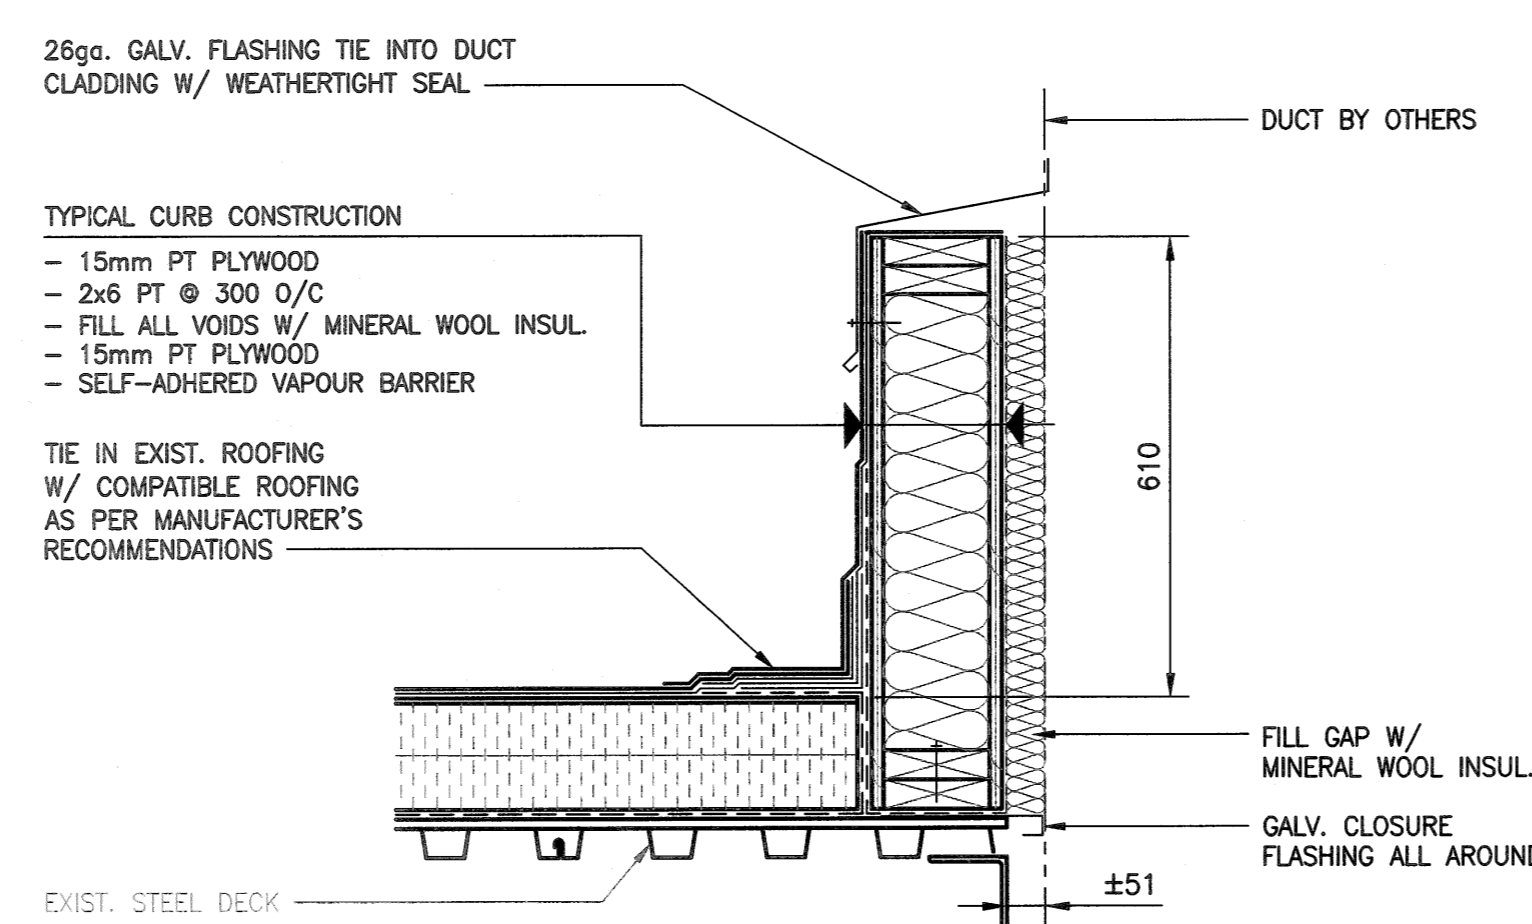

DETAIL - TYPICAL DUCT PENETRATION
SCALE: 1:10

NOTES:
- ROOFING TO BE COMPLETED
IN 2 SEPARATE PHASES

LEGEND:
RD - ROOF DRAIN (NEW)
HSS - HOLLOW STRUCTURAL SECTION
WF - WIDE FLANGE BEAM
OWSJ - OPEN WEB STEEL JOIST
L - STRUCTURAL ANGLE

METRIC

WHOLE NUMBERS INDICATE MILLIMETRES
DECIMALIZED NUMBERS INDICATE METRES

10		
9		
8		
7		
6		
5		
4		
3		
2	1-0650A-D0001-001	COVER SHEET
1	1-0650M-S0004-001	STRUCTURAL - ROOFING - SECTION AND DETAILS
NO. DRAWING NUMBER REFERENCE DRAWING TITLE		



B.M. -					
ELEV. -					
KGS GROUP					
DESIGNED BY:	L. MILIUS-ALPHONSE	CHECKED BY:	C. SIEPMAN		
DRAWN BY:	F. VALENCIA	APPROVED BY:	C. SIEPMAN		
SCALE:	AS NOTED	ISSUED FOR CONSTRUCTION			
DATE:	2019/04/30	DATE:			
ISSUED FOR CONSTRUCTION			2020/06/18	LMA	CMS
NO. REVISIONS		DATE		DESIGN	CHECK
			CONSULTANT NO.:	19-0107-005_S03	



THE CITY OF WINNIPEG Water and Waste Department							
HURST PUMPING STATION STRUCTURAL REPAIRS AND DRAINAGE BUILDING UPGRADES PUMP STATION ROOFING PLAN AND DETAILS							
CITY DRAWING NUMBER	1-0650M-S0003	SHEET	001	REV.	0	SIZE	A1