


PLAN VIEW - HURST DRAINAGE LIFT STATION

SCALE: 1:20

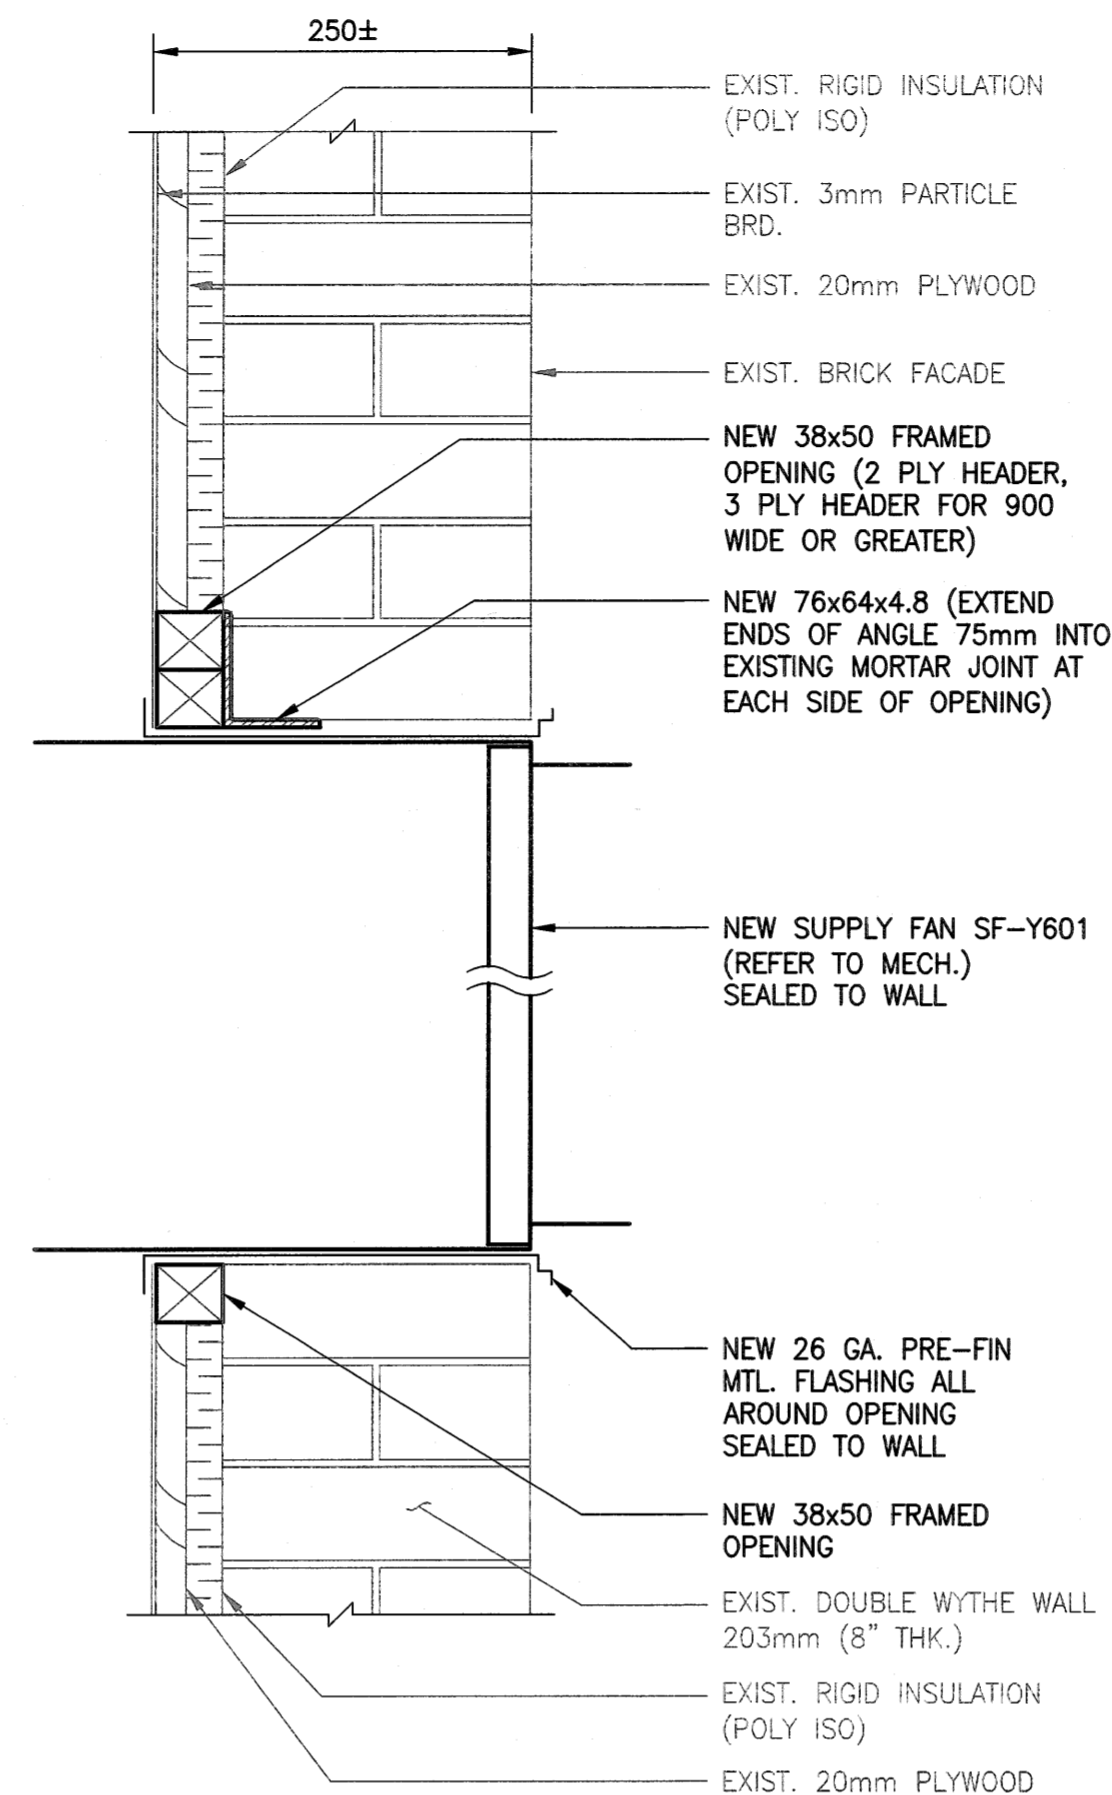

NEW WALL OPENING

SCALE: 1:5


GENERAL NOTES:

1. PERFORM WORK IN ACCORDANCE WITH ALL APPLICABLE CODES AND REGULATIONS.
2. REVIEW EQUIPMENT LOCATIONS WITH THE CONTRACT ADMINISTRATOR PRIOR TO INSTALLATION.
3. EQUIPMENT LOCATIONS INDICATED ON THE DRAWINGS IS APPROXIMATE ONLY. CONFIRM IN THE FIELD CHANGES WITH CONTRACT ADMINISTRATOR. **COORDINATE WORK WITH ALL SUBTRADES**.
4. WHERE DIMENSIONS ARE INDICATED, THESE ARE FOR BIDDING PURPOSES ONLY. THE CONTRACTOR SHALL VERIFY ALL DIMENSIONS IN THE FIELD PRIOR TO COMMENCING INSTALLATION WITHOUT EXTRA CHARGES TO THE PROJECT.
5. SEAL ALL NEW WALL PENETRATIONS WATER AND AIR TIGHT.

LEGEND:

- — EXISTING EQUIPMENT
- — NEW EQUIPMENT AND DUCTWORK

DOOR SCHEDULE								HARDWARE												
DOOR NO.	DOOR			FRAME			FIRE RATING (HOURS)	HINGES	PASSAGE SET	CLOSER	DOOR STOP	KICKPLATE	LOCK SET	CHECK CHAIN	WEATHER STRIPPING	THRESHOLD	SECURITY GUARD PLATE	DOOR HASP	PAD LOCK WITH KEY (MEDECO, ASSA ABLOY)	
	SIZE	TYPE	MATERIAL	CORE	MATERIAL	FINISH														
D102	TO SUIT EXISTING DOOR SIZE (760 X 2210 X 44 CONTRACTOR TO CONFIRM)	SLAB	HOLLOW METAL	INSUL	STEEL	PAINTED (GREY)	3/4	•	•	•	•	•	•	•	•	•	•	•	•	•

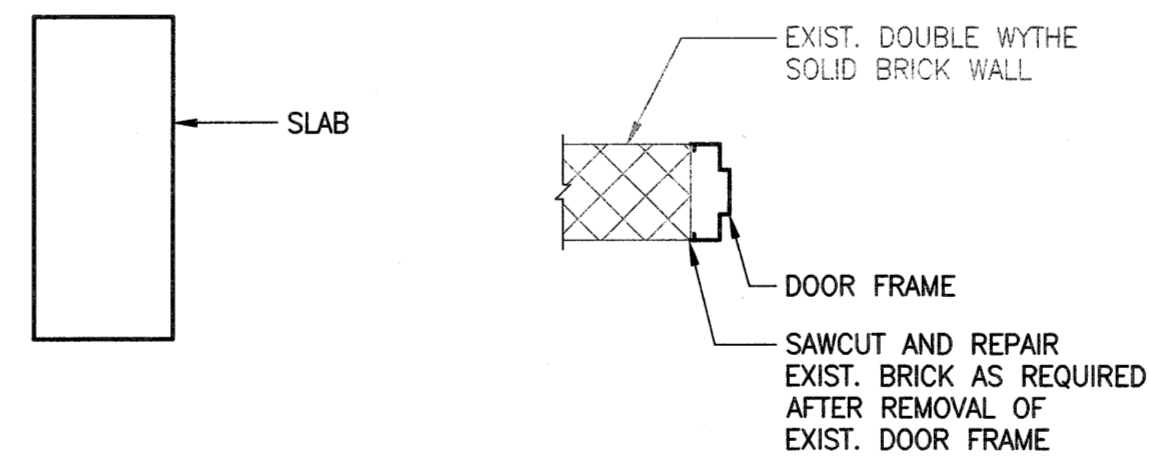

DETAIL - DOOR/JAMB

METRIC


WHOLE NUMBERS INDICATE MILLIMETRES
DECIMALIZED NUMBERS INDICATE METRES

10		
9		
8		
7		
6		
5		
4		
3		
2		
1	1-0650A-D0001-001	COVER SHEET
NO.	DRAWING NUMBER	REFERENCE DRAWING TITLE
REFERENCE DRAWINGS		



B.M. —			
ELEV. —			
KGS GROUP			
DESIGNED BY:	L. MILIUS-ALPHONSE	CHECKED BY:	C. SIEPMAN
DRAWN BY:	F. VALENCIA	APPROVED BY:	C. SIEPMAN
SCALE:	AS NOTED	ISSUED FOR CONSTRUCTION BY:	
DATE:	2020/04/31	DATE:	
0	ISSUED FOR CONSTRUCTION	2020/06/18	LA CAS
NO. REVISIONS	DATE	DESIGN	CHECK

KGS GROUP	
DESIGNED BY:	L. MILIUS-ALPHONSE
CHECKED BY:	C. SIEPMAN
DRAWN BY:	F. VALENCIA
APPROVED BY:	C. SIEPMAN
SCALE:	AS NOTED
ISSUED FOR CONSTRUCTION BY:	
DATE:	2020/04/31
DATE:	
CONSULTANT NO.:	19-0107-005_S13

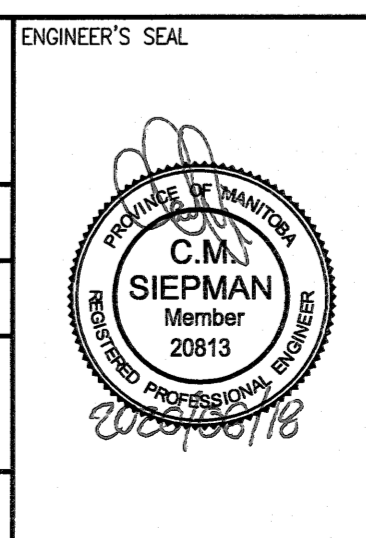

THE CITY OF WINNIPEG WATER AND WASTE DEPARTMENT	
HURST PUMPING STATION STRUCTURAL REPAIRS AND DRAINAGE BUILDING UPGRADES STRUCTURAL DRAINAGE LIFT STATION PLAN, SECTIONS AND SCHEDULE	
CITY DRAWING NUMBER	1-0650Y-S0001
SHEET	001
REV.	0
SIZE	A1