




1 CENTRIFUGAL ROOF EXHAUST FAN (MECHANICAL)
SCALE: N.T.S.

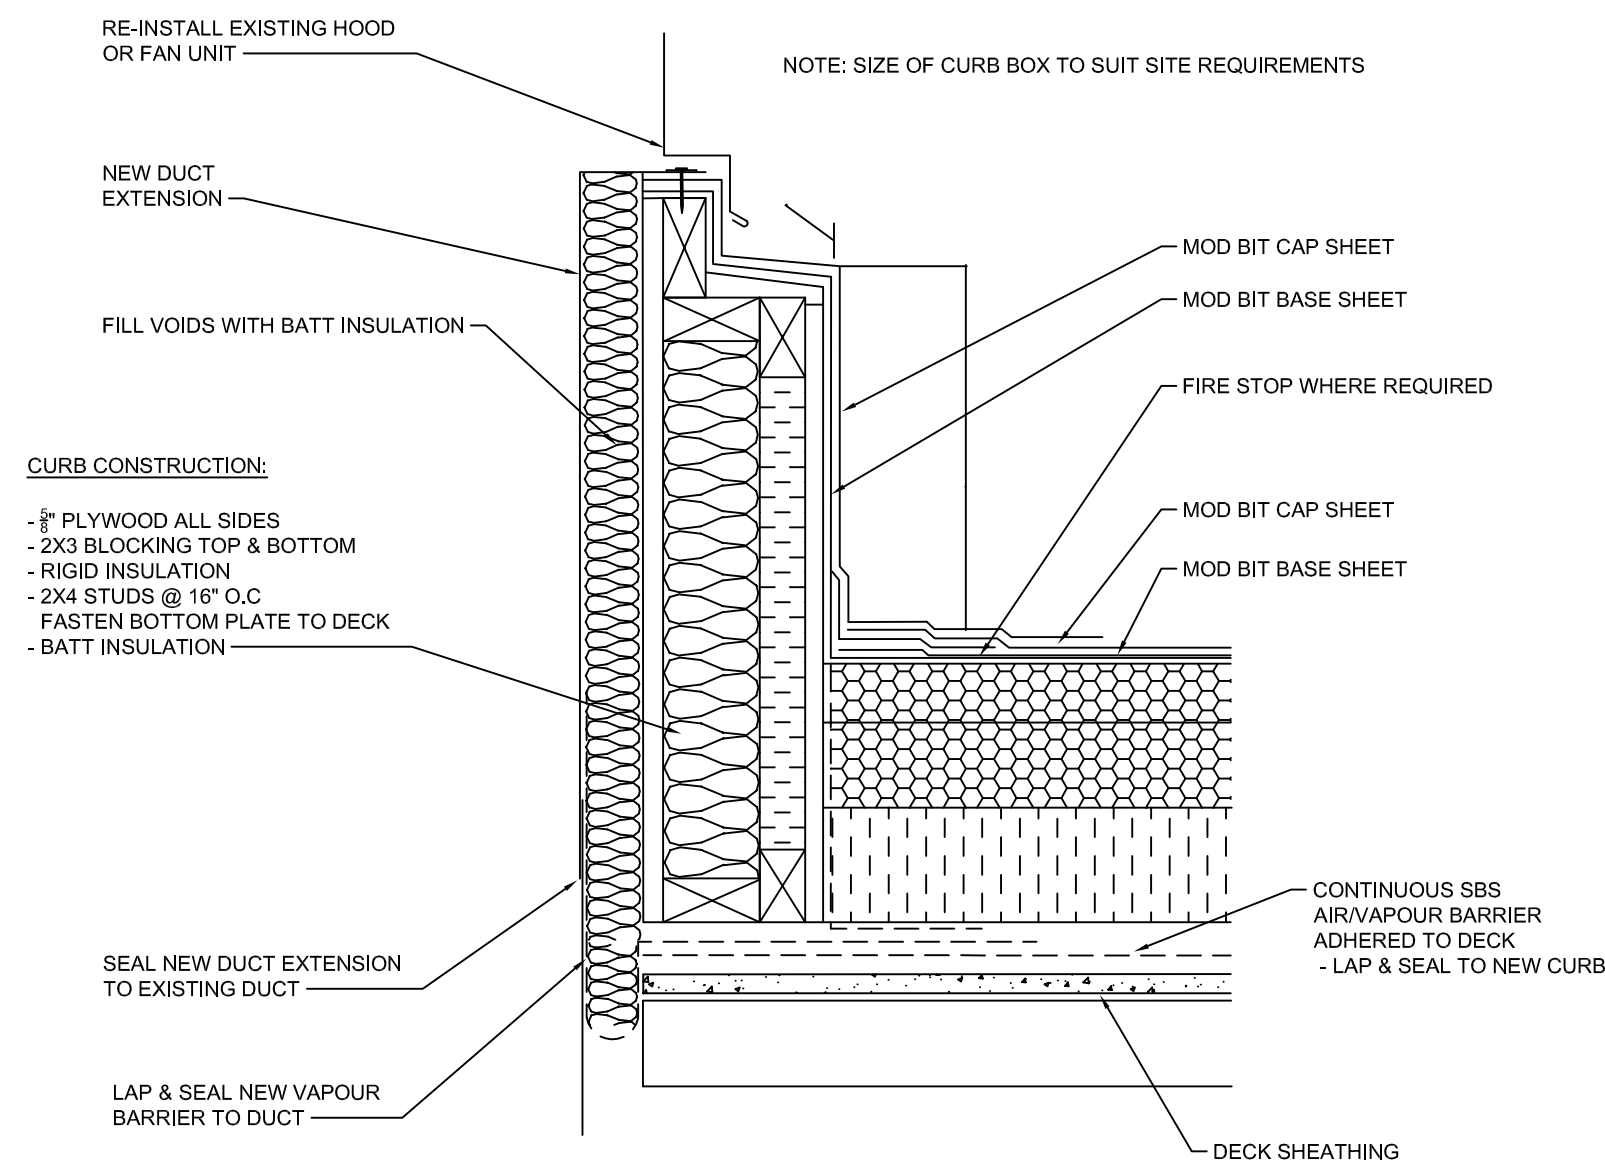


4 ROOF CURB @ EXHAUST DUCT DETAIL (MECHANICAL)
SCALE: N.T.S.

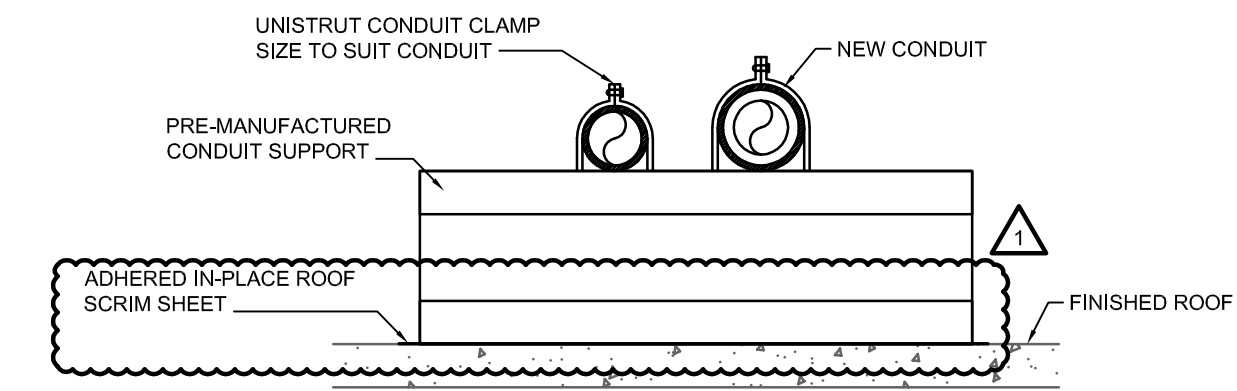


7 TYPICAL ROOF CONDUIT SUPPORT DETAIL (ELECTRICAL)
SCALE: N.T.S.

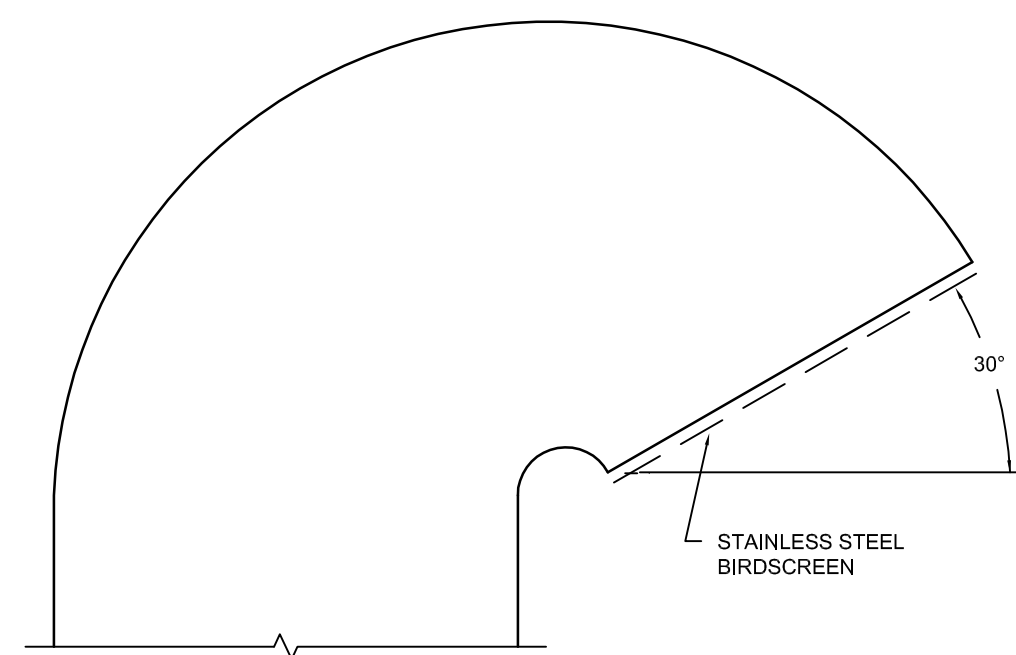


2 OUTLET GOOSENECK (MECHANICAL)
SCALE: N.T.S.

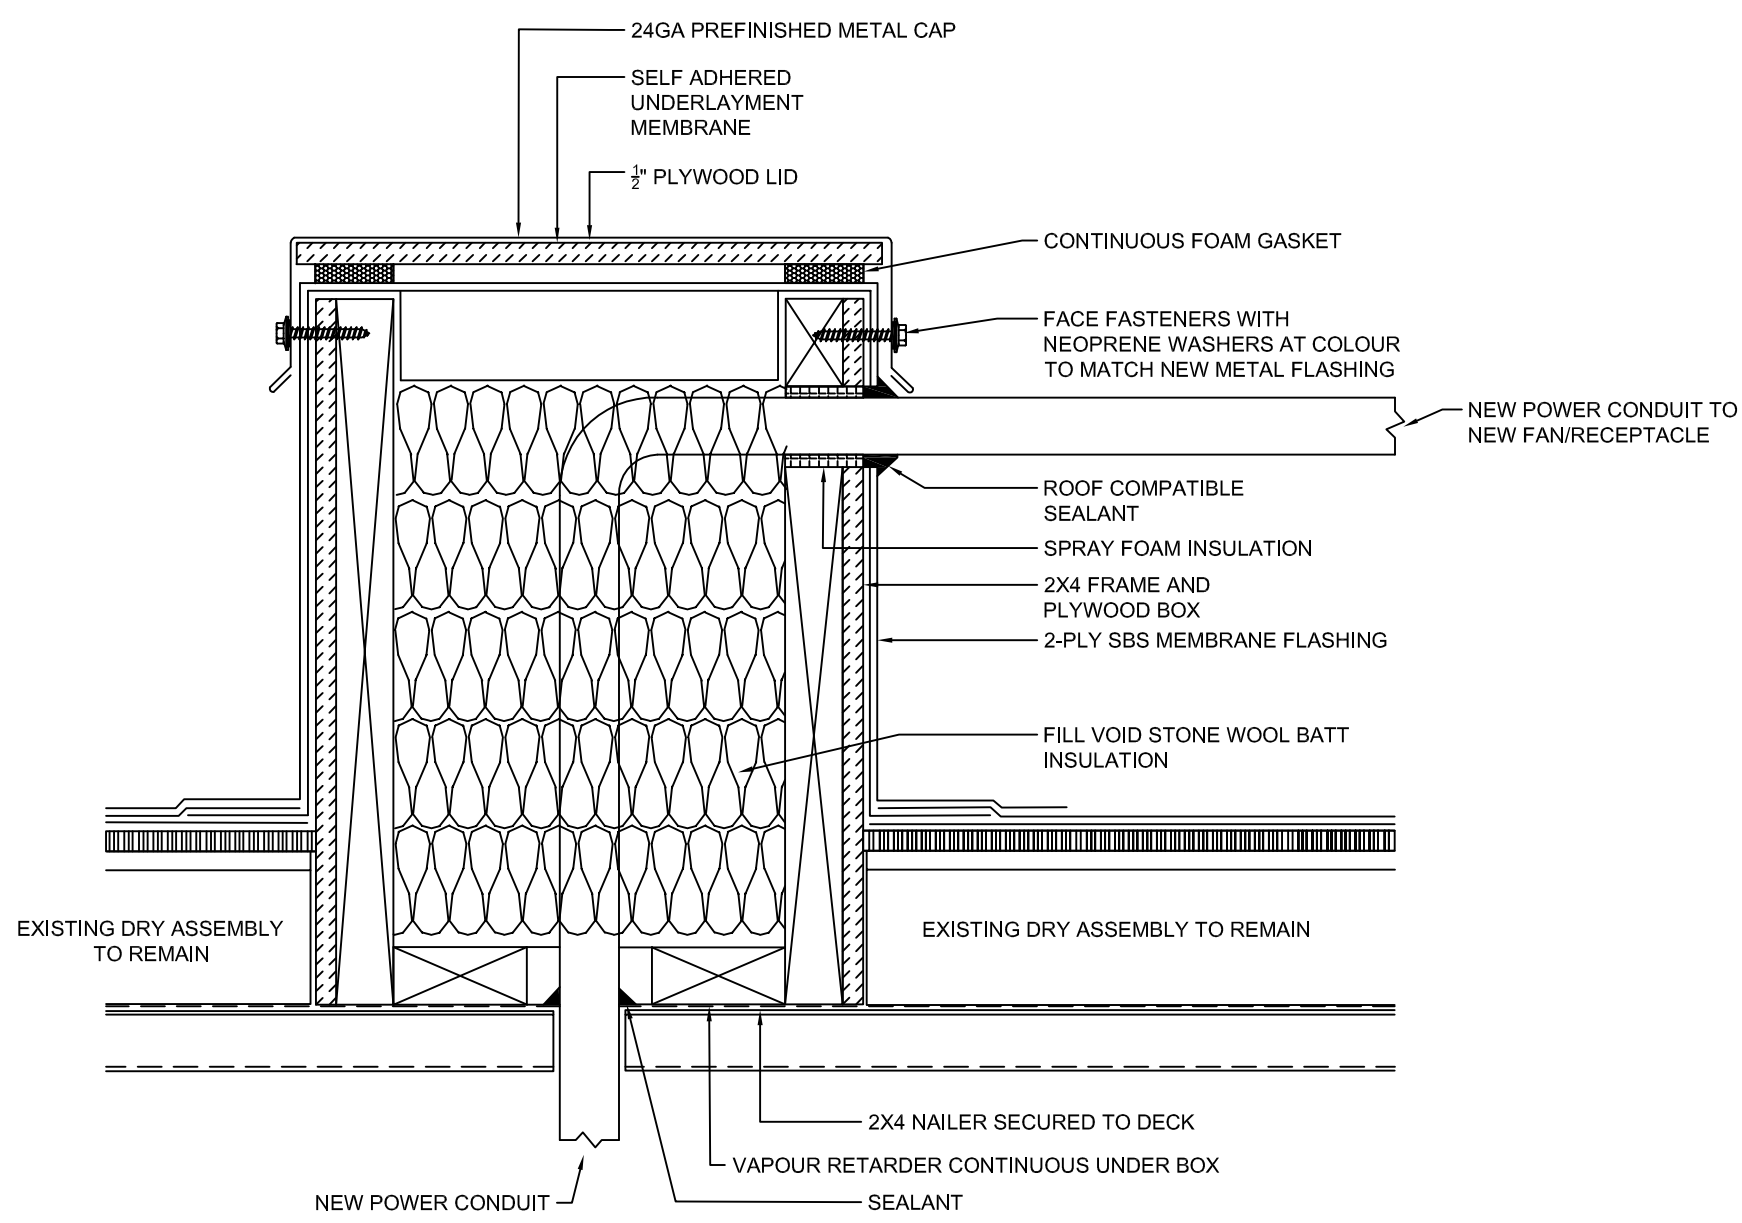

5 CONDUIT BOX DETAIL (ELECTRICAL)
SCALE: N.T.S.

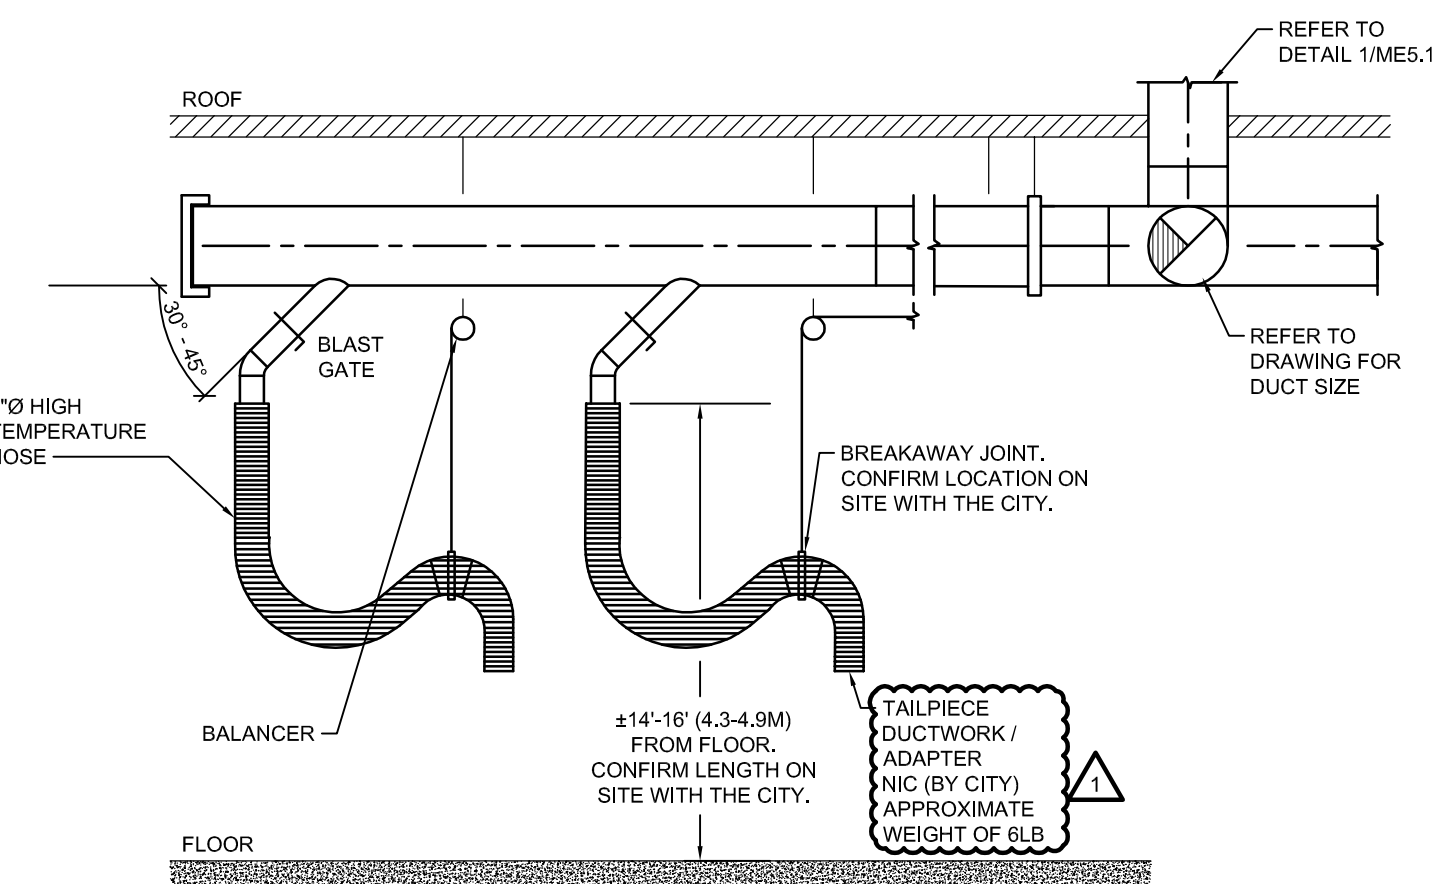

3 ABOVE FLOOR EXHAUST (MECHANICAL)
SCALE: N.T.S.

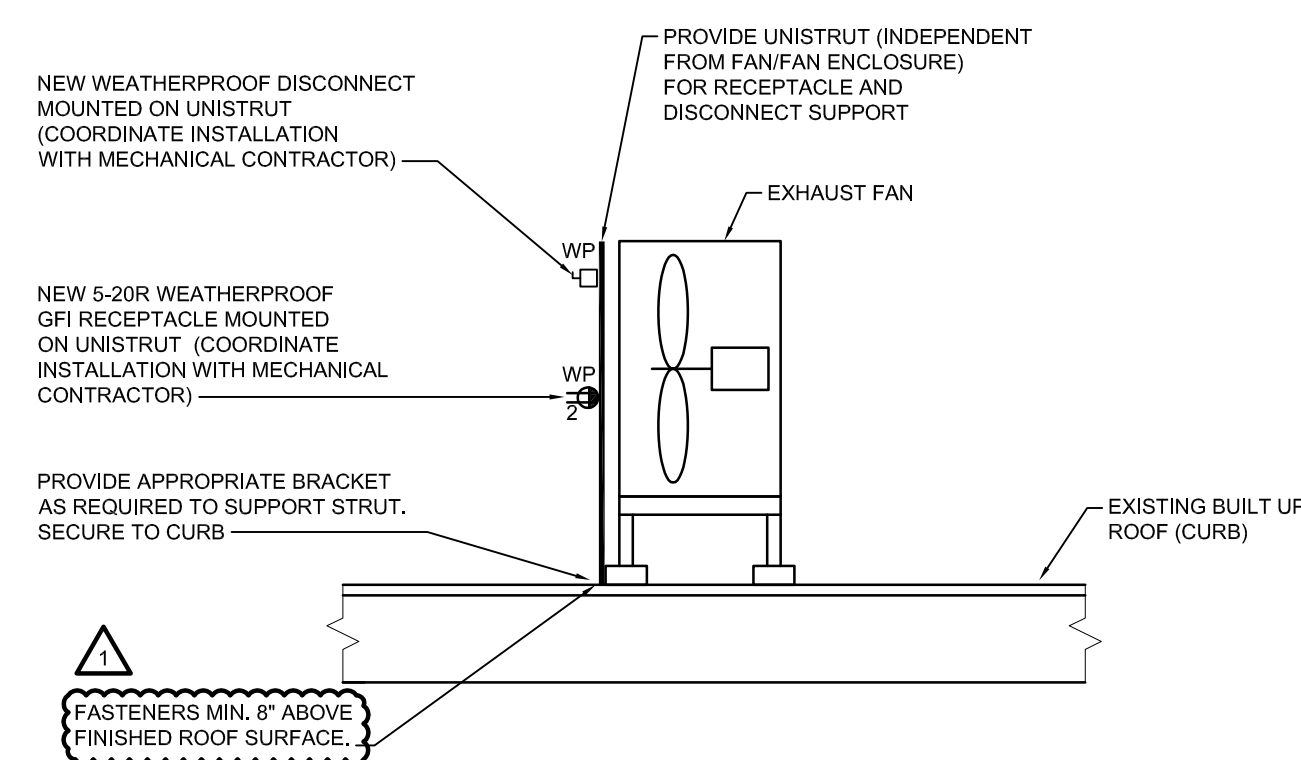

6 TYPICAL ROOF RECEPTACLE AND DISCONNECT MOUNTING DETAIL (ELECTRICAL)
SCALE: N.T.S.

NO.	Description	BY	DDMMYY
1	ISSUED FOR ADDENDUM 2	JH	30/07/21
0	ISSUED FOR CONSTRUCTION	JH/AS	09/07/21

ORIGINAL CONTRACT DRAWING SIGNED AND SEALED BY J.T. HORROCKS, P. ENG JULY 09, 2021

ORIGINAL CONTRACT DRAWING SIGNED AND SEALED BY A.J. SCHINKEL, P. ENG JULY 09, 2021

770 Bradford Street
Winnipeg, Canada
T 204 775 0291
SMSeng.com

SMS ENGINEERING

Winnipeg Transit

Project Title
TRANSIT HOIST 10-18 VEHICLE EXHAUST

WINNIPEG MANITOBA

Drawing Title
MECHANICAL AND ELECTRICAL DETAILS

Drawn By LP/WPD	Checked By XZ/CRM	Approved By JH/AS
Scale AS NOTED	Date JULY 2021	Project No. 21-083-01
Revision Number 1	Drawing Number ME5.1	Sheet Order 5 OF 5

ENGINEERS GEOSCIENTISTS MANITOBA
Certificate of Authorization
SMS Engineering Ltd.
No. 166

FILE NAME AND PATH: G:\PROJECTS\2021\081 Transit Hoist 10-18 Vehicle Exhausts\03-Curb_Box\ME5.1.dwg
LAST SAVED BY: JH
DATE PLOTTED: 2021-07-14 10:53:19 AM