



202102REV1.dwg FILE NAME: DATE: 2021.10.12 PROJECT No: 2020-126 SHEET TITLE: ELEC.-SITE AND MAIN FLOOR PLANS ADDRESS: 10 ALLAN BLYE DRIVE

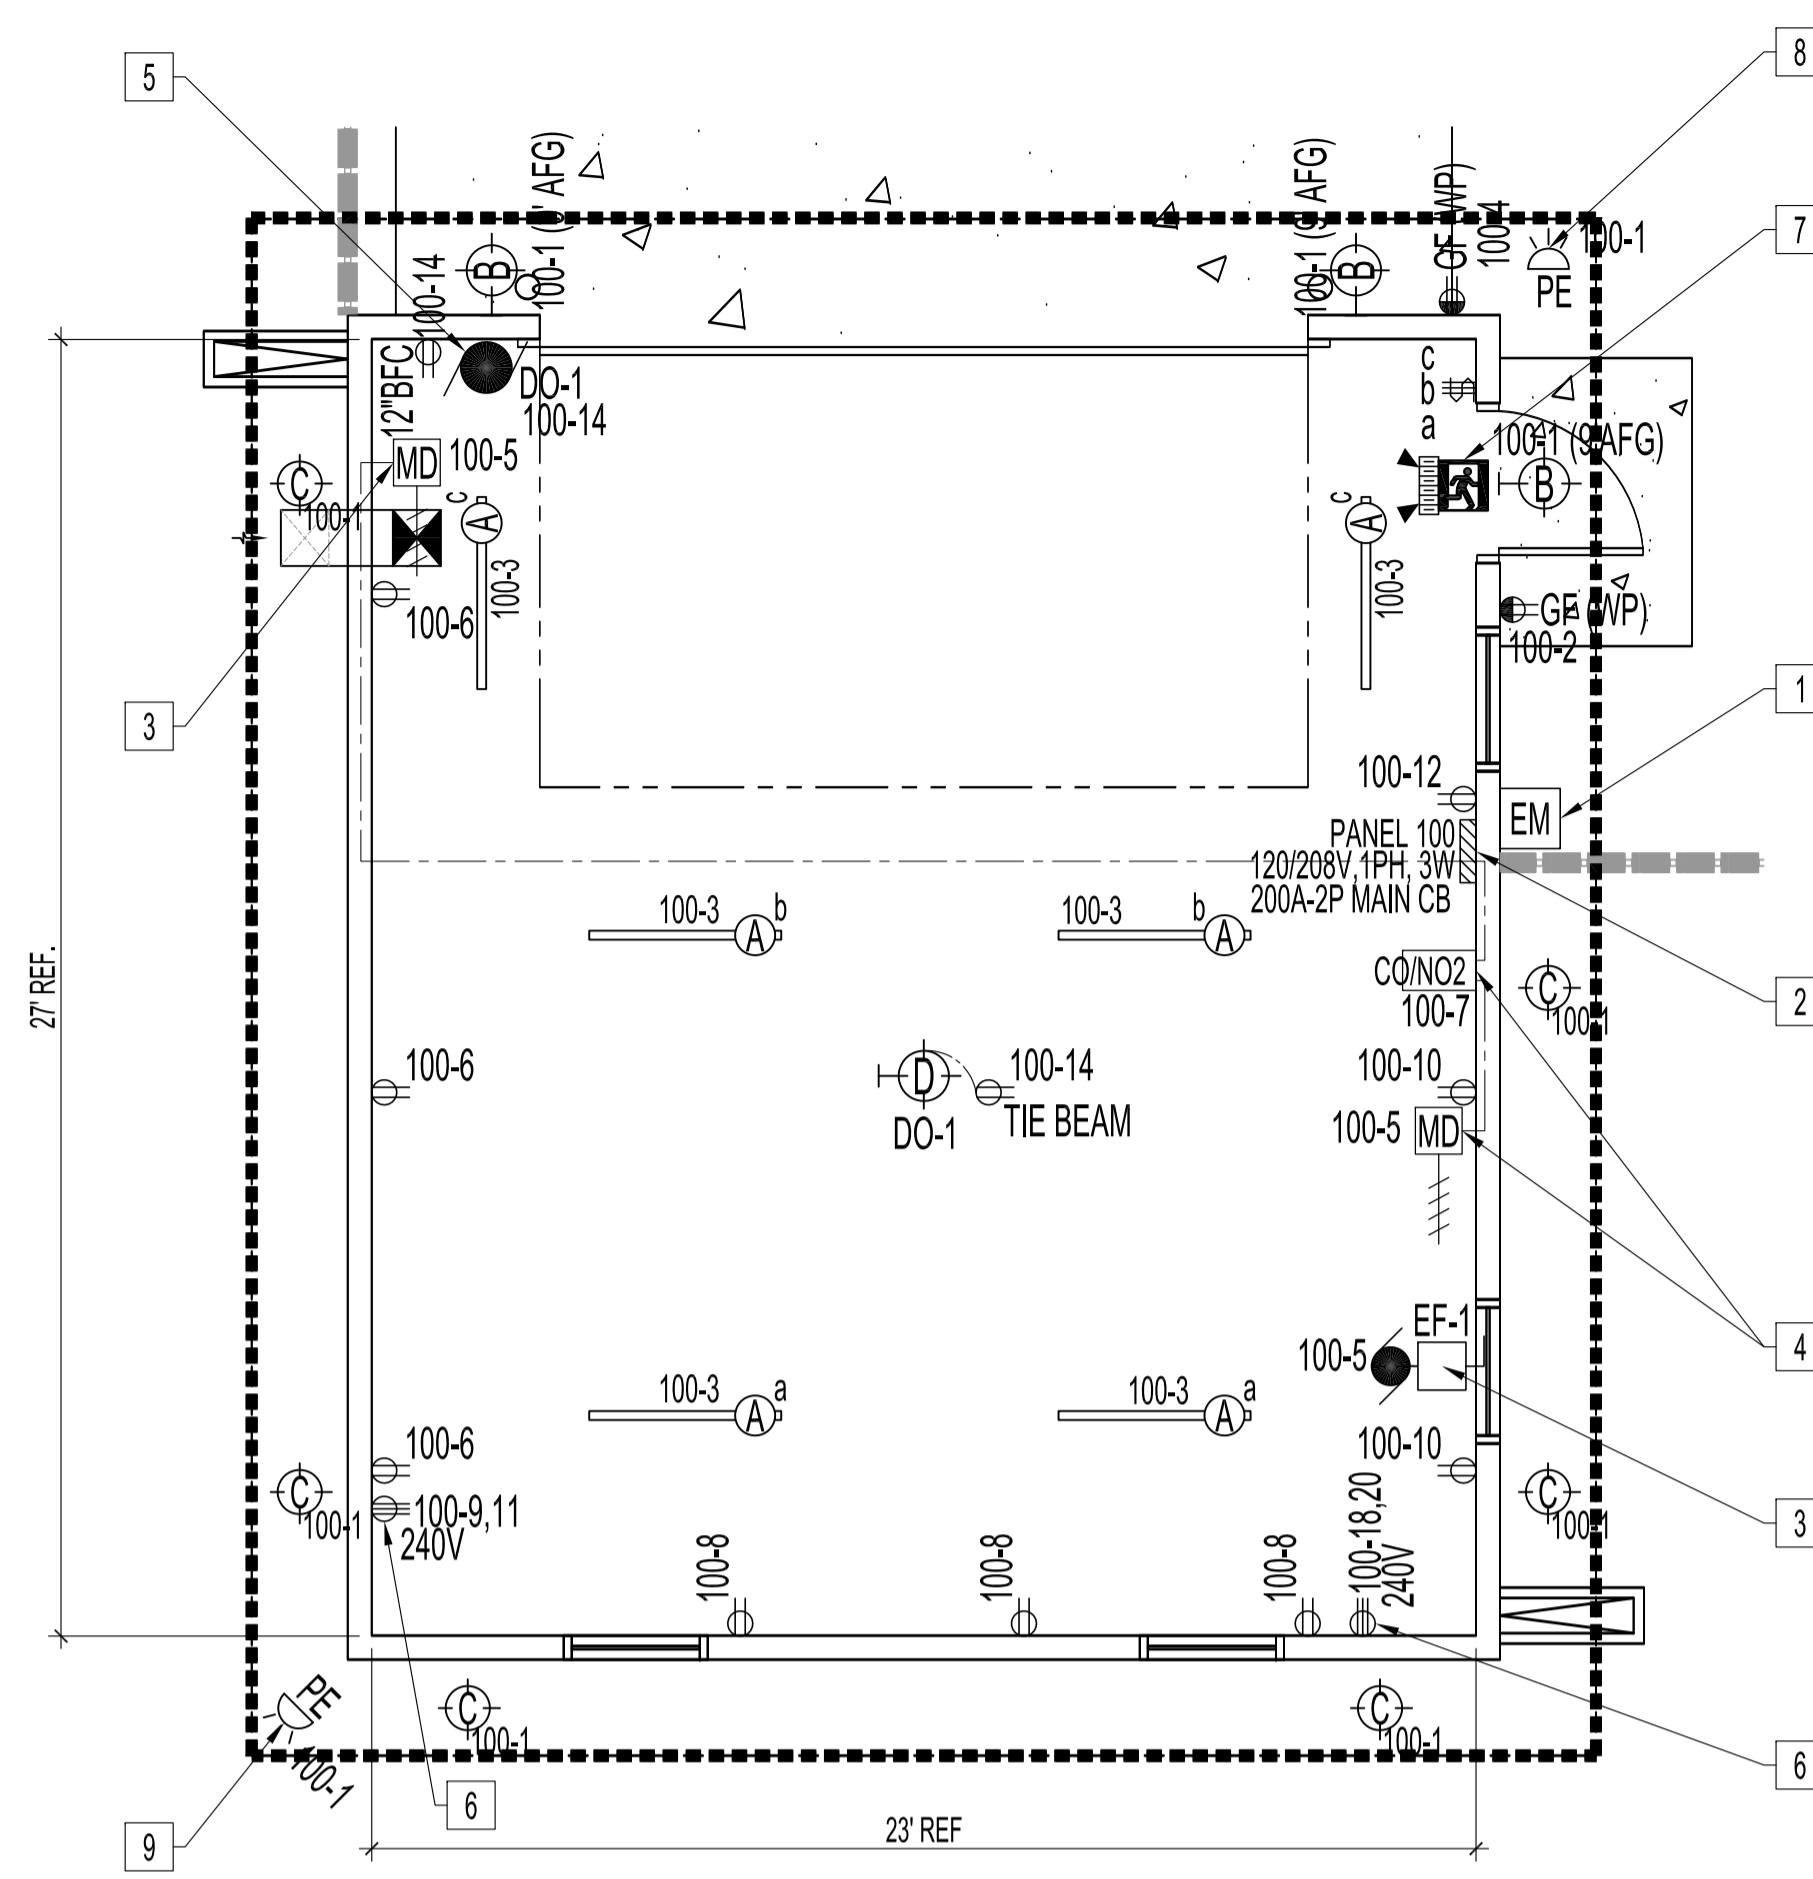

MAIN FLOOR PLAN SCALE: 1/4"=1'-0"

Table with columns: NOTES, DESCRIPTION, VA, BKR, A, B, DESCRIPTION, NOTES. Lists electrical loads and their breaker assignments.

LOAD SUMMARY table with columns: PANEL/LOAD, CONNECTED LOAD (KW), DEMAND FACTOR (%), DEMAND LOAD (KW). Totals: 28.5 KW connected, 28.5 KW demand.

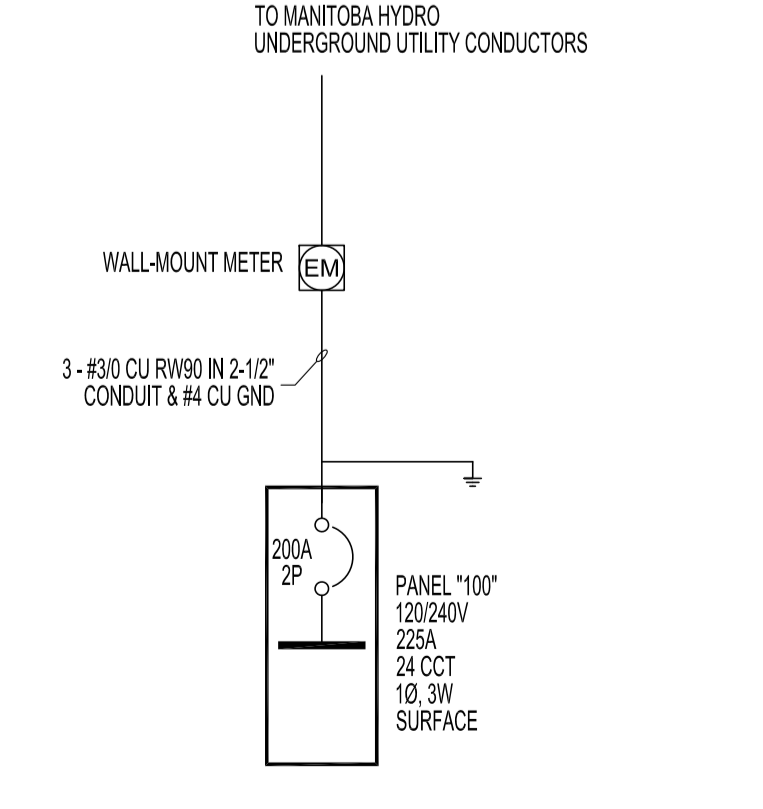

- 1.1 ELECTRICAL SPECIFICATIONS
1.2 EXAMINATION
1.3 SUPERVISION
1.4 ACCURACY OF DATA
1.5 APPROVAL OF MATERIAL
1.6 SHOP DRAWINGS
1.7 AS-BUILT DRAWINGS
1.8 TESTING
1.9 GUARANTEE
1.10 REQUEST FOR CHANGE
1.11 GROUNDING
1.12 WORKMANSHIP


- 2.0 MATERIALS AND INSTALLATION
2.1 OUTLET BOXES
2.2 WIRING METHODS
2.3 IDENTIFICATION OF EQUIPMENT
2.4 DEVICES
2.5 EQUIPMENT

RENOVATION NOTES "X" ALSO SEE NOTES & SPECIFICATIONS. ALL WIRING SHALL BE CONCEALED BEHIND WALLS & FASTENED ABOVE TIE BEAMS.

- 1. APPLY APPLICATION, COORDINATE, PAY & PROVIDE UNDERGROUND ELECTRICAL SERVICE...
2. PROVIDE ELECTRICAL PANEL "100".
3. PROVIDE (EF-1) CIRCUIT & INTERLOCK WITH (CINO2) & BOTH (MD).
4. PROVIDE DEDICATED 120V, 15 AMP CIRCUIT FOR NEW STANDALONE DUAL-GAS DETECTORS...
5. PROVIDE WALL MOUNT BATTERY BACKUP GARAGE DOOR OPENER...

LUMINAIRE, SWITCH & LIGHTING CONTROL SCHEDULE table with columns: TYPE, MANUFACTURER, CATALOGUE No., LAMP, DESCRIPTION.

ALL NEW LIGHTING LUMINAIRES AND COMPONENTS SHALL BE MANITOBA HYDRO POWER SMART APPROVED.

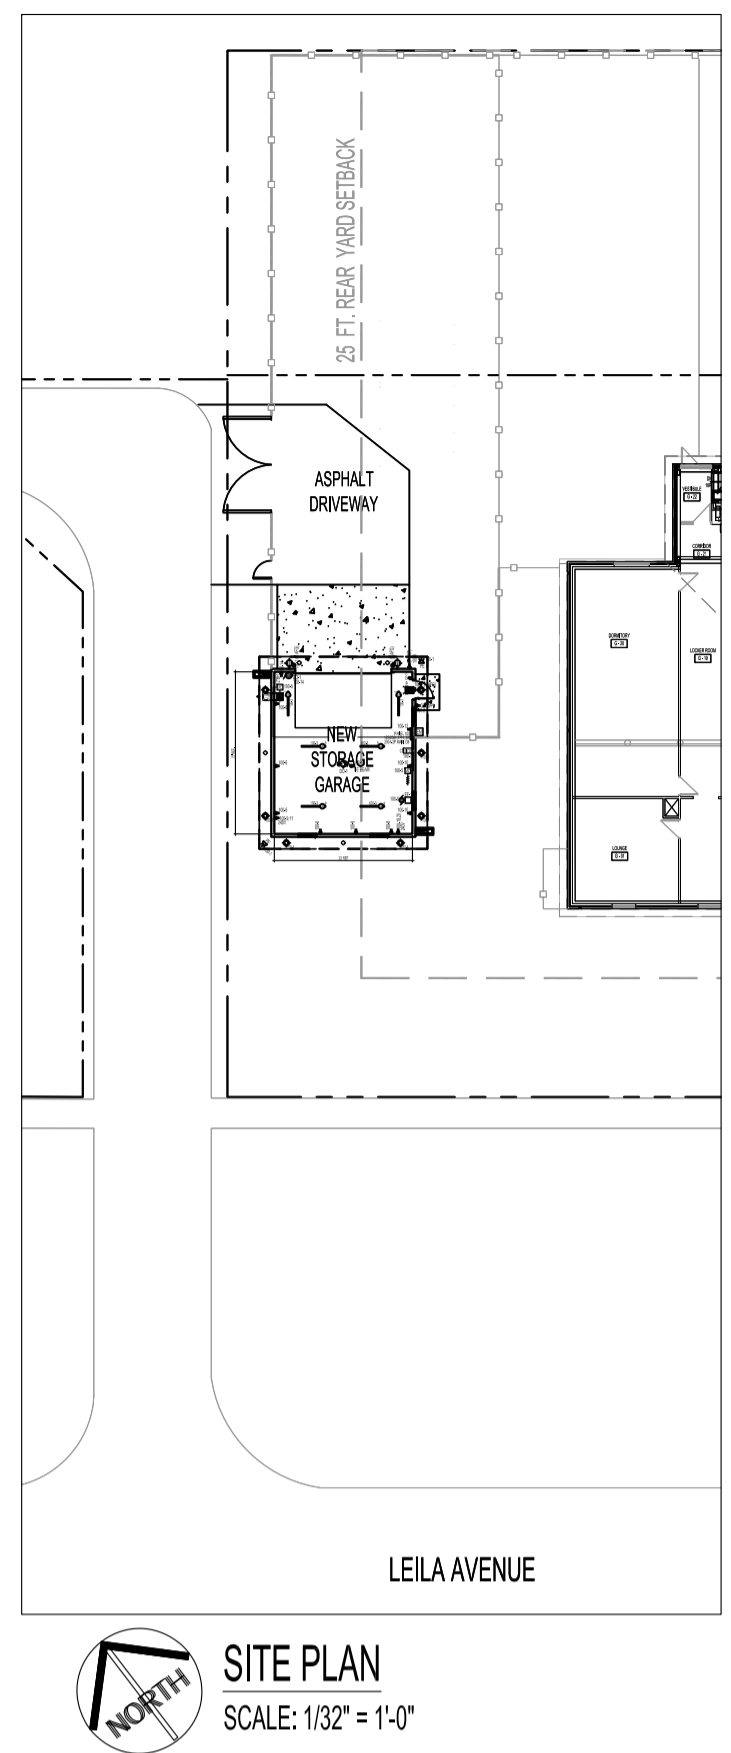

SITE PLAN SCALE: 1/32"=1'-0"

ABBREVIATIONS and ELECTRICAL LEGEND tables. Abbreviations list symbols for various electrical components. Legend lists types and descriptions for electrical symbols.

- NOTES: THESE DRAWINGS SHALL NOT BE SCALED... SUBMISSION OF SITE MARKUPS... THE CONTRACTOR SHALL VISIT THE SITE... ALL PRODUCTS AND MATERIALS TO BE USED...

Revision table with columns: No., REVISION/DESCRIPTION, BY, DATE. Shows revisions issued for addendum and construction.



Approval table with columns: DRAWN, CHECKED, DESIGNED, APPROVED. Includes dates and initials.

THE CITY OF WINNIPEG PLANNING, PROPERTY AND DEVELOPMENT DEPARTMENT MUNICIPAL ACCOMMODATIONS DIVISION 3-65 GARRY STREET, R3C 4K4

PROJECT PARKS AND OPEN SPACE AMBER TRAILS - STORAGE GARAGE

10 ALLAN BLYE DRIVE SHEET TITLE: SITE AND MAIN FLOOR PLAN ELECTRICAL POWER, SYSTEMS AND SLD

Scale and Sheet info: SCALE AS SHOWN, PROJECT No: 2020-126, SHEET No: E1R1

DRAWING SHEET SIZE: A1 (841mm x 594mm) PLOT 1:1