


EXISTING DEWATERING ELECTRICAL ROOM
 EXISTING MCC 2WB (PARTIAL) (REF. 3)

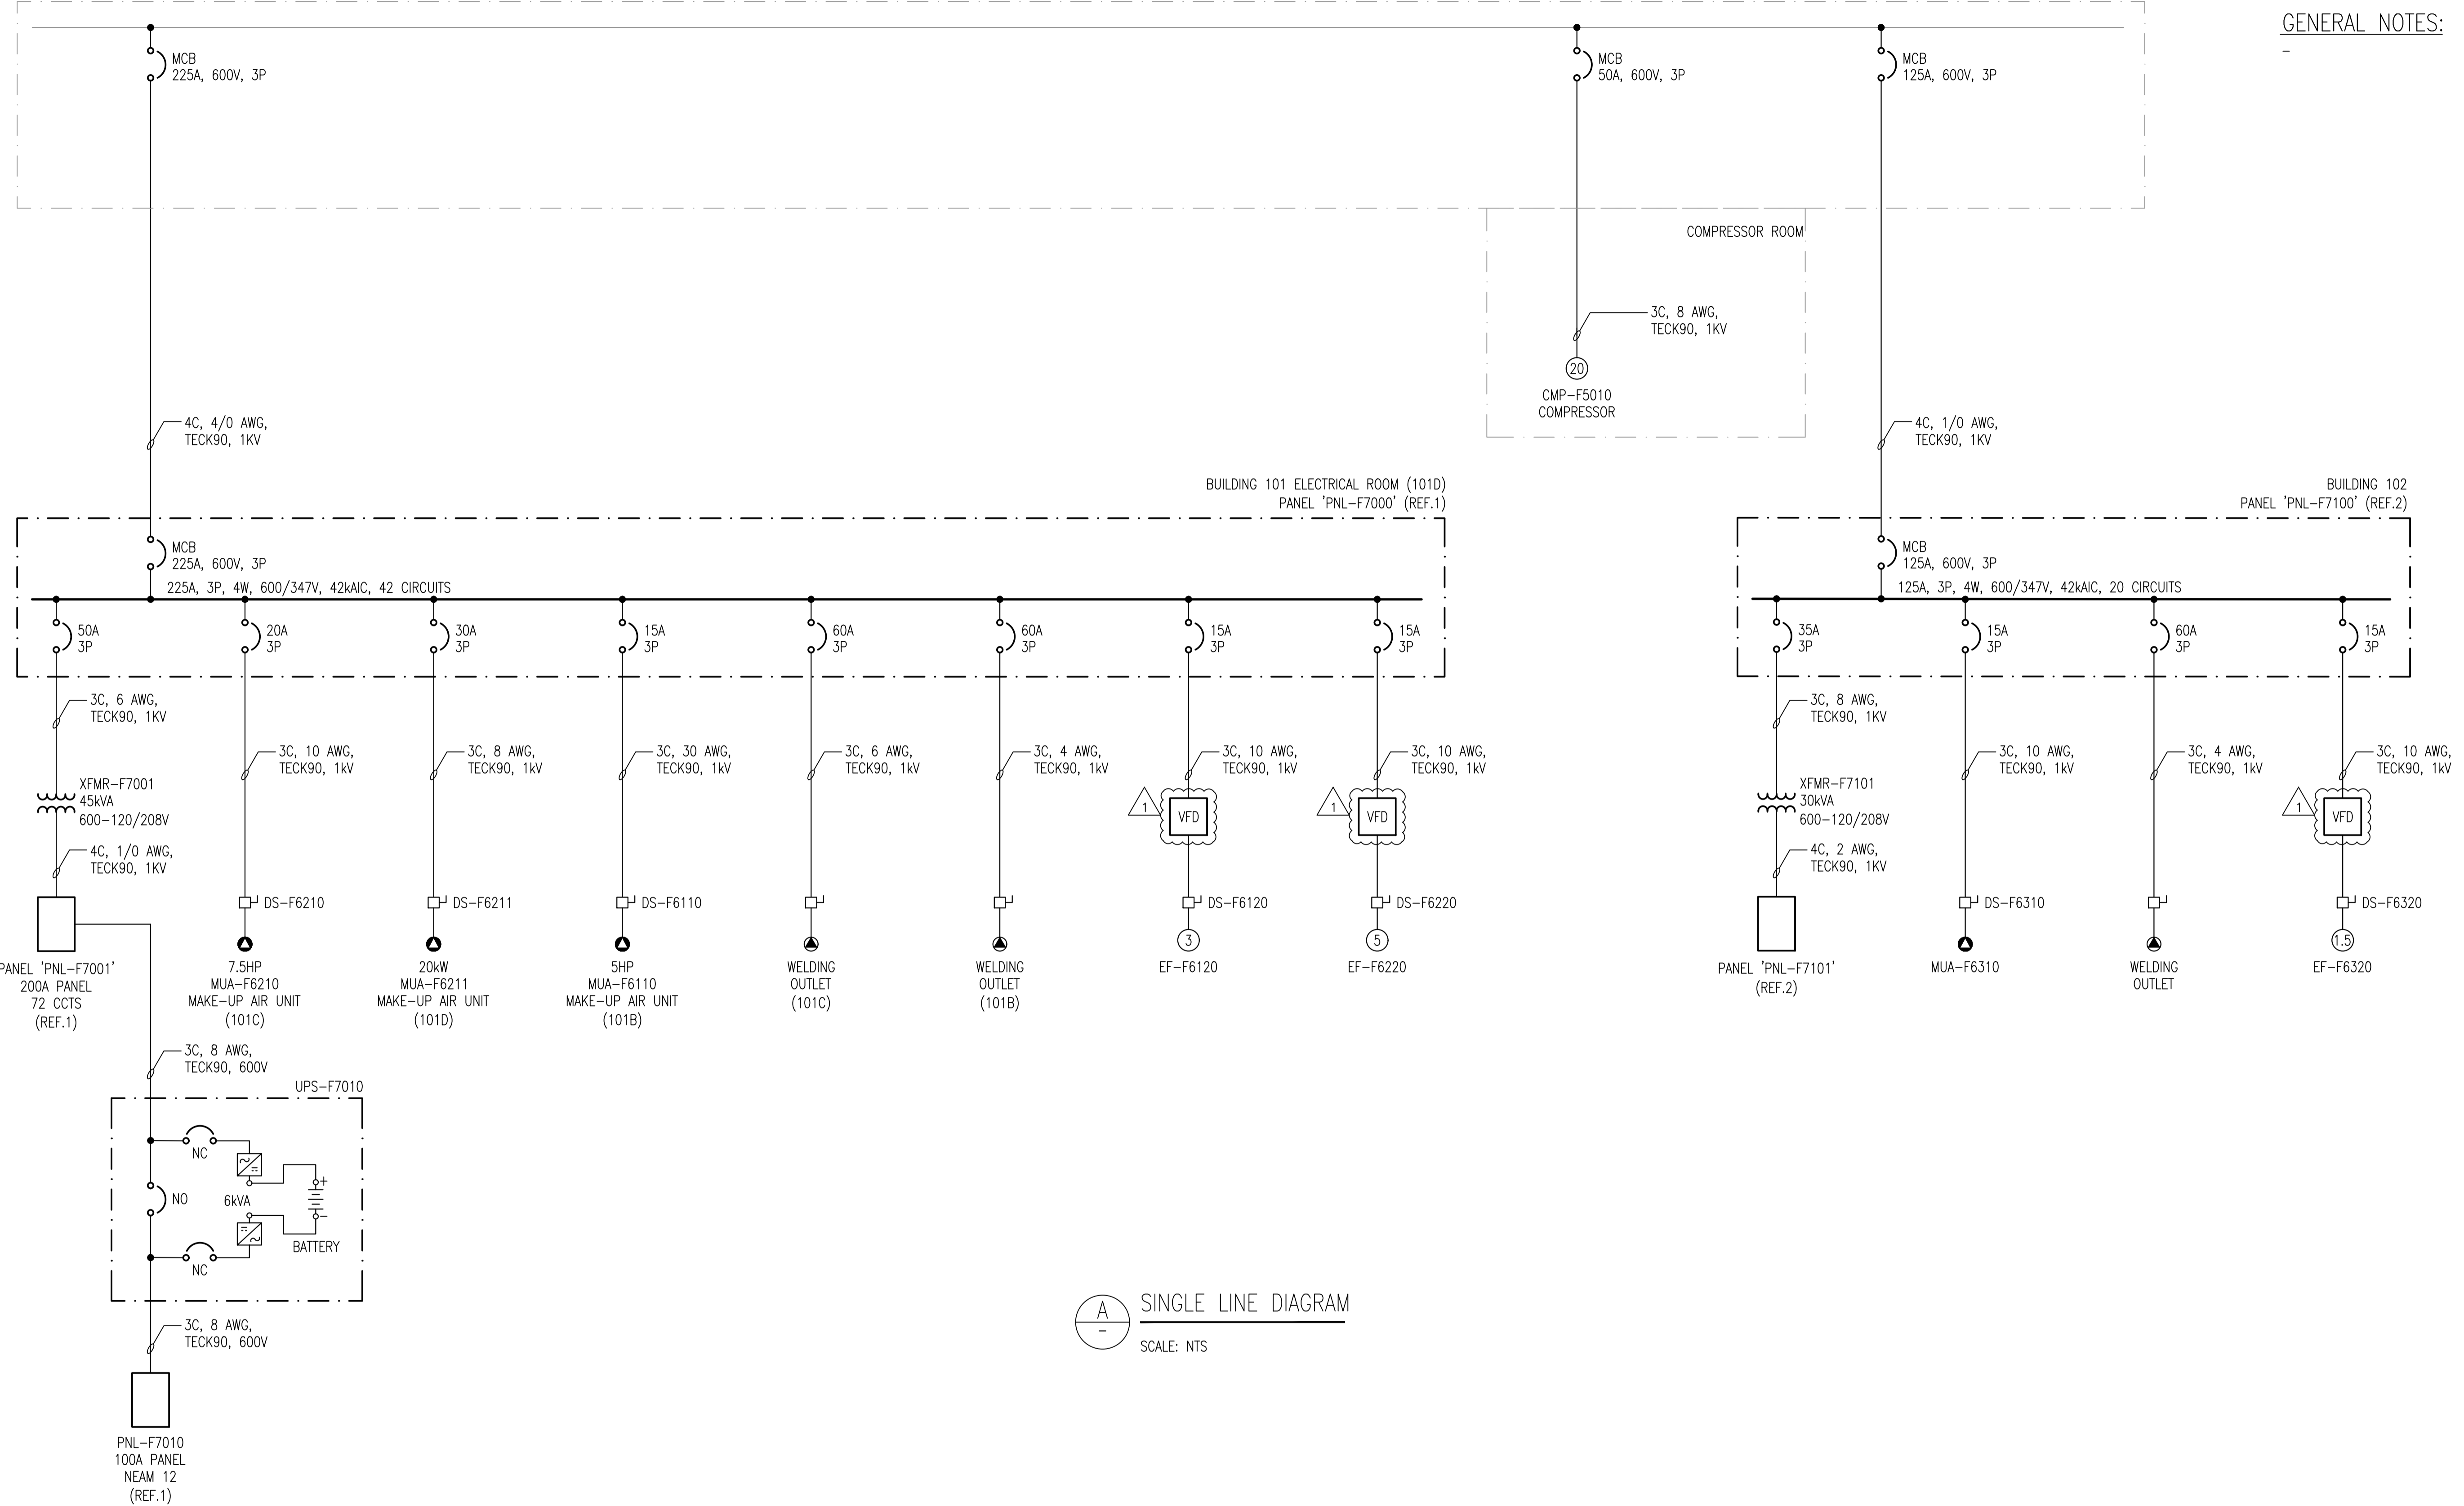

GENERAL NOTES:

A SINGLE LINE DIAGRAM
 SCALE: NTS

10	-	-
9	-	-
8	-	-
7	-	-
6	-	-
5	-	-
4	-	-
3	1-0101W-E0005-001	DEWATERING - ELECTRICAL - SINGLE LINE DIAGRAM
2	1-0101-ESCH-F203-001	BUILDING 102 - PANEL BOARD SCHEDULE
1	1-0101-ESCH-F201-001	BUILDING 101 - PANEL BOARD SCHEDULE
NO.	DRAWING NUMBER	REFERENCE DRAWING TITLE
REFERENCE DRAWINGS		



B.M. ELEV.			
CONSTRUCTION COMPLETION DATE: YYYY MM DD			
NO.	REVISIONS	DATE	BY
1	RE-ISSUED FOR CONSTRUCTION	2022 07 05	JAB
0	ISSUED FOR CONSTRUCTION	2022 05 18	JAB

KGS GROUP			
DESIGNED BY	DG	CHECKED BY	JAB
DRAWN BY	RG	APPROVED BY	JAB
SCALE:	NTS		
DATE	2022 03 09	RELEASED FOR CONSTRUCTION DATE	

ENGINEER'S SEAL
CONSULTANT DRAWING NUMBER
21-0107-015_E0.002

	THE CITY OF WINNIPEG WATER AND WASTE DEPARTMENT ENGINEERING DIVISION
	NORTH END SEWAGE TREATMENT PLANT (NEPCC) INTERIM PHOSPHOROUS REMOVAL
ELECTRICAL POWER SINGLE LINE DIAGRAM	
CITY DRAWING NUMBER	1-0101-ESLD-A001-001
SHEET	1 OF 1