

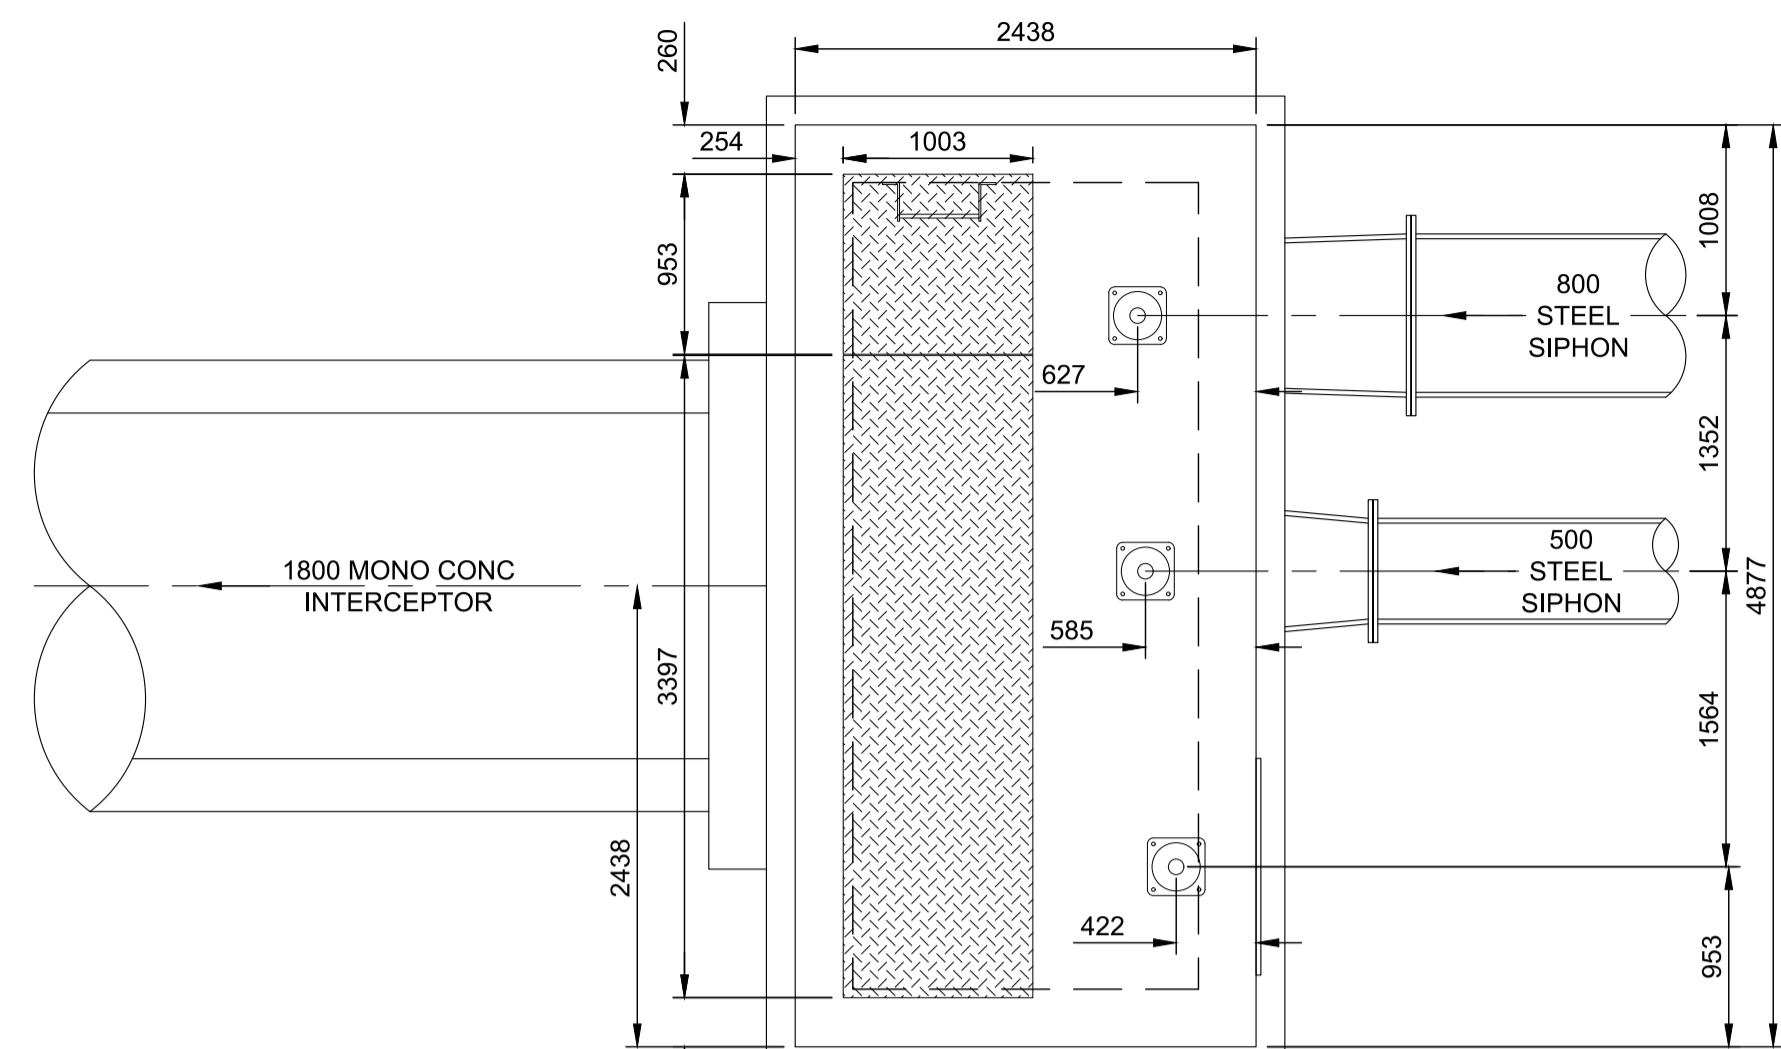


NOTES:



1. REFER TO APPENDIX A RECORD DRAWINGS FOR FURTHER CHAMBER INFORMATION.
2. ALL WORK SHALL BE COMPLETED WITHOUT DEWATERING SIPHONS.

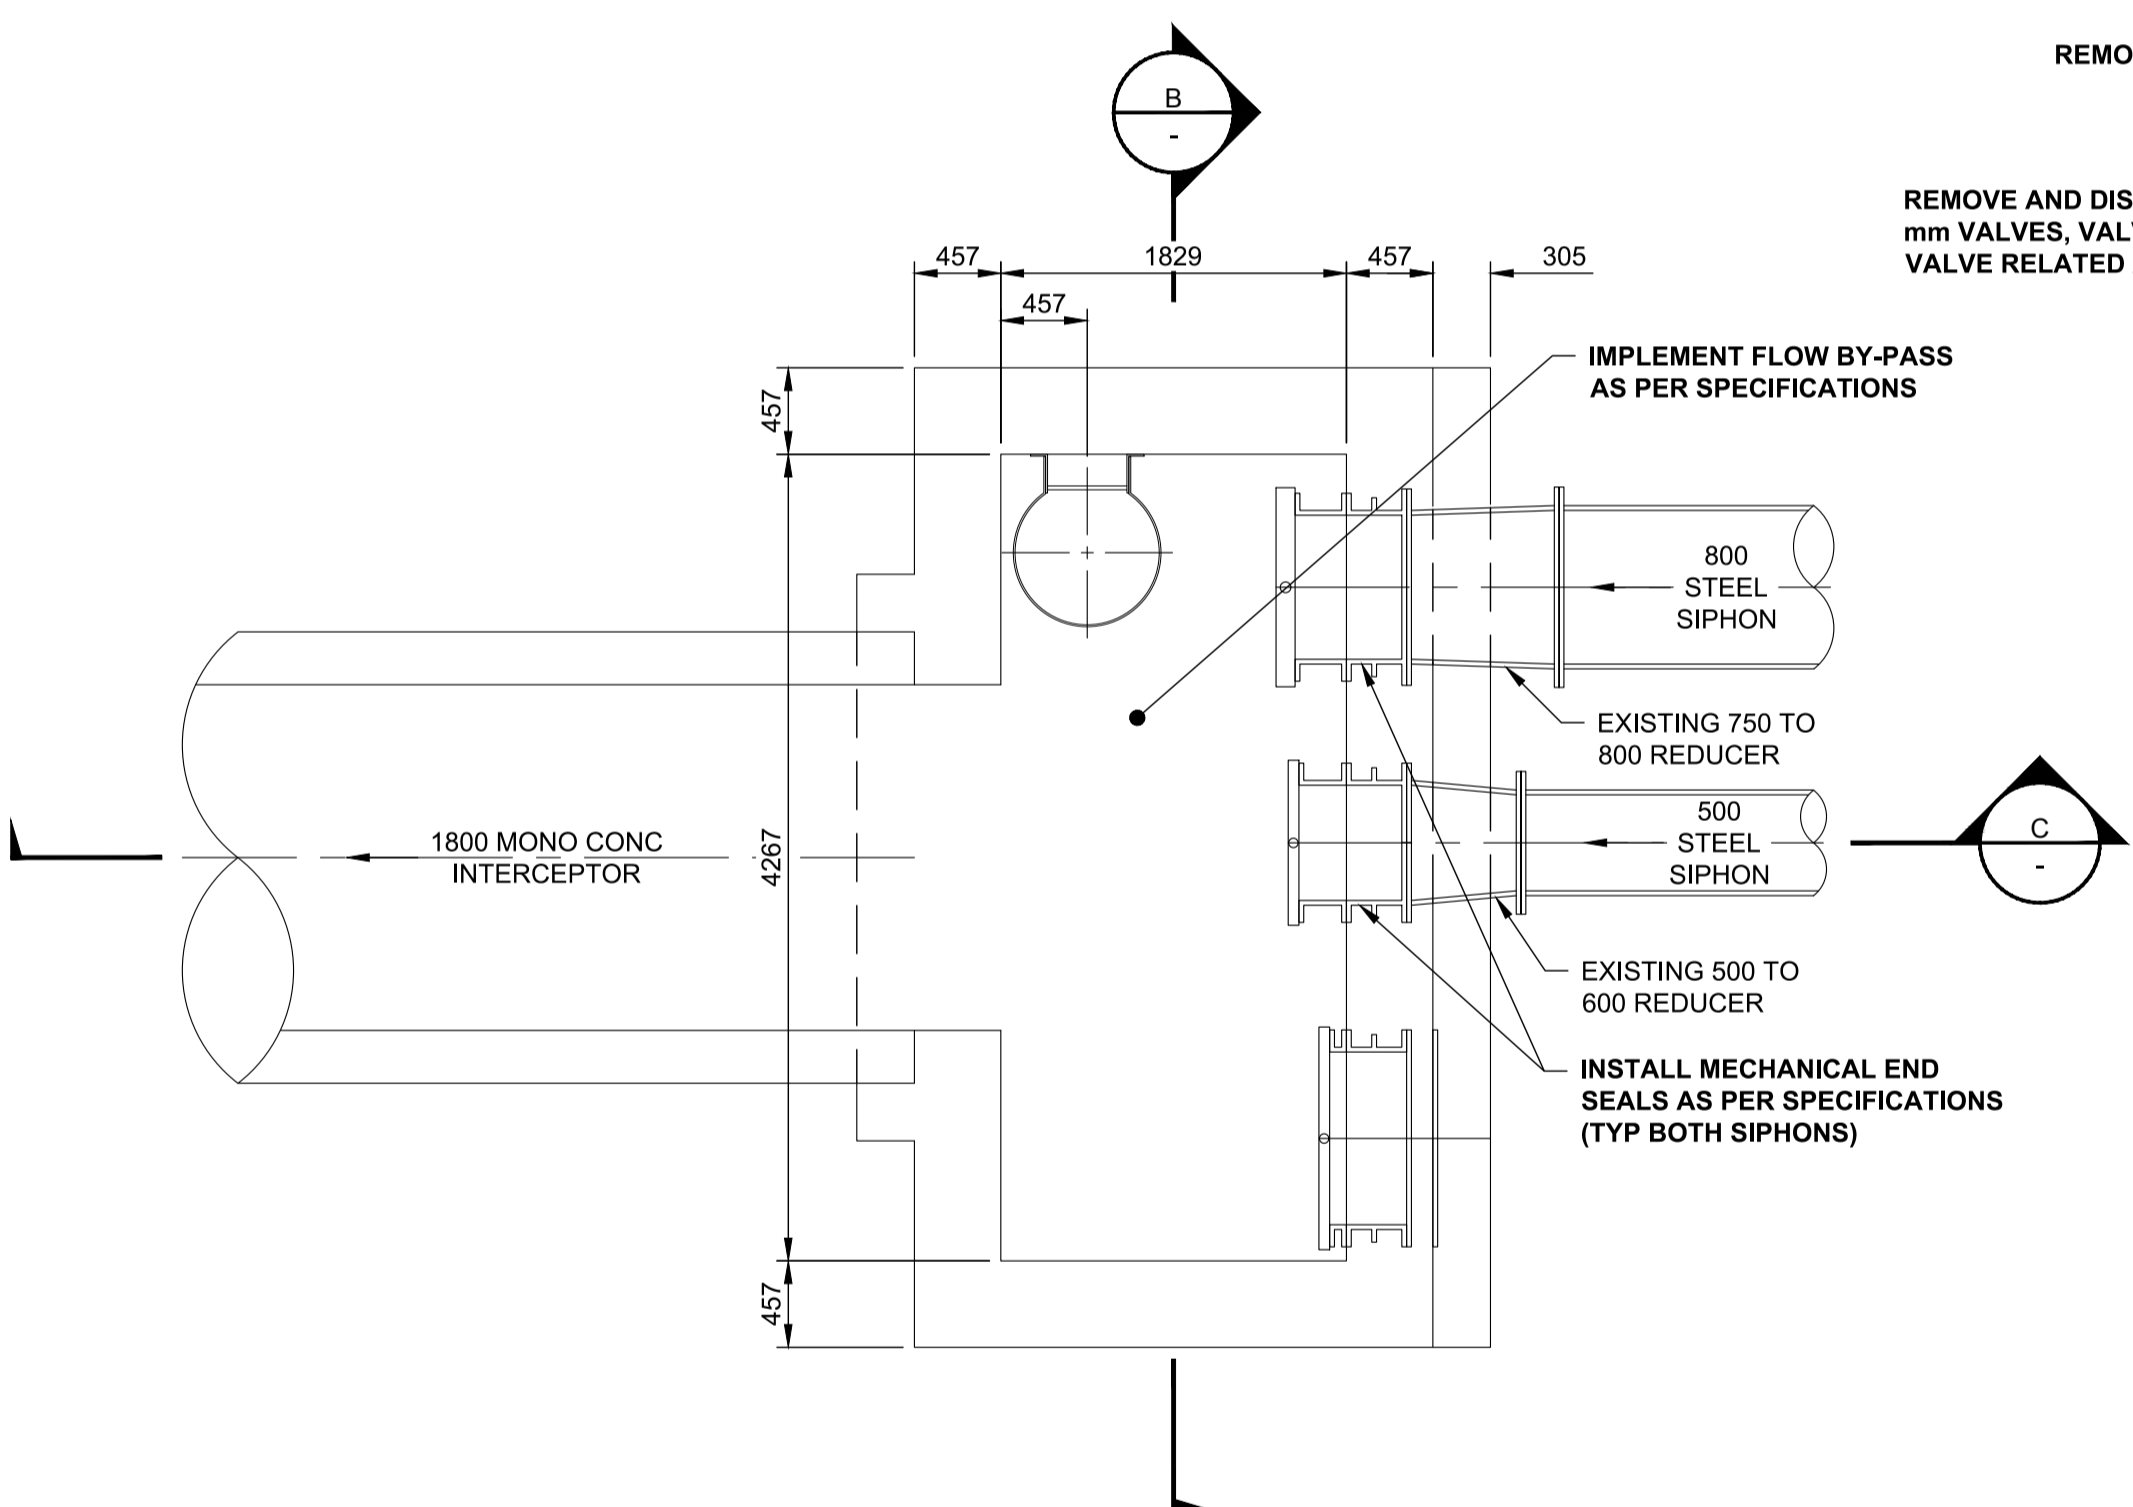



ROOF PLAN

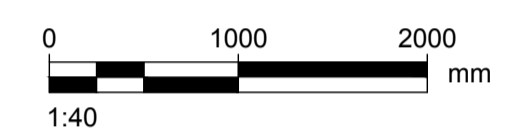


A SECTION FLOOR PLAN

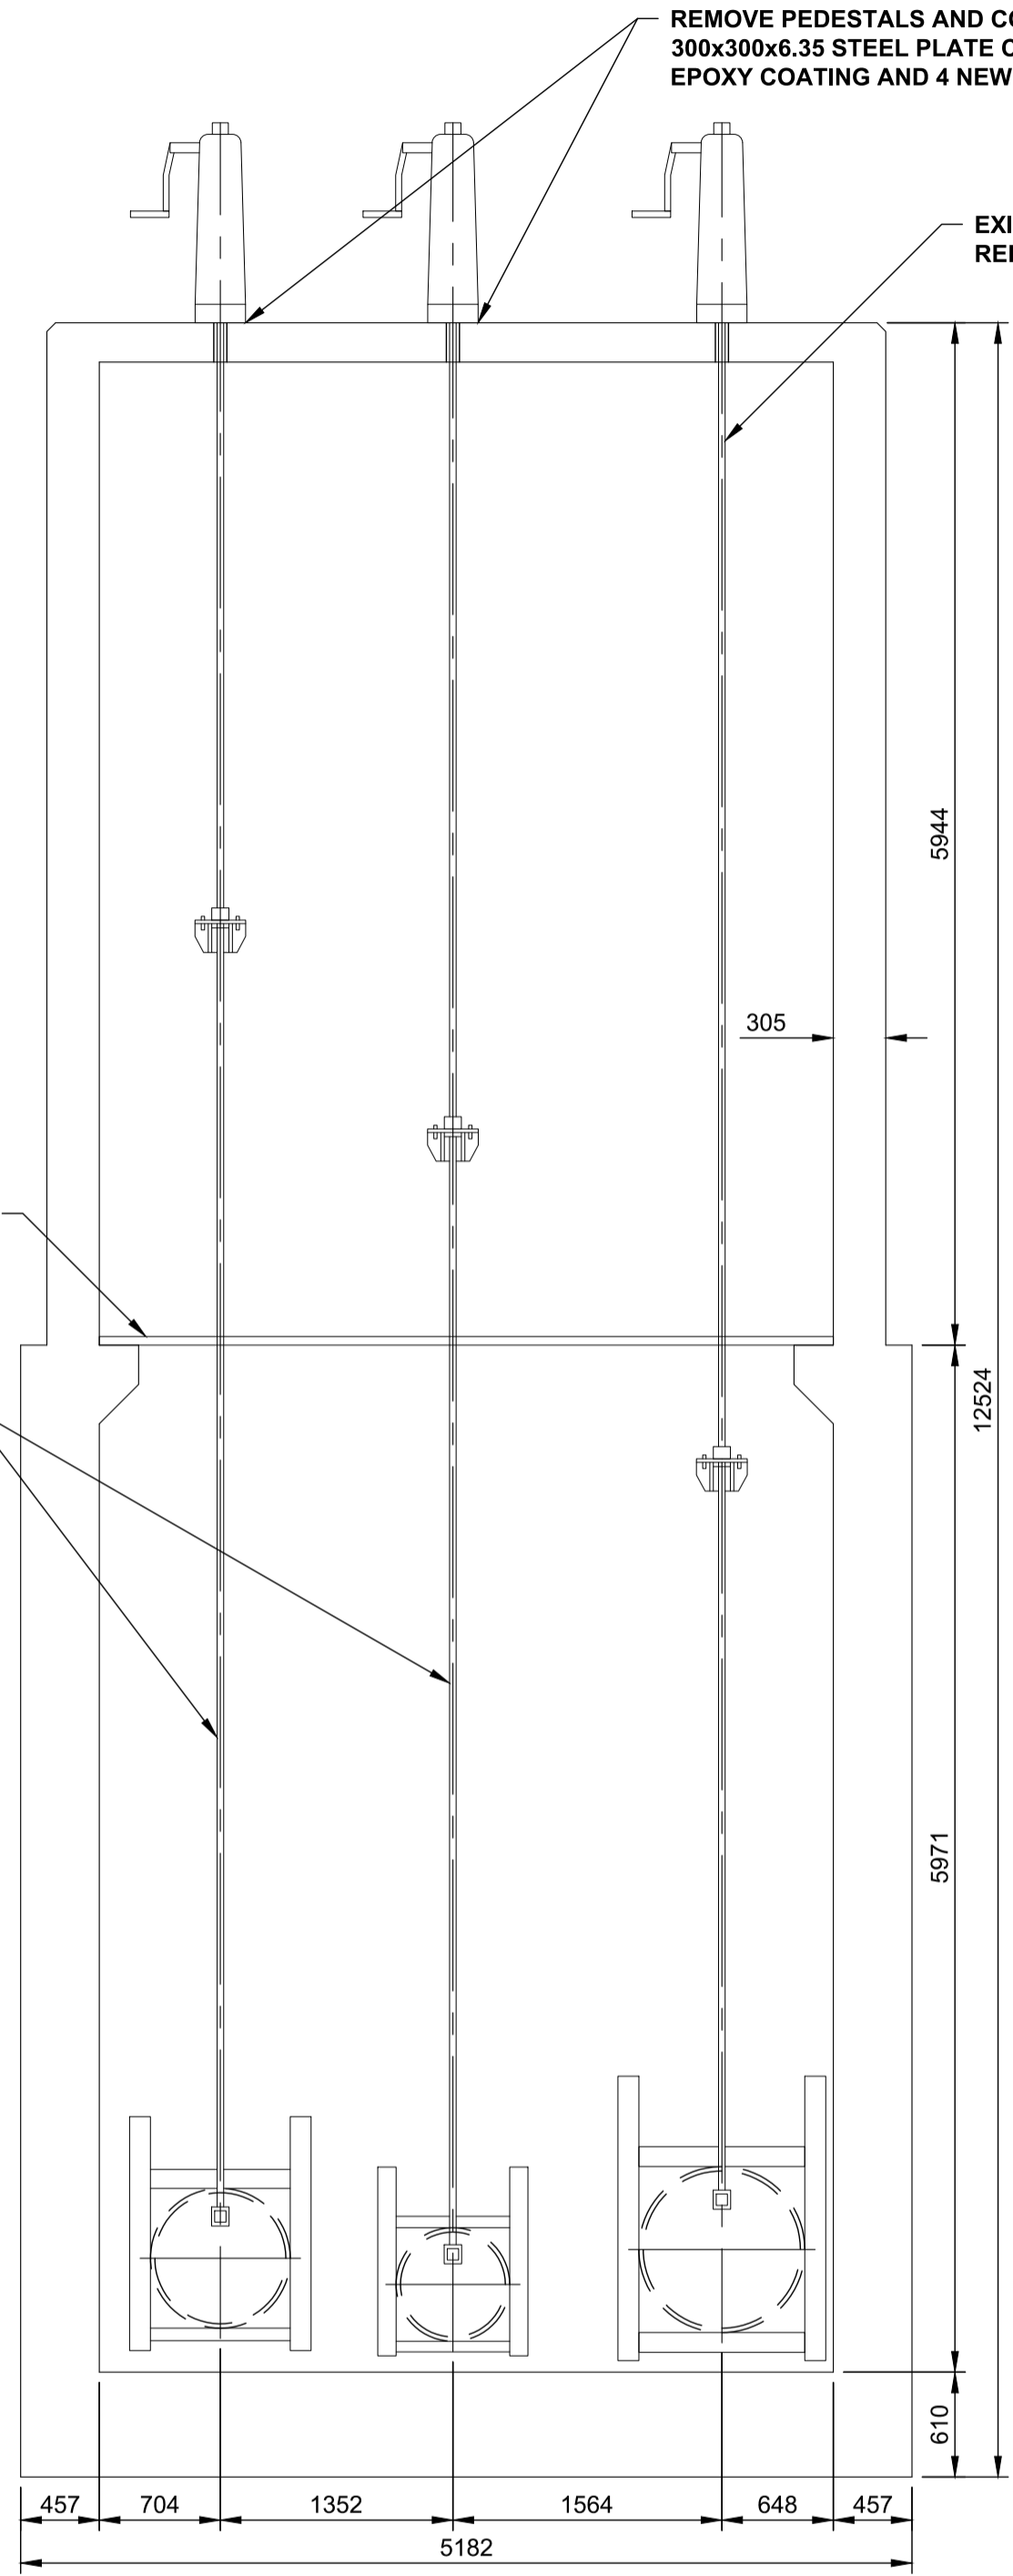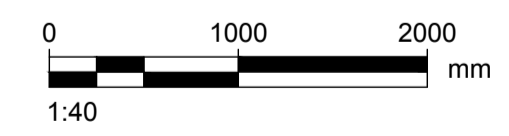

B SECTION

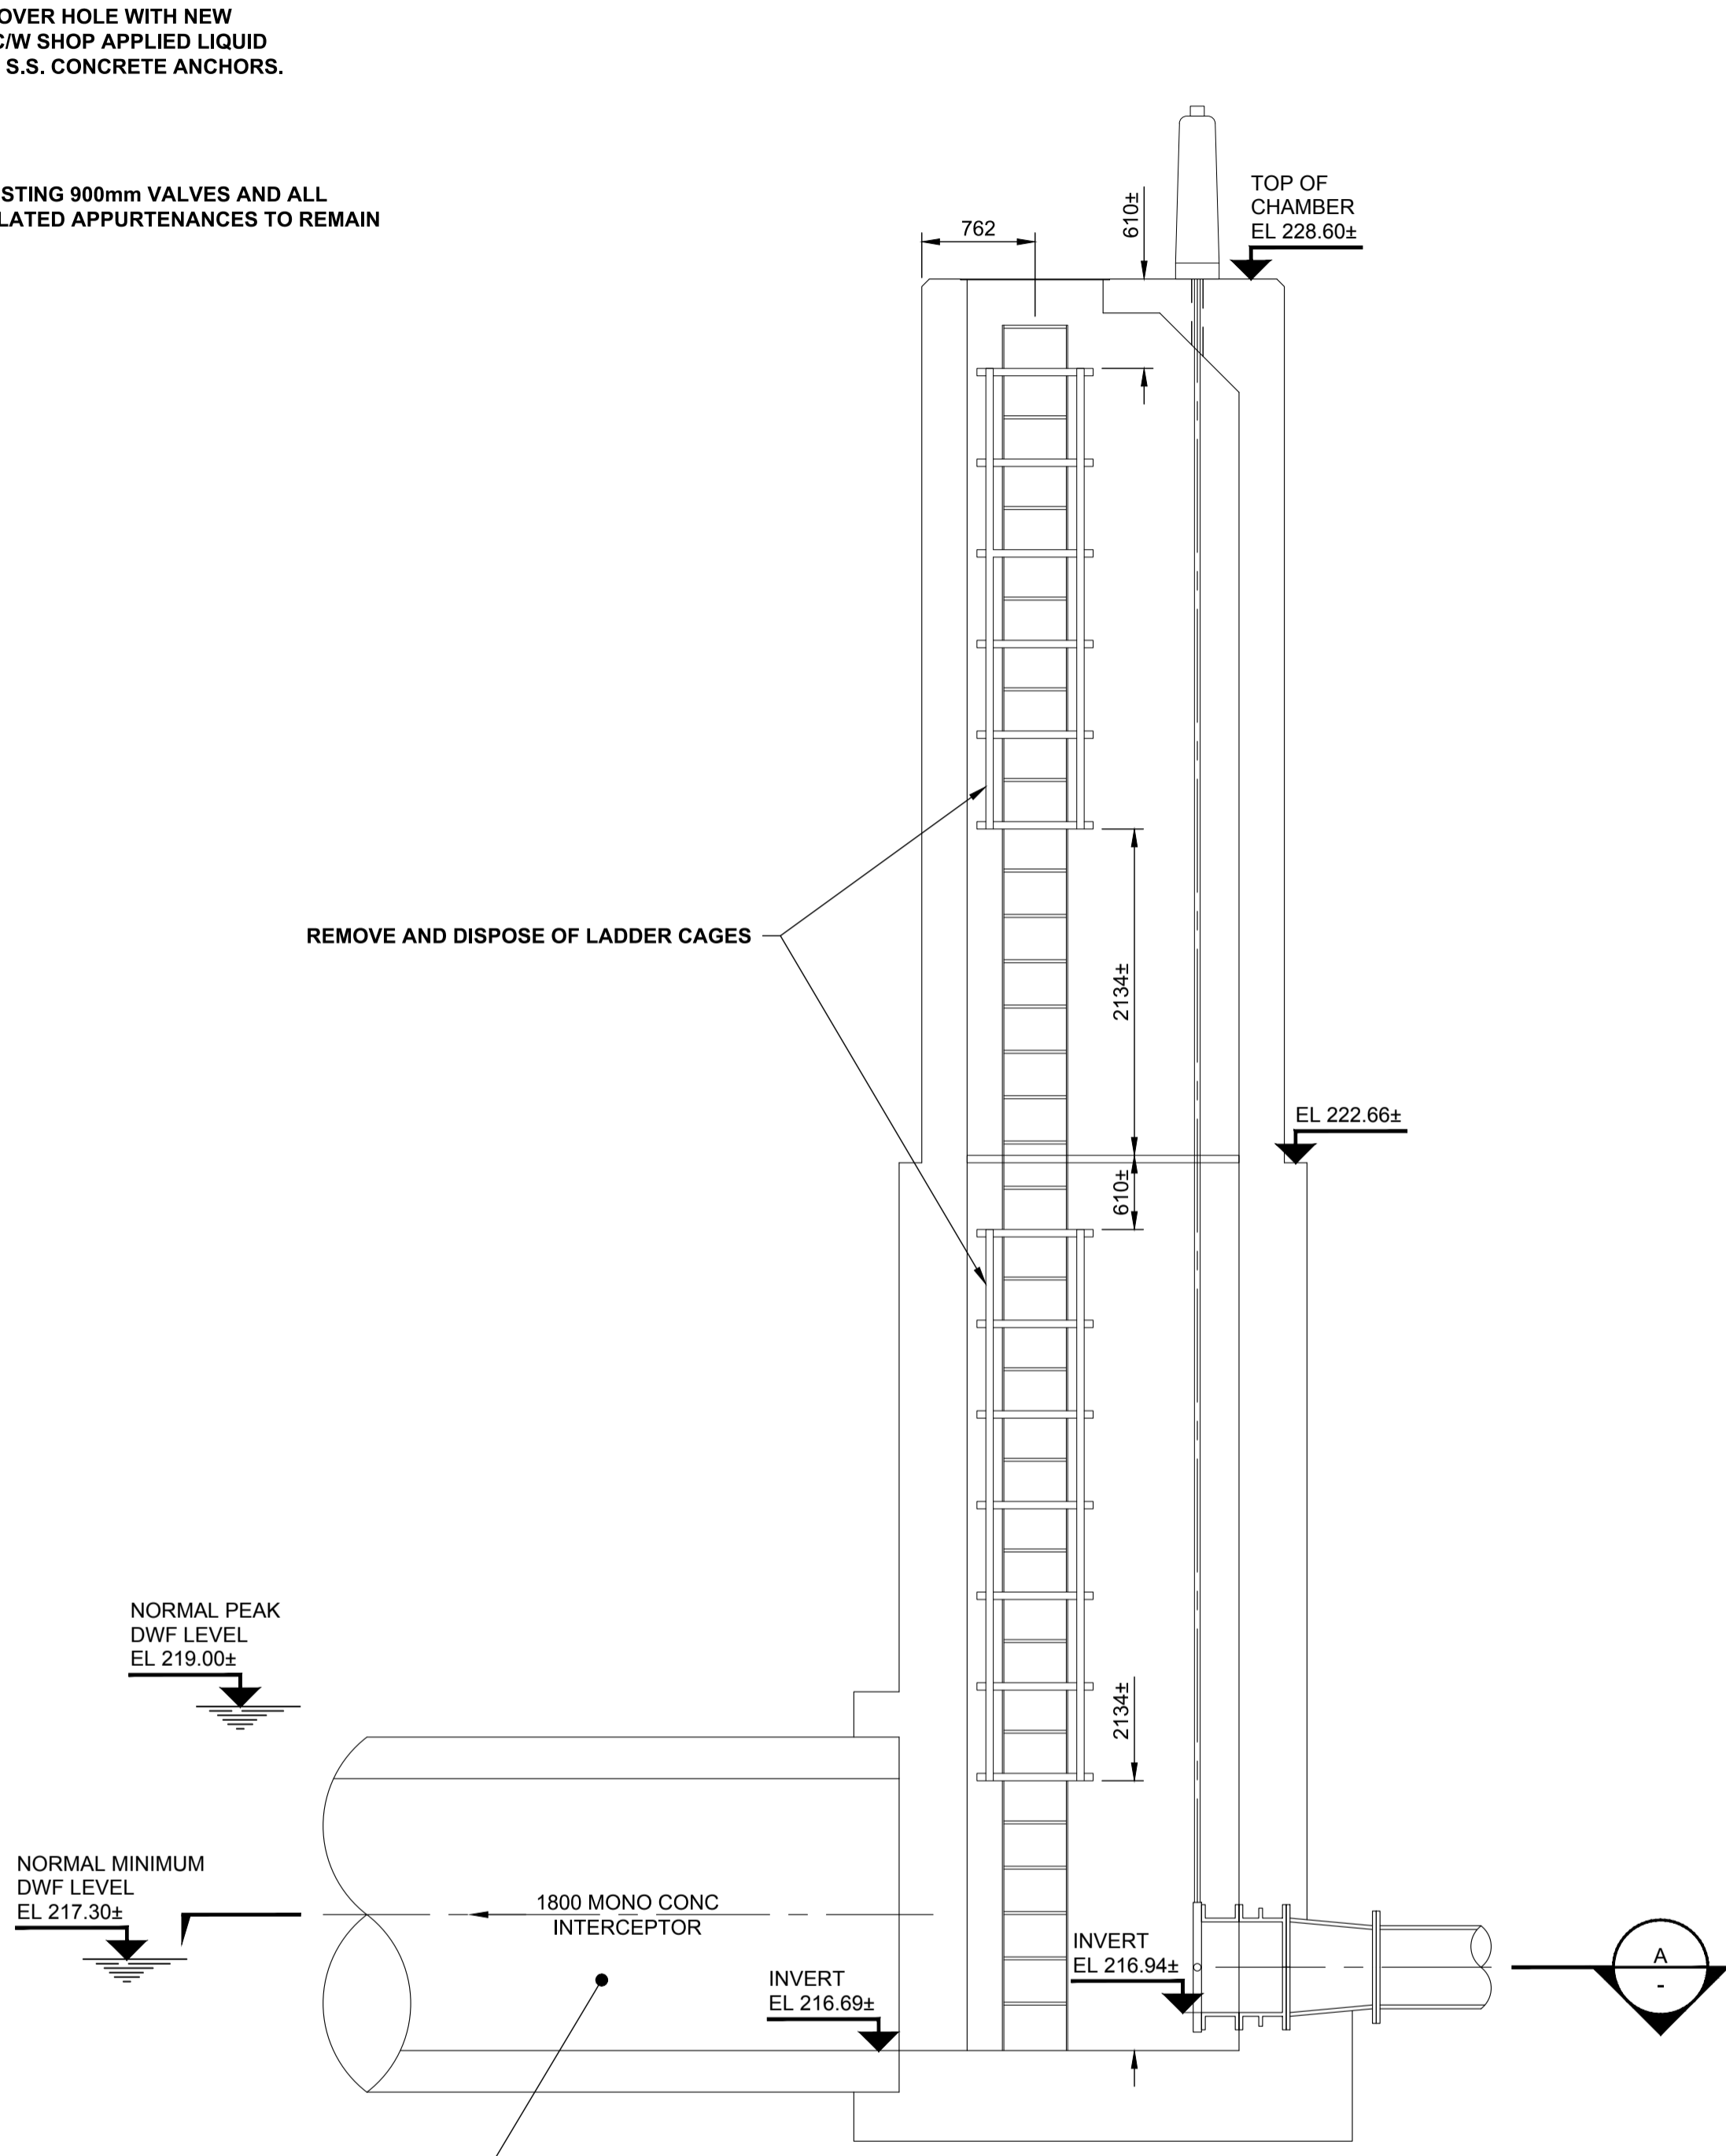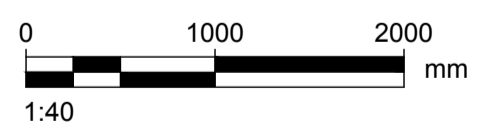

C SECTION

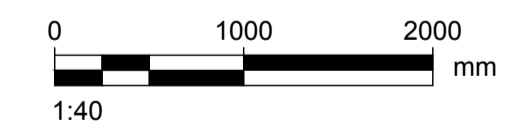

LEVELS IN THE DOWNSTREAM 1800mm INTERCEPTOR CAN BE DRAWN DOWN BY OPERATIONS AT NEWPCC TO MAINTAIN A LEVEL NEAR 217.7 m TO FACILITATE IMPLEMENTATION OF FLOW BY PASS

METRIC
WHOLE NUMBERS INDICATE MILLIMETRES
DECIMALIZED NUMBERS INDICATE METRES

WARNING
IF POWER EQUIPMENT OR EXPLOSIVES ARE TO BE USED FOR EXCAVATION ON THIS PROJECT THE CONTRACTOR MUST:
1) NOTIFY THE GAS COMPANY OF THE PROPOSED LOCATION OF EXCAVATION.
2) TAKE PRECAUTION TO AVOID DAMAGE TO GAS COMPANY INSTALLATIONS.
SEE PROVINCIAL REGULATION 21072 FOR DETAILS

LOCATION APPROVED UNDERGROUND STRUCTURES
SUPV. U/G STRUCTURES COMMITTEE DATE
NOTE:
LOCATION OF UNDERGROUND STRUCTURES AS SHOWN ARE BASED ON THE BEST INFORMATION AVAILABLE BUT NO GUARANTEE IS GIVEN THAT ALL EXISTING UTILITIES ARE SHOWN OR THAT THE GIVEN LOCATIONS ARE EXACT. CONFIRMATION OF EXISTENCE AND EXACT LOCATION OF ALL SERVICES MUST BE OBTAINED FROM THE INDIVIDUAL UTILITIES BEFORE PROCEEDING WITH CONSTRUCTION.

B.M. ELEV.		CONSTRUCTION COMPLETION DATE: YYYY MM DD	
0	ISSUED FOR TENDER	22/06/15	ADL
NO.	REVISIONS	DATE	BY

AECOM	
DESIGNED BY: TJB	CHECKED BY: MPG
DRAWN BY: ADL	APPROVED BY: CCM
SCALE: HORIZONTAL AS NOTED	RELEASED FOR CONSTRUCTION: K Zurek
VERTICAL: N/A	DATE: Jun 20/22
DATE: 2022 06 20	DATE: Jun 20/22

ENGINEER'S SEAL
ORIGINAL SIGNED BY C. Macey 16 June 2022
CONSULTANT DRAWING NUMBER: C-3001

THE CITY OF WINNIPEG
WATER AND WASTE DEPARTMENT
ENGINEERING SERVICES DIVISION
REHABILITATION OF WHELLAMS LANE
SIPHONS BY CIPP LINING
SECTIONS & DETAILS
EXISTING DOWNSTREAM SIPHON
OUTLET CHAMBER
SHEET 6 OF 7
CITY DRAWING NUMBER 13068

ENGINEERS GEOSCIENTISTS MANITOBA
Certificate of Authorization
AECOM Canada Ltd.
No. 4671 Date: 2022/06/20