



# THE CITY OF WINNIPEG


WATER AND WASTE DEPARTMENT  
ENGINEERING SERVICES DIVISION

## WINNIPEG WATER TREATMENT PLANT DEACON BOOSTER PUMPING STATION SUCTION HEADER SPLIT

TENDER 640-2022

### LIST OF PROJECT DRAWINGS

SHEET No.	CITY DWG. No.	CONSULTANT DWG No.	AREA	DISCIPLINE	DRAWING TITLE
1	1-0601D-G0001-001	G-0001	WATER TREATMENT PLANT	GENERAL	COVER
2	1-0601D-C0001-001	C-0001	WATER TREATMENT PLANT	CIVIL	GENERAL LAYOUT AND SECTION
3	1-0601D-C0002-001	C-0002	WATER TREATMENT PLANT	CIVIL	PIPE LAYOUT AND SECTION
4	1-0601D-C0003-001	C-0003	WATER TREATMENT PLANT	CIVIL	DETAILS
5	1-0601D-S0001-001	S-0001	WATER TREATMENT PLANT	STRUCTURAL	STAGING
6	1-0601D-S0002-001	S-0002	WATER TREATMENT PLANT	STRUCTURAL	WALL SECTIONS AND DETAILS
7	1-0601D-S0003-001	S-0003	WATER TREATMENT PLANT	STRUCTURAL	FLOOR COVER DETAILS AND SECTIONS
8	1-0601D-S0004-001	S-0004	WATER TREATMENT PLANT	STRUCTURAL	STEEL DETAILS
9	1-0601D-E0001-001	E-001	WATER TREATMENT PLANT	ELECTRICAL	PLAN AND SECTION
10	1-0601D-E0002-001	E-0002	WATER TREATMENT PLANT	ELECTRICAL	PANEL SCHEDULE
11	1-0601D-E0003-001	E-0003.1	WATER TREATMENT PLANT	ELECTRICAL	SUMP PUMP CONTROL PANEL SCHEMATIC
12	1-0601D-E0003-002	E-0003.2	WATER TREATMENT PLANT	ELECTRICAL	SUMP PUMP CONTROL PANEL SCHEMATIC

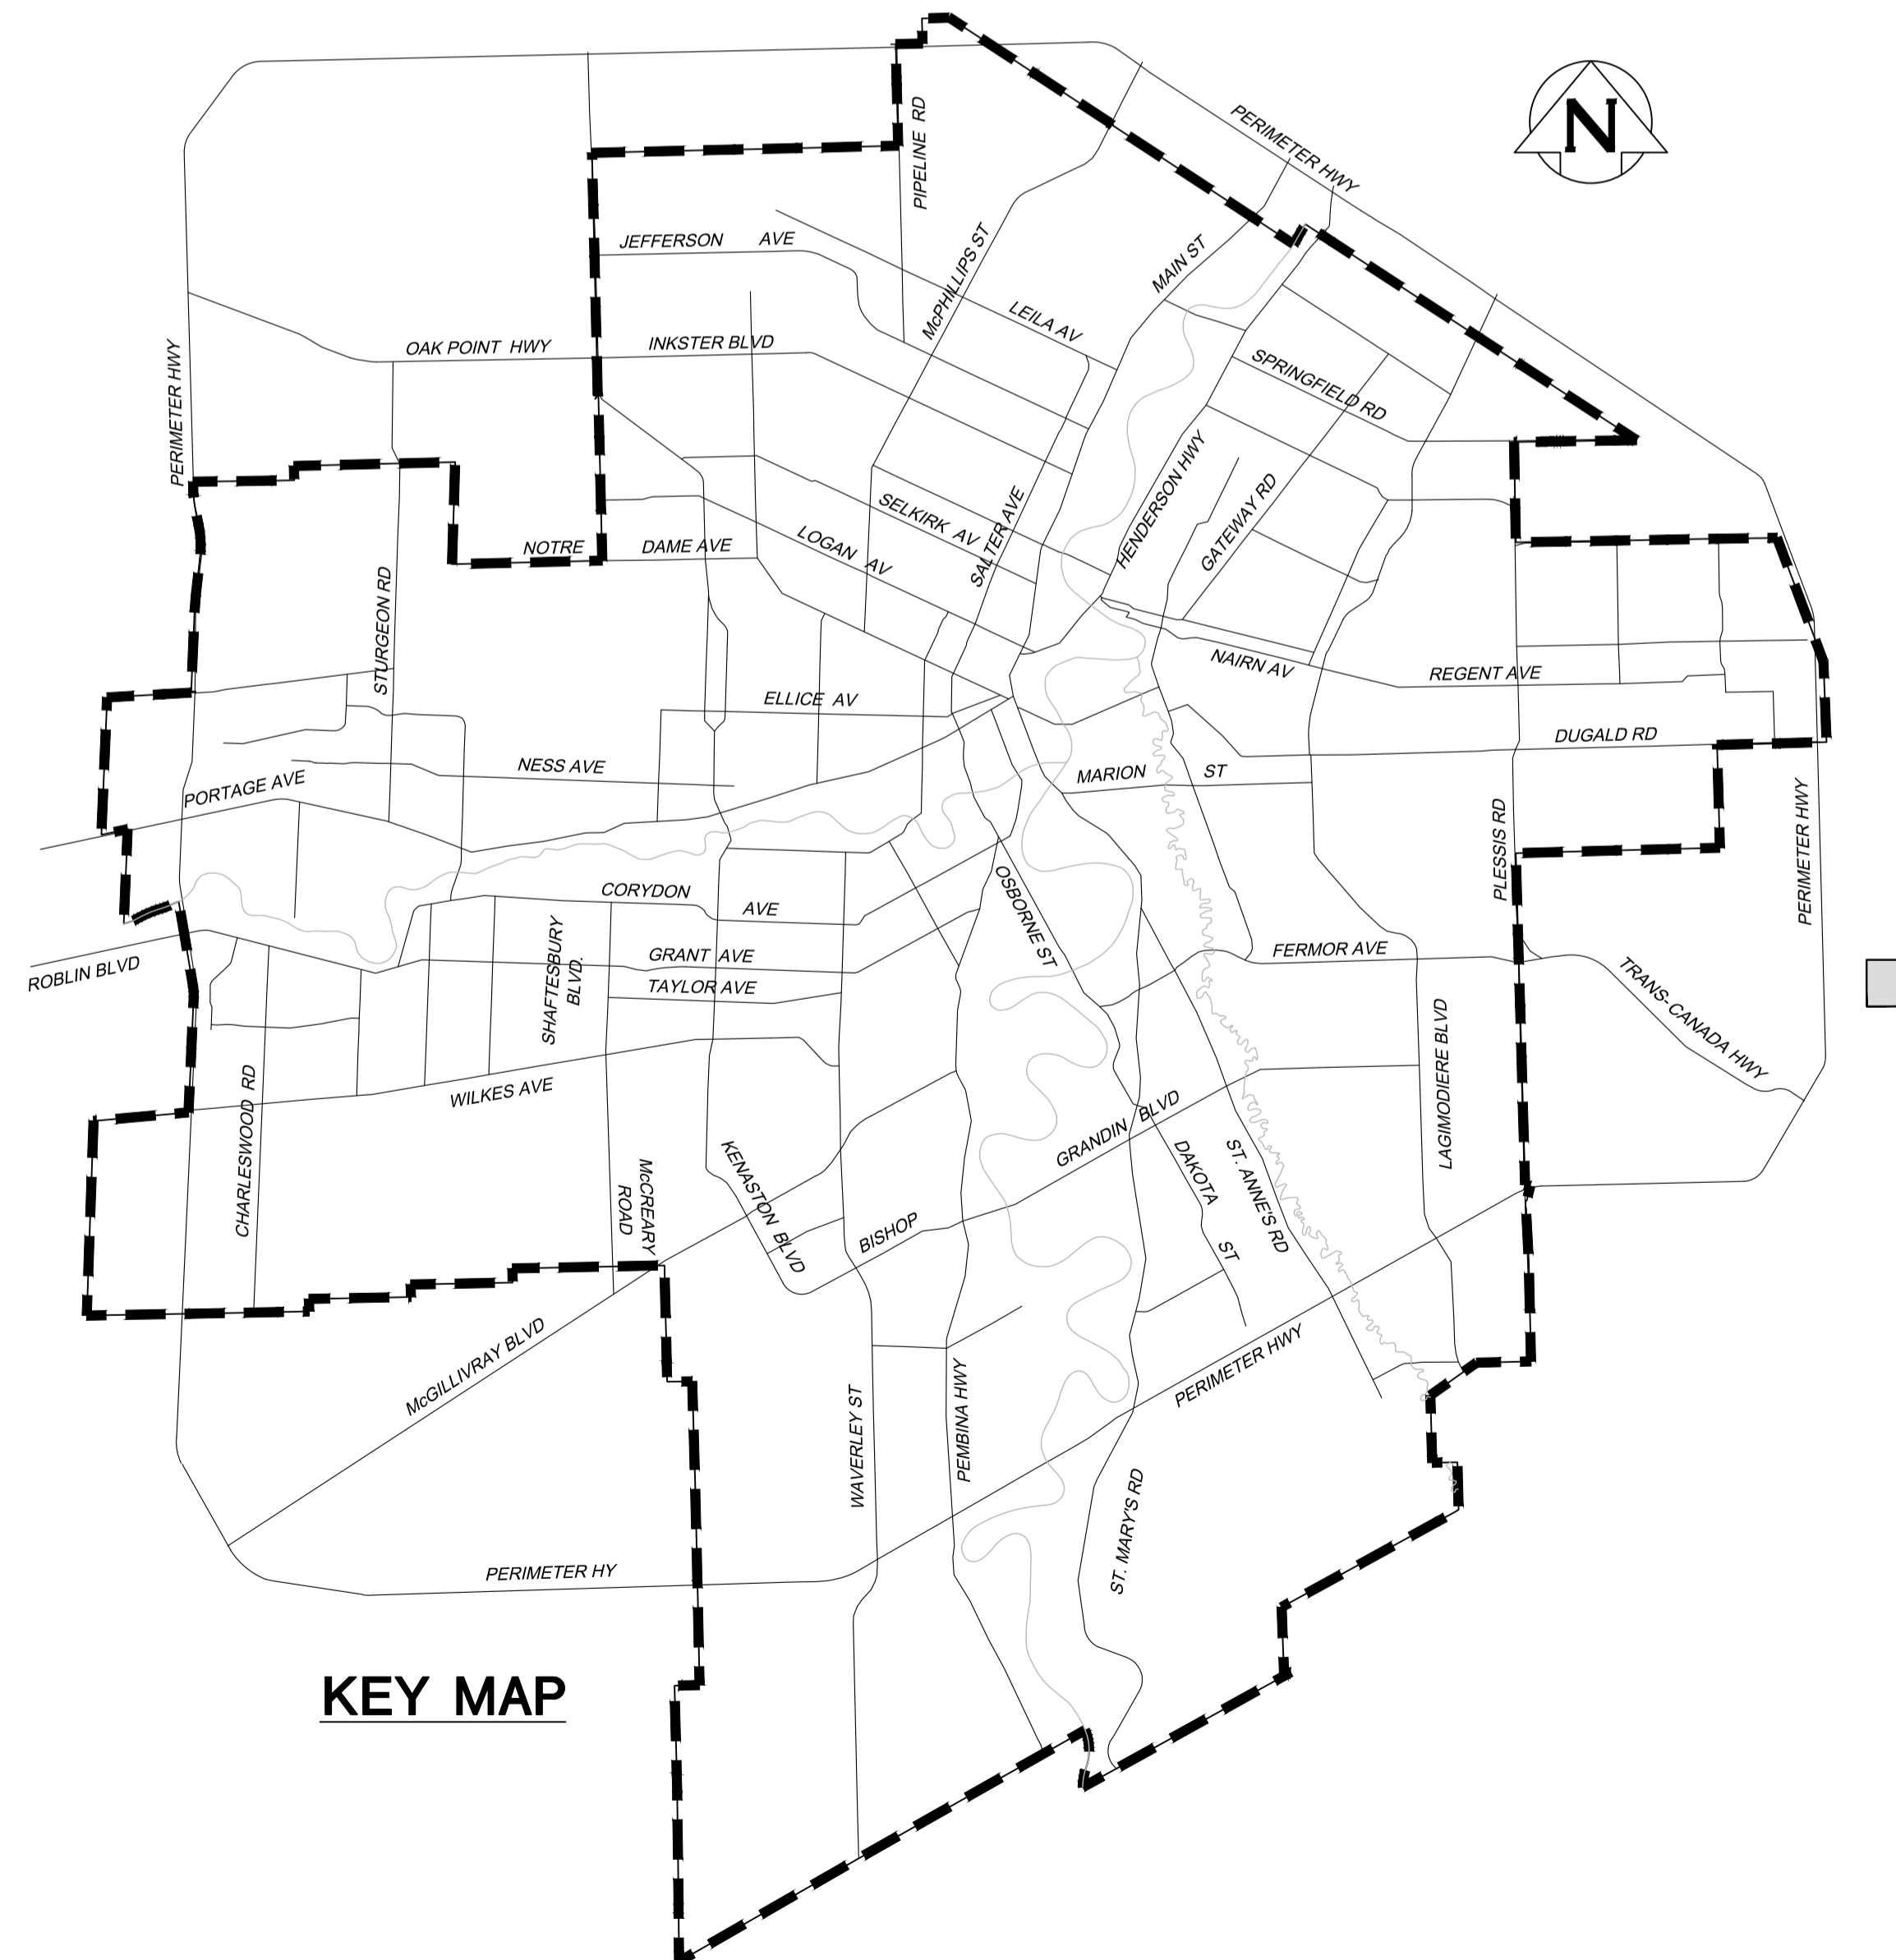

KEY MAP