


DRAWING LIST

- M0.1 DRAWING LIST, SYMBOL LEGEND AND SITE PLAN
- M1.1 PARTIAL MAIN FLOOR PLAN - HVAC - DEMOLITION AND NEW CONSTRUCTION
- M1.2 PARTIAL ROOF PLAN - HVAC - DEMOLITION AND NEW CONSTRUCTION
- M2.1 MECHANICAL SPECIFICATION AND SCHEDULE

HVAC LEGEND										
	SUPPLY									
	RETURN AIR DUCT UP / DOWN									
	EXHAUST / RELIEF AIR DUCT UP / DOWN									
	MANUAL BALANCING DAMPER									
	THERMOSTAT									
	NATURAL GAS									
	EQUIPMENT DESIGNATION									
	<table border="0"> <tr> <td>TYPE</td> <td>GRILLE / DIFFUSER TYPE</td> <td rowspan="4">} GRILLE OR DIFFUSER DESIGNATION</td> </tr> <tr> <td>NECK</td> <td>NECK SIZE</td> </tr> <tr> <td>QTY</td> <td>QUANTITY OR NUMBER OF</td> </tr> <tr> <td>FLOW</td> <td>FLOW RATE (CFM)</td> </tr> </table>	TYPE	GRILLE / DIFFUSER TYPE	} GRILLE OR DIFFUSER DESIGNATION	NECK	NECK SIZE	QTY	QUANTITY OR NUMBER OF	FLOW	FLOW RATE (CFM)
TYPE	GRILLE / DIFFUSER TYPE	} GRILLE OR DIFFUSER DESIGNATION								
NECK	NECK SIZE									
QTY	QUANTITY OR NUMBER OF									
FLOW	FLOW RATE (CFM)									

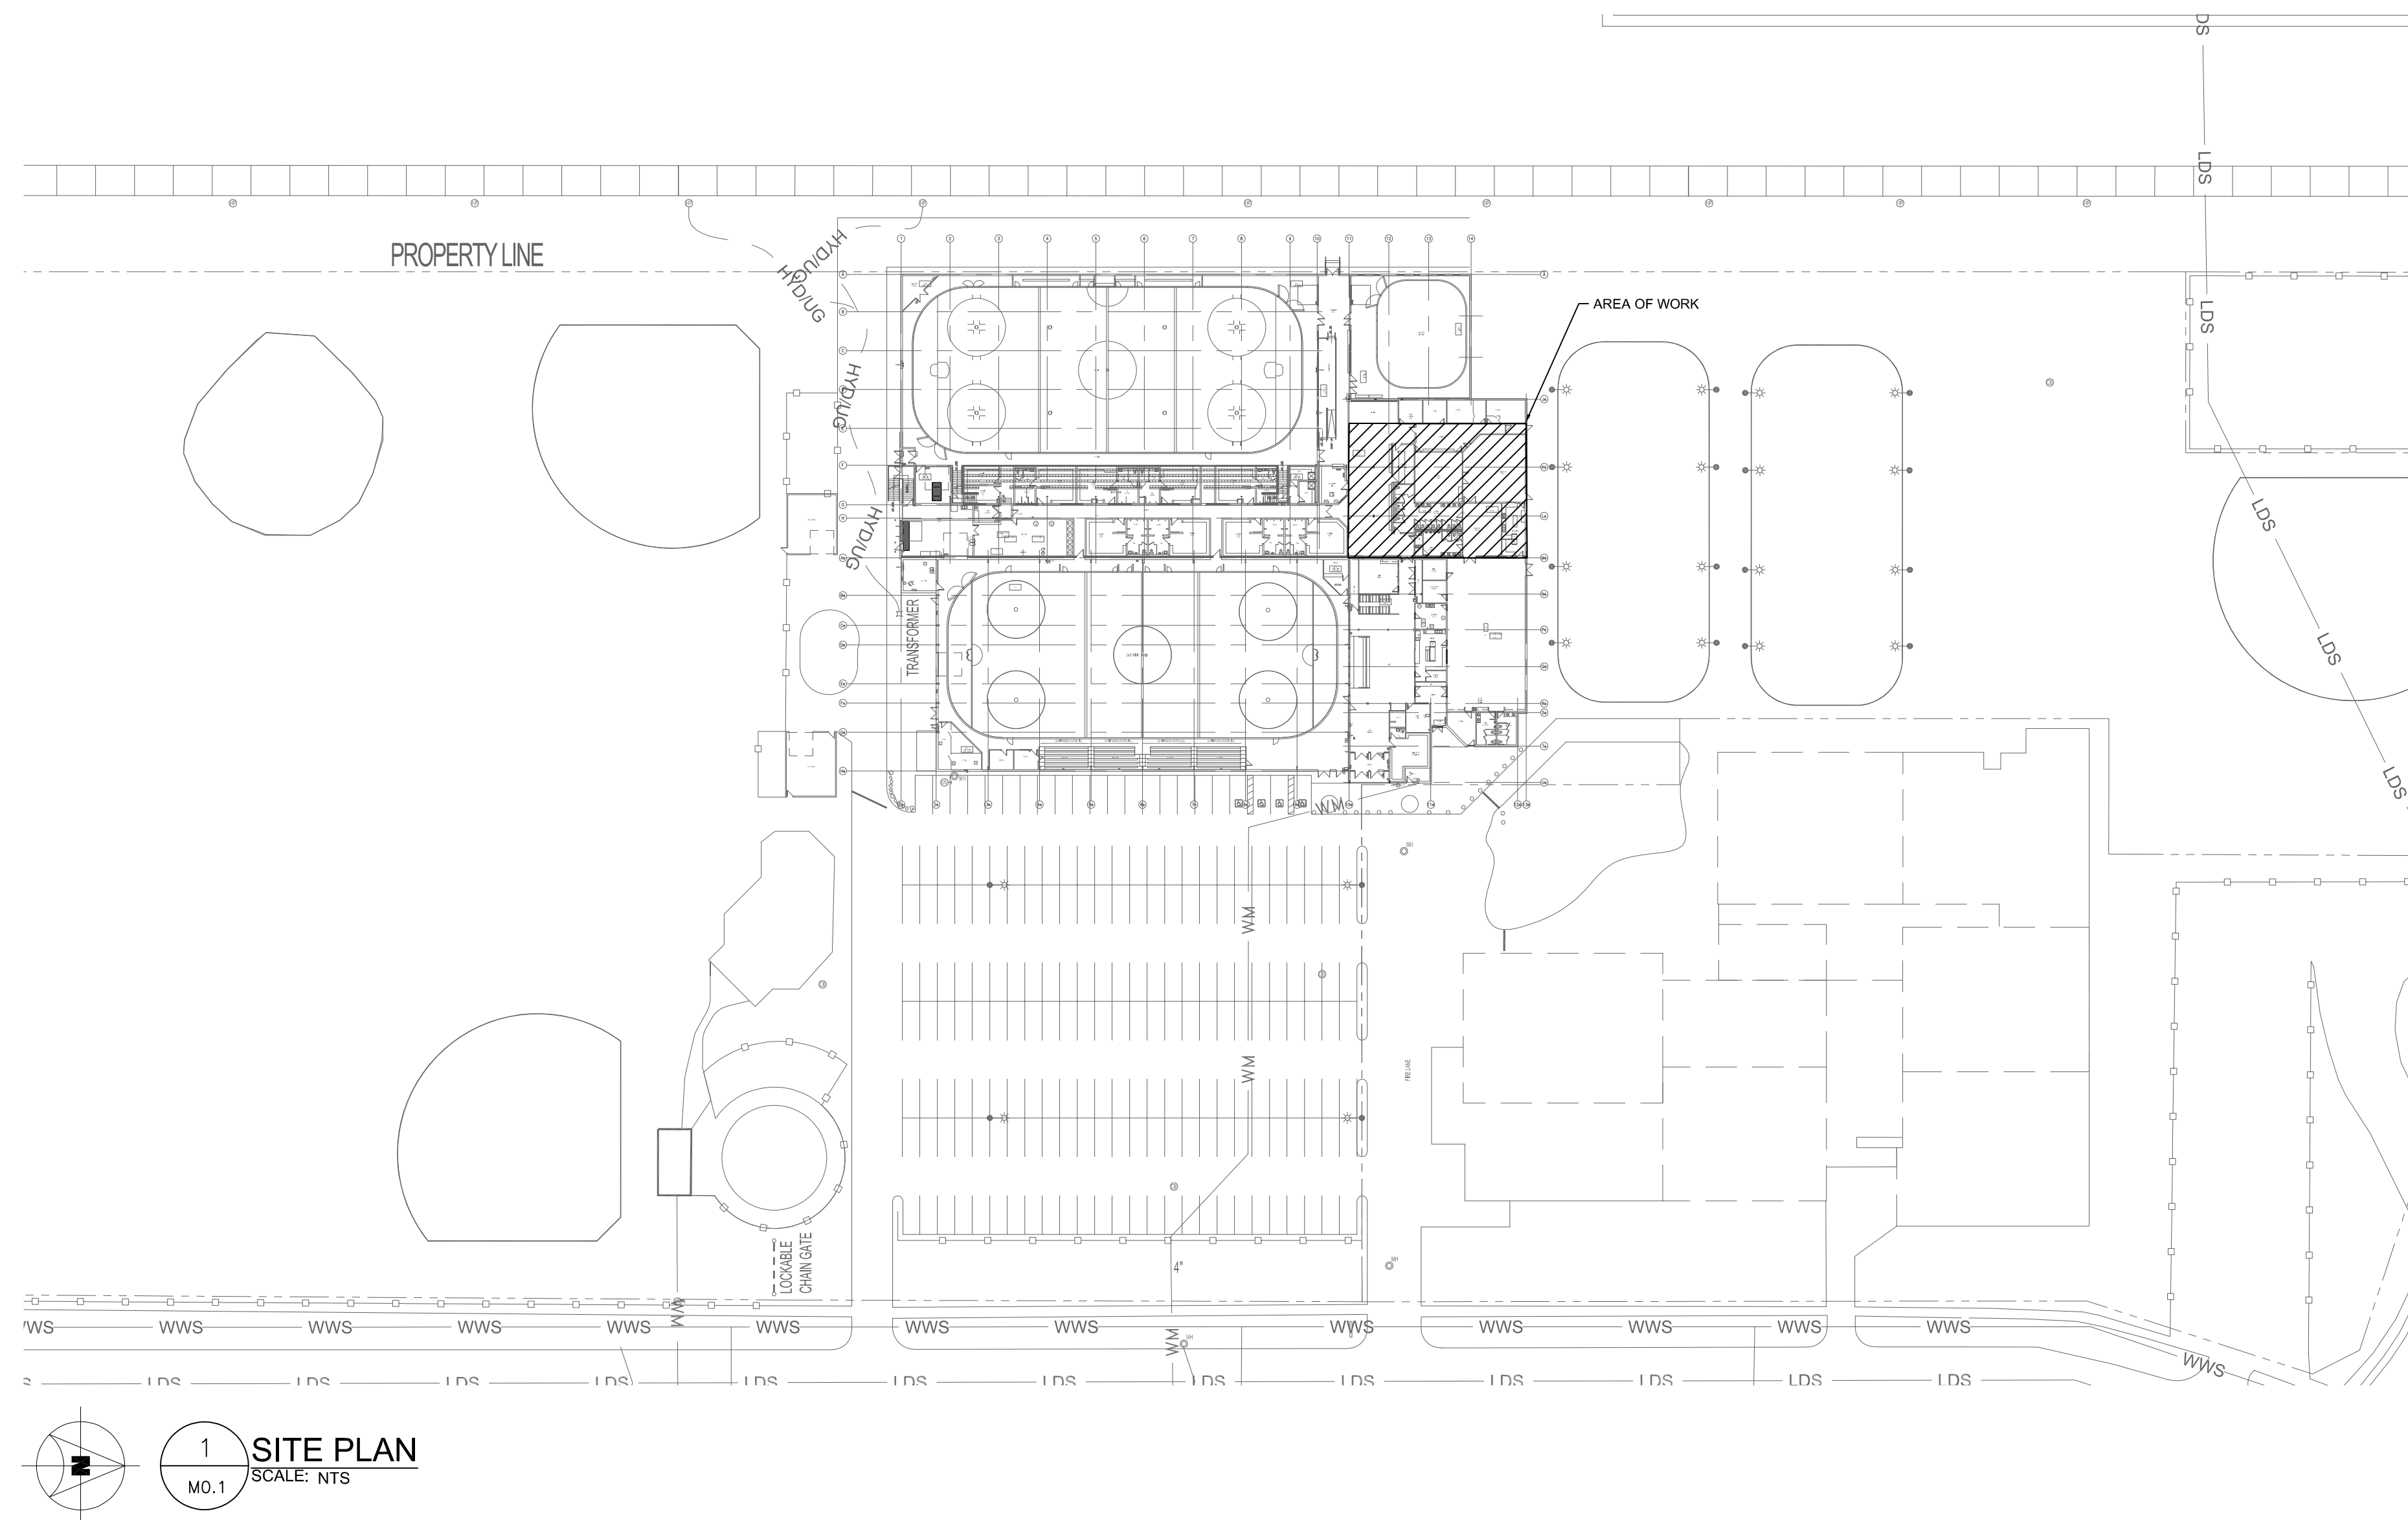

0	ISSUED FOR CONSTRUCTION	JH	13/12/22	<p>ENGINEERS GEO-SCIENTISTS MANITOBA Certificate of Authorization SMS Engineering Ltd. No. 166</p>	<p>PROVINCE OF MANITOBA REGISTERED PROFESSIONAL ENGINEER</p>	<p>770 Bradford Street Winnipeg, Canada (204) 775-0291 smseng.com</p>	Project Title SOUTHDALE CC RTU REPLACEMENT BID OPP. 648-2022	Drawing Title DRAWING LIST, SYMBOL LEGEND AND SITE PLAN	Drawn By IE	Revision Number 0
	LETTER OR NUMBER	DESCRIPTION	BY						DDMMYY	Checked By DW

P:\0 - NAME AND DATE OF FILE: C:\Users\jhorrocks\OneDrive - SMS Engineering Ltd.\Projects\648-2022\Drawings\01 - DRAWING LIST\01 - DRAWING LIST.dwg
 LAYOUT: M0.1 LAST SAVED BY: jhorrocks DATE PLOTTED: 2022-08-04 10:30:00 AM