




**1** ROOF DETAIL AT CONCRETE TEE  
1-0601B-80076-001 1:5

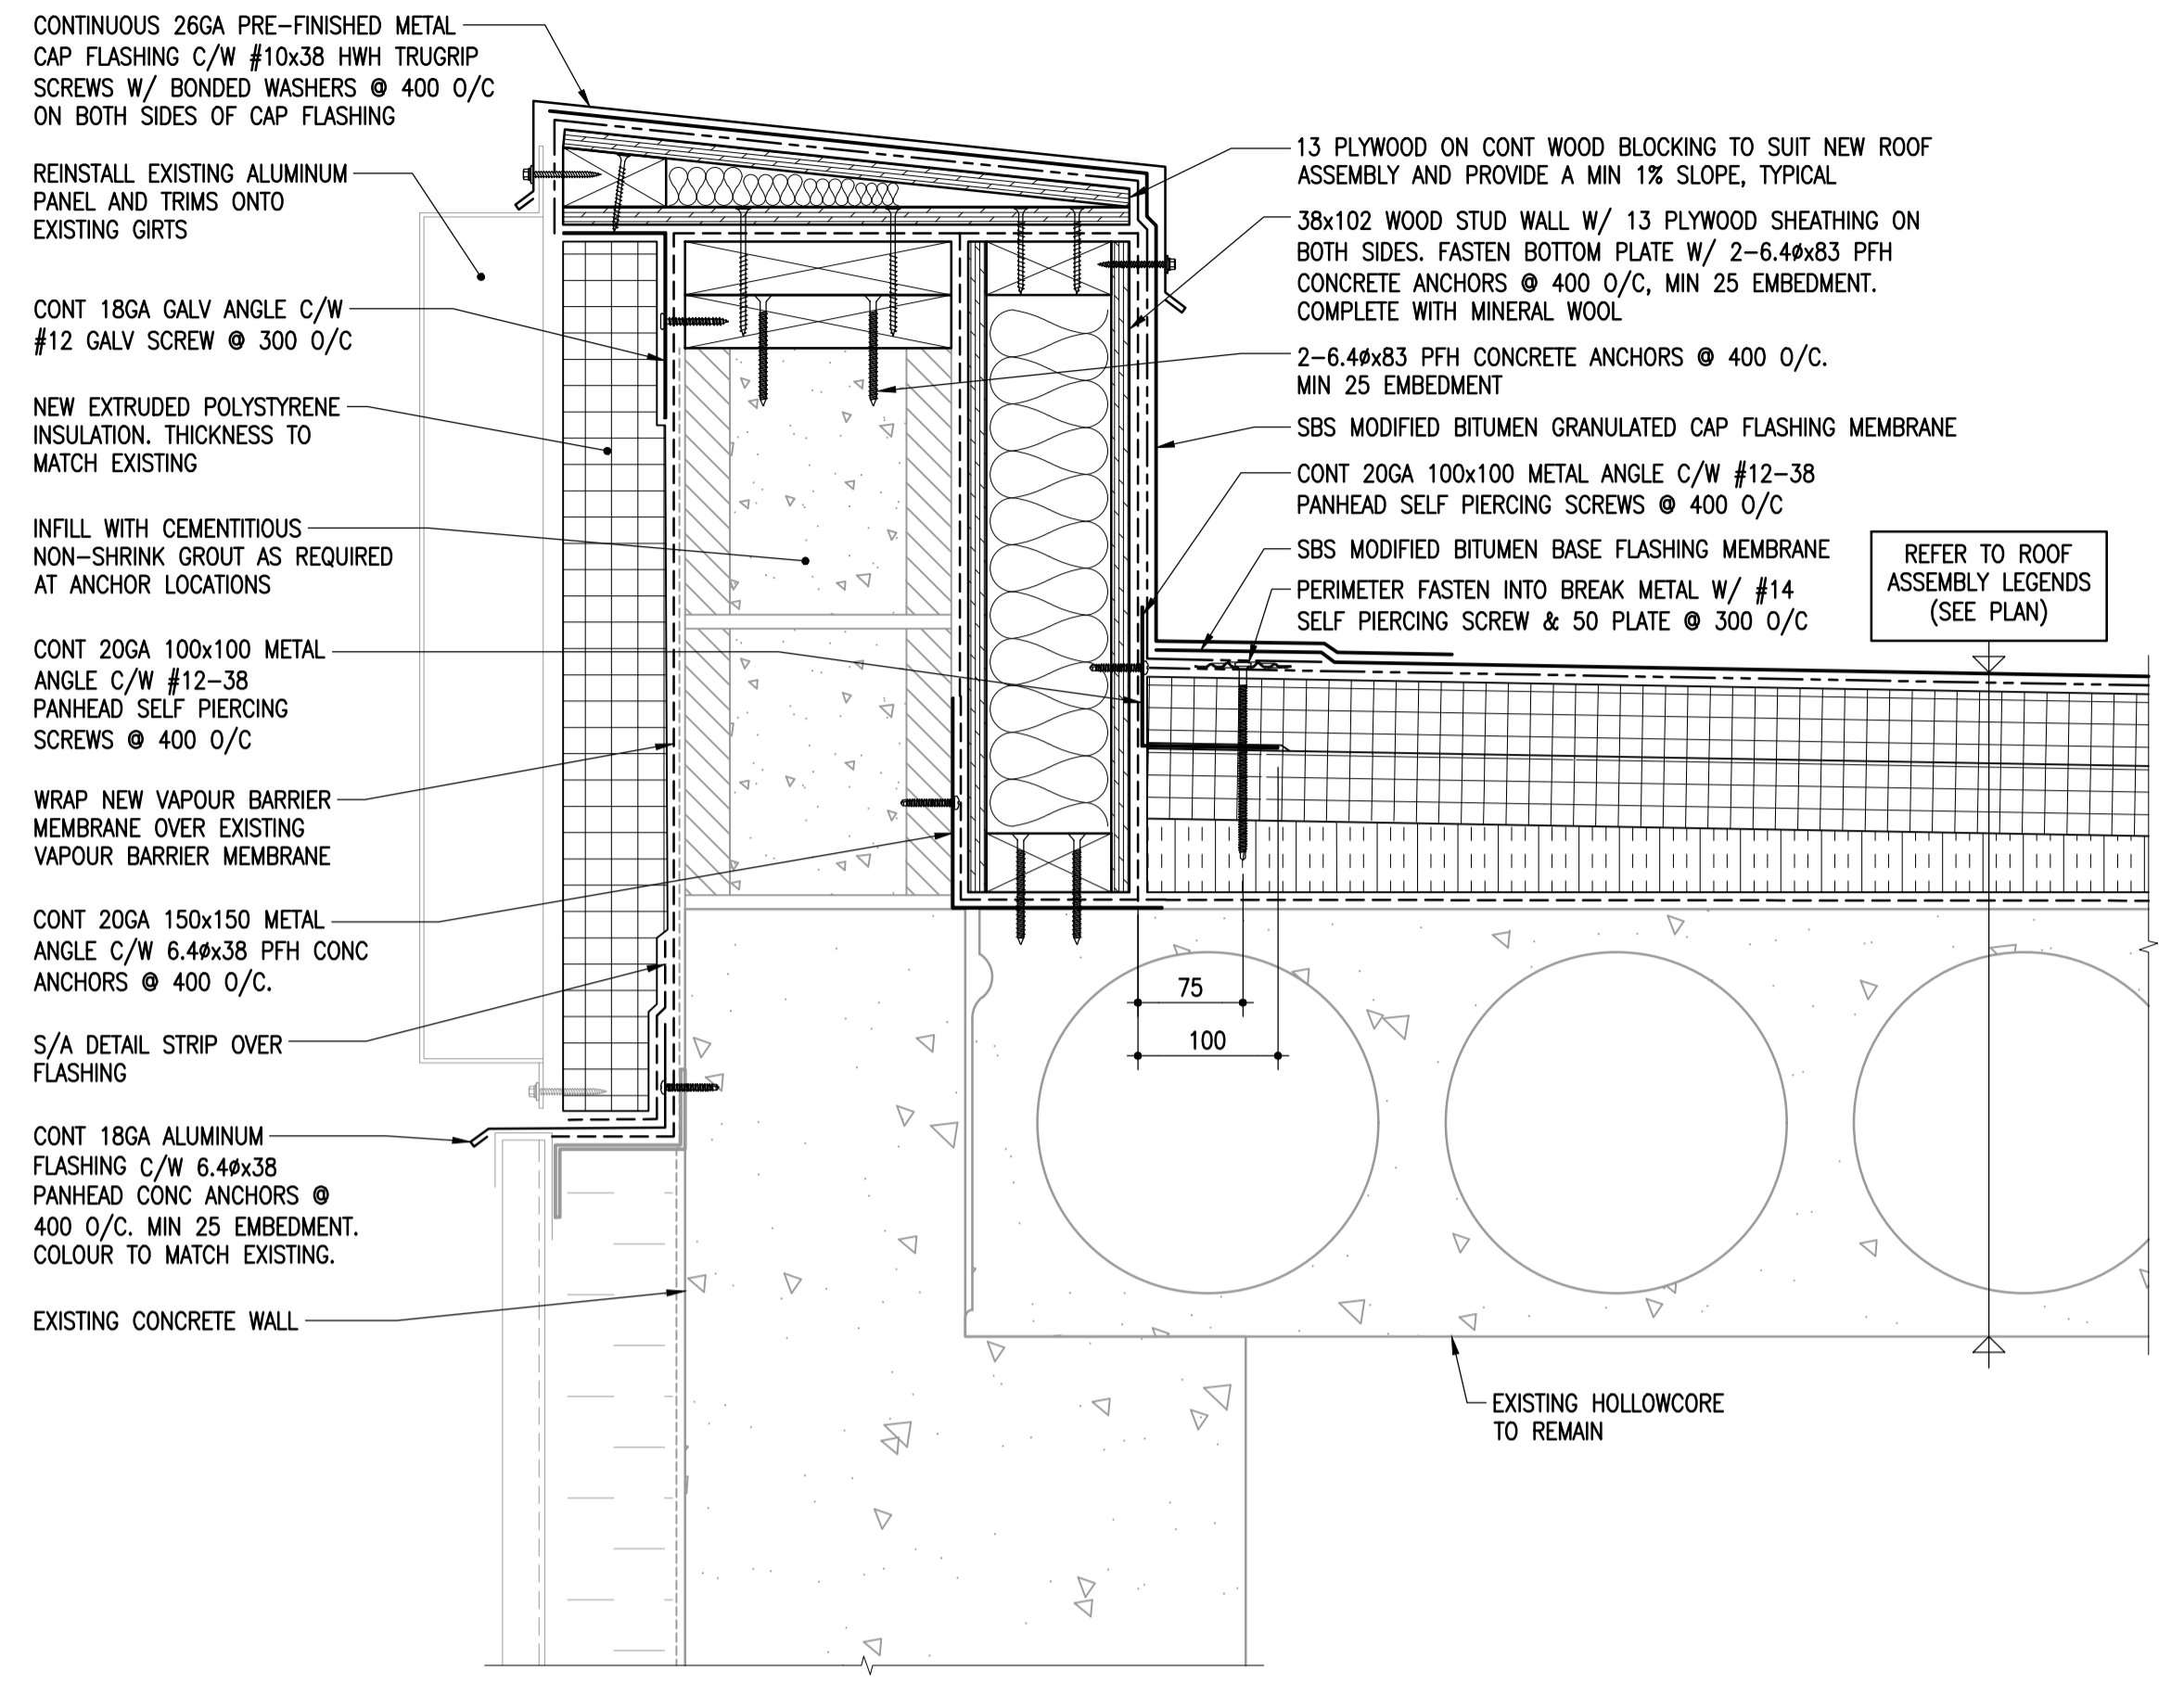

**2** ROOF DETAIL AT HOLLOWCORE  
1-0601B-80076-001 1:5

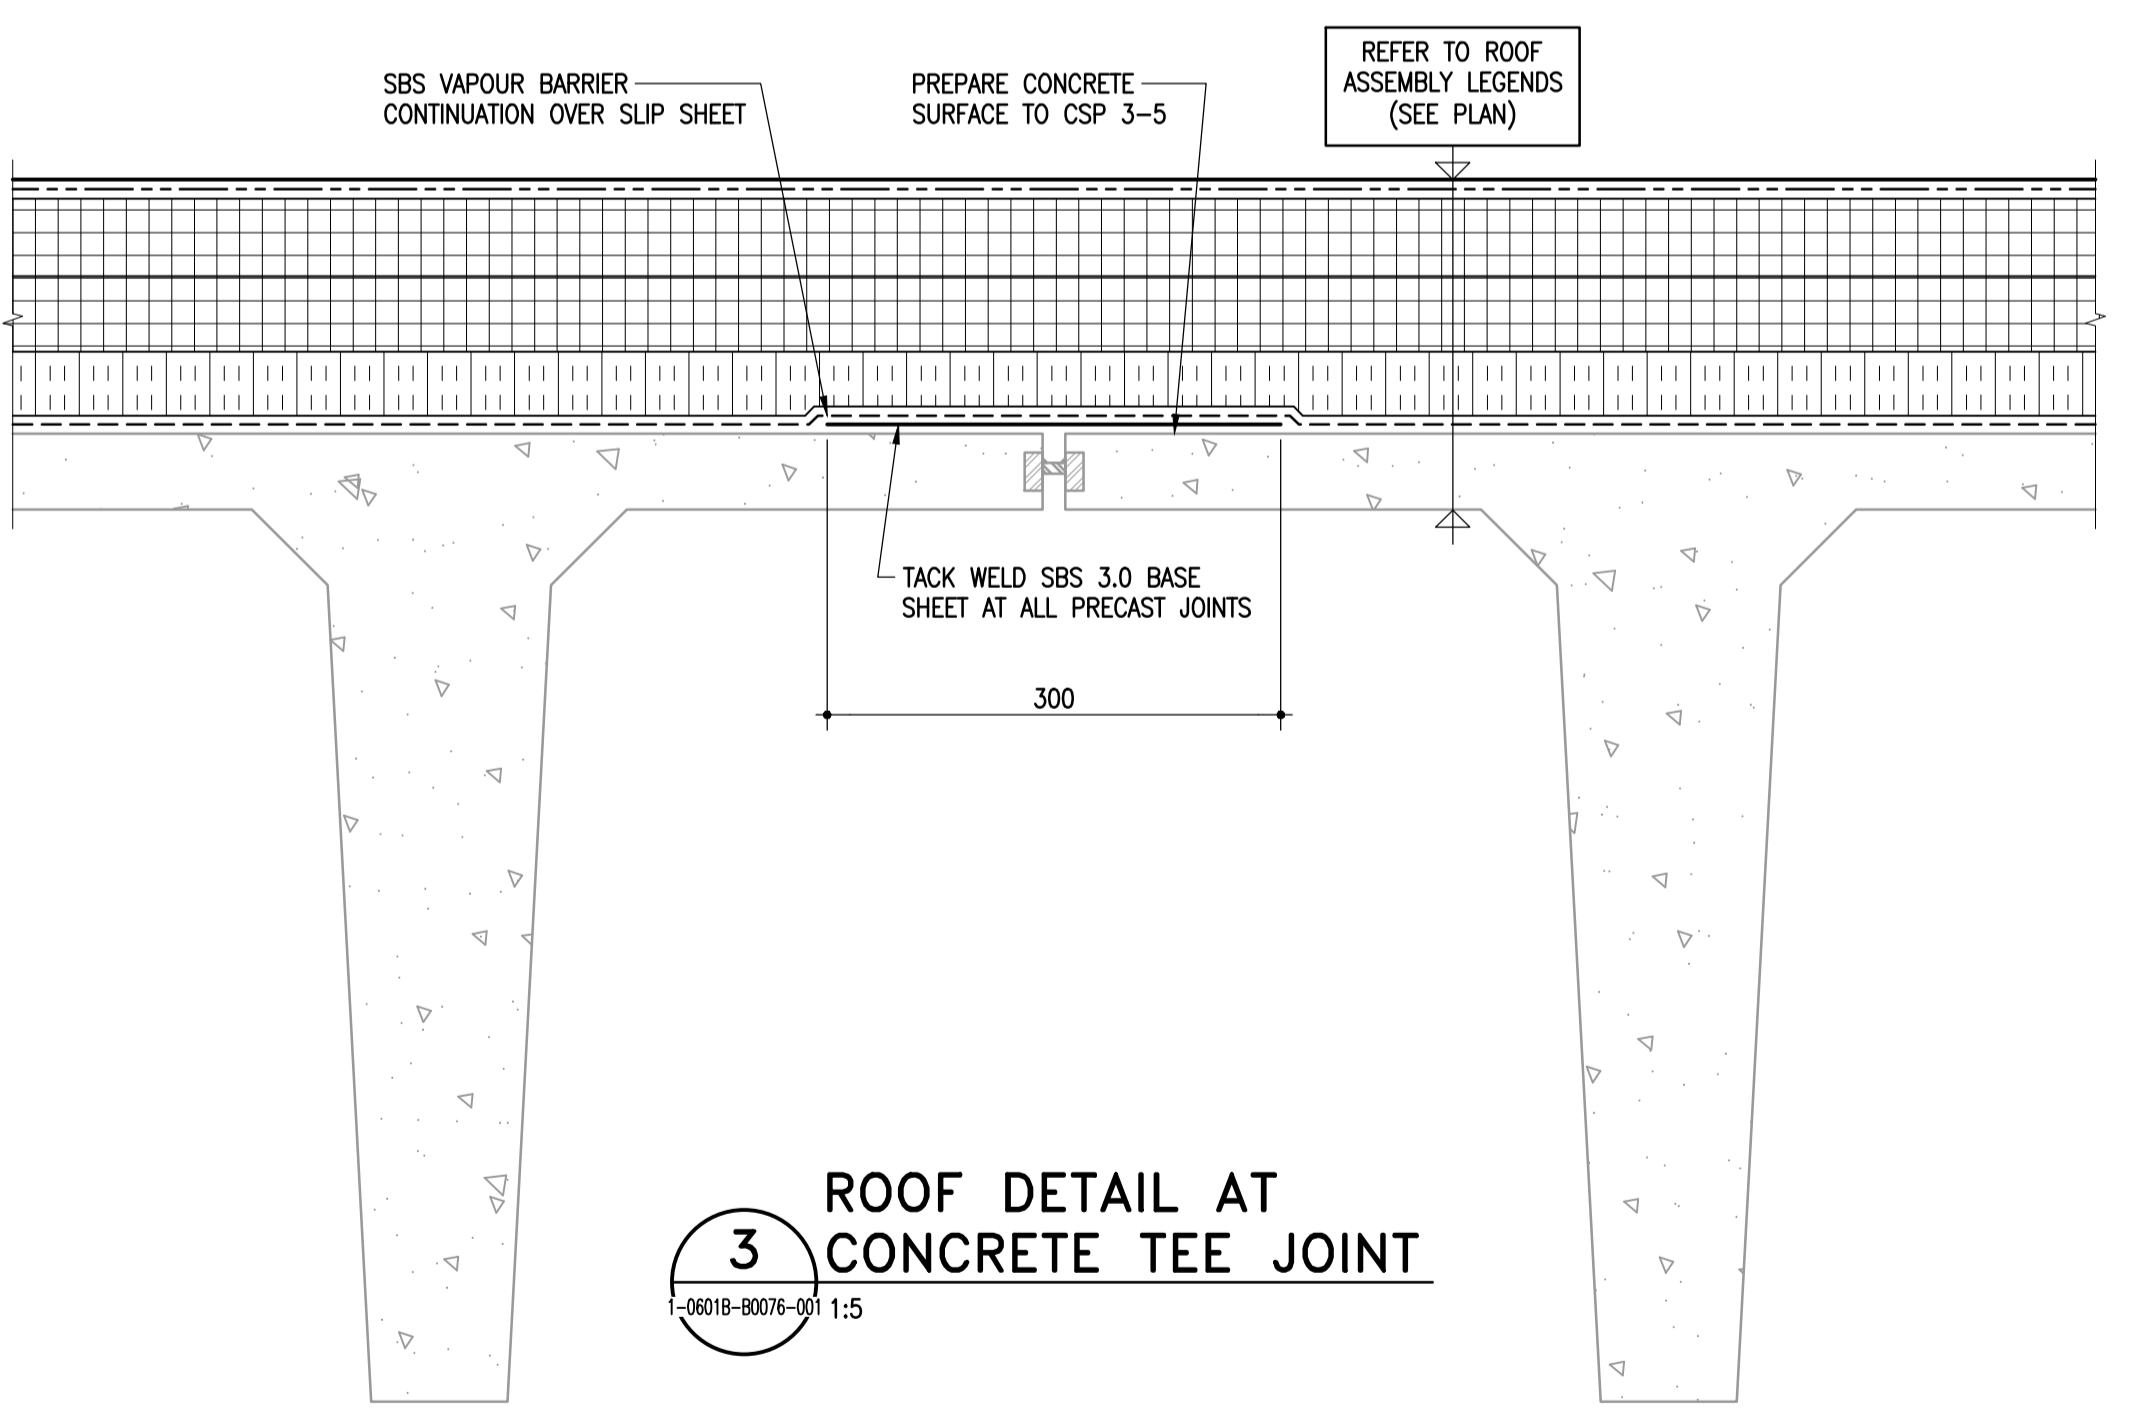

**3** ROOF DETAIL AT CONCRETE TEE JOINT  
1-0601B-80076-001 1:5

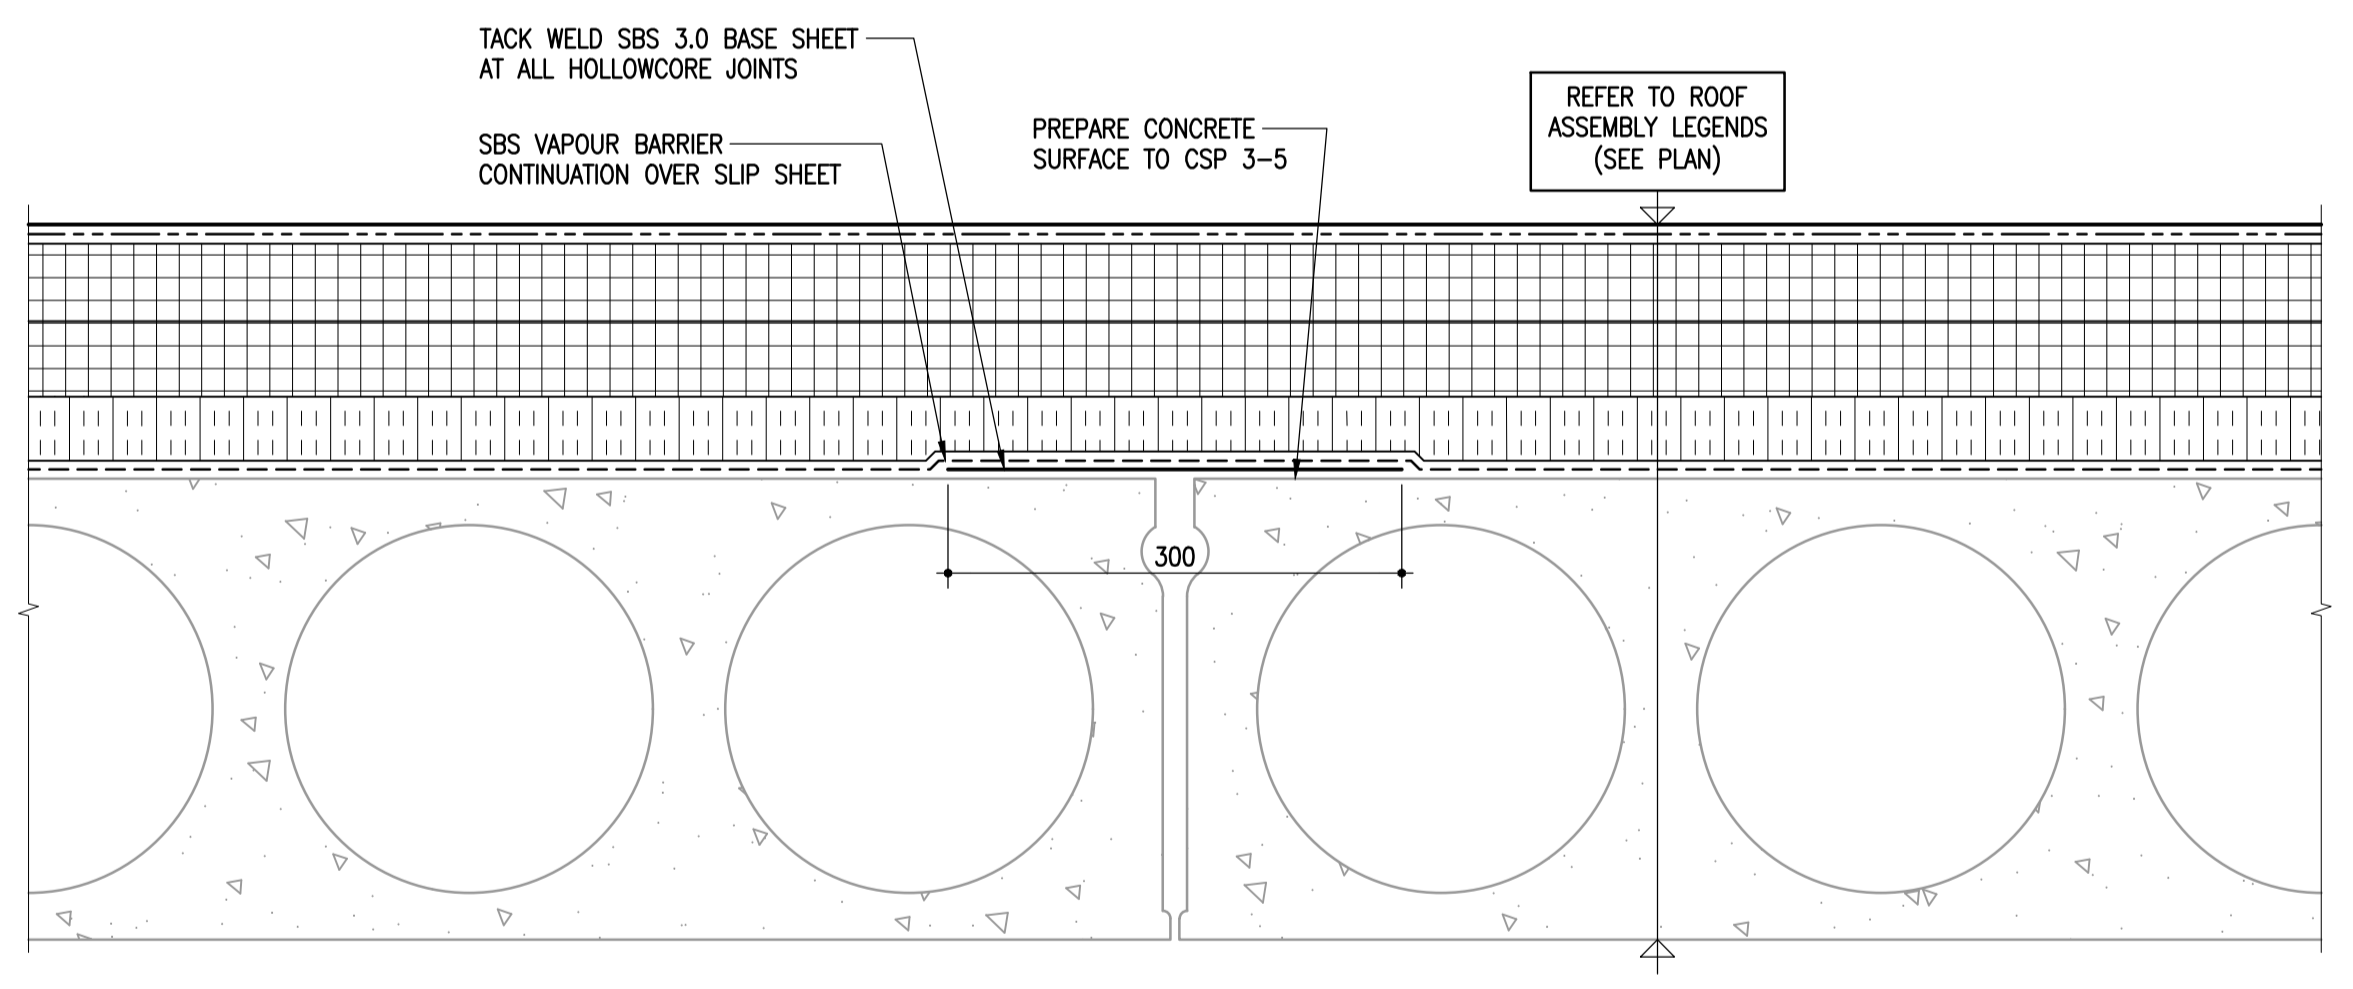

**4** ROOF DETAIL AT HOLLOWCORE JOINT  
1-0601B-80076-001 1:5

10		
9		
8		
7		
6		
5		
4	1-0601B-80071-001	BUILDING WI & WM ROOF PLAN
3	1-0601B-80069-001	BUILDING WF ROOF PLAN
2	1-0601B-80068-001	BUILDING WF, WR, WO & WC ROOF PLAN
1	1-0601B-80004-001	BUILDING NOTES, SCHEDULE & LEGENDS
NO.	DRAWING NUMBER	REFERENCE DRAWING TITLE
REFERENCE DRAWINGS		

**EG ENGINEERS GEOSCIENTISTS MANITOBA**  
Certificate of Authorization  
Crosier Kilgour & Partners Ltd.  
No. 235

B.M. ELEV.					
DESIGNED BY	GJH	CHECKED BY	JAW		
DRAWN BY	LOL	APPROVED BY	GJH		
SCALE:	1:5	RELEASED FOR CONSTRUCTION BY:			
NO.	ISSUED FOR TENDER	23/03/21	GJH	DATE	2023/03/21
NO.	REVISIONS			DATE	

ENGINEER'S SEAL  
PROVINCE OF MANITOBA  
REGISTERED PROFESSIONAL ENGINEER  
**J.A. WELLS**  
23/03/21  
CONSULTANT DRAWING NO. S4.1

**THE CITY OF WINNIPEG**  
WATER AND WASTE DEPARTMENT  
ENGINEERING DIVISION

DRINKING WATER TREATMENT PLANT  
MAIN BUILDING  
ROOF REPLACEMENT

BUILDING ROOF  
DETAILS 1 OF 9

CITY FILE NUMBER **W-1049**  
SHEET 1 OF 9  
CITY DRAWING NUMBER 1-0601B-80076-001