



**1 PARAPET ROOF DETAIL AT PENTHOUSE**

1-0601B-80076-005 1:5

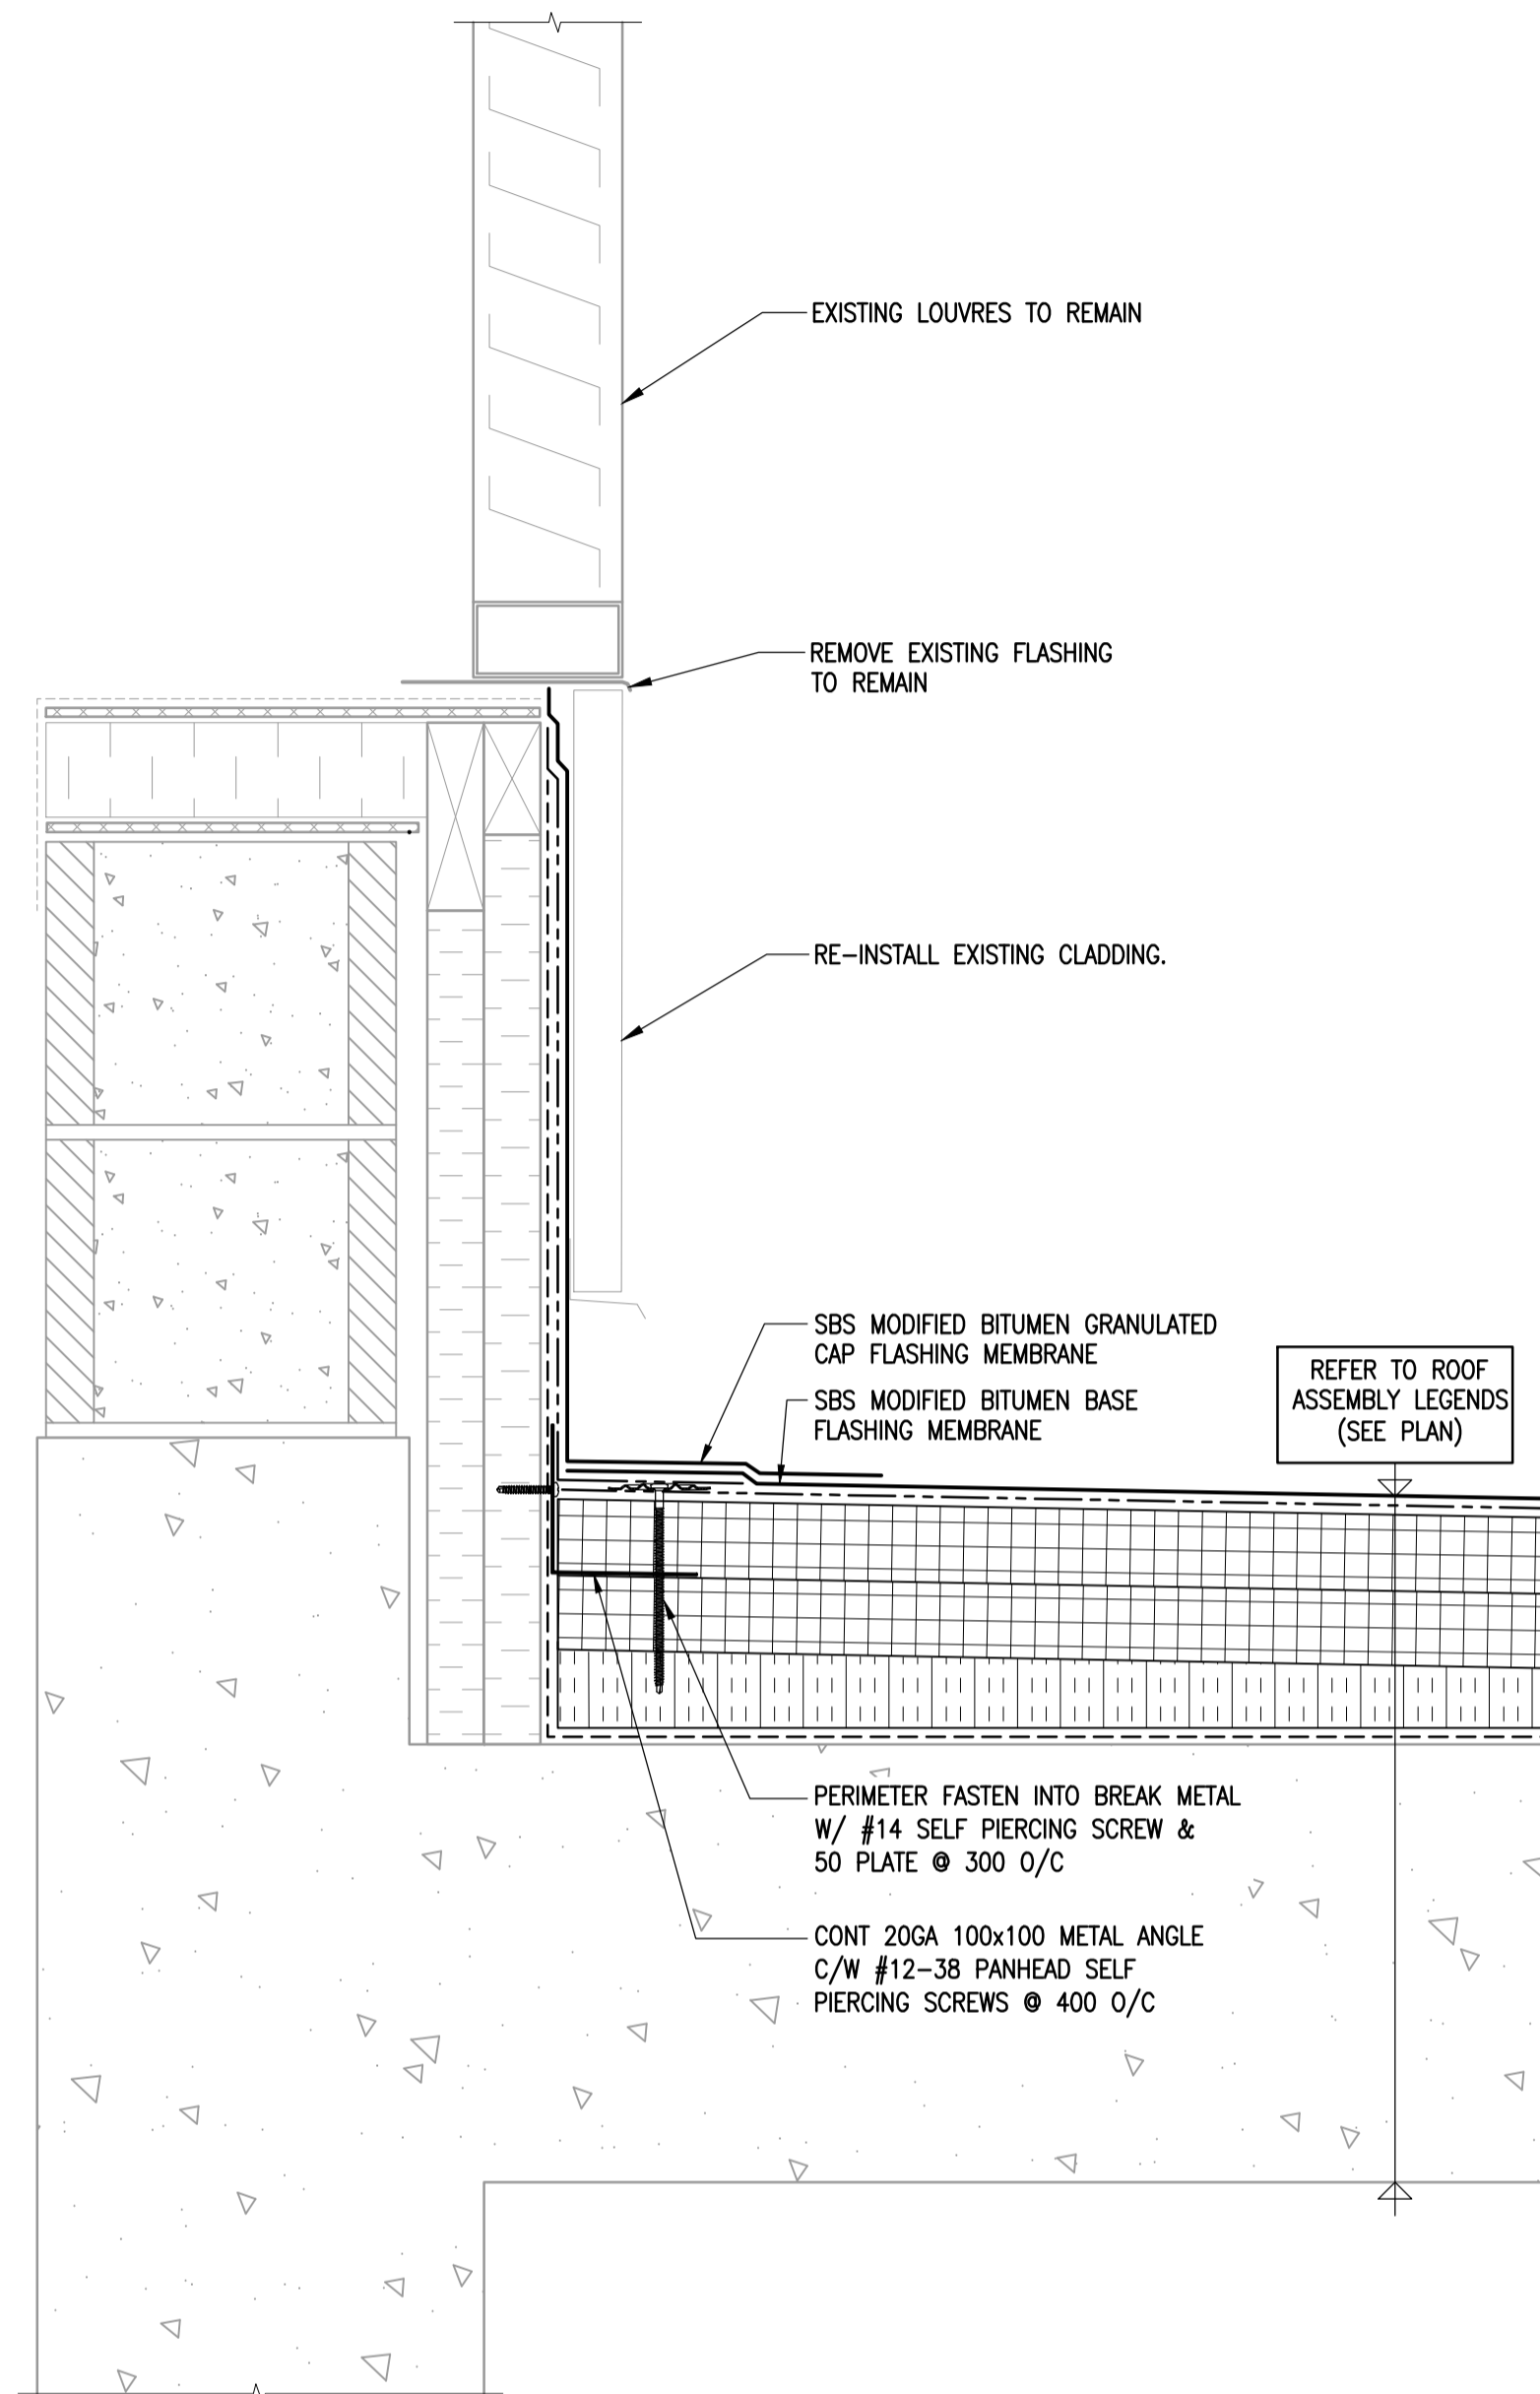


**3 ROOFING TIE-IN DETAIL (AT LOUVRES)**

1-0601B-80076-005 1:5

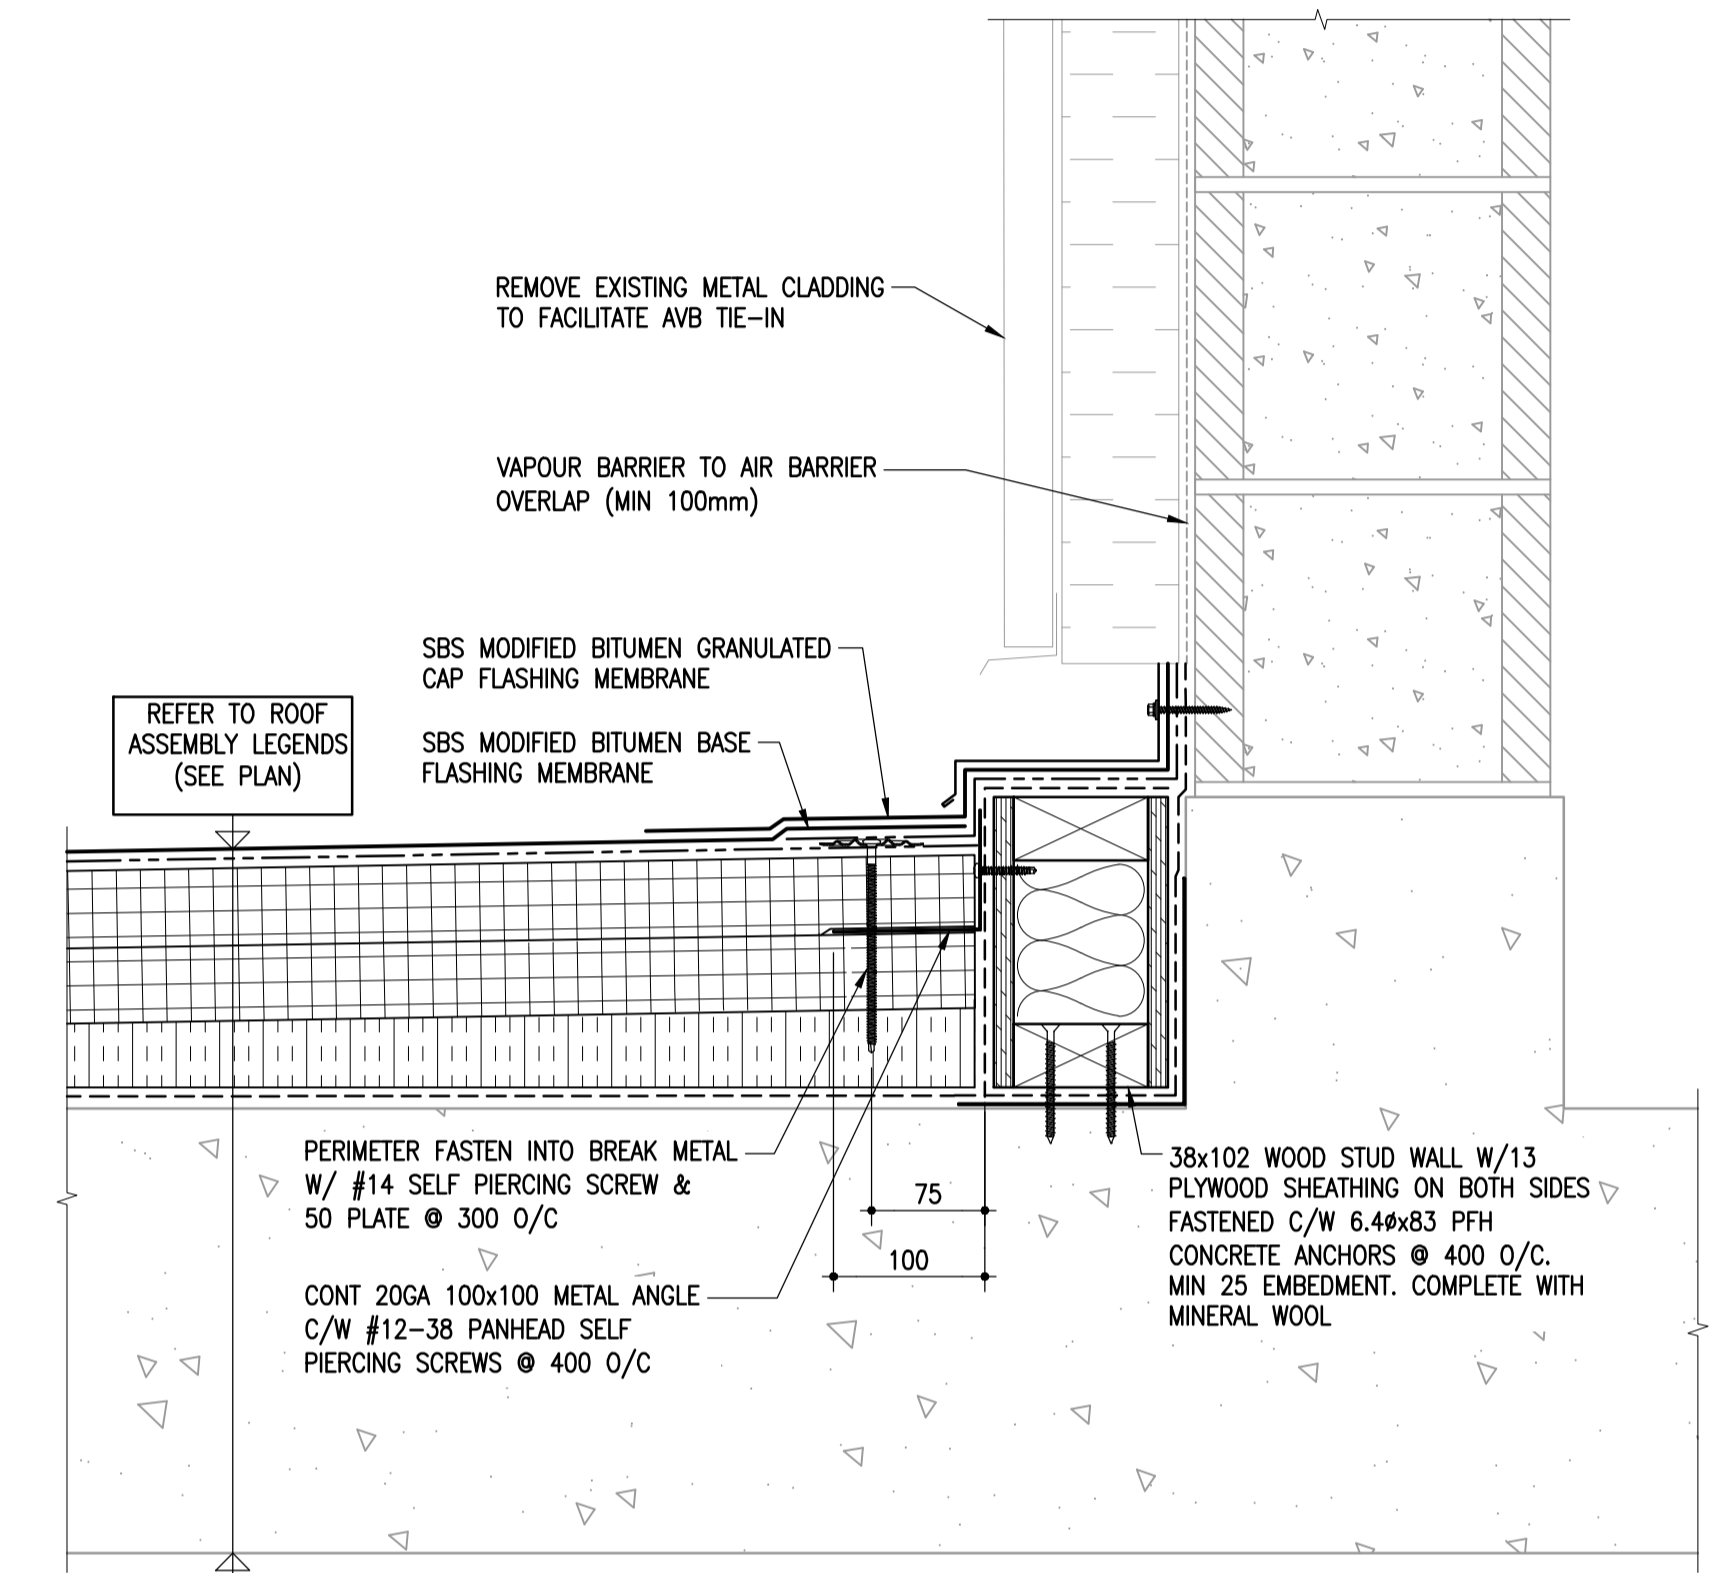

**4 ROOF/WALL INTERFACE TIE-IN DETAIL**

1-0601B-80076-005 1:5

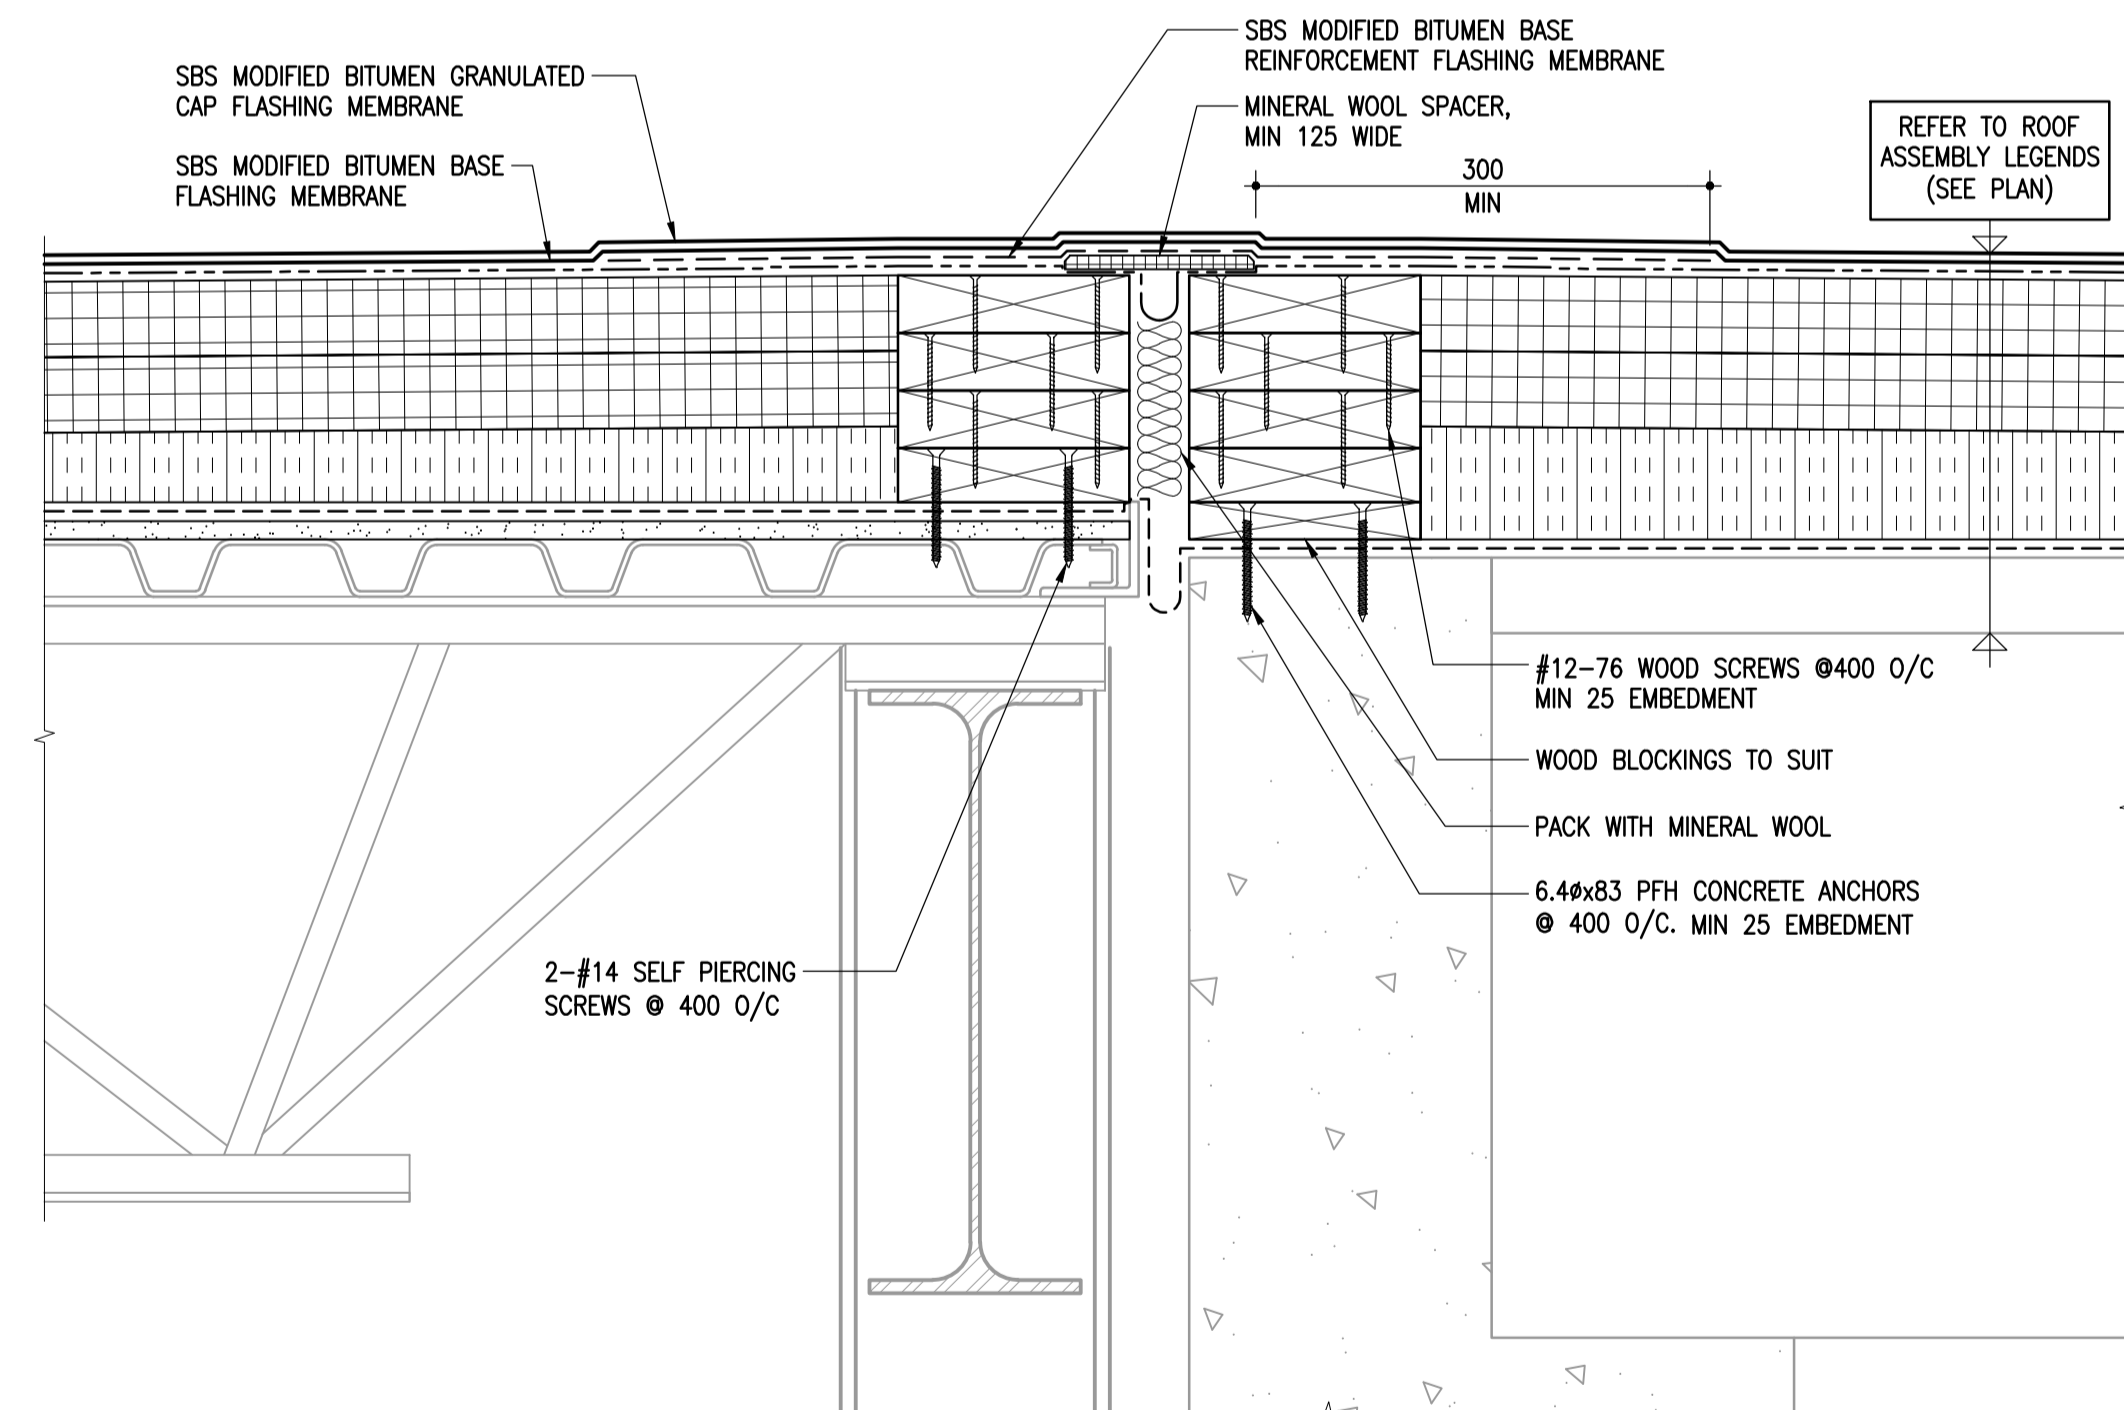

**2 ROOF TIE-IN AT SAME ELEVATION**

1-0601B-80076-005 1:5

10		
9		
8		
7		
6		
5		
4		
3	1-0601B-80071-001	BUILDING WI & WM ROOF PLAN
2	1-0601B-80070-001	BUILDING WA ROOF PLAN
1	1-0601B-G0004-001	BUILDING NOTES, SCHEDULE & LEGENDS
NO.	DRAWING NUMBER	REFERENCE DRAWING TITLE
REFERENCE DRAWINGS		

**EG ENGINEERS GEOSCIENTISTS MANITOBA**  
 Certificate of Authorization  
 Crozier Kilgour & Partners Ltd.  
 No. 235

B.M. ELEV.					
DESIGNED BY	GJH	CHECKED BY	JAW	300-275 Carlton Street Winnipeg, Manitoba R3C 5R6 T 204-943-7501 F 204-943-7507 2022-1008	<b>Crosier Kilgour &amp; Partners Ltd.</b> CONSULTING STRUCTURAL ENGINEERS
DRAWN BY	LOL	APPROVED BY	GJH		
SCALE:	1:5	RELEASED FOR CONSTRUCTION BY:			
00	ISSUED FOR TENDER	23/03/21	GJH		
NO.	REVISIONS	DATE	BY	DATE	2023/03/21

ENGINEER'S SEAL  
 PROVINCE OF MANITOBA  
**J.A. WELLS**  
 23/03/21  
 REGISTERED PROFESSIONAL ENGINEER  
 CONSULTANT DRAWING NO. S4.5

**THE CITY OF WINNIPEG**  
 WATER AND WASTE DEPARTMENT  
 ENGINEERING DIVISION  
**Winnipeg**  
 DRINKING WATER TREATMENT PLANT  
 MAIN BUILDING  
 ROOF REPLACEMENT  
 BUILDING ROOF  
 DETAILS 5 OF 9  
 CITY FILE NUMBER **W-1049**  
 SHEET 5 OF 9  
 CITY DRAWING NUMBER 1-0601B-80076-005