




1 ROOF SECTION AT CLERESTORY
1-0601B-80076-006 1:10

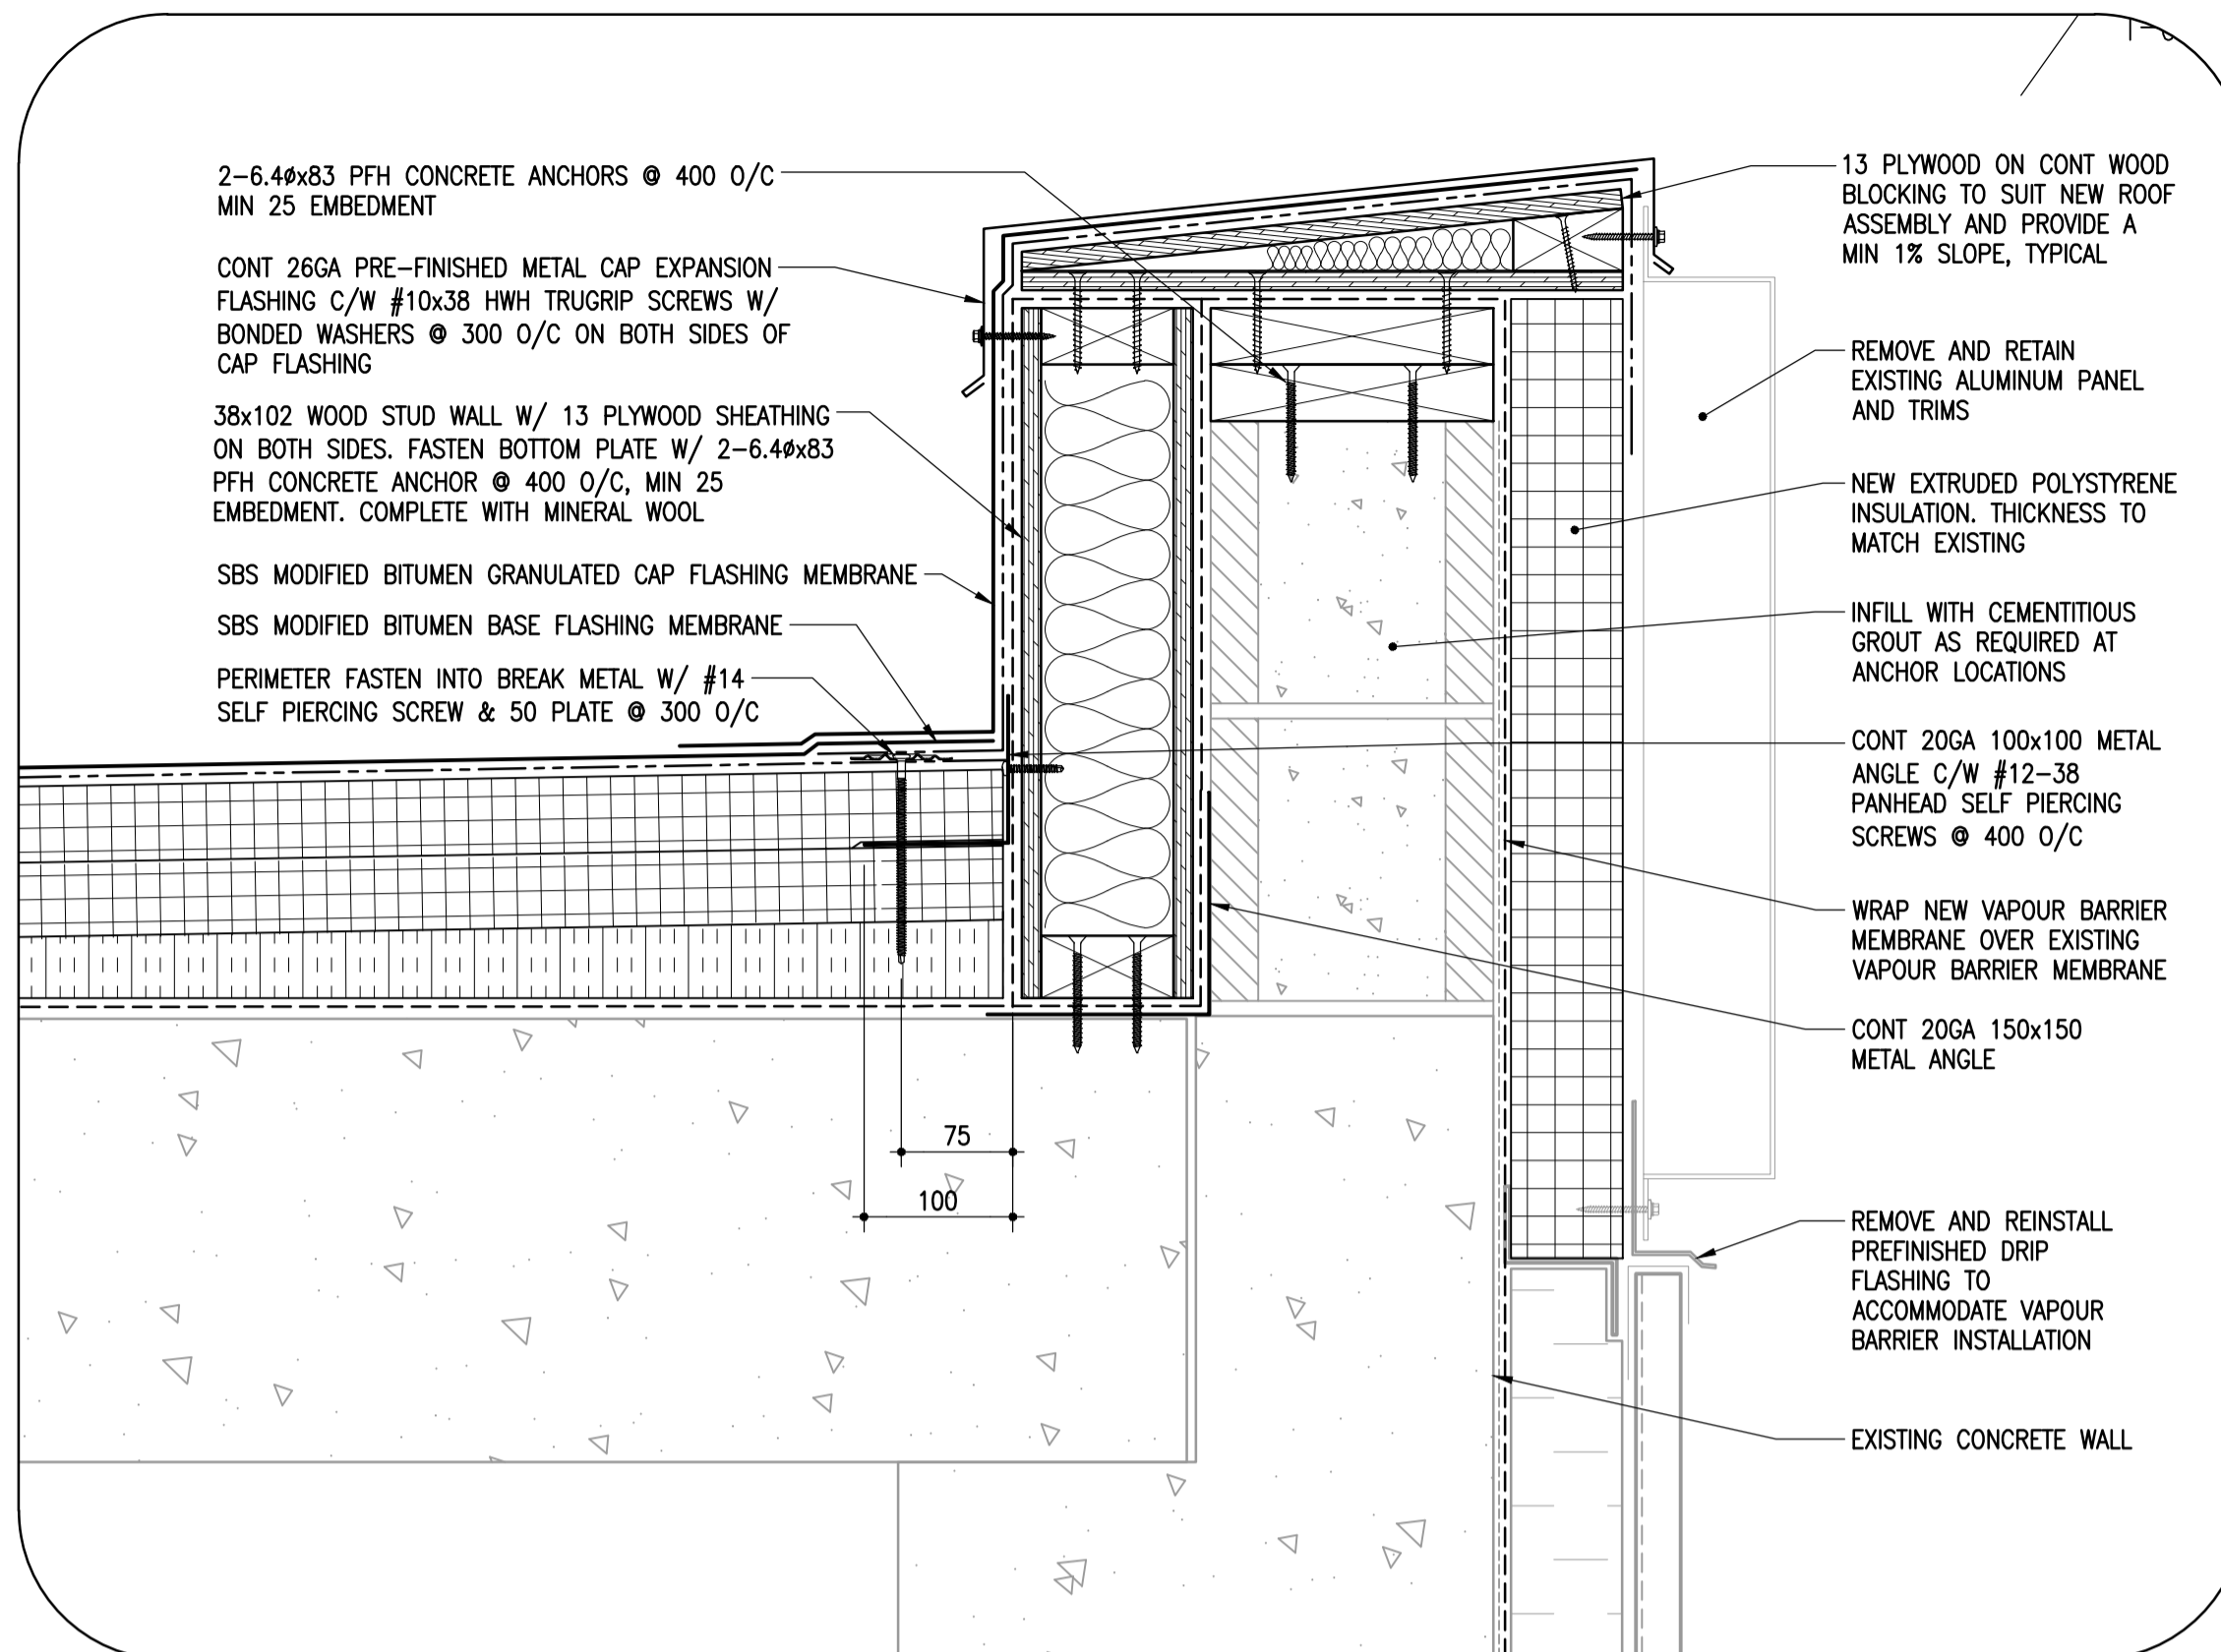


A PARAPET DETAIL
1-0601B-80076-006 1:5

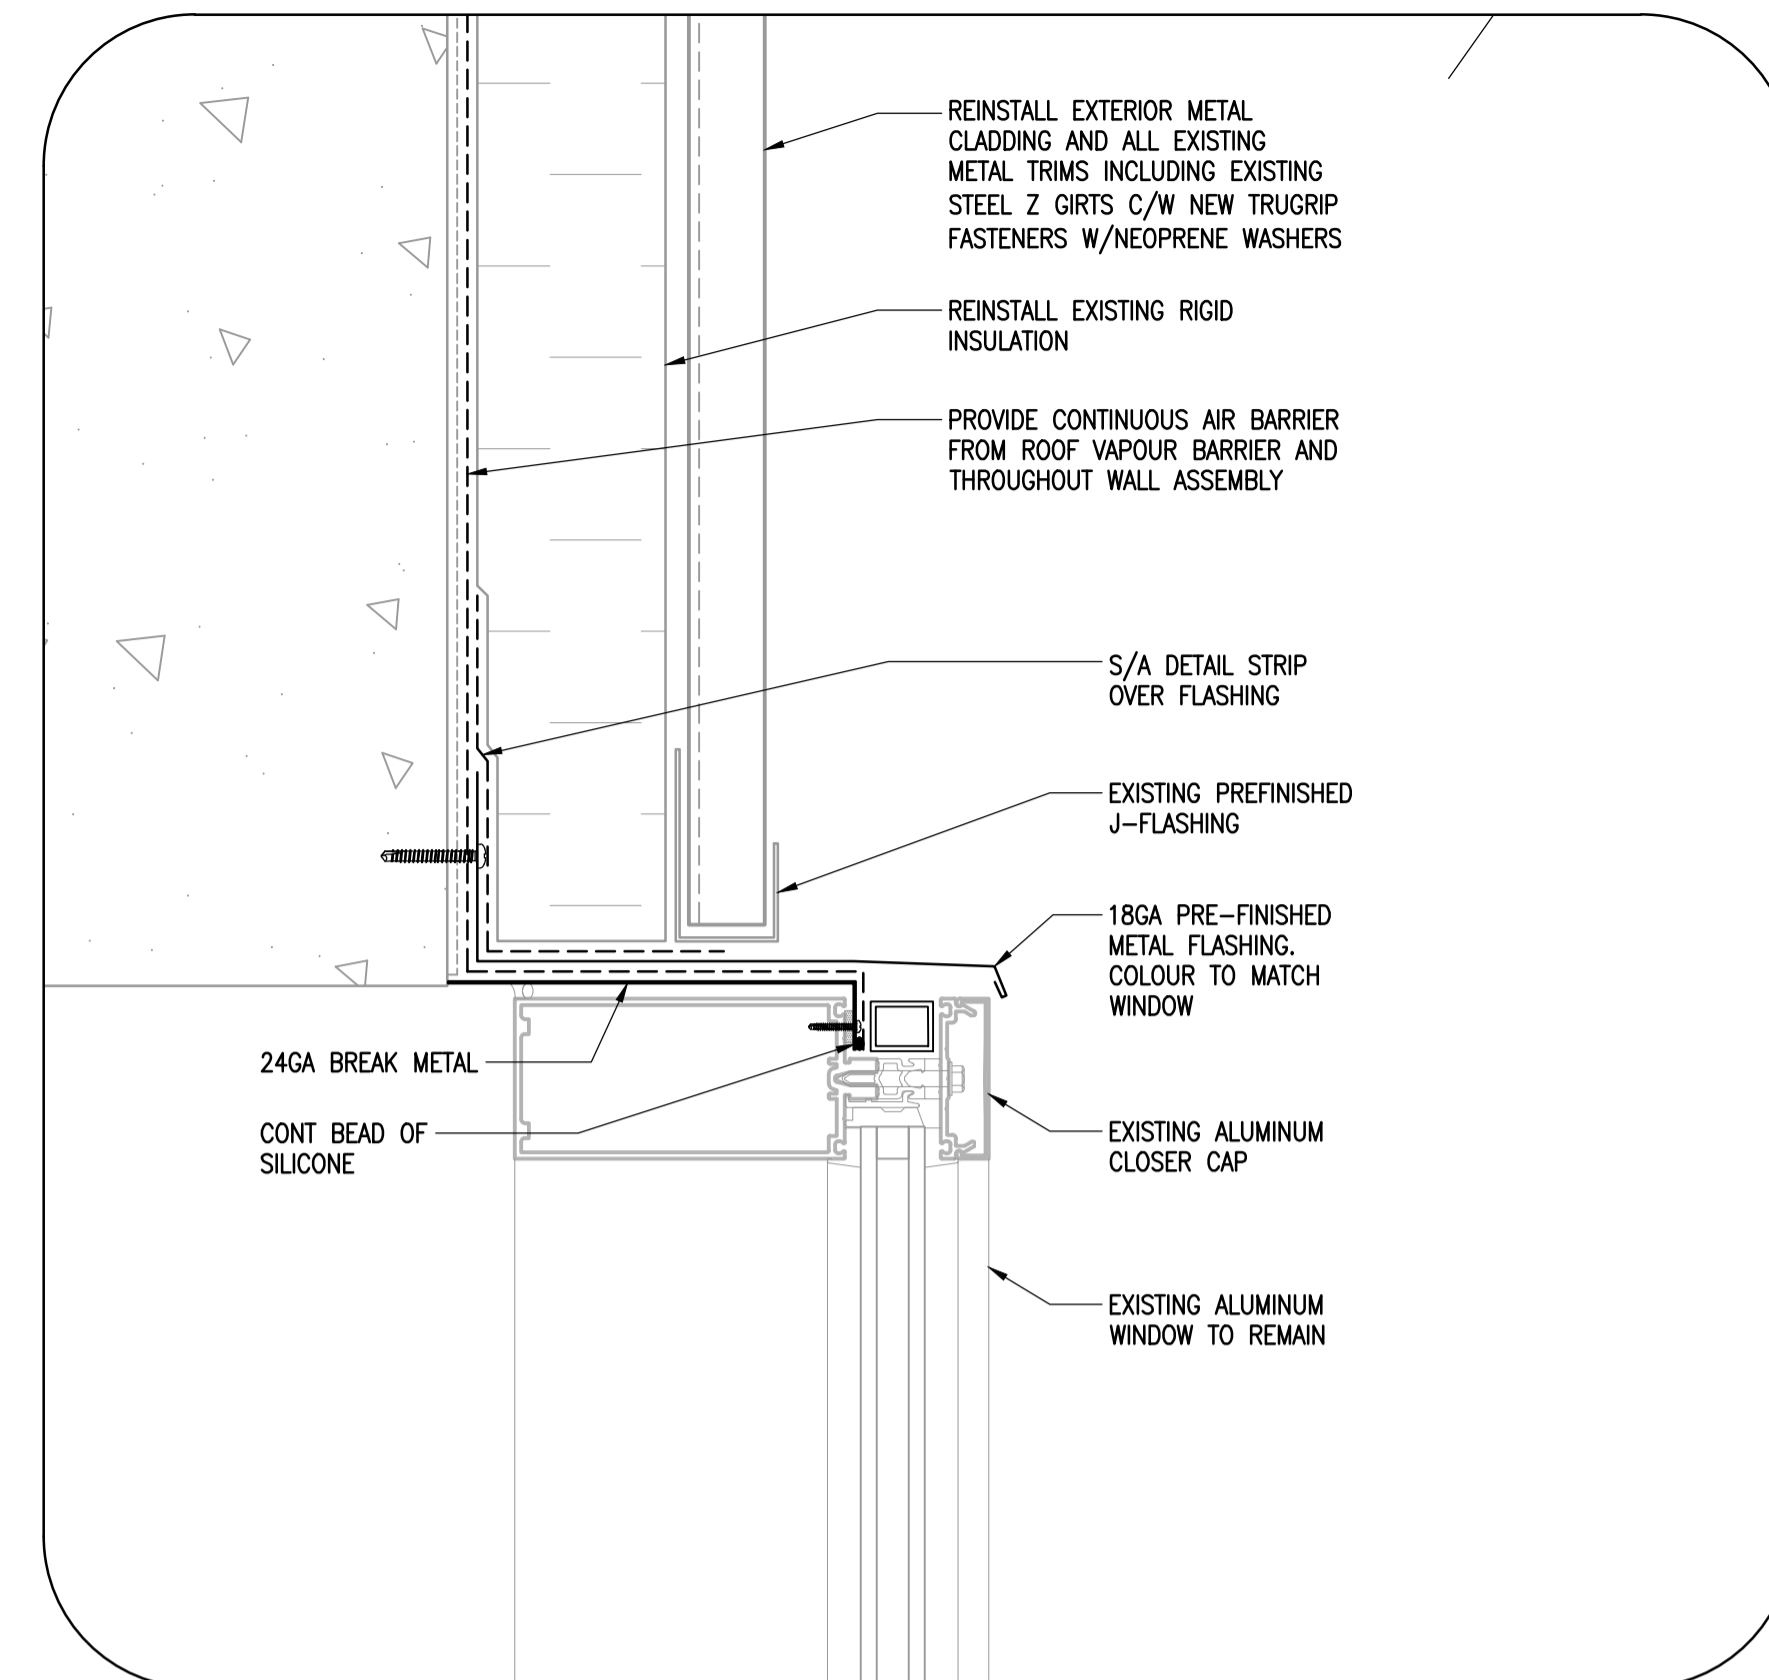

C CLERESTORY HEAD DETAIL
1-0601B-80076-006 1:5

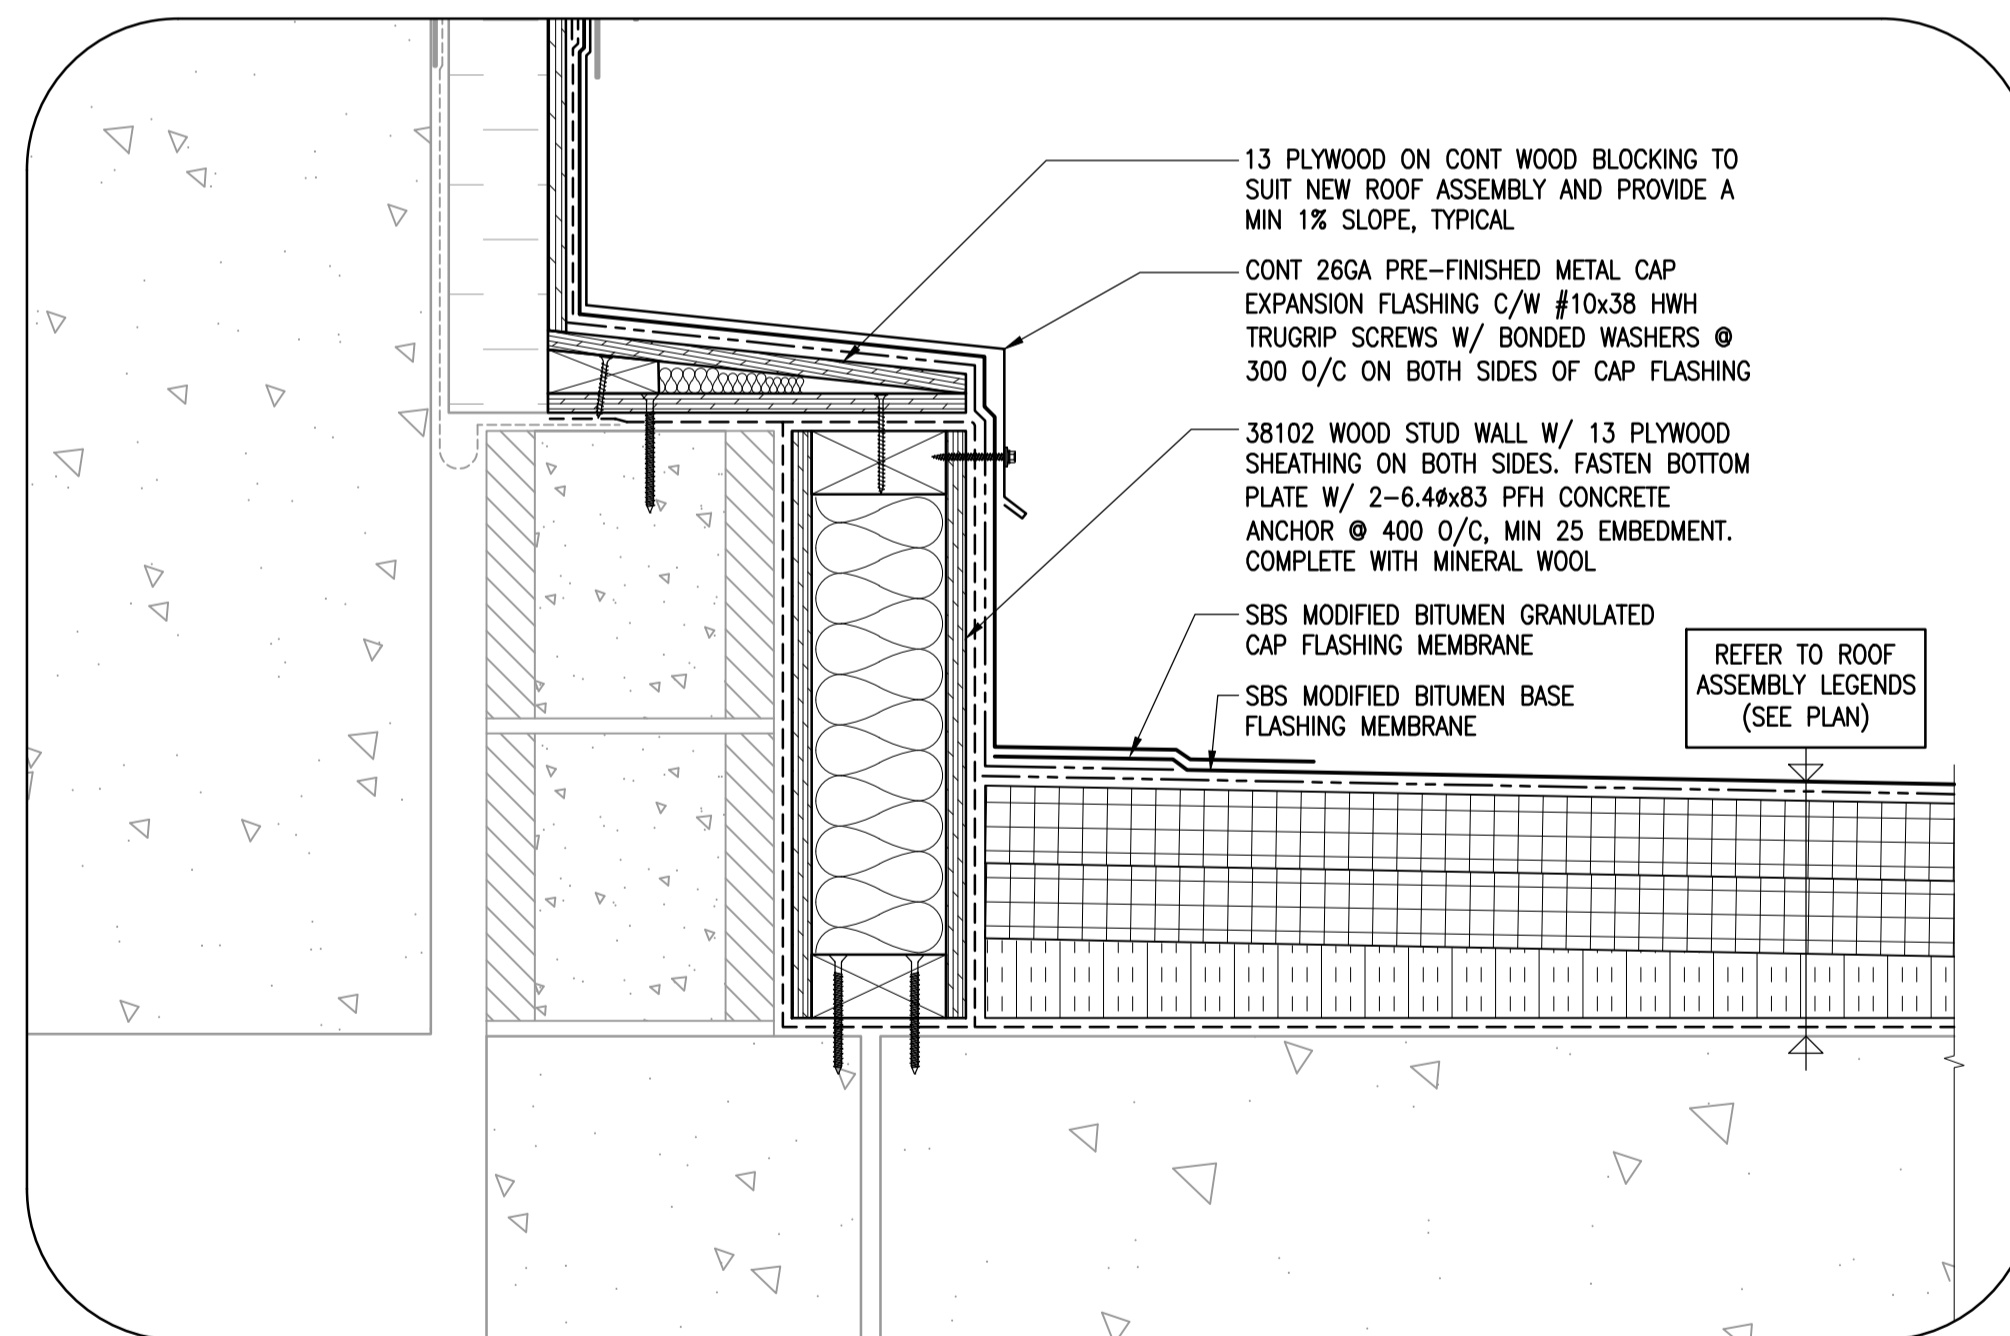

B WALL INTERFACE DETAIL
1-0601B-80076-006 1:5

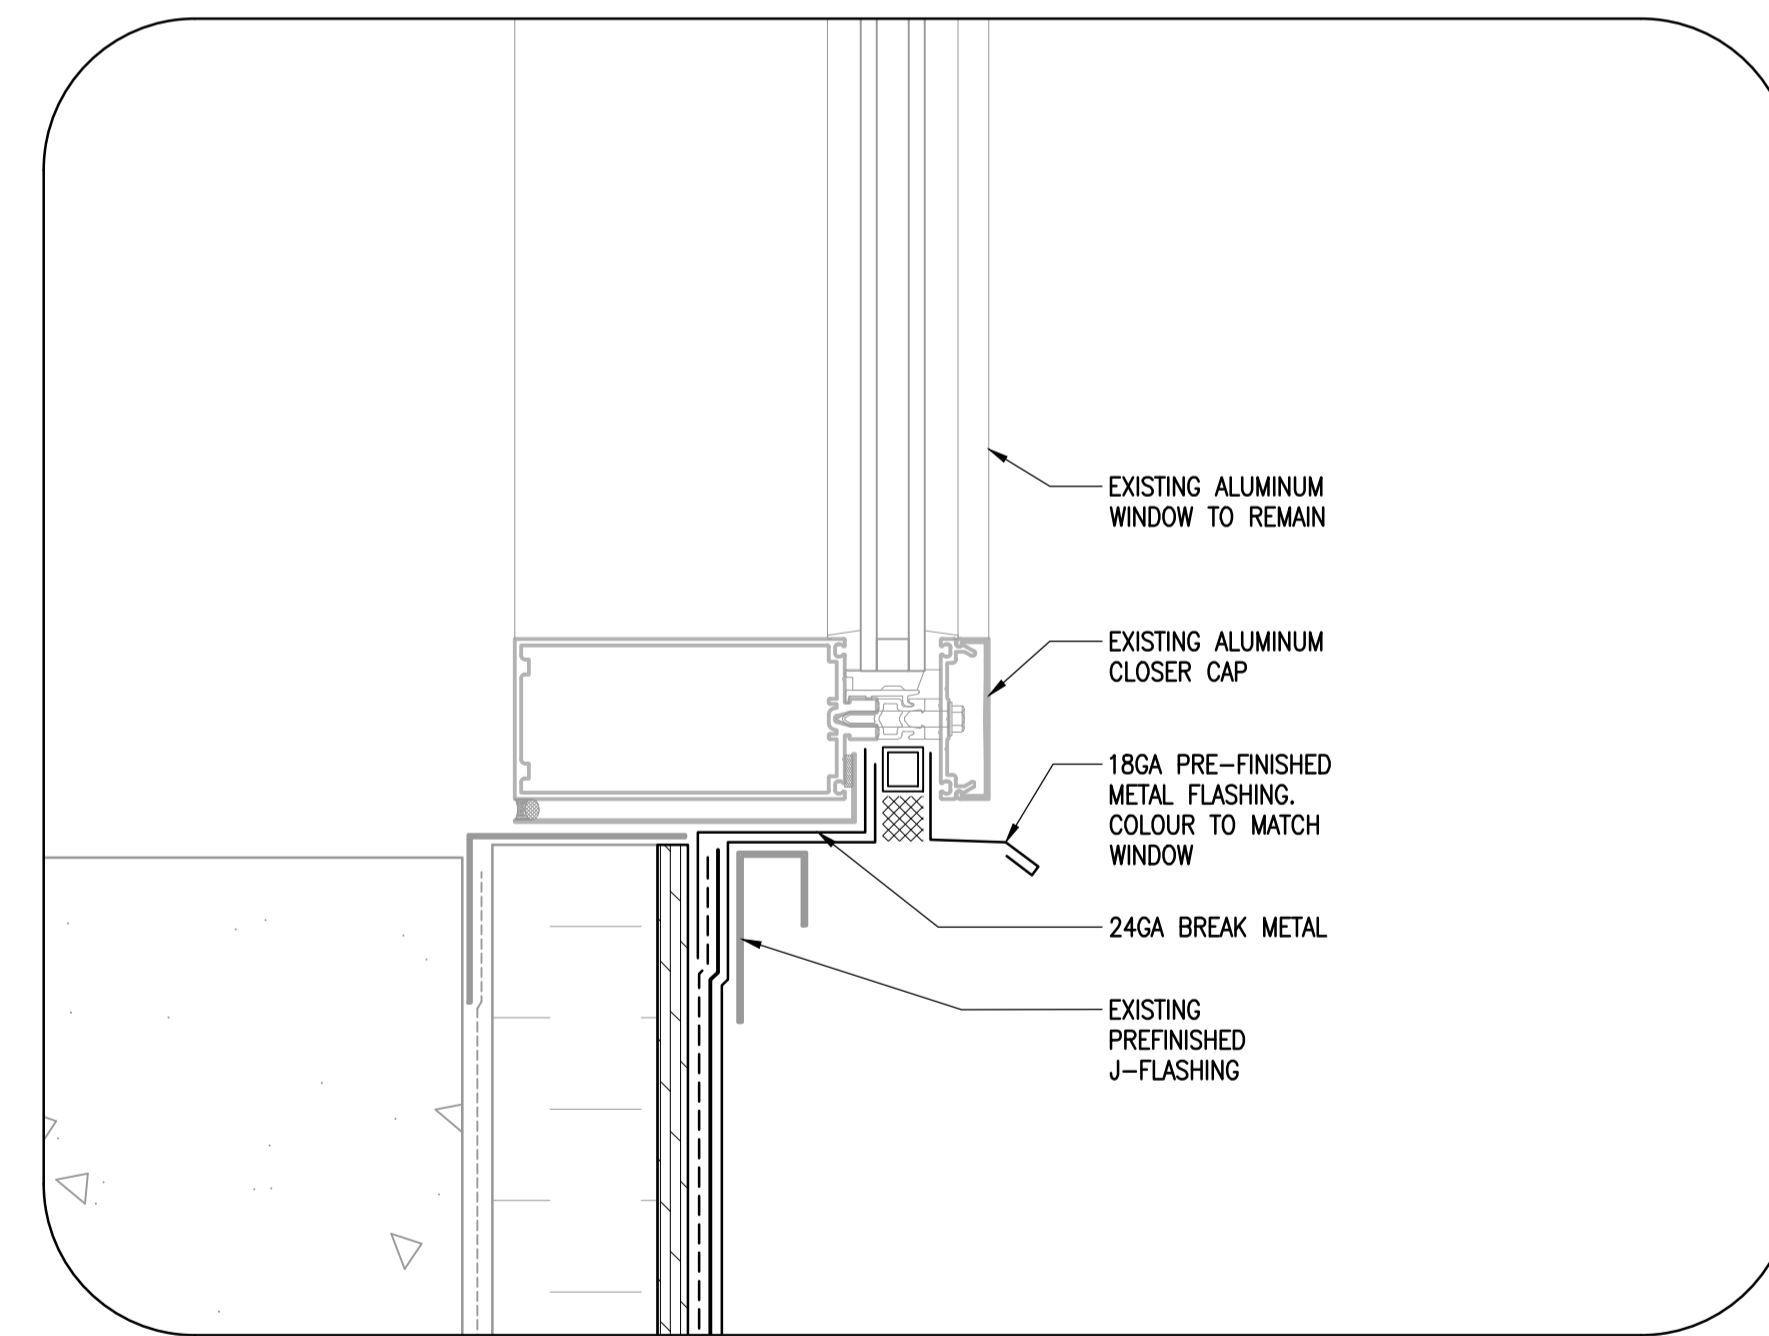

D CLERESTORY SILL DETAIL
1-0601B-80076-006 1:5

10		
9		
8		
7		
6		
5		
4		
3		
2	1-0601B-B0068-001	BUILDING WF, WR, WO & WC ROOF PLAN
1	1-0601B-G0004-001	BUILDING NOTES, SCHEDULE & LEGENDS
NO.	DRAWING NUMBER	REFERENCE DRAWING TITLE
REFERENCE DRAWINGS		

ENGINEERS GEOSCIENTISTS MANITOBA
Certificate of Authorization
Crosier Kilgour & Partners Ltd.
No. 235

B.M. ELEV.					
00	ISSUED FOR TENDER	23/03/21	GJH		
NO.	REVISIONS	DATE	BY	DATE	

DESIGNED BY	GJH	CHECKED BY	JAW
DRAWN BY	LOL	APPROVED BY	GJH
SCALE:	AS NOTED	RELEASED FOR CONSTRUCTION BY:	
DATE	2023/03/21	DATE	

ENGINEER'S SEAL
PROVINCE OF MANITOBA
REGISTERED PROFESSIONAL ENGINEER
J.A. WELLS
23/03/21
CONSULTANT DRAWING NO. S4.6

THE CITY OF WINNIPEG
WATER AND WASTE DEPARTMENT
ENGINEERING DIVISION

DRINKING WATER TREATMENT PLANT
MAIN BUILDING
ROOF REPLACEMENT

BUILDING ROOF
DETAILS 6 OF 9

CITY FILE NUMBER **W-1049**
SHEET 6 OF 9
CITY DRAWING NUMBER 1-0601B-80076-006