


1 GOOSENECK DETAIL
1-0601B-00076-008 1:5

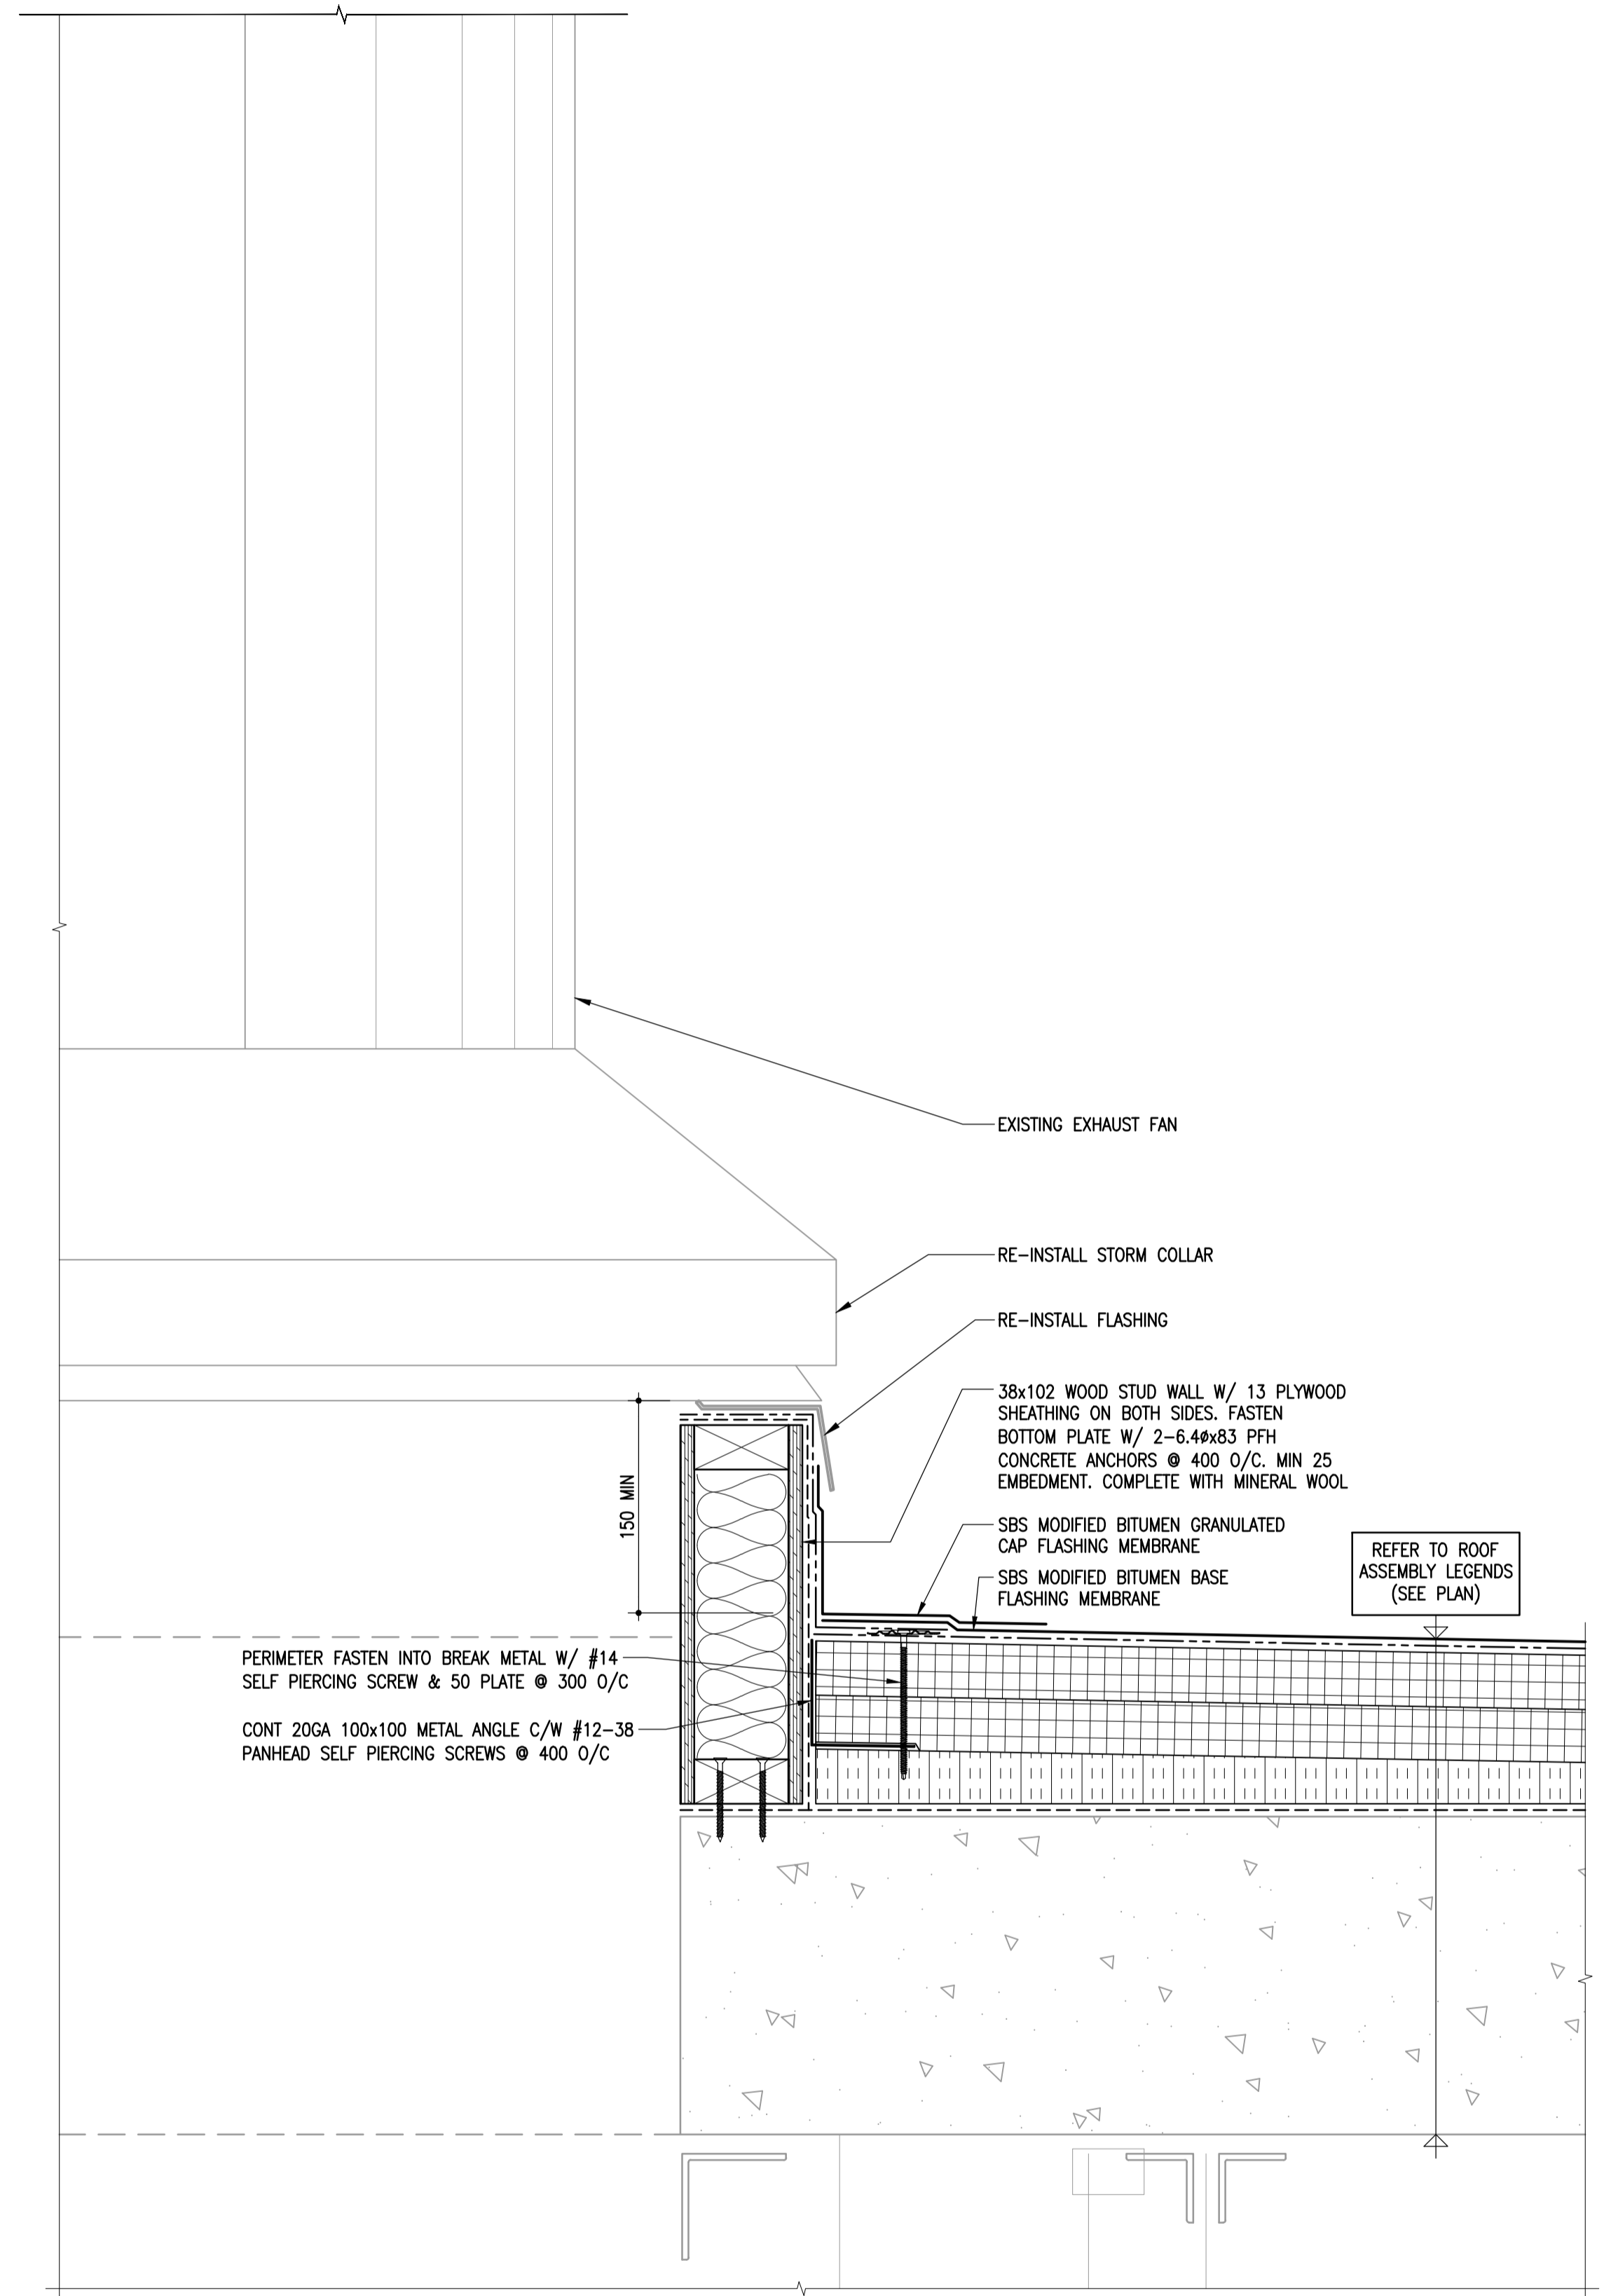

2 EXHAUST FAN DETAIL
1-0601B-00076-008 1:5

10		
9		
8		
7		
6		
5		
4		
3		
2	1-0601B-B0068-001	BUILDING WF, WR, WO & WC ROOF PLAN
1	1-0601B-G0004-001	BUILDING NOTES, SCHEDULE & LEGENDS
NO.	DRAWING NUMBER	REFERENCE DRAWING TITLE
REFERENCE DRAWINGS		

**ENGINEERS
GEOLOGISTS
MANITOBA**
Certificate of Authorization
Crosier Kilgour & Partners Ltd.
No. 235

B.M.	ELEV.				
00	ISSUED FOR TENDER	23/03/21	GJH		
NO.	REVISIONS	DATE	BY	DATE	

300-275 Carlton Street
Winnipeg, Manitoba R3C 5R6
T 204. 943. 7503
F 204. 943. 7507
2022-1008

**Crosier Kilgour
& Partners Ltd.**
CONSULTING STRUCTURAL ENGINEERS

DESIGNED BY	GJH	CHECKED BY	JAW
DRAWN BY	LOL	APPROVED BY	GJH
SCALE:	1:5	RELEASED FOR CONSTRUCTION BY:	
		DATE	2023/03/21

ENGINEER'S SEAL
PROVINCE OF MANITOBA
J.A. WELLS
23/03/21
REGISTERED PROFESSIONAL ENGINEER
CONSULTANT DRAWING NO.
S4.8

THE CITY OF WINNIPEG
WATER AND WASTE DEPARTMENT
ENGINEERING DIVISION

DRINKING WATER TREATMENT PLANT
MAIN BUILDING
ROOF REPLACEMENT

BUILDING
ROOF
DETAILS 8 OF 9

CITY FILE NUMBER
W-1049

SHEET 8 OF 9

CITY DRAWING NUMBER
1-0601B-B0076-008