




1 OVERFLOW SCUPPER DETAIL
1-0601B-0076-09 1:5

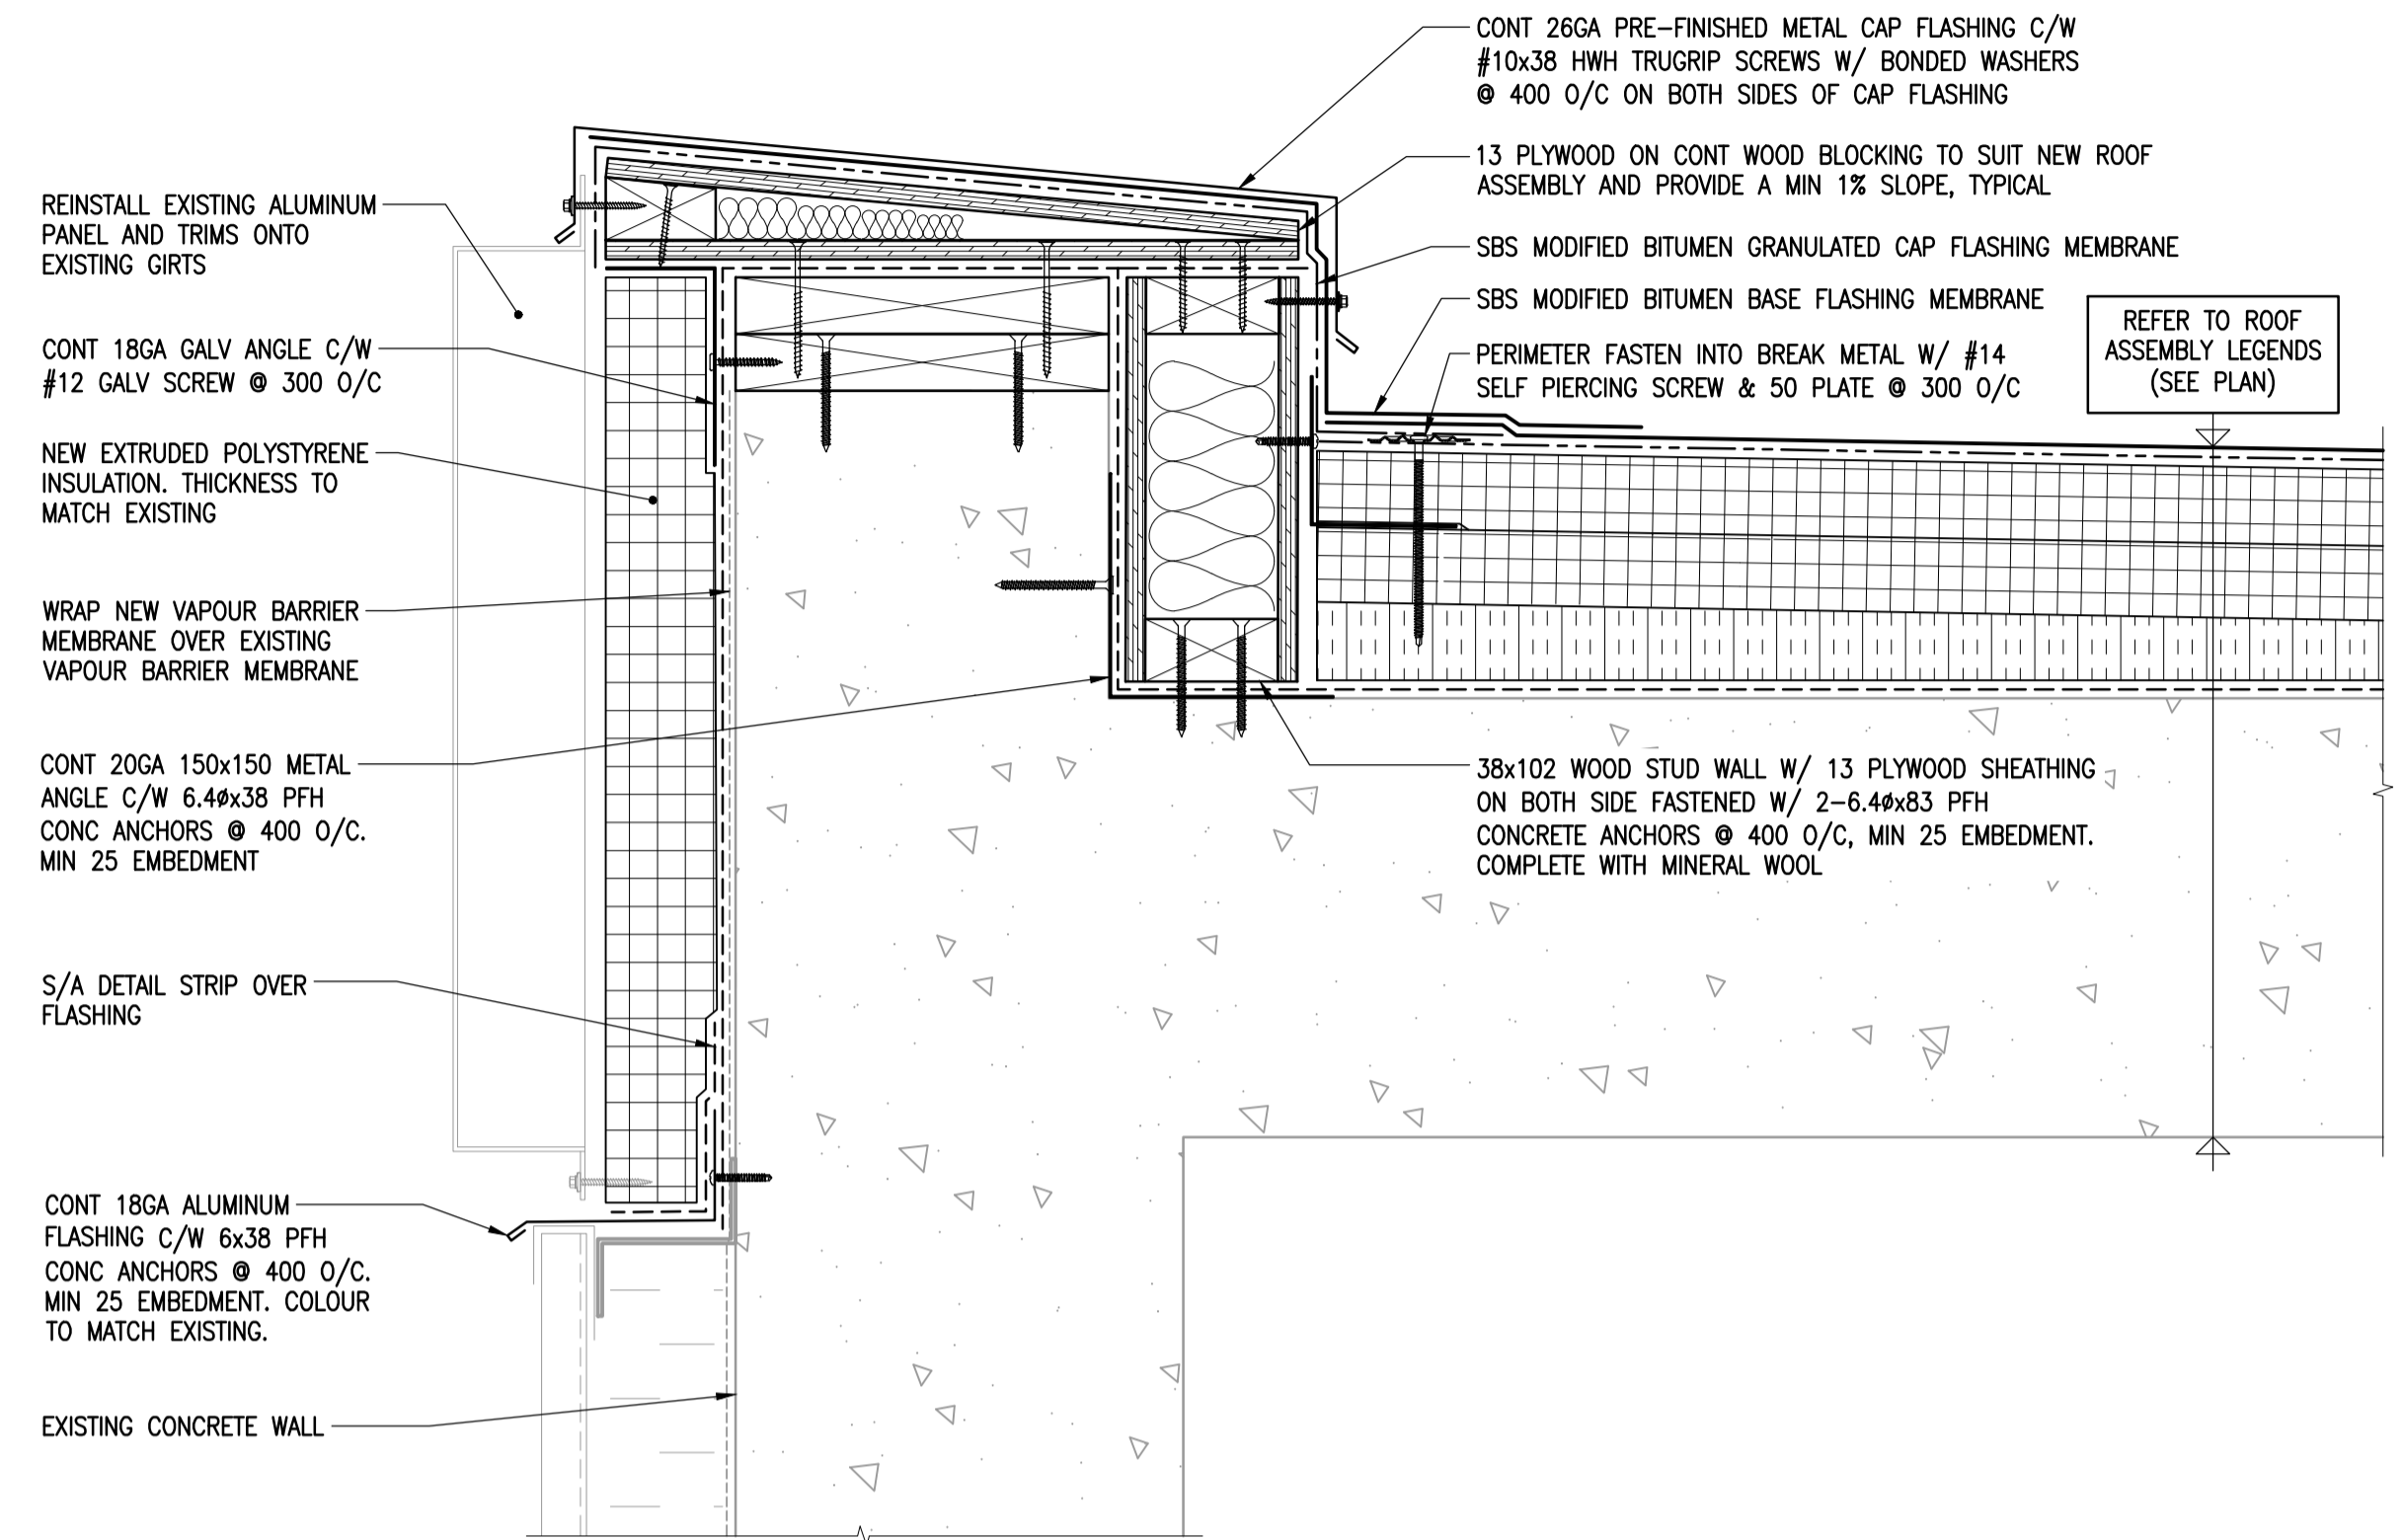

3 ROOFING TIE-IN DETAIL
1-0601B-0076-09 1:5

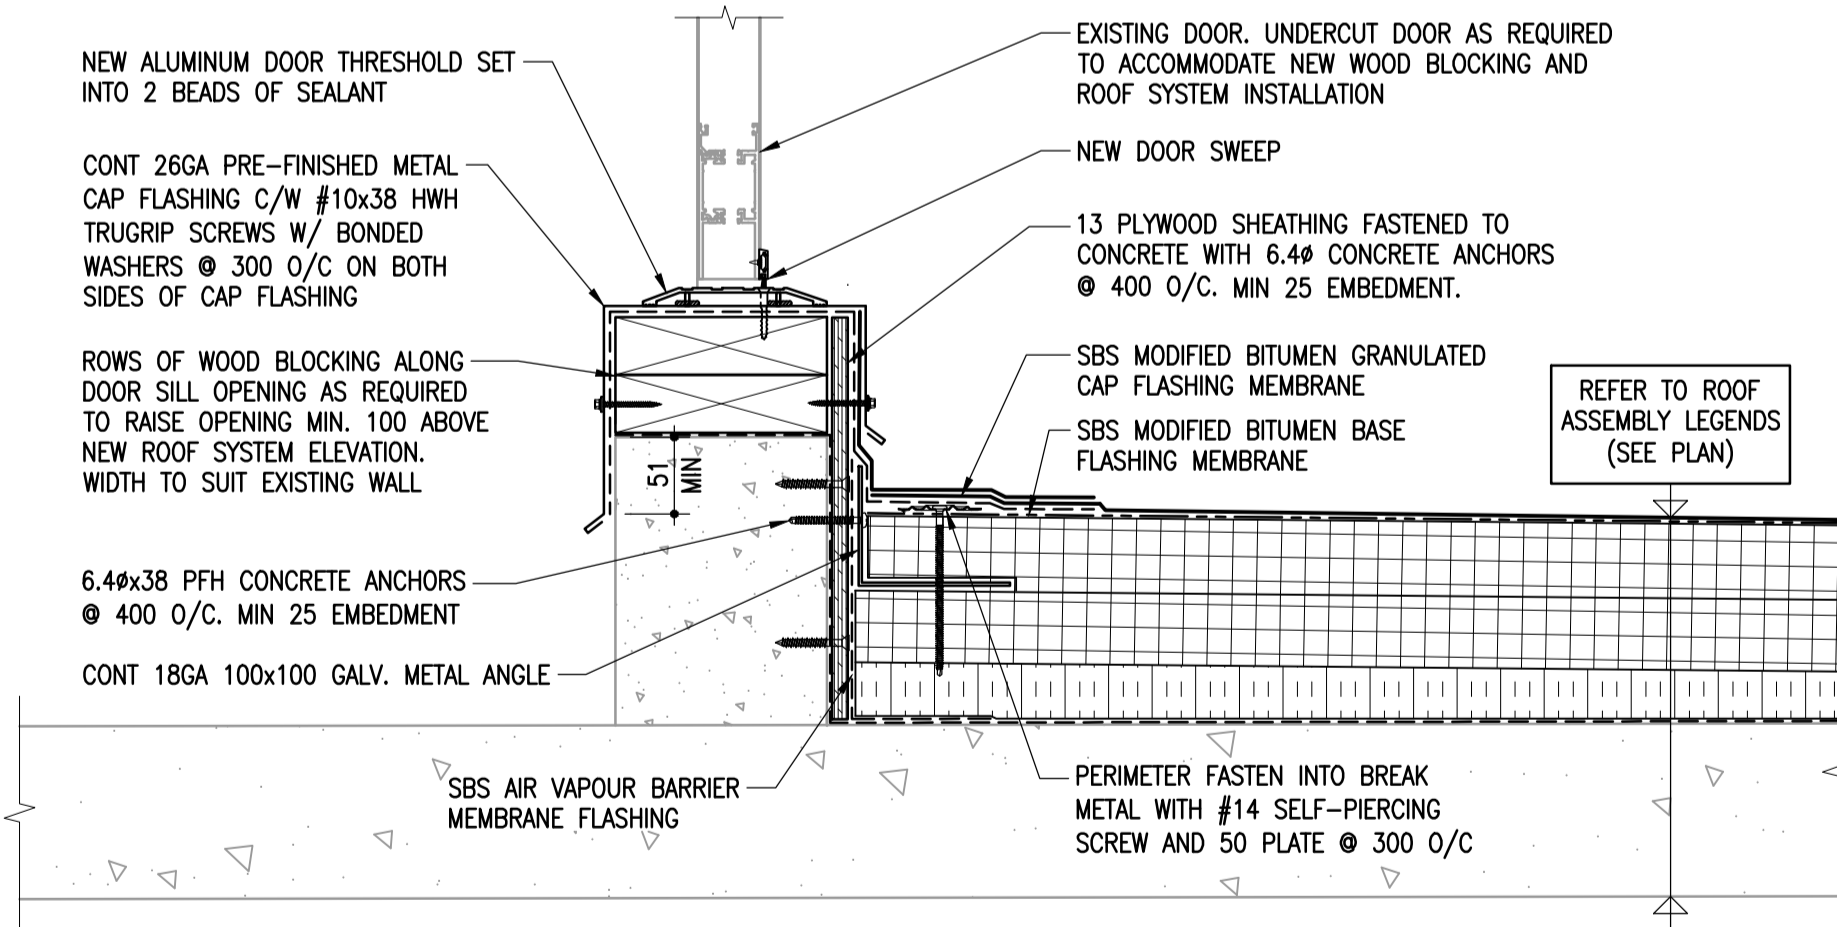

2 ROOF DETAIL AT ACCESS DOOR
1-0601B-0076-09 1:5

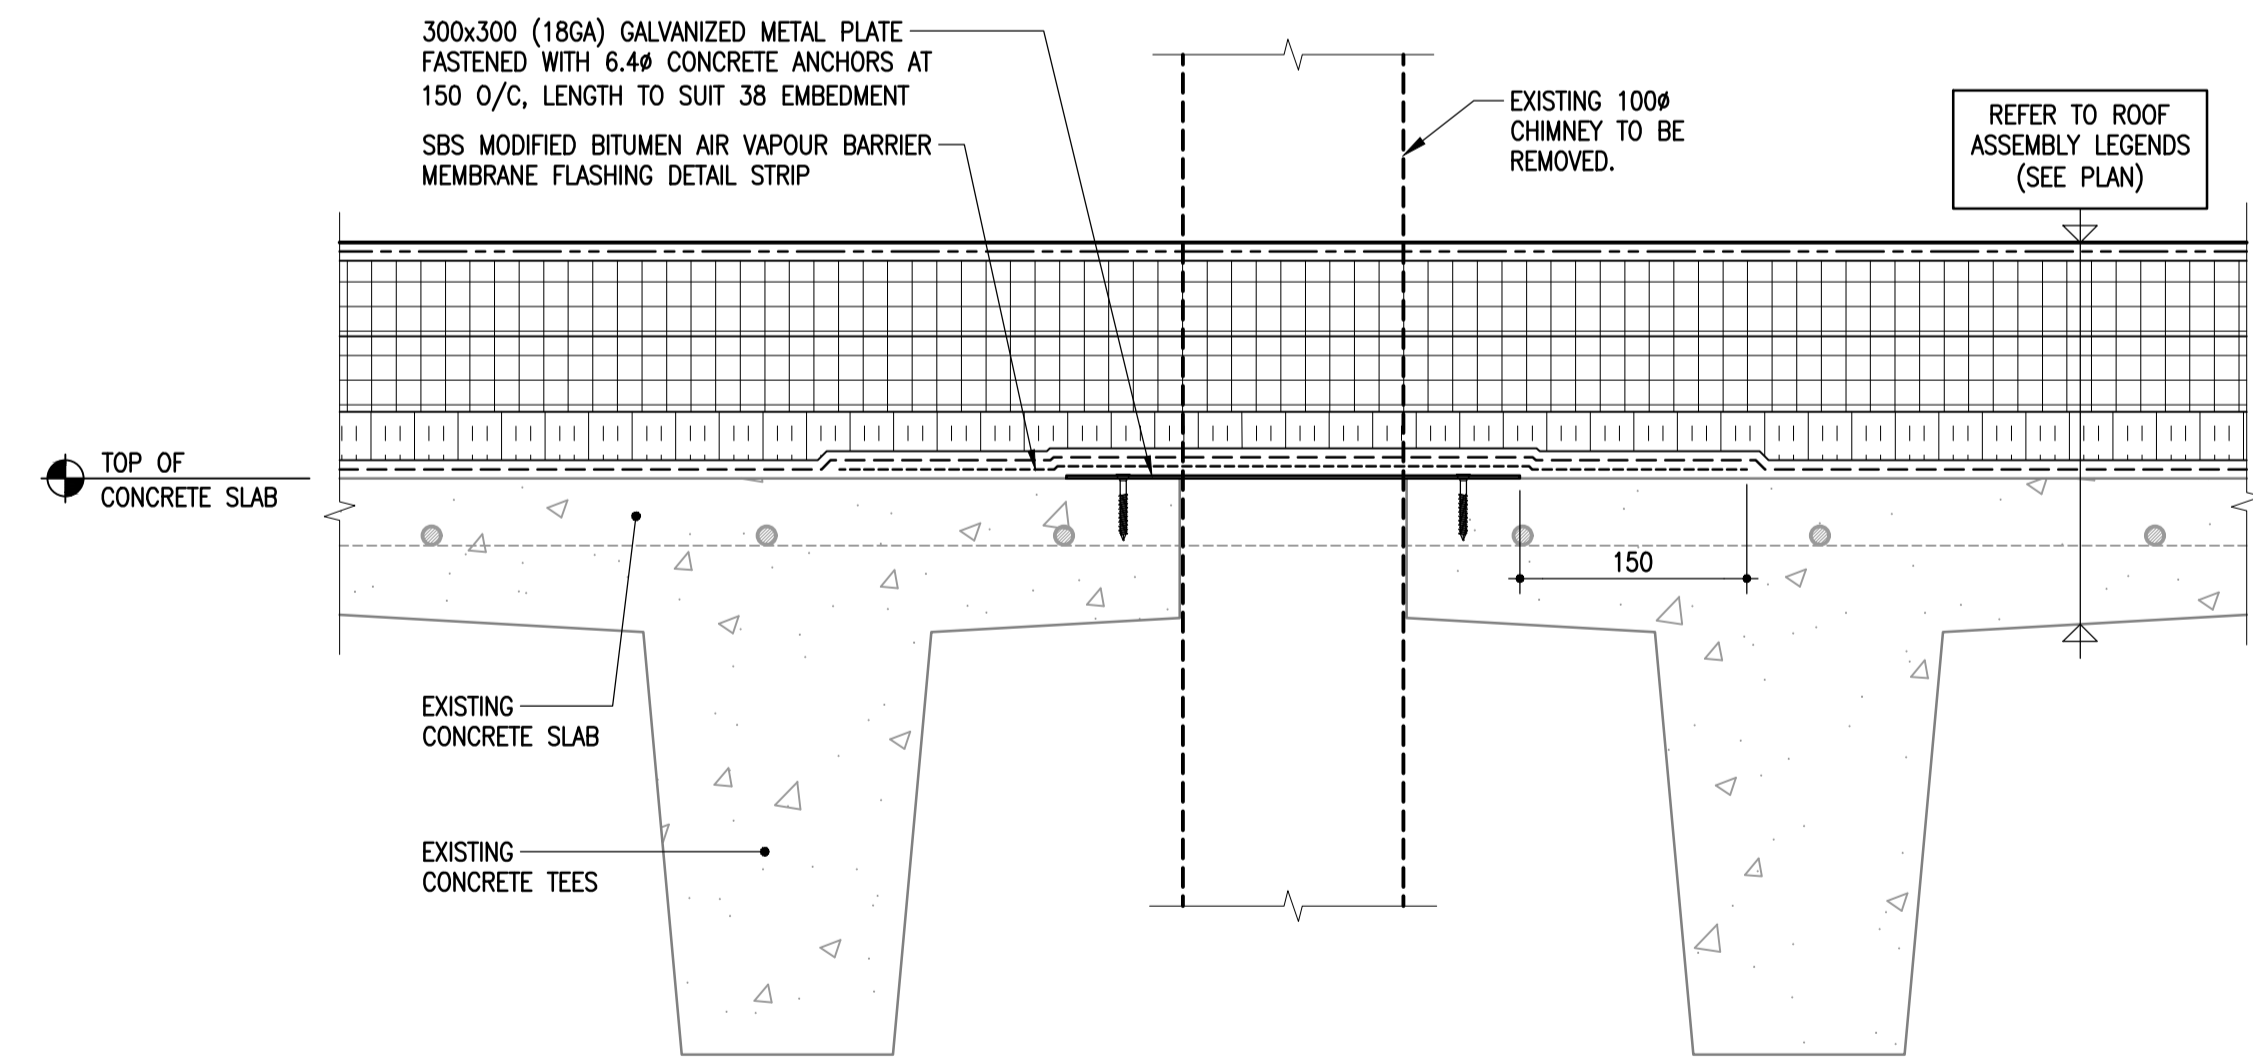

4 THRU SLAB INFILL DETAIL
1-0601B-0076-09 NTS

10		
9		
8		
7		
6		
5	1-0601B-0071-001	BUILDING WI & WM ROOF PLAN
4	1-0601B-0070-001	BUILDING WA ROOF PLAN
3	1-0601B-0069-001	BUILDING WP ROOF PLAN
2	1-0601B-0068-001	BUILDING WF, WR, WO & WC ROOF PLAN
1	1-0601B-G0004-001	BUILDING NOTES, SCHEDULE & LEGENDS
NO.	DRAWING NUMBER	REFERENCE DRAWING TITLE
REFERENCE DRAWINGS		

**ENGINEERS
GEOSCIENTISTS
MANITOBA**
Certificate of Authorization
Crosier Kilgour & Partners Ltd.
No. 235

B.M. ELEV.					
DESIGNED BY	GJH	CHECKED BY	JAW		
DRAWN BY	LOL	APPROVED BY	GJH		
SCALE:	1:5	RELEASED FOR CONSTRUCTION BY:			
00	ISSUED FOR TENDER	23/03/21	GJH		
NO.	REVISIONS	DATE	BY	DATE	2023/03/21

ENGINEER'S SEAL
PROVINCE OF MANITOBA
REGISTERED PROFESSIONAL ENGINEER
J.A. WELLS
23/03/21
CONSULTANT DRAWING NO. S4.9

THE CITY OF WINNIPEG
WATER AND WASTE DEPARTMENT
ENGINEERING DIVISION
Winnipeg
DRINKING WATER TREATMENT PLANT
MAIN BUILDING
ROOF REPLACEMENT
BUILDING ROOF
DETAILS 9 OF 9
CITY FILE NUMBER
W-1049
SHEET 9 OF 9
CITY DRAWING NUMBER
1-0601B-0076-009