




THE CITY OF WINNIPEG


WATER AND WASTE DEPARTMENT ENGINEERING DIVISION

DRINKING WATER TREATMENT PLANT ROOF REPLACEMENT

TENDER : 37-2023

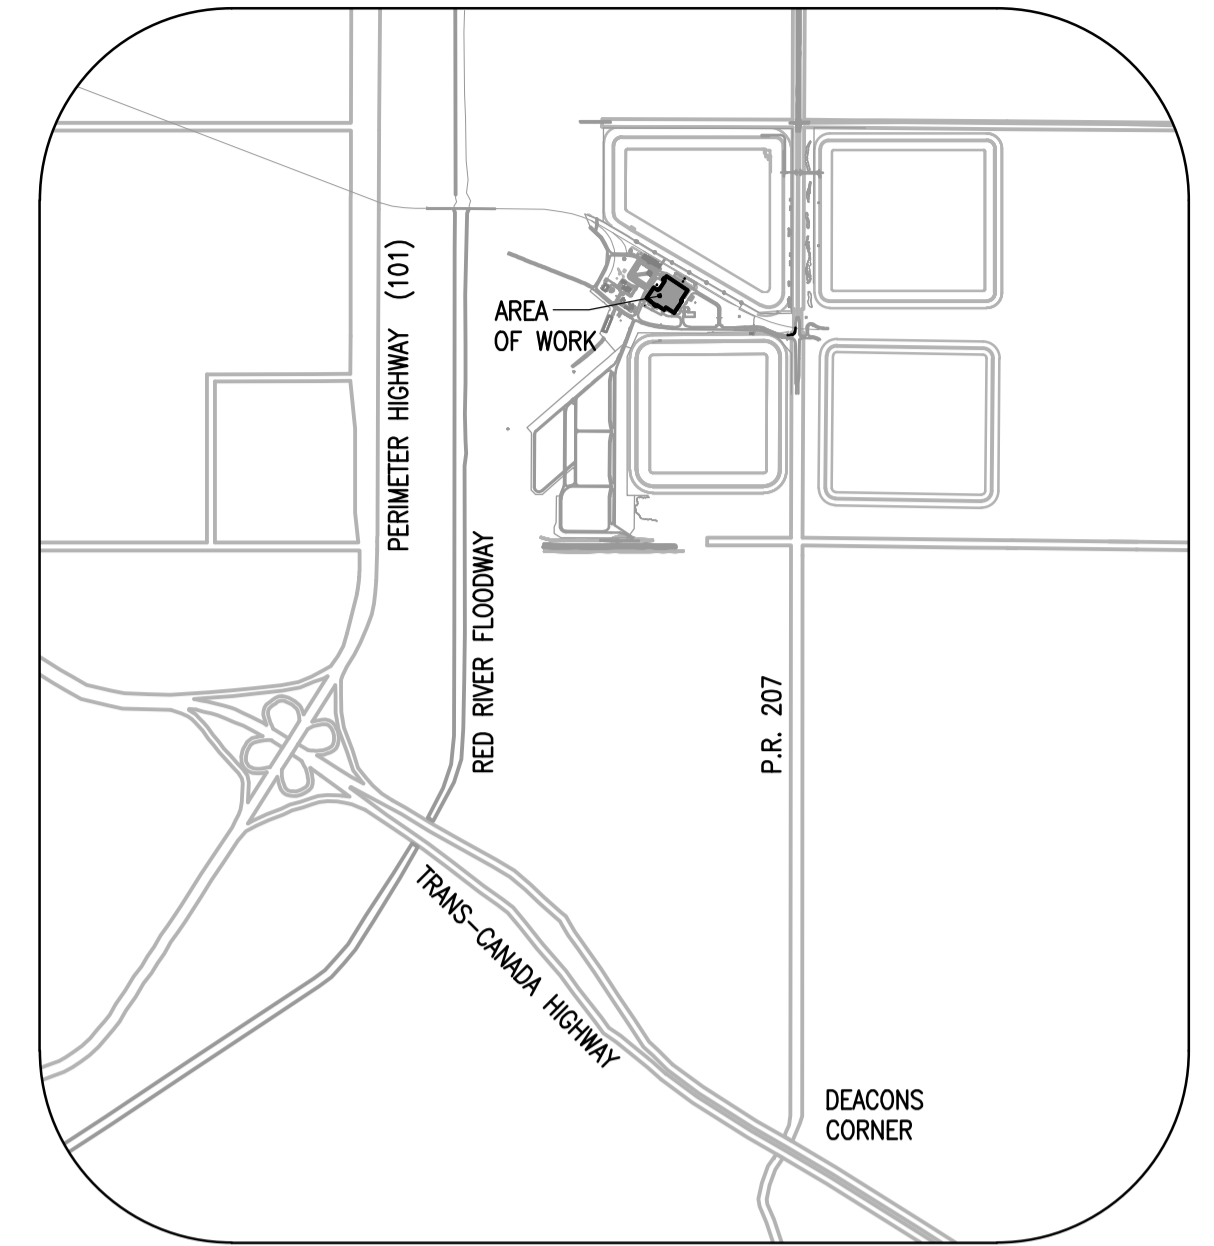

TRUE NORTH
REF. NORTH
KEY PLAN
NOT TO SCALE

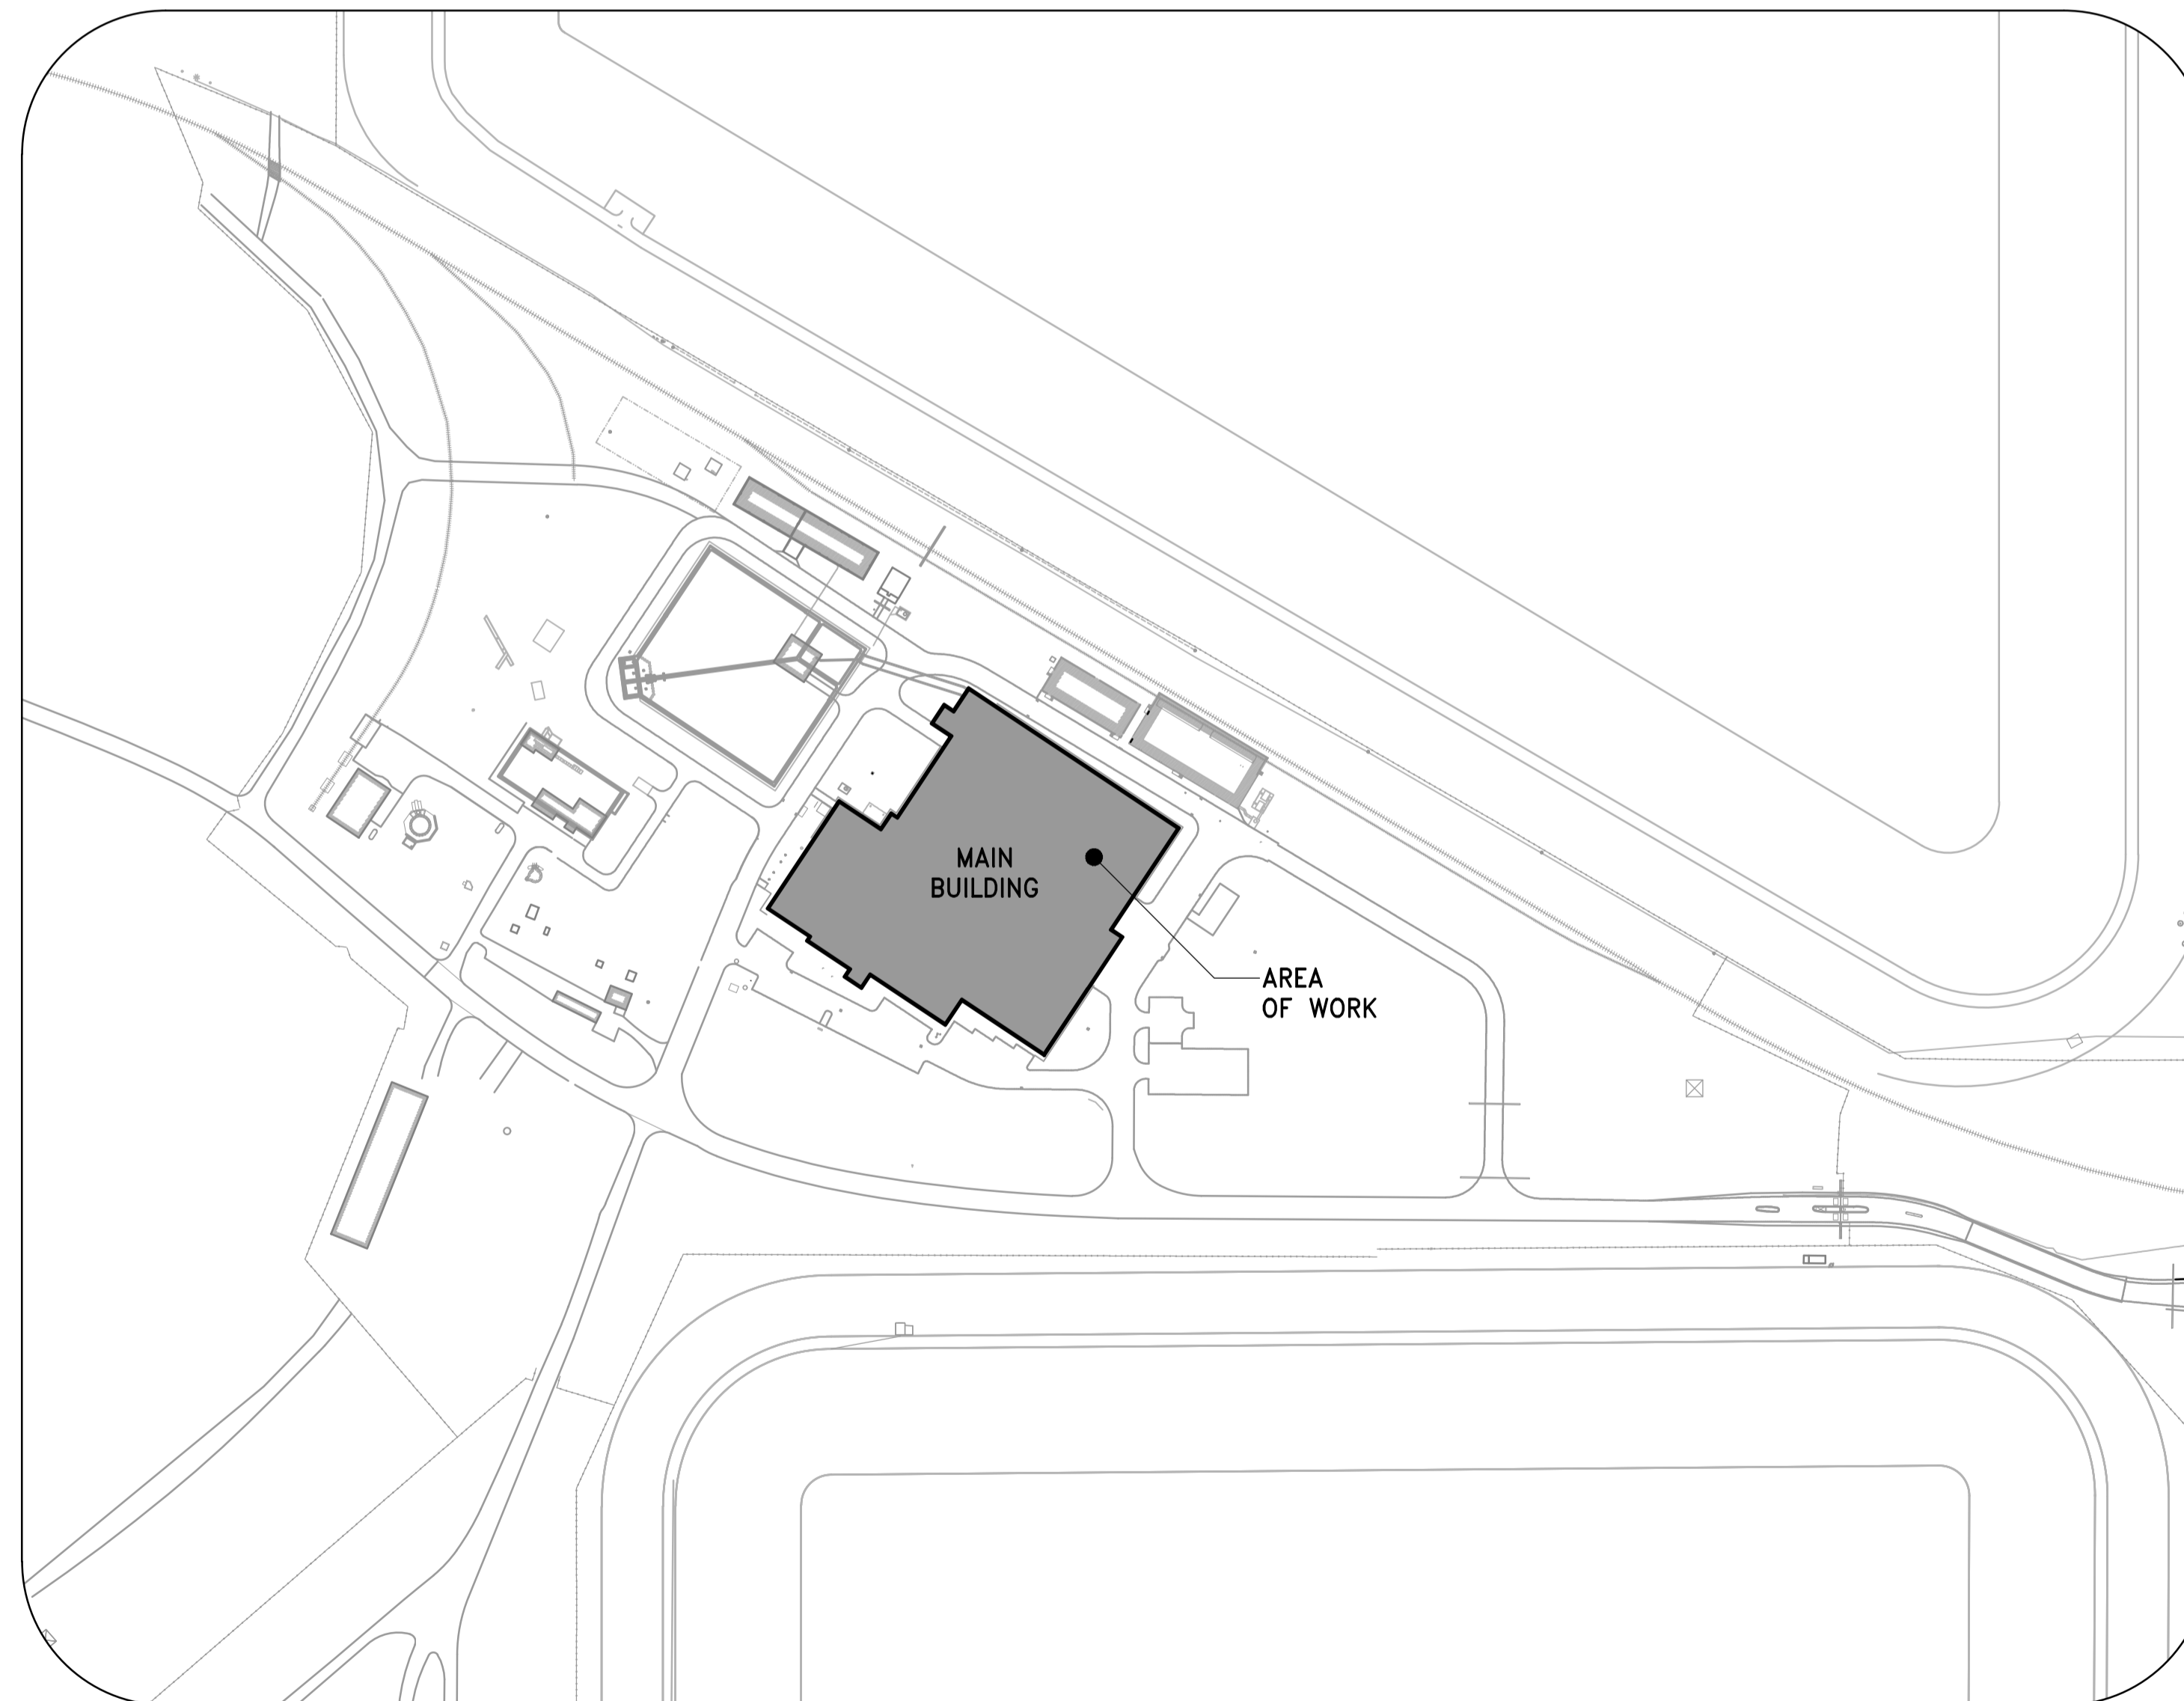

TRUE NORTH
REF. NORTH
SITE PLAN
NOT TO SCALE

CONSULTANT DRAWING NO.
S0.1
CITY DRAWING NUMBER
1-0601B-G0002-001