




1 PRIMARY ROOF DRAIN: RD-1
SCALE: NTS
M3.3

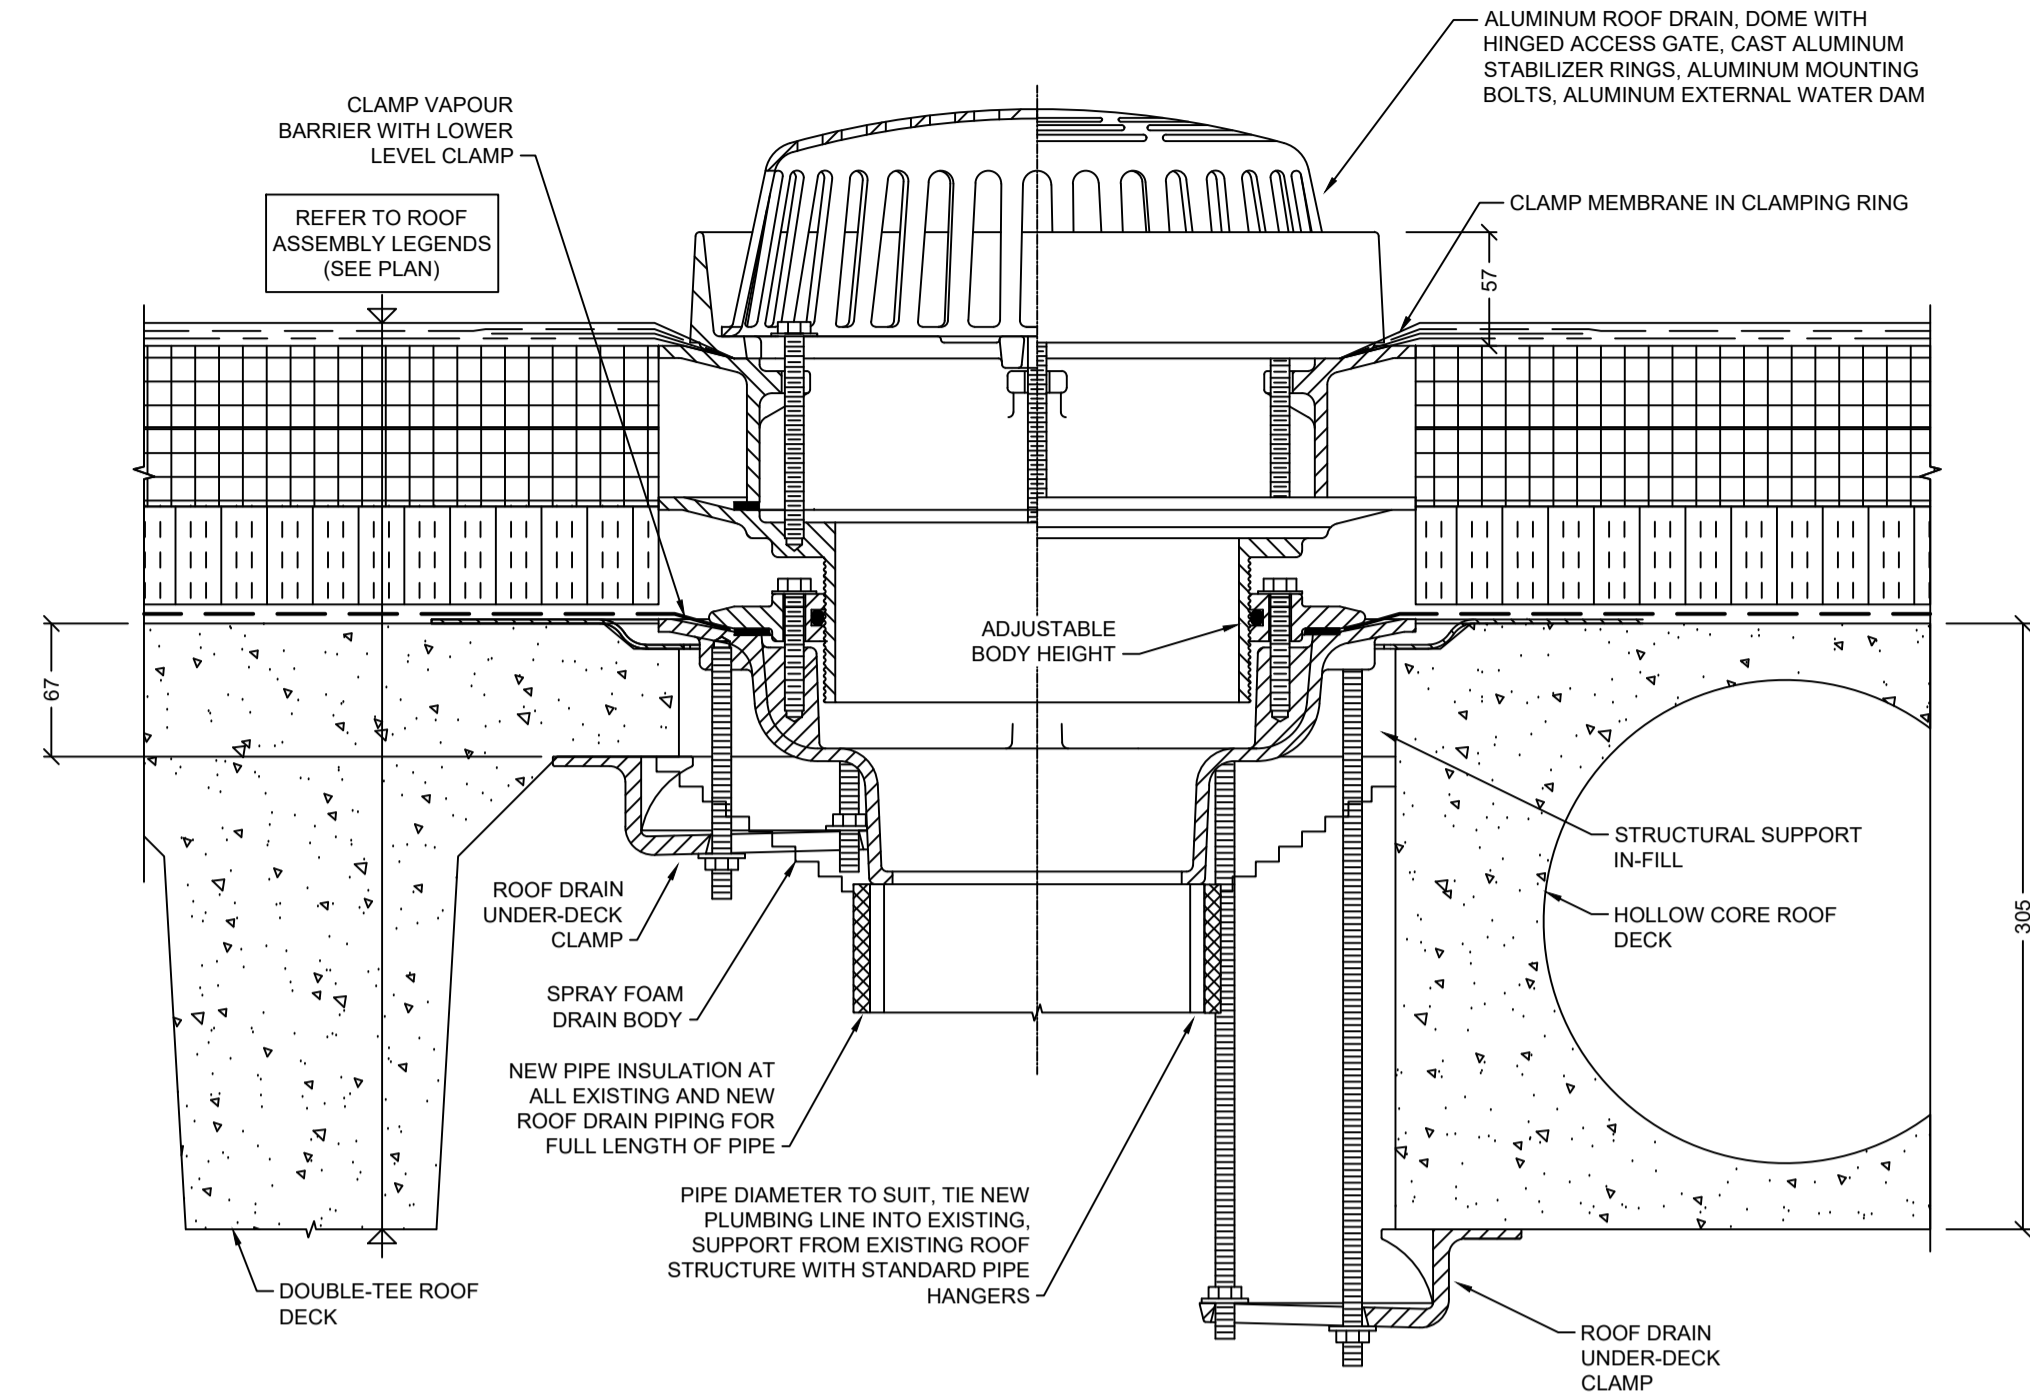


2 OVERFLOW ROOF DRAIN: RD-2
SCALE: NTS
M3.3

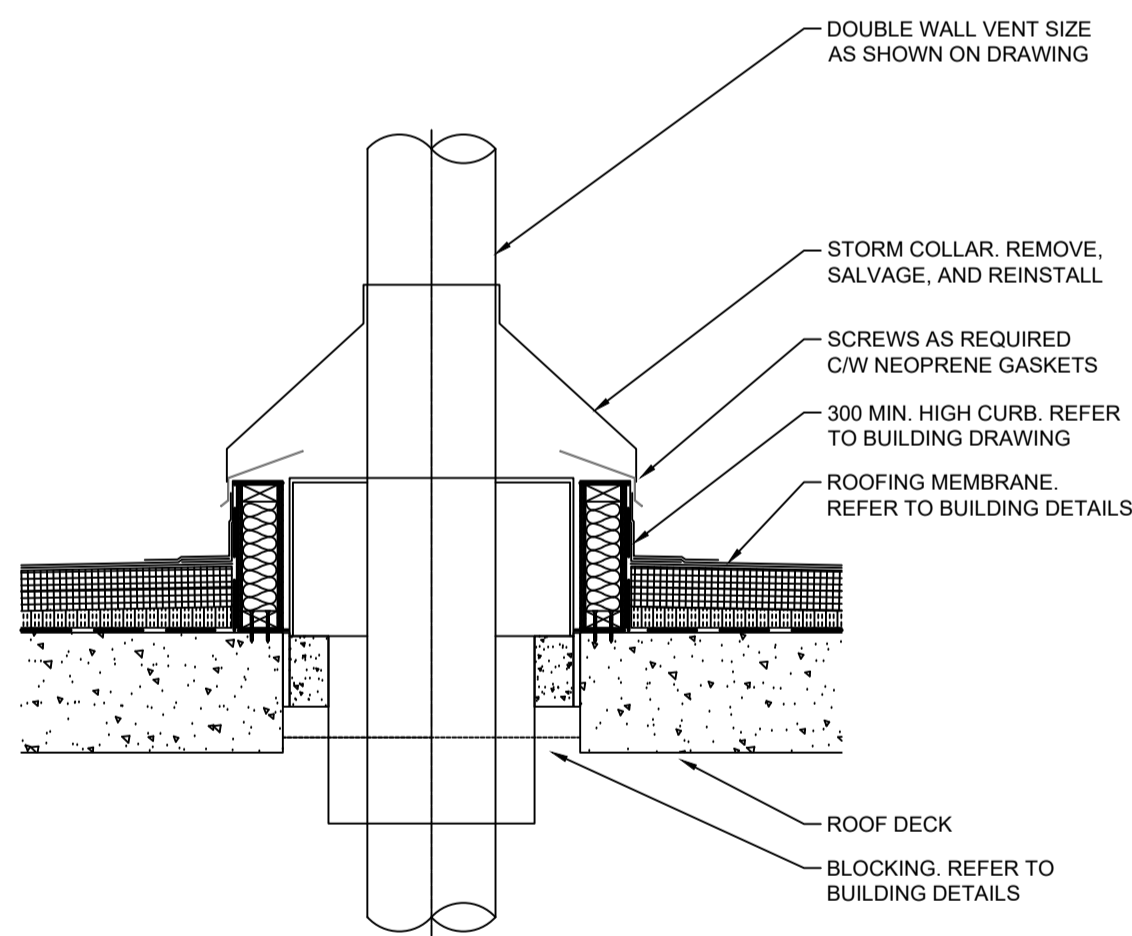

3 CHIMNEY THROUGH ROOF
SCALE: NTS
M3.3

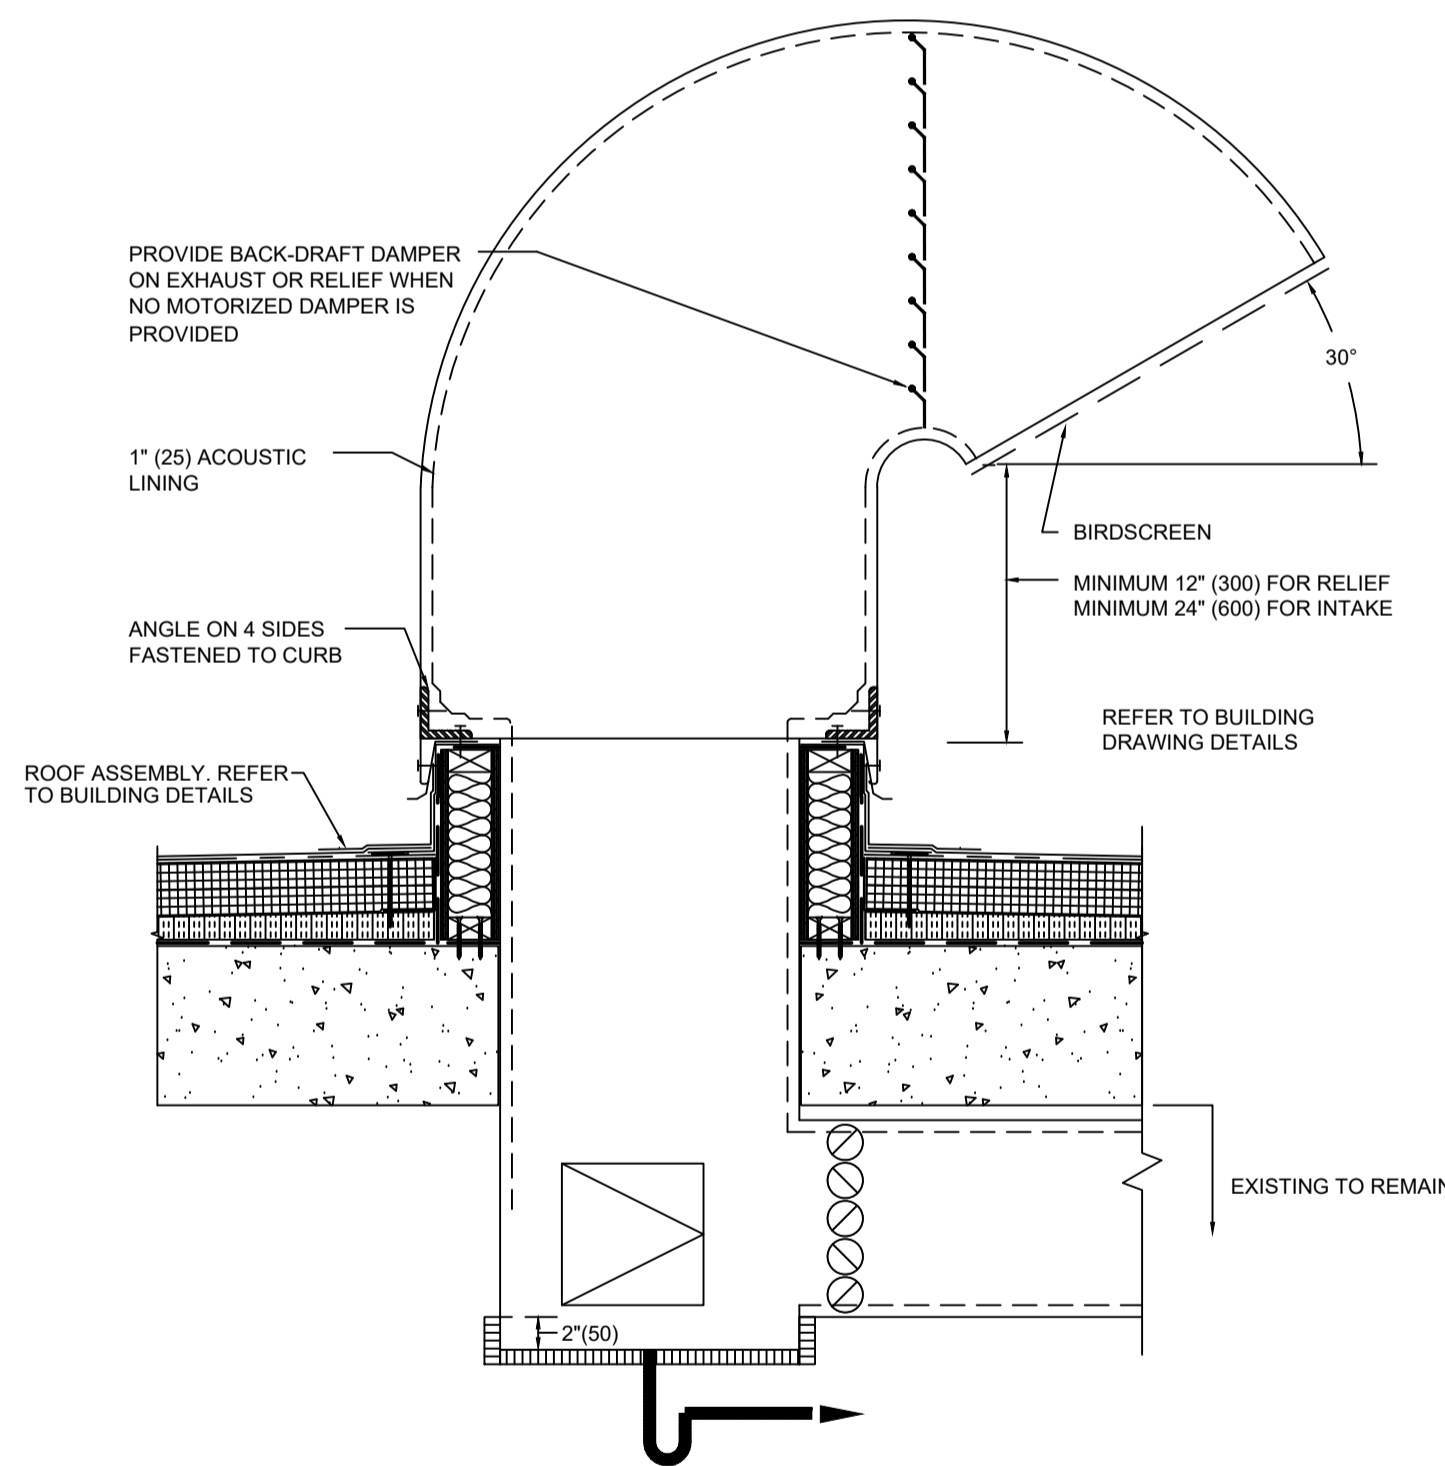

4 INTAKE OR OUTLET AIR GOOSENECK
SCALE: NTS
M3.3

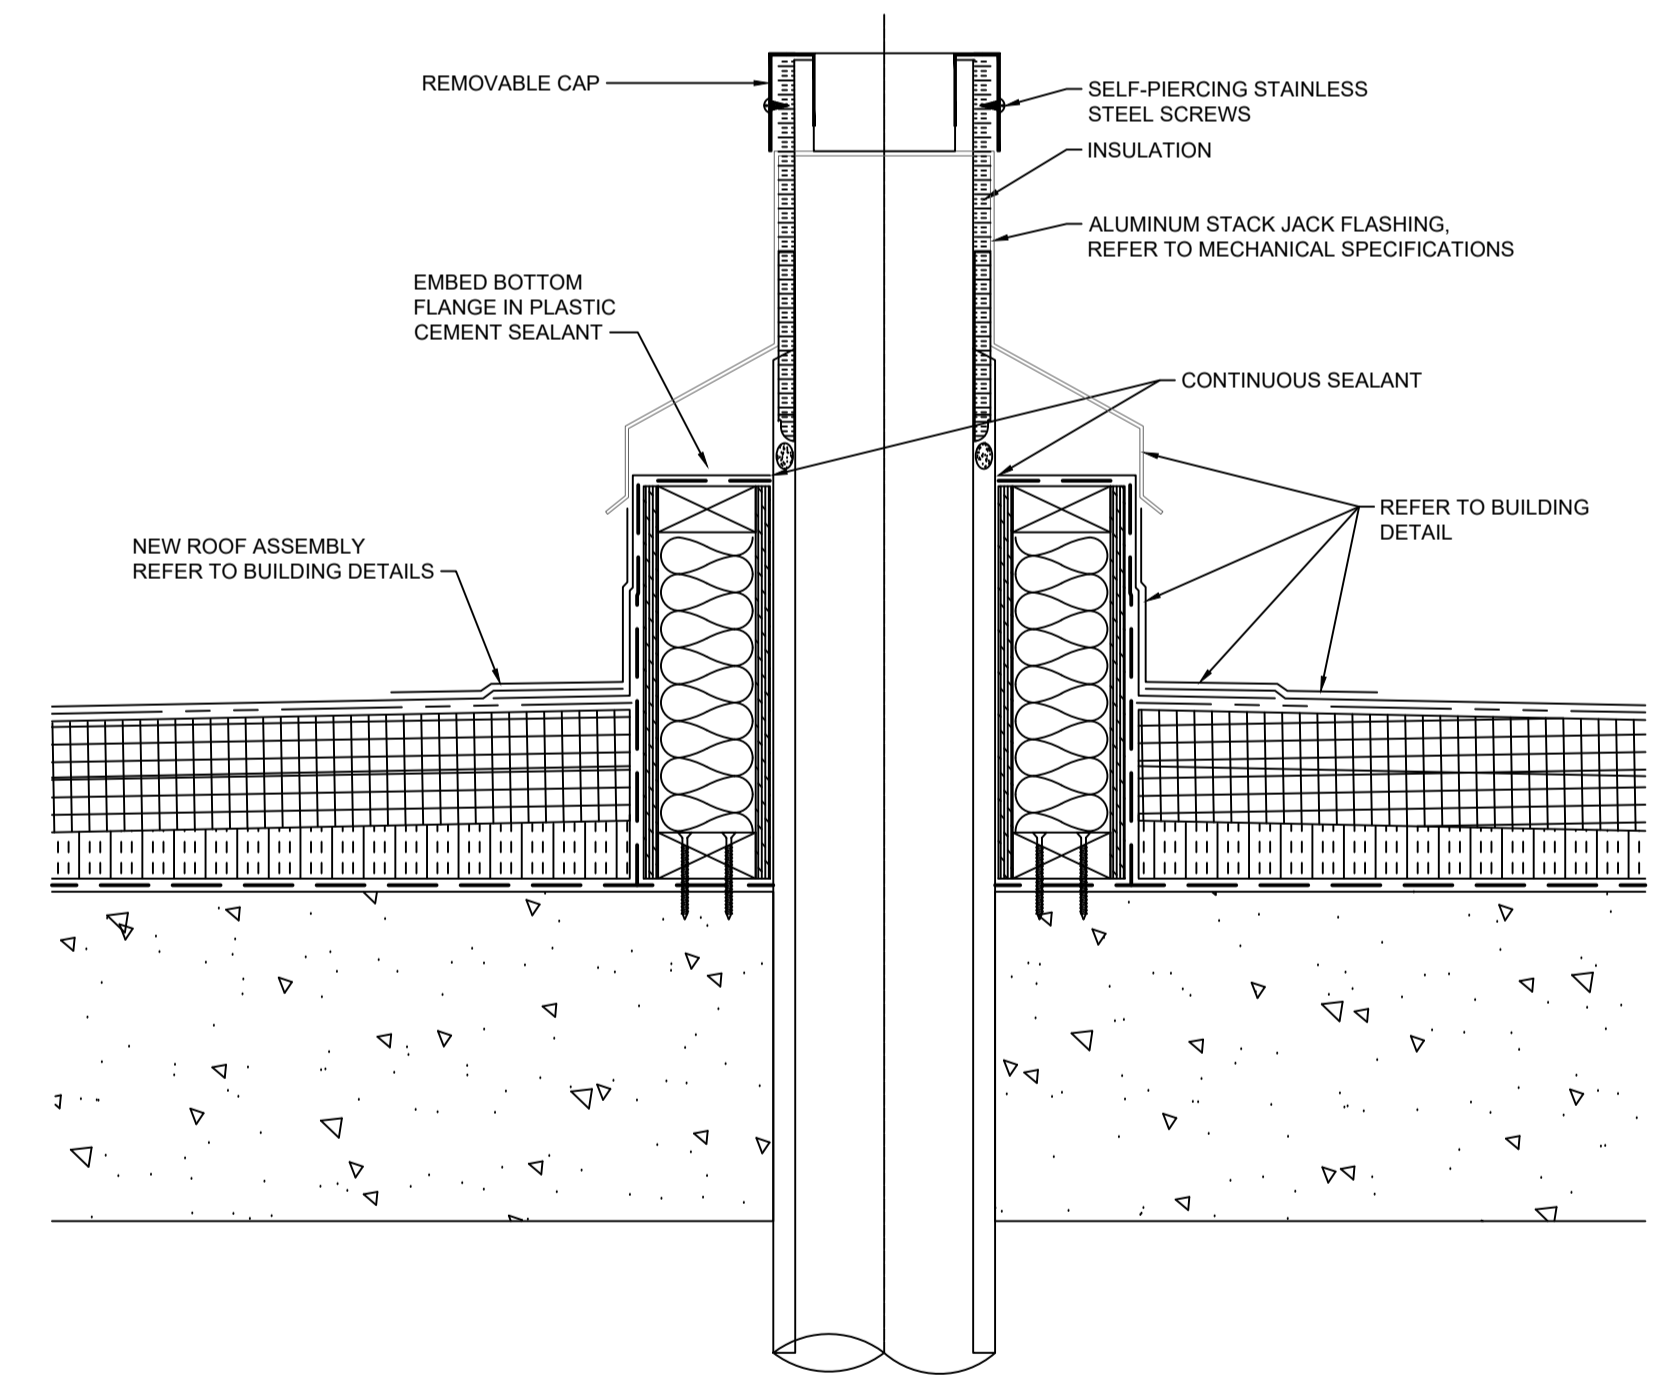

5 PLUMBING VENT THROUGH ROOF
SCALE: NTS
M3.3

10		
9		
8		
7		
6		
5		
4		
3	1-0601B-B0076-008	BUILDING ROOF DETAILS 8 OF 9
2	1-0601B-B0076-007	BUILDING ROOF DETAILS 7 OF 9
1	1-0601B-B0076-003	BUILDING ROOF DETAILS 3 OF 9
NO.	DRAWING NUMBER	REFERENCE DRAWING TITLE



B.M. ELEV.					
DESIGNED BY	GR	CHECKED BY	GS		
DRAWN BY	GR	APPROVED BY	GS		
SCALE:	AS NOTED	RELEASED FOR CONSTRUCTION BY:	-		
00	ISSUED FOR TENDER	23/03/21	GS		
NO.	REVISIONS	DATE	BY	DATE	

SMS Engineering
770 Bradford Street Winnipeg, Canada (204) 775-0291 smseng.com
22-284-01

DESIGNED BY	GR	CHECKED BY	GS
DRAWN BY	GR	APPROVED BY	GS
SCALE:	AS NOTED	RELEASED FOR CONSTRUCTION BY:	-
00	ISSUED FOR TENDER	23/03/21	GS
NO.	REVISIONS	DATE	BY

ENGINEER'S SEAL
PROFESSOR OF HANNOVER
2023-03-21
D & D STEWART
Member 31816
REGISTERED PROFESSIONAL ENGINEER
CONSULTANT DRAWING NO. M3.3

THE CITY OF WINNIPEG
WATER AND WASTE DEPARTMENT
ENGINEERING DIVISION

DRINKING WATER TREATMENT PLANT
MAIN BUILDING
ROOF REPLACEMENT

MECHANICAL ROOF DETAILS

CITY FILE NUMBER **W-1049**
SHEET 1 OF 1
CITY DRAWING NUMBER 1-0601B-M0019-001