


LEGEND

- VACUUM
- SKIMMER
- DRAIN
- SIDE WALL DRAIN
- INLET
- DISCHARGE PIPING
- SUCTION PIPING

ISSUED FOR CONSTRUCTION

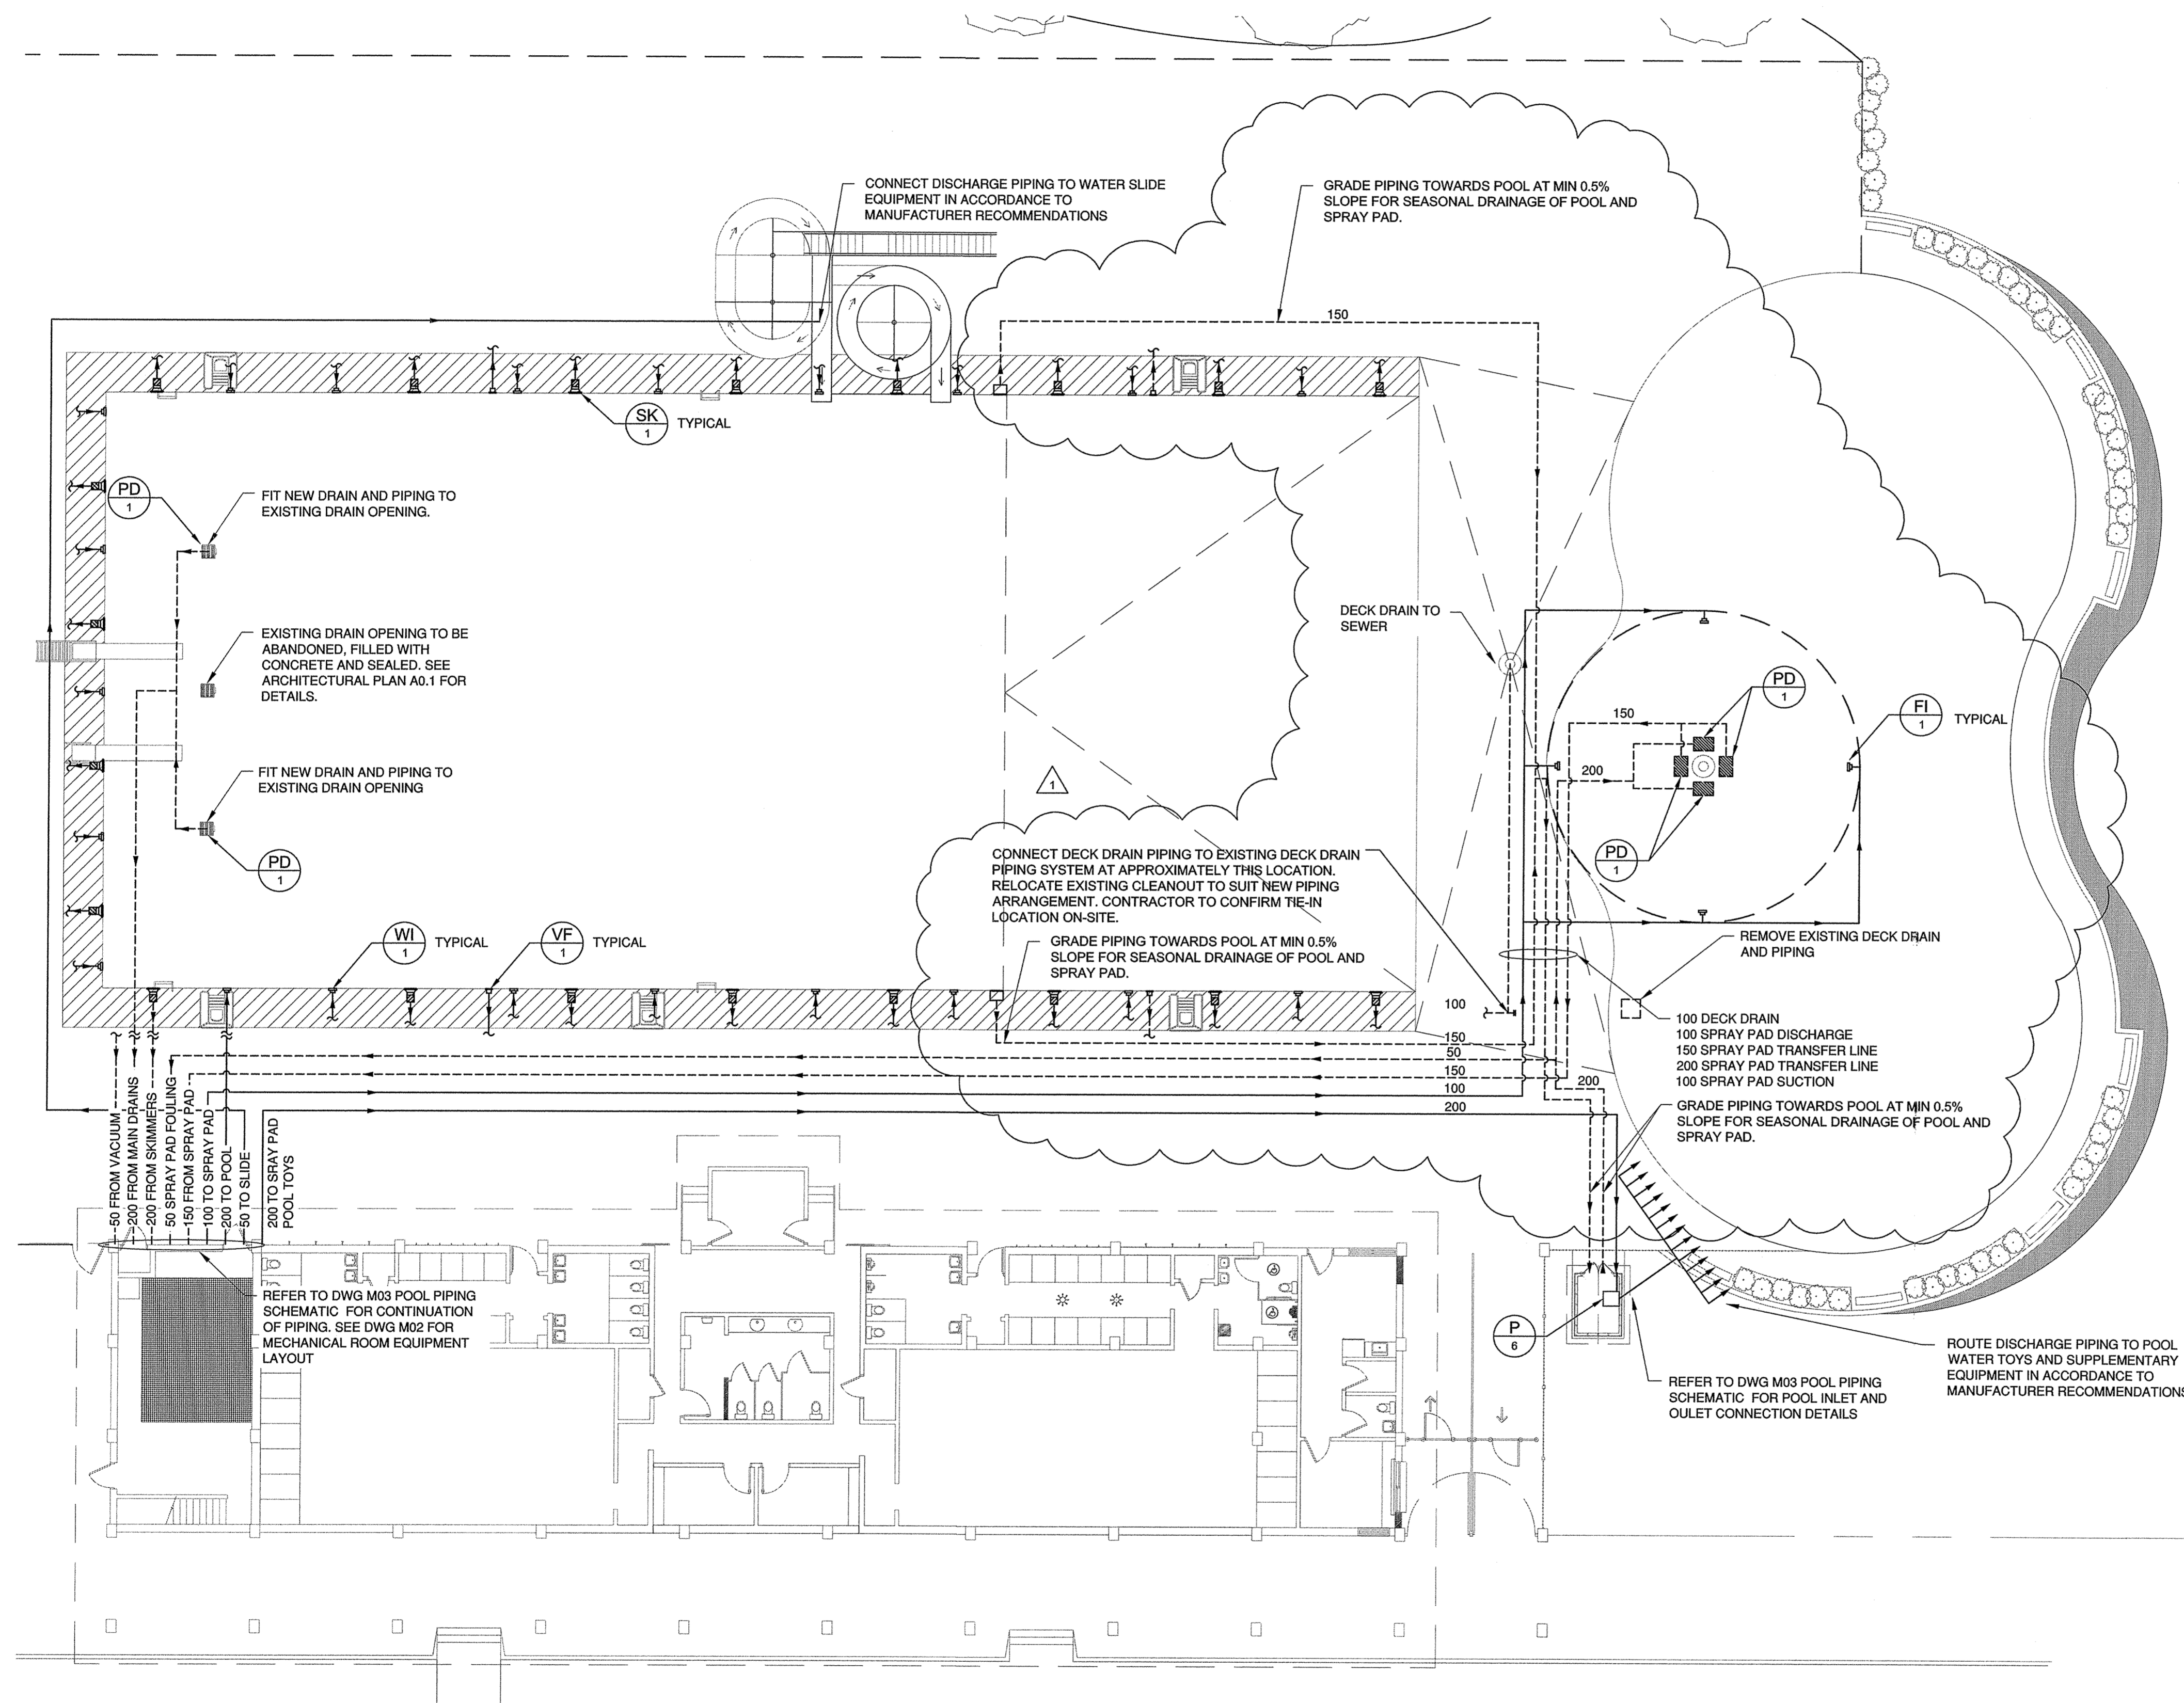

REV	DESCRIPTION	DATE	BY
1	MIXING PIPING REVISION	2009/09/17	E.G.

REV	DESCRIPTION	DATE	BY
1	MIXING PIPING REVISION	2009/09/17	E.G.

SEAL: **GENIVAR CONSULTANTS LIMITED PARTNERSHIP** No. 4388 Date August 20, 2009

SEAL: **E.W.G. GUEST** No. 1755

THIS DRAWING MUST NOT BE SCALED.
THE GENERAL CONTRACTOR SHALL VERIFY ALL DIMENSIONS, DATUMS AND LEVELS PRIOR TO COMMENCEMENT OF WORK AND IS HELD RESPONSIBLE FOR REPORTING ANY DISCREPANCY OR OMISSION TO NEIL COOPER ARCHITECT INC IMMEDIATELY.
THIS DRAWING AND DESIGN MAY NOT BE USED ON OTHER PROJECTS WITHOUT WRITTEN PERMISSION FROM GENIVAR CONSULTANTS LIMITED PARTNERSHIP.

DRAWING: **POOL PIPING SITE PLAN**

PROJECT: **KILDONAN PARK URBAN OASIS**

Winnipeg, Manitoba

Neil Cooper Architect Inc.
10-395 Berry Street, Winnipeg, Manitoba R3J 1N6

DRAWN BY: D.M.	CHECKED BY: E.G.	SHEET NO: M011	REV NO:
DATE: SEP 17, 2009		SCALE: N.T.S.	
FILE: WE-09-103-00-WE			

POOL PIPING SITE PLAN
N.T.S.