


GENERAL NOTES:

- CONTRACTOR TO CONDUCT ALL UTILITY AND SITE SERVICE LOCATES PRIOR TO PROCEEDING WITH EXCAVATION. LOCATES TO INCLUDE POWER FEEDERS, COMMUNICATION AND SECURITY SYSTEMS. PROVIDE 10 WORKING DAYS NOTICE TO CLIENT REPRESENTATIVE FROM DATE OF PROPOSED WORK COMMENCEMENT. COORDINATE AND ARRANGE WITH CLIENT REPRESENTATIVE FOR SCHEDULING OF UTILITY LOCATES.
- UPON COMPLETION OF SITE LOCATES PROVIDE A WRITTEN LIST IDENTIFYING ANY AREAS OF CONFLICTS ALONG WITH RECOMMENDATIONS FOR CHANGES TO THE WORK SEQUENCE FOR REVIEW BY CLIENT REPRESENTATIVE.
- CONTRACTOR TO REMEDIATE ALL DISTRIBUTED AREAS, WITHIN THE SCOPE OF THIS PROJECT AND RETURN TO ORIGINAL CONDITION. CONTRACTOR TO CARRY ALL COSTS ASSOCIATED WITH REMEDIATION.
- CONTRACTOR TO DIRECTIONALLY DRILL ALL DUCTS BETWEEN POLES. DUCTS TO BE A MINIMUM OF 650MM BELOW FINISHED GRADE. MINIMUM DUCT SIZED BE 50MM HDPE.
- MINIMUM WIRE SIZE FOR CIRCUITS TO BE #10 AWG RATED FOR DIRECT BURIAL. PROVIDE SPLICE KITS SUITABLE FOR DIRECT BURIAL. STANDARD OF ACCEPTANCE: TYCO GEL FILLED CAP AND CONNECTOR TYPE GELCAP-SL- SERIES.
- CONTRACTOR TO COORDINATE ACCESSIBILITY TO SITE WITH OWNERS REPRESENTATIVE.

1 SITE PLAN - LIGHTING
E-201 1:1000

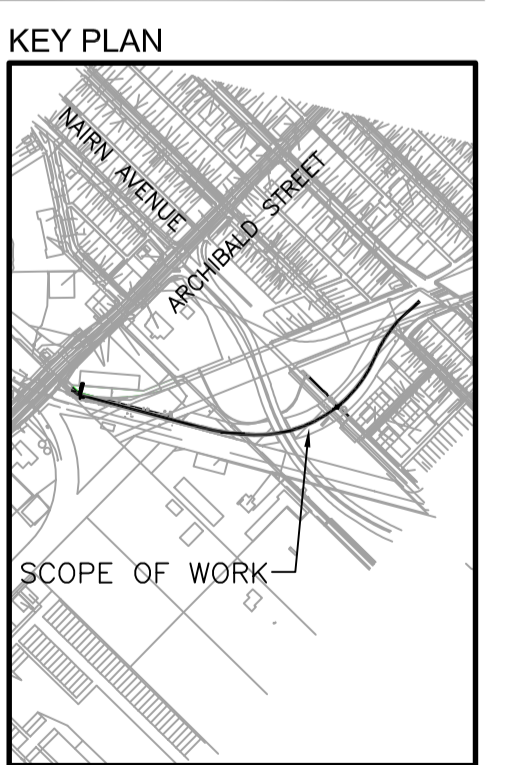

METRIC
WHOLE NUMBERS INDICATE MILLIMETRES
DECIMALIZED NUMBERS INDICATE METRES

EXISTING		LEGEND-PLAN		PROPOSED		EXISTING		LEGEND-PLAN		PROPOSED		EXISTING		LEGEND-PROFILE		PROPOSED	
<p>POLE MOUNTED LUMINAIRE</p> <p>LOCATION APPROVED UNDERGROUND STRUCTURES</p> <p>SUPV. U/G STRUCTURES COMMITTEE DATE</p> <p>NOTE: LOCATION OF UNDERGROUND STRUCTURES AS SHOWN ARE BASED ON THE BEST INFORMATION AVAILABLE BUT NO GUARANTEE IS GIVEN THAT ALL EXISTING UTILITIES ARE SHOWN OR THAT THE GIVEN LOCATIONS ARE EXACT. CONFIRMATION OF EXISTENCE AND EXACT LOCATION OF ALL SERVICES MUST BE OBTAINED FROM THE INDIVIDUAL UTILITIES BEFORE PROCEEDING WITH CONSTRUCTION.</p>																	
<p>B.M. BM52-16 ELEV. 232.706</p> <p>Stantec 500 - 311 Portage Avenue, Winnipeg MB Canada www.stantec.com</p> <p>DESIGNED BY: S.S. CHECKED BY: A.A. DRAWN BY: E.D. APPROVED BY: S.S.</p> <p>HOR. SCALE: 1:1000 VERTICAL: N/A</p> <p>RELEASED FOR CONSTRUCTION: _____</p> <p>NO. REVISIONS: _____ DATE: 2023.06.30 BY: _____</p> <p>ISSUED FOR TENDER: 24.01.23 S.S.</p>																	
<p>ENGINEER'S SEAL: PROVINCE OF MANITOBA, S. SHARMA, Member, 40584, 2024-01-25</p> <p>THE CITY OF WINNIPEG PUBLIC WORKS DEPARTMENT ENGINEERING DIVISION</p> <p>Winnipeg</p> <p>NORTH EAST PIONEERS GREENWAY ACTIVE TRANSPORTATION PATH ELECTRICAL - SITE PLAN - LIGHTING</p> <p>CONSULTANT DRAWING NO. E-201</p>																	
<p>SHEET 4 OF 5 CAD FILE DRAWING NUMBER 07560e-201-xxx.dwg CITY DRAWING NUMBER P-3578-4</p>																	

\\c0005-p5-p401\workgroup\1137\active\113707560\0300_drawing\0302_sheet\sheet_08_electrical\07560e-201-xxx.dwg
 2024/01/25 12:24 PM 2024/01/25 12:24 PM 2024/01/25 12:24 PM