

Copyright Reserved
 The Contractor shall verify and be responsible for all dimensions.
 DO NOT scale the drawing - any errors or omissions shall be reported
 to Stantec without delay.
 The Copyrights to all designs and drawings are the property of Stantec.
 Reproduction or use for any purpose other than that authorized by
 Stantec is forbidden.

Client

Legend

Notes

Revision By Appd. YY.MM.DD

0 ISSUED FOR CONSTRUCTION CB AA 23.09.18

Issued By Appd. YY.MM.DD

File Name: 115423001e_e-002m CB AA CB 22.05.27
 Dwn. Chkd. Dsgn. YY.MM.DD

Permit-Seal




Client/Project
 WINNIPEG TRANSIT DIRECT CURRENT FAST
 CHARGING BUS STATIONS BRANDON GARAGE

600 Brandon Ave. Winnipeg, Manitoba

Title
 ELECTRICAL SITE PLAN
 GENERAL ARRANGEMENT

Project No. 144523001 Scale As Indicated

Drawing No. E-002 Sheet 2 of 12 Revision 0

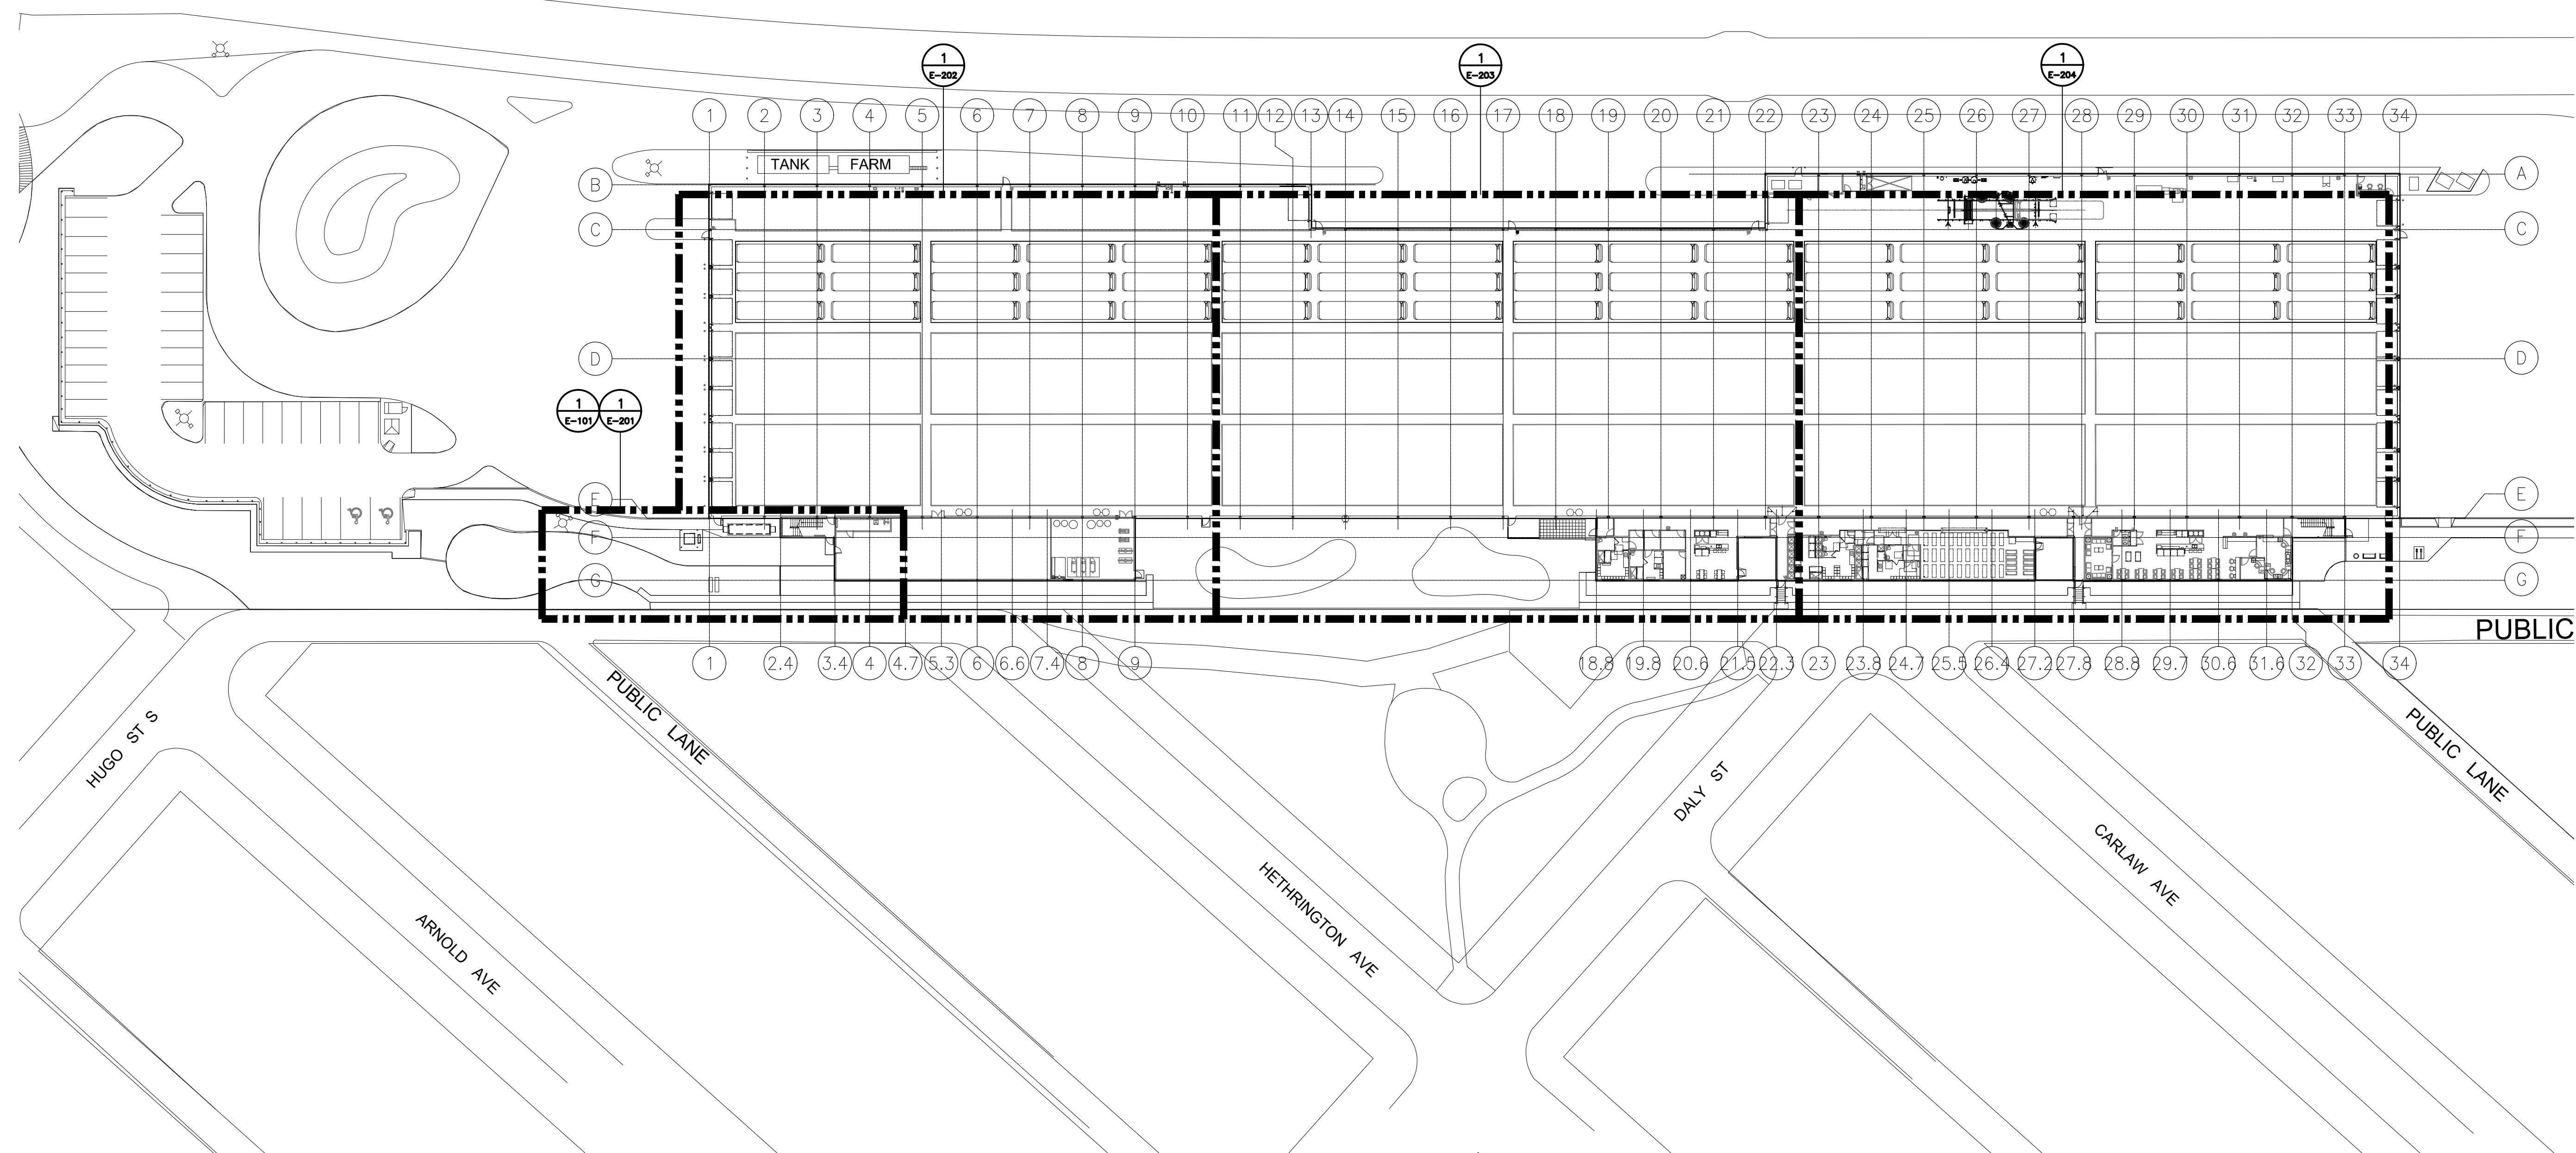

 1 ELECTRICAL SITE PLAN GENERAL ARRANGEMENT
 E-002 1:500

I:\CA0045\PP\301\Shared Project\115423001\1_electrical\01_cad\01_sheets\115423001_e_e-002m.dwg E-002
 2023/11/07 11:52 AM By: Chan, Howard
 ORIGINAL SHEET - ISO ARCH D - v17.05