

DRAWING INDEX

STRUCTURAL

- S0.1 SITE PLAN AND DRAWING INDEX
- S0.2 STRUCTURAL GENERAL NOTES, LEGEND AND ABBREVIATIONS
- S0.3 PUBLIC AND CONTRACTOR AREAS - SITE PLAN
- S0.4 PUBLIC AND CONTRACTOR AREAS - BASEMENT PLAN
- S0.5 PUBLIC AND CONTRACTOR AREAS - MAIN FLOOR PLAN
- S2.1 EAST EXIT - PARTIAL BASEMENT AND MAIN FLOOR PLAN
- S2.2 FAN UNIT ALTERATIONS - MAIN FLOOR PLAN
- S2.3 POOL AREA - PARTIAL MAIN FLOOR FRAMING PLAN - STRUCTURAL REPAIRS
- S2.4 POOL AREA - PARTIAL BASEMENT FLOOR PLAN
- S2.5 POOL AREA - PARTIAL MAIN FLOOR PLAN - DEMOLITION TILING AND WATERPROOFING
- S2.6 POOL AREA - PARTIAL MAIN FLOOR PLAN - NEW CONSTRUCTION
- S2.7 SPLASH PAS AREA - PARTIAL MAIN FLOOR PLAN AND DETAILS
- S3.1 POOL AREA - TANK ELEVATIONS - DEMOLITION
- S3.2 POOL AREA - TANK ELEVATIONS - NEW CONSTRUCTION
- S5.1 STRUCTURAL DETAILS
- S5.2 STRUCTURAL DETAILS
- S5.3 STRUCTURAL DETAILS
- S5.4 STRUCTURAL DETAILS
- S5.5 TILING AND WATERPROOFING DETAILS
- S5.6 TILING AND WATERPROOFING DETAILS

ARCHITECTURAL


- A2.1 POOL PLAN AND DETAILS
- A4.1 POOL SECTIONS
- A6.1 POOL DETAILS
- A6.2 ENLARGED POOL DETAILS

ELECTRICAL

- E0.1 ELECTRICAL SYMBOLS AND ABBREVIATIONS
- ED2.1 MAIN FLOOR - DEMOLITION PLAN
- ED2.2 BASEMENT - DEMOLITION PLAN
- ELP2.1 MAIN FLOOR - LIGHTING & POWER
- EL2.2 BASEMENT - LIGHTING & POWER

MECHANICAL

- M0.1 MECHANICAL SYMBOLS
- MD2.0 BASEMENT - DEMOLITION PLAN
- MD2.1 MAIN FLOOR - DEMOLITION PLAN
- MP2.1 MAIN FLOOR - PLUMBING PLAN
- MH2.1 MAIN FLOOR - HVAC PLAN

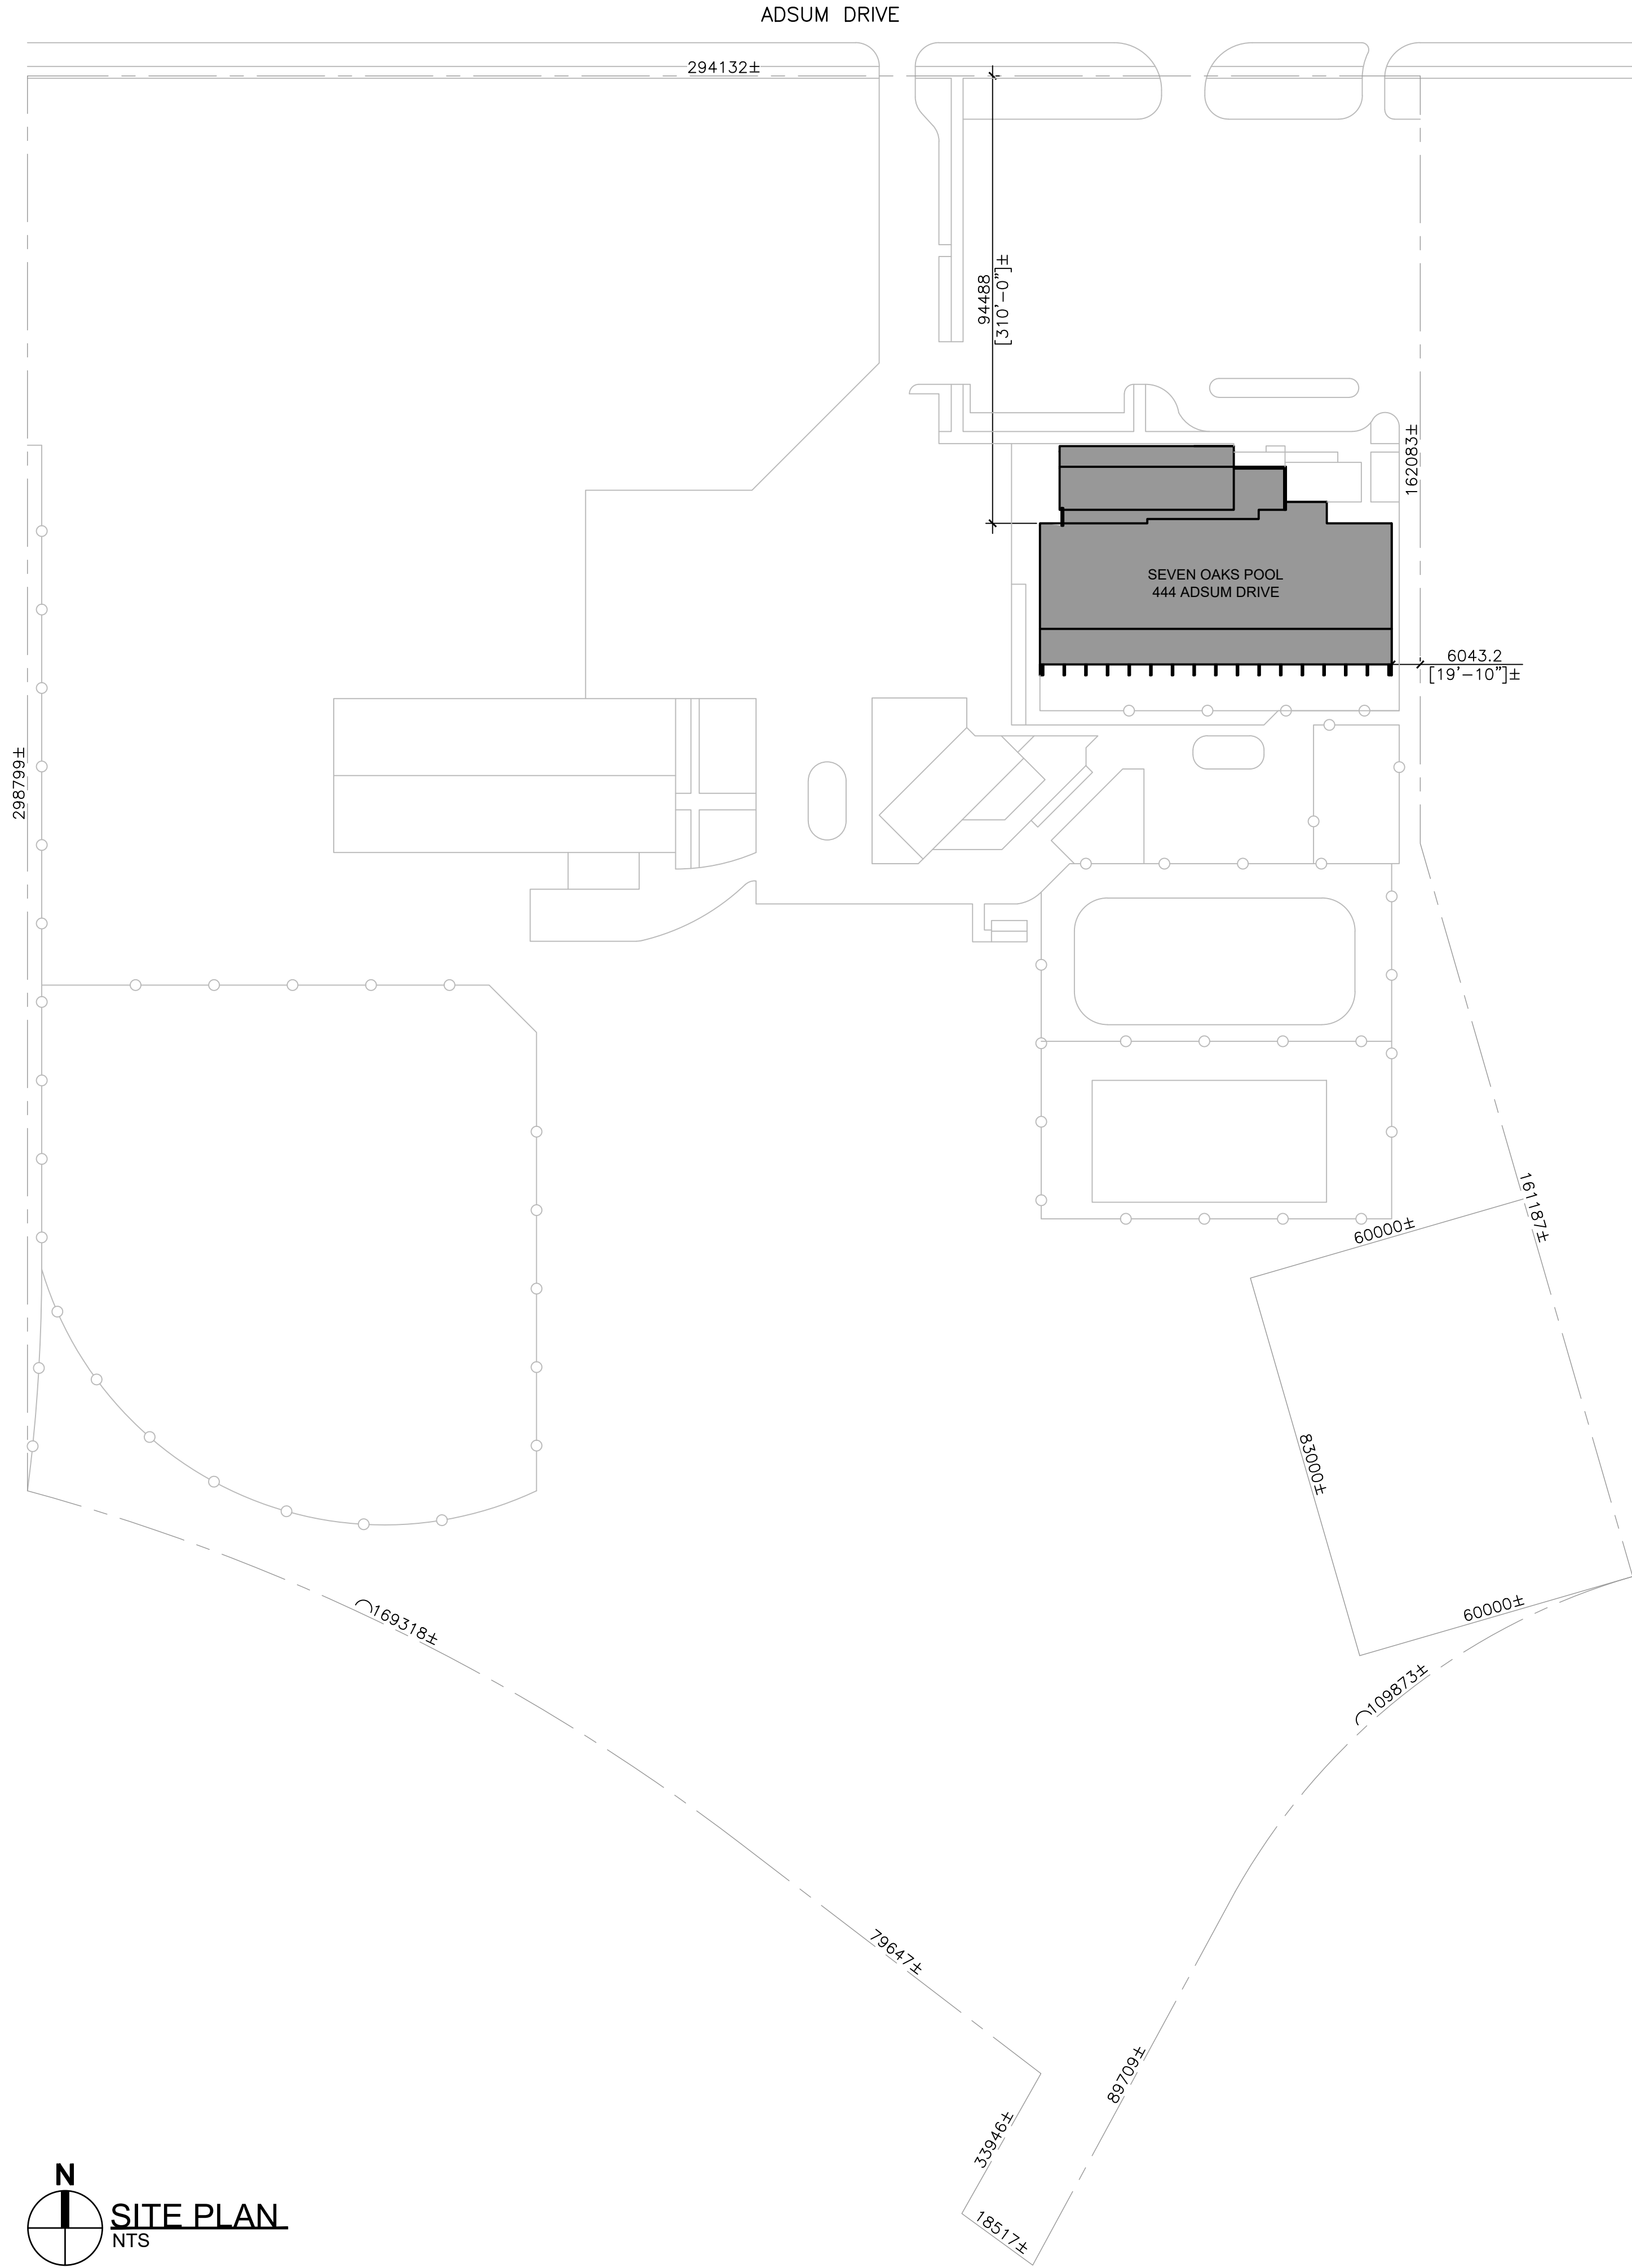

0	ISSUED FOR CONSTRUCTION	TRB	07-07 2025
No.	REVISION/DESCRIPTION	BY	DATE

SEAL



2025.07.07	TRB	ACG	TRB	TRB
DATE	DESIGNED	DRAWN	CHECKED	APPROVED

Winnipeg THE CITY OF WINNIPEG
ASSETS & PROJECT MANAGEMENT
DEPARTMENT
MUNICIPAL ACCOMMODATIONS DIVISION
3-65 GARRY STREET, R3C 4K4

PROJECT
**SEVEN OAKS POOL
POOL RENEWAL**

444 ADSUM DRIVE
SHEET TITLE
SITE PLAN AND DRAWING INDEX

SCALE	PROJECT No:	SHEET No:
AS SHOWN	2023-0220	S0.1