

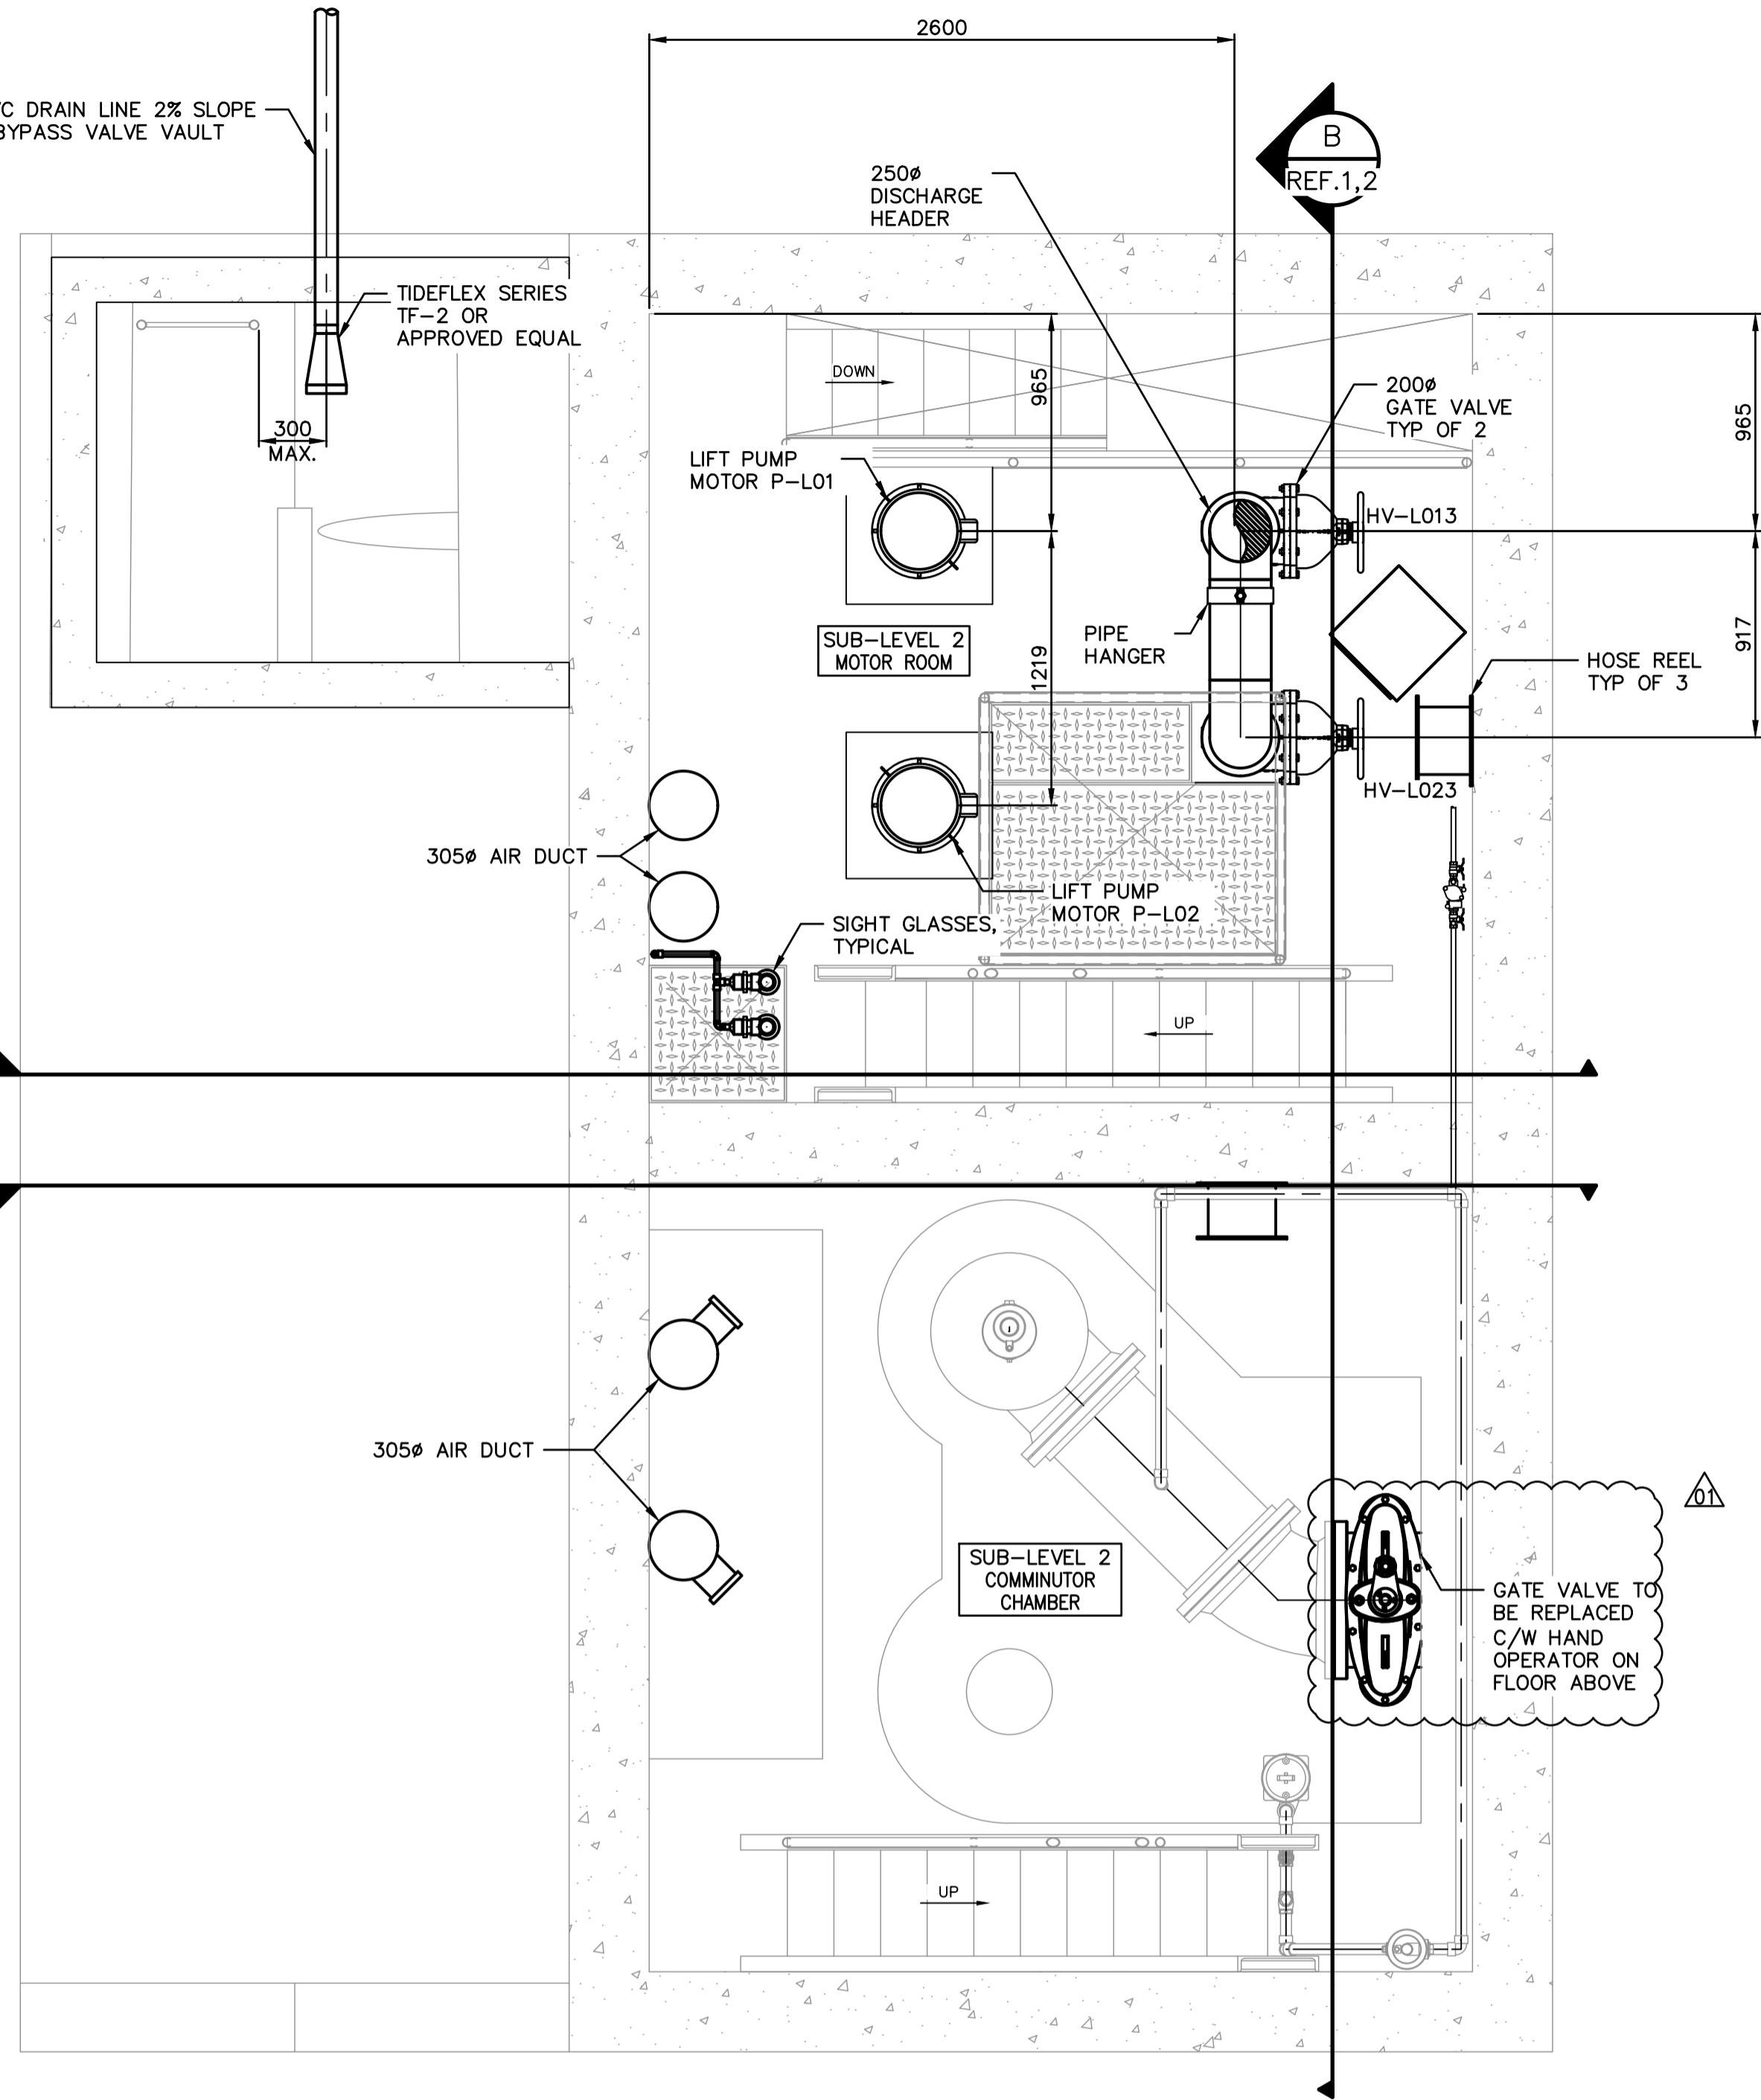


100 PVC DRAIN LINE 2% SLOPE FROM BYPASS VALVE VAULT

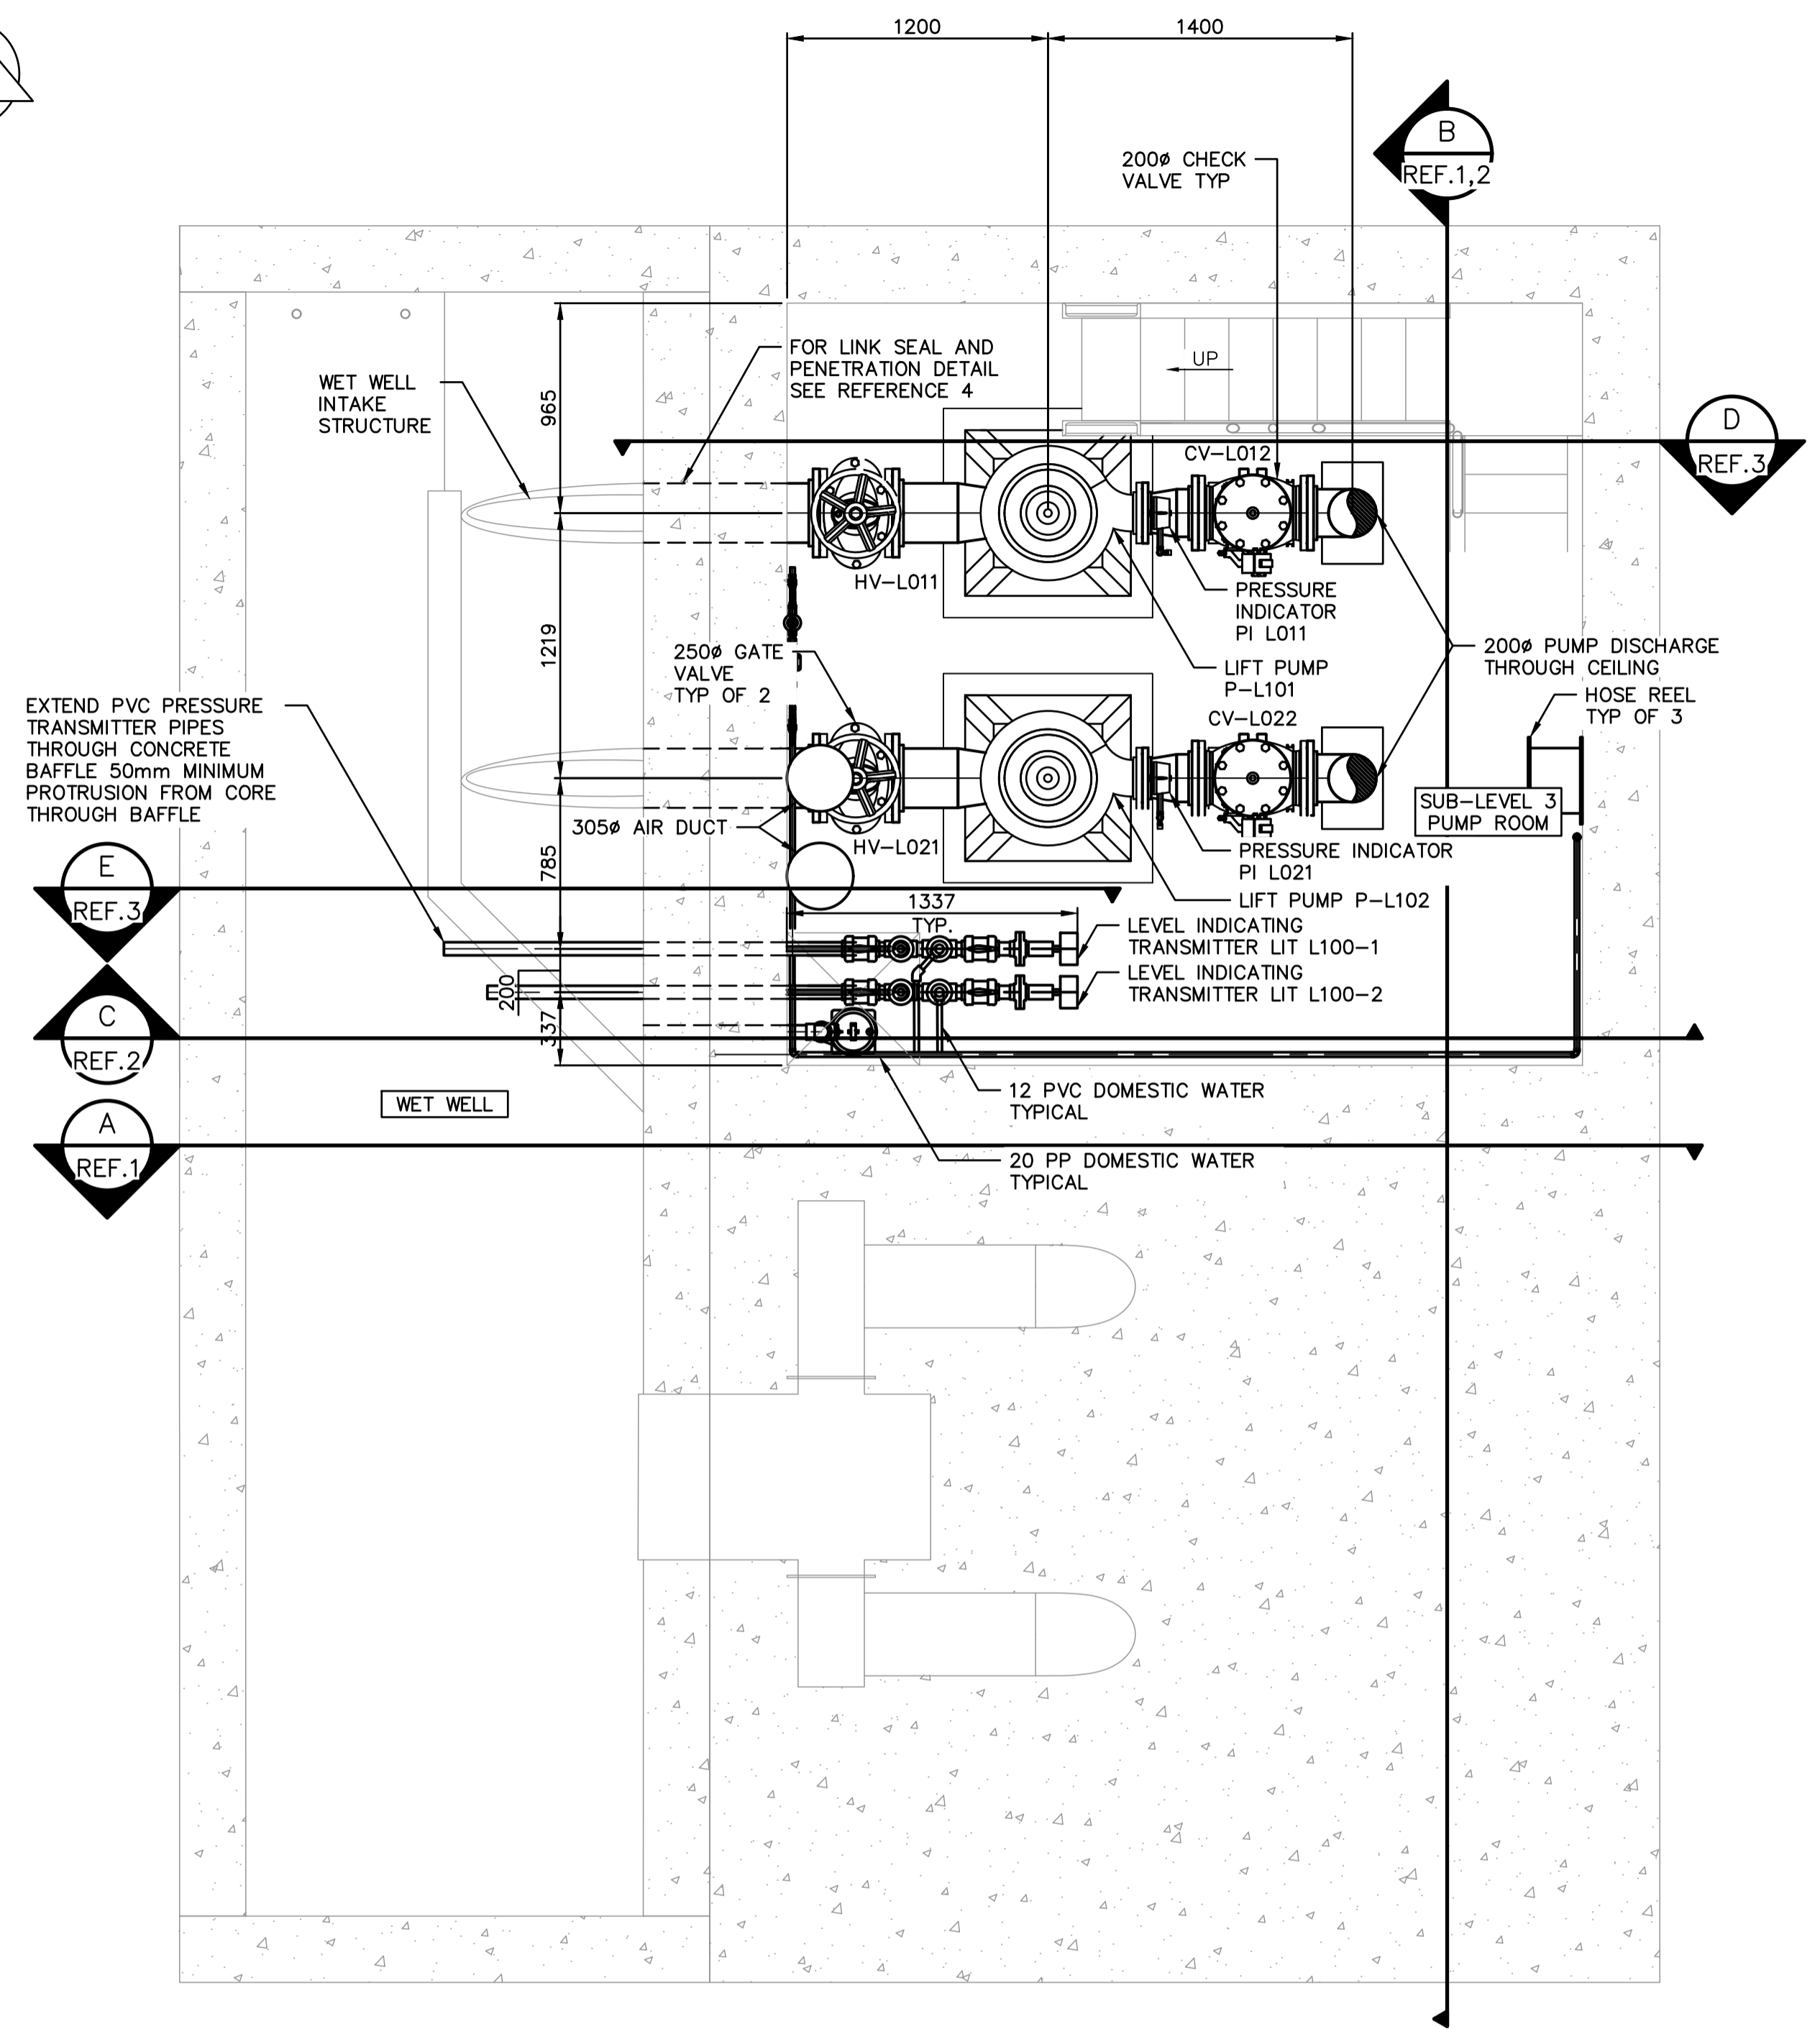


MOTOR ROOM FLOOR PLAN
SCALE: 1:25

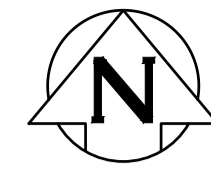

PUMP ROOM FLOOR PLAN
SCALE: 1:25


GENERAL NOTES:

- PERFORM WORK IN ACCORDANCE WITH ALL APPLICABLE CODES AND REGULATION.
- EQUIPMENT LOCATIONS AND PIPE ROUTING IN THE DRAWING IS APPROXIMATE ONLY. CONFIRM ALL LOCATIONS IN THE FIELD. LISTED DIMENSIONS ARE APPROXIMATE AND ARE ONLY INTENDED FOR BIDDING PURPOSES. THE CONTRACTOR IS RESPONSIBLE TO VERIFY ALL DIMENSIONS AND ROUTING IN THE FIELD FOR ORDERING EQUIPMENT AND COMMENCING INSTALLATION WITHOUT EXTRA CHARGES TO THE PROJECT.
- CONTRACTOR TO ENSURE PIPES ARE ADEQUATELY SUPPORTED AGAINST MOVEMENT PRIOR TO PRESSURIZATION.
- ALL EQUIPMENT SHOWN ON THIS DRAWING IS NEW AND IS TO BE PROVIDED BY THE CONTRACTOR UNLESS OTHERWISE INDICATED AS EXISTING.

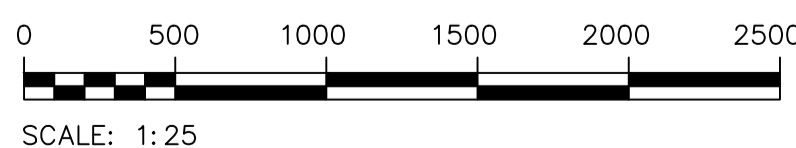

SCALE: 1:25


METRIC
WHOLE NUMBERS INDICATE MILLIMETRES
DECIMALIZED NUMBERS INDICATE METRES
UNLESS OTHERWISE NOTED

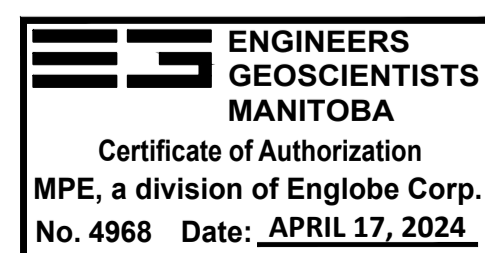

10		
9		
8		
7		
6		
5		
4	1-0131L-S0003-001-00	PUMP ROOM, WET WELL & COMMUNICATOR CHAMBER PLAN
3	1-0131L-M0010-001-00	LIFT PUMPS & LEVEL GAUGE DETAILS
2	1-0131L-M0009-001-00	PROCESS & MECHANICAL SECTION 2
1	1-0131L-M0008-001-00	PROCESS & MECHANICAL SECTION 1
NO.	DRAWING NUMBER	REFERENCE DRAWING TITLE
REFERENCE DRAWINGS		

B.M. ELEV.	NO.	REVISIONS	DATE	BY
	1	ADDENDUM 01, RE-ISSUED FOR CONSTRUCTION	2024-04-17	
	0	ISSUED FOR CONSTRUCTION	2024-03-22	

DESIGNED BY	B. BAKER
CHECKED BY	
DRAWN BY	D. MCMILLAN
APPROVED BY	
SCALE:	AS SHOWN
HORIZONTAL	
VERTICAL	
DATE	2024-03-19
PLOT DATE:	2024 04 17

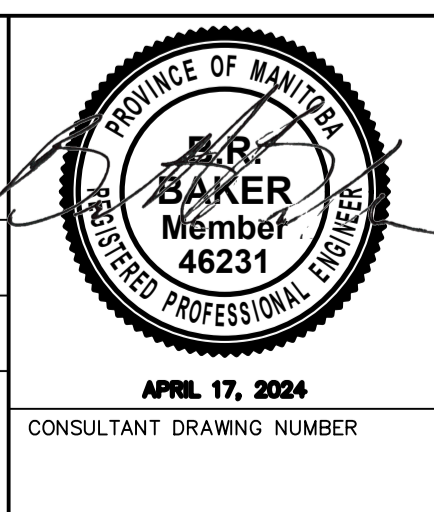

THE CITY OF WINNIPEG
WATER AND WASTE DEPARTMENT
ENGINEERING DIVISION

CONWAY LIFT PUMPING STATION
2024 UPGRADES
MECHANICAL PLAN
PLANS AND SECTIONS
MOTOR & PUMP ROOM PROCESS PIPING PLAN

CITY DRAWING NUMBER **1-0131L-M0005-001-01** SHEET **33** OF **102**