



MOTOR ROOM FLOOR PLAN
SCALE: 1:25

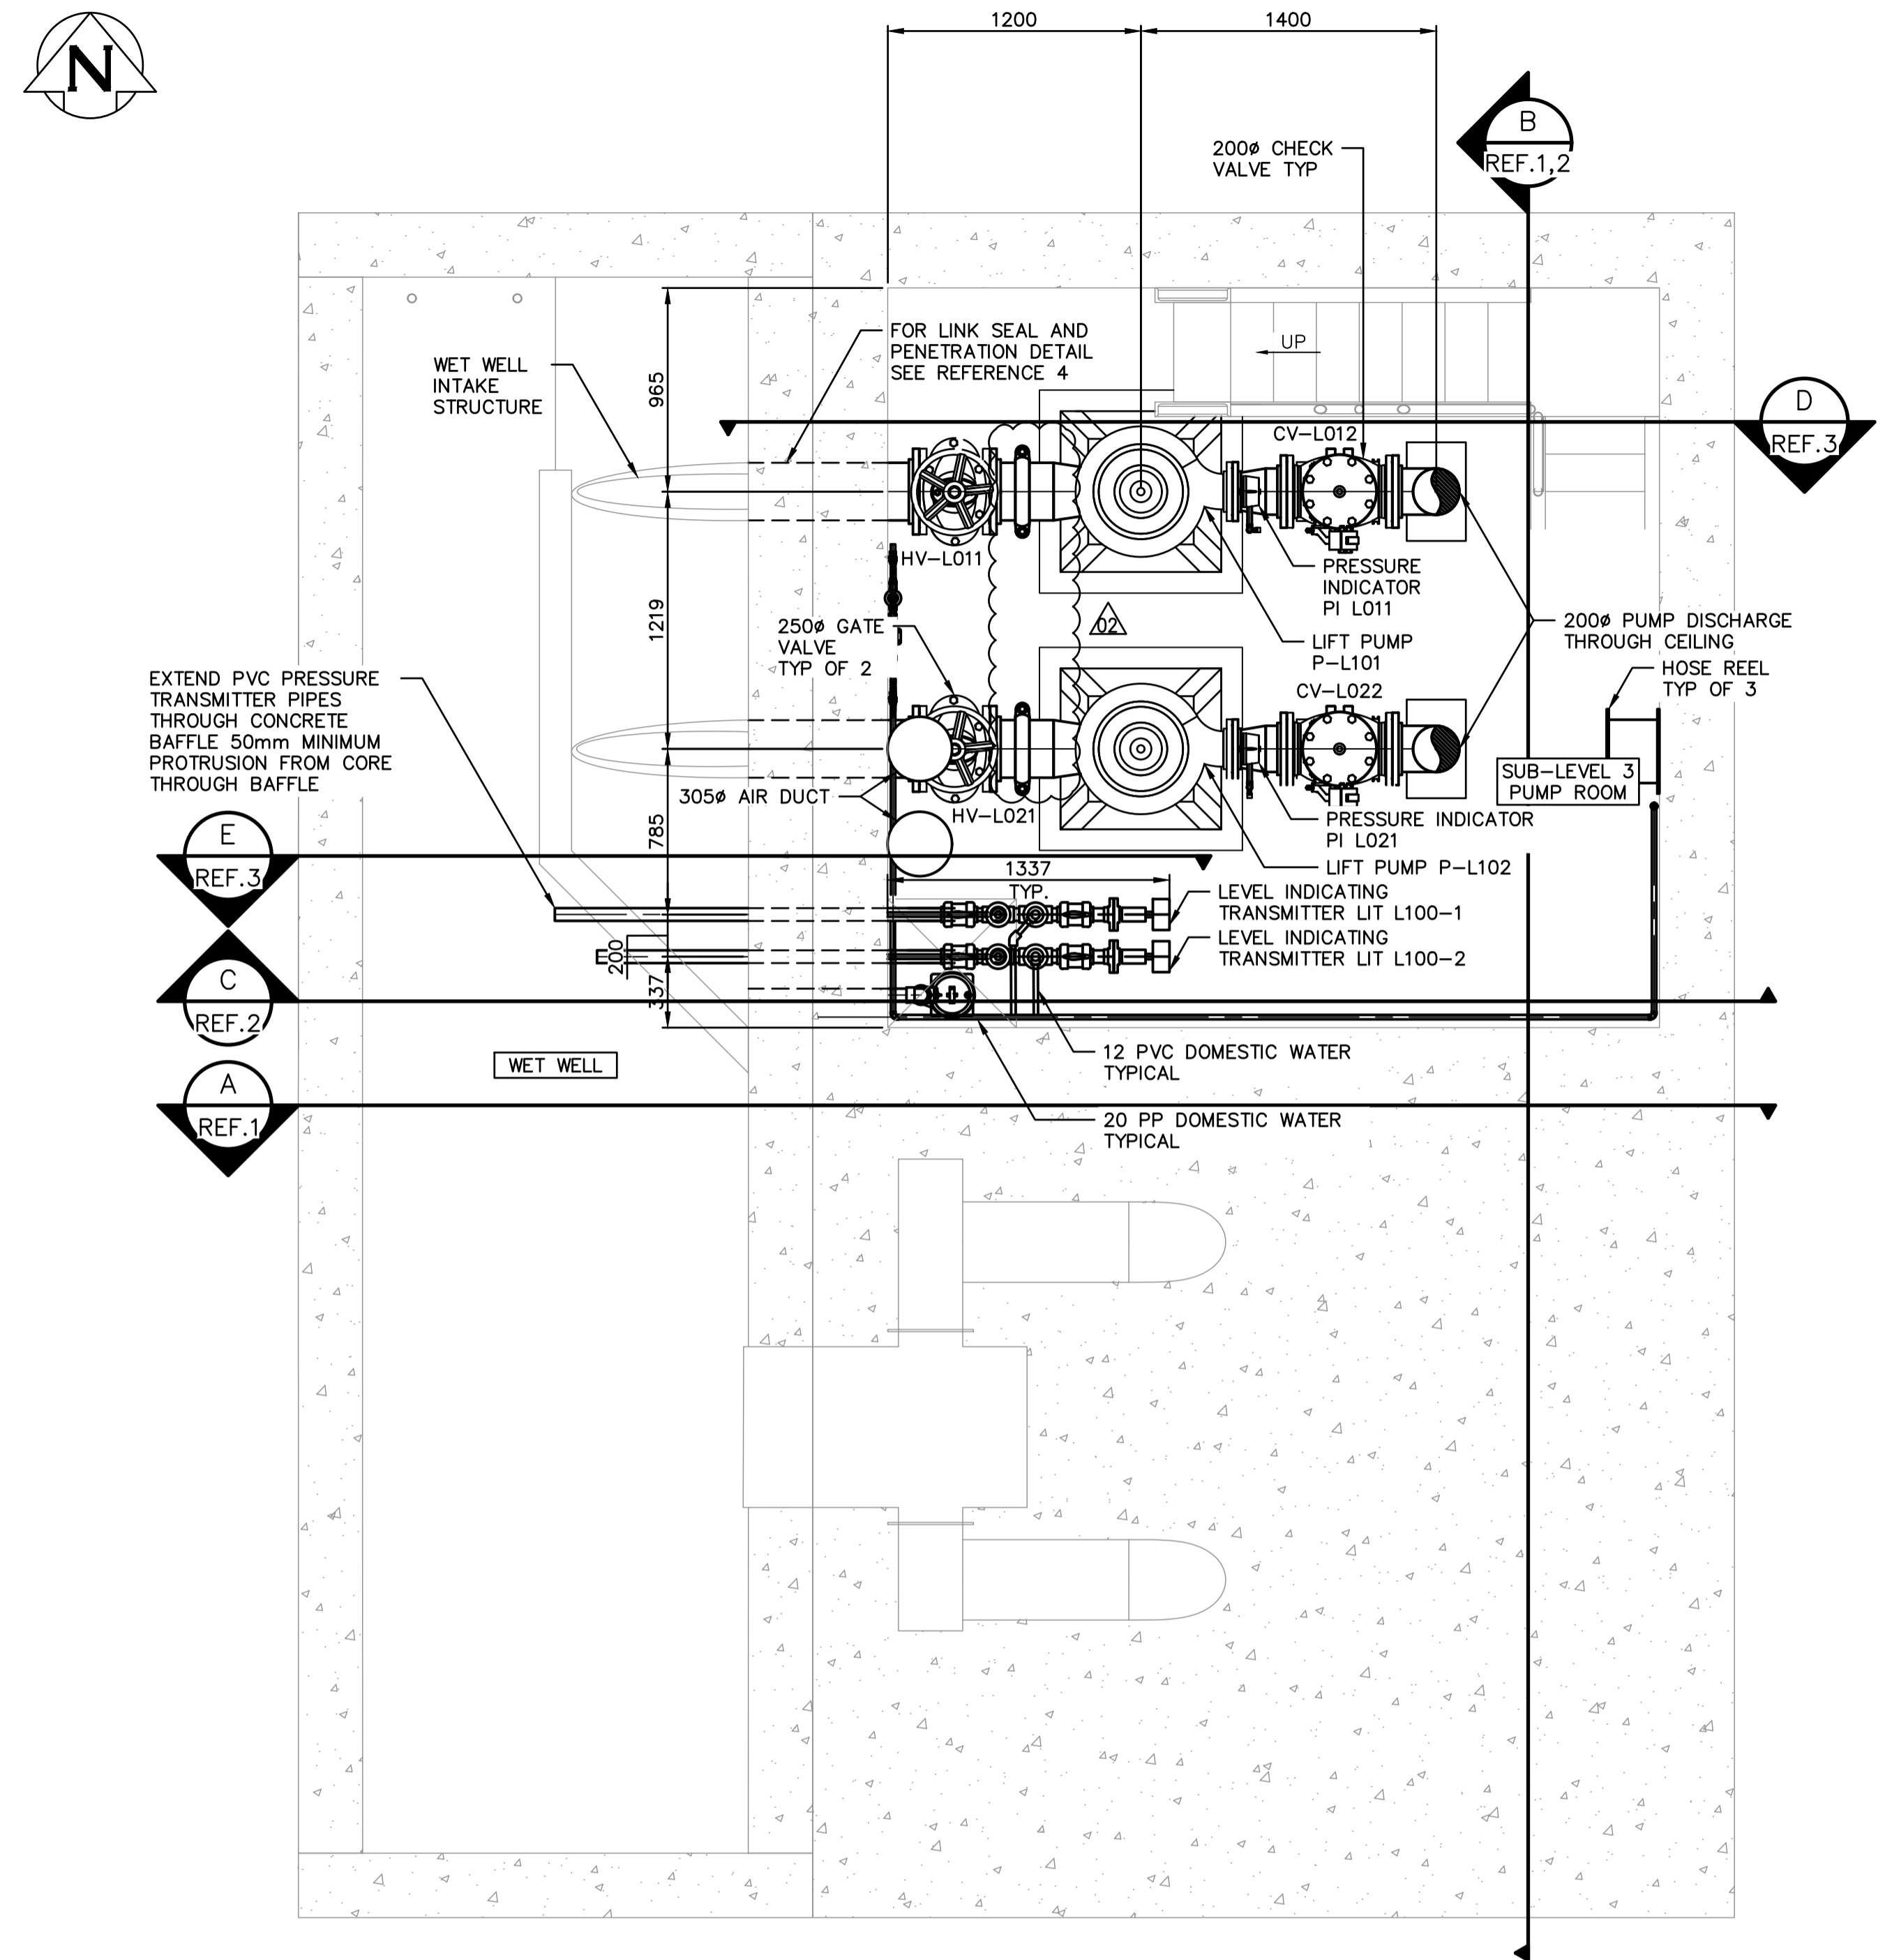

PUMP ROOM FLOOR PLAN
SCALE: 1:25

- GENERAL NOTES:
- PERFORM WORK IN ACCORDANCE WITH ALL APPLICABLE CODES AND REGULATION.
 - EQUIPMENT LOCATIONS AND PIPE ROUTING IN THE DRAWING IS APPROXIMATE ONLY. CONFIRM ALL LOCATIONS IN THE FIELD. LISTED DIMENSIONS ARE APPROXIMATE AND ARE ONLY INTENDED FOR BIDDING PURPOSES. THE CONTRACTOR IS RESPONSIBLE TO VERIFY ALL DIMENSIONS AND ROUTING IN THE FIELD FOR ORDERING EQUIPMENT AND COMMENCING INSTALLATION WITHOUT EXTRA CHARGES TO THE PROJECT.
 - CONTRACTOR TO ENSURE PIPES ARE ADEQUATELY SUPPORTED AGAINST MOVEMENT PRIOR TO PRESSURIZATION.
 - ALL EQUIPMENT SHOWN ON THIS DRAWING IS NEW AND IS TO BE PROVIDED BY THE CONTRACTOR UNLESS OTHERWISE INDICATED AS EXISTING.

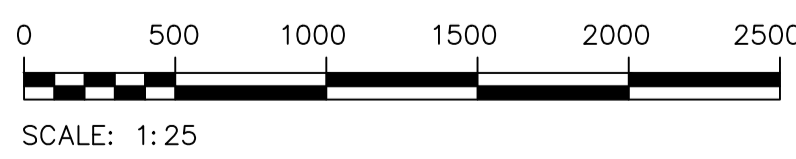

METRIC
WHOLE NUMBERS INDICATE MILLIMETRES
DECIMALIZED NUMBERS INDICATE METRES
UNLESS OTHERWISE NOTED

10		
9		
8		
7		
6		
5		
4	1-0131L-S0003-001-01	PUMP ROOM, WET WELL & COMMUNICATOR CHAMBER PLAN
3	1-0131L-M0010-001-01	LIFT PUMPS & LEVEL GAUGE DETAILS
2	1-0131L-M0009-001-01	PROCESS & MECHANICAL SECTION 2
1	1-0131L-M0008-001-01	PROCESS & MECHANICAL SECTION 1
NO.	DRAWING NUMBER	REFERENCE DRAWING TITLE
REFERENCE DRAWINGS		

B.M. ELEV.			
2	ADDENDUM 03, RE-ISSUED FOR CONSTRUCTION	2024-04-26	
1	ADDENDUM 01, RE-ISSUED FOR CONSTRUCTION	2024-04-17	
0	ISSUED FOR CONSTRUCTION	2024-03-22	
NO.	REVISIONS	DATE	BY

MPE
a division of Englobe

DESIGNED BY: B. BAKER
CHECKED BY: P. GOERTZEN

DRAWN BY: D. MCMILLAN
APPROVED BY: P. GOERTZEN

SCALE: AS SHOWN
HORIZONTAL
VERTICAL

DATE: 2024-03-19

PLOT DATE: 2024 04 25

PROVINCE OF MANITOBA
BAKER
Member
46231
REGISTERED PROFESSIONAL ENGINEER

APRIL 26, 2024
CONSULTANT DRAWING NUMBER

THE CITY OF WINNIPEG
WATER AND WASTE DEPARTMENT
ENGINEERING DIVISION

Winnipeg

CONWAY LIFT PUMPING STATION
2024 UPGRADES
MECHANICAL PLAN
PLANS AND SECTIONS
MOTOR & PUMP ROOM PROCESS PIPING PLAN

CITY DRAWING NUMBER: 1-0131L-M0005-001-02

SHEET 33 OF 102

FILE PATH: M:\N-DATA\84\00 City of Winnipeg\005 - Conway Lift Station\Autodesk\ACAD\FILE NAME: M1.4-MECHANICAL PLAN_ADD03.dwg