


SPECIFIC ELECTRICAL NOTES

- 1 REFER TO DETAIL D2/E5.0 FOR INSTALLATION OF DUCT SMOKE DETECTORS.
- 2 REFER TO DETAIL D1/E5.0 FOR INSTALLATION OF TRANSFER SMOKE DETECTORS (TYPICAL). HRV-2 TO SHUT DOWN UPON ACTIVATION OF DAMPERS.
- 3 REFER TO DETAIL D2/E5.0 FOR INSTALLATION OF DUCT SMOKE DETECTORS (TYPICAL). HRV-1 TO SHUT DOWN UPON ACTIVATION OF DAMPERS.
- 4 REFER TO DETAIL D2/E5.0 FOR INSTALLATION OF DUCT SMOKE DETECTORS (TYPICAL). HRV-2 TO SHUT DOWN UPON ACTIVATION OF DAMPERS.
- 5 FIRE ALARM PULL STATION PROVIDED TO RELEASE DOOR D154B ELECTRIC STRIKE IN CASE OF EMERGENCY. PROVIDE SIGNAGE ON DOOR INDICATING, "IN CASE OF EMERGENCY, PULL PULL STATION TO RELEASE DOOR."
- 6 WIRE AND CONNECT SPRINKLER SYSTEM FLOW, TAMPER, PRESSURE AND TROUBLE SWITCHES AS REQUIRED BACK TO FIRE ALARM SYSTEM. CONFIRM EXACT LOCATIONS AND REQUIREMENTS WITH SPRINKLER SYSTEM INSTALLER ON SITE.

GENERAL ELECTRICAL NOTES

1. IF ANY FIRE SMOKE DAMPER ASSOCIATED WITH HRV-1 OR HRV-2 ARE ACTIVATED, SHUT DOWN ASSOCIATED UNIT AND ALL ASSOCIATED DAMPERS.

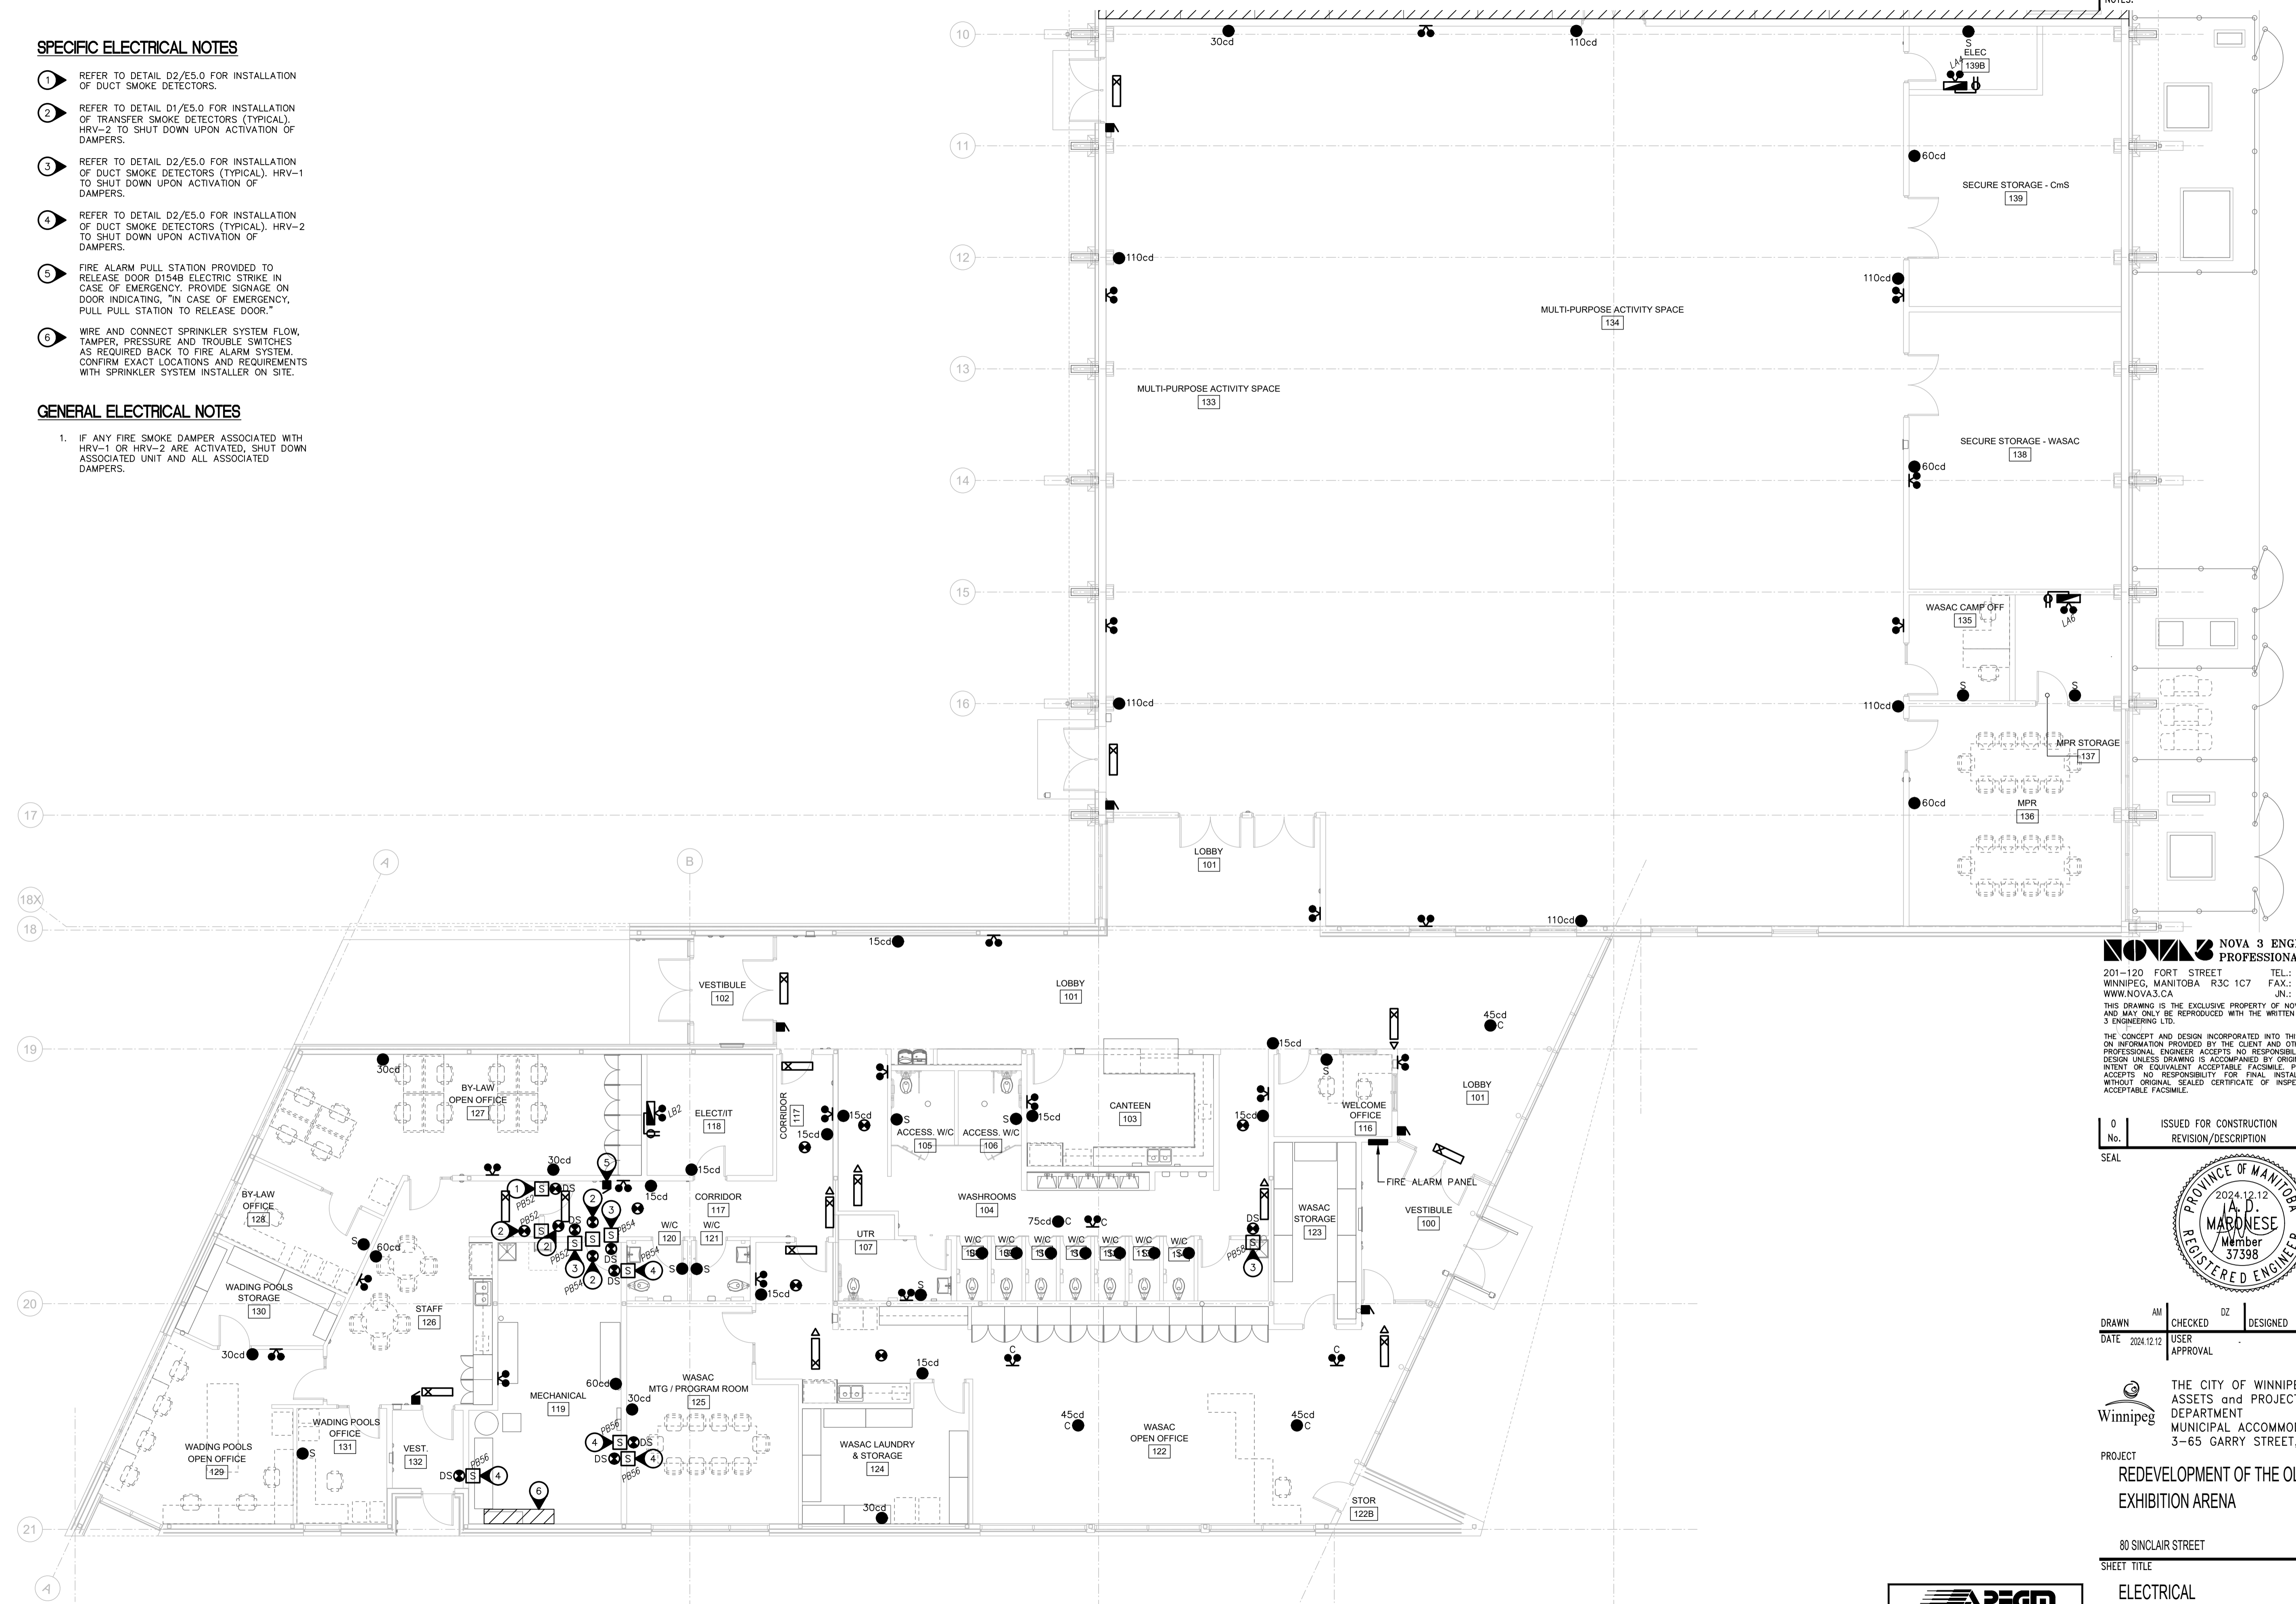

NOTES:

NOVA 3 ENGINEERING LTD. PROFESSIONAL ENGINEERS
 201-120 FORT STREET TEL: (204) 943-6142
 WINNIPEG, MANITOBA R3C 1C7 FAX: (204) 942-1276
 WWW.NOVA3.CA JUN: 41-193
 THIS DRAWING IS THE EXCLUSIVE PROPERTY OF NOVA 3 ENGINEERING LTD. AND MAY ONLY BE REPRODUCED WITH THE WRITTEN PERMISSION OF NOVA 3 ENGINEERING LTD.

THE CONCEPT AND DESIGN INCORPORATED INTO THIS DRAWING ARE BASED ON INFORMATION PROVIDED BY THE CLIENT AND OTHER RELATED SOURCES. PROFESSIONAL ENGINEER ACCEPTS NO RESPONSIBILITY FOR DRAWING AND DESIGN UNLESS DRAWING IS ACCOMPANIED BY ORIGINAL SEALED LETTER OF INTENT OR EQUIVALENT ACCEPTABLE FACSIMILE. PROFESSIONAL ENGINEER ACCEPTS NO RESPONSIBILITY FOR FINAL INSTALLATION CONFORMANCE WITHOUT ORIGINAL SEALED CERTIFICATE OF INSPECTION OR EQUIVALENT ACCEPTABLE FACSIMILE.

No.	ISSUED FOR CONSTRUCTION	AM	2024.12.12
0	REVISION/DESCRIPTION	BY	DATE



DRAWN	AM	CHECKED	DZ	DESIGNED	AM	APPROVED	AM
DATE	2024.12.12	USER	APPROVAL				

THE CITY OF WINNIPEG
 ASSETS and PROJECT MANAGEMENT
 DEPARTMENT
 MUNICIPAL ACCOMMODATIONS DIVISION
 3-65 GARRY STREET, R3C 4K4

PROJECT
**REDEVELOPMENT OF THE OLD
 EXHIBITION ARENA**

80 SINCLAIR STREET
 SHEET TITLE

**ELECTRICAL
 SYSTEMS LAYOUT - SOUTH**

SCALE	PROJECT No.	SHEET No.
AS SHOWN	2020-136	E5.1

1 SYSTEMS LAYOUT - SOUTH AREA
 E5.1 SCALE: 1/100

