

FILE NAME:




DATE:

SHEET TITLE:






PROJECT No.:

ADDRESS:

NOTE: COORDINATE FINAL AIR COMPRESSOR REQUIREMENTS WITH ELECTRICAL CONTRACTOR

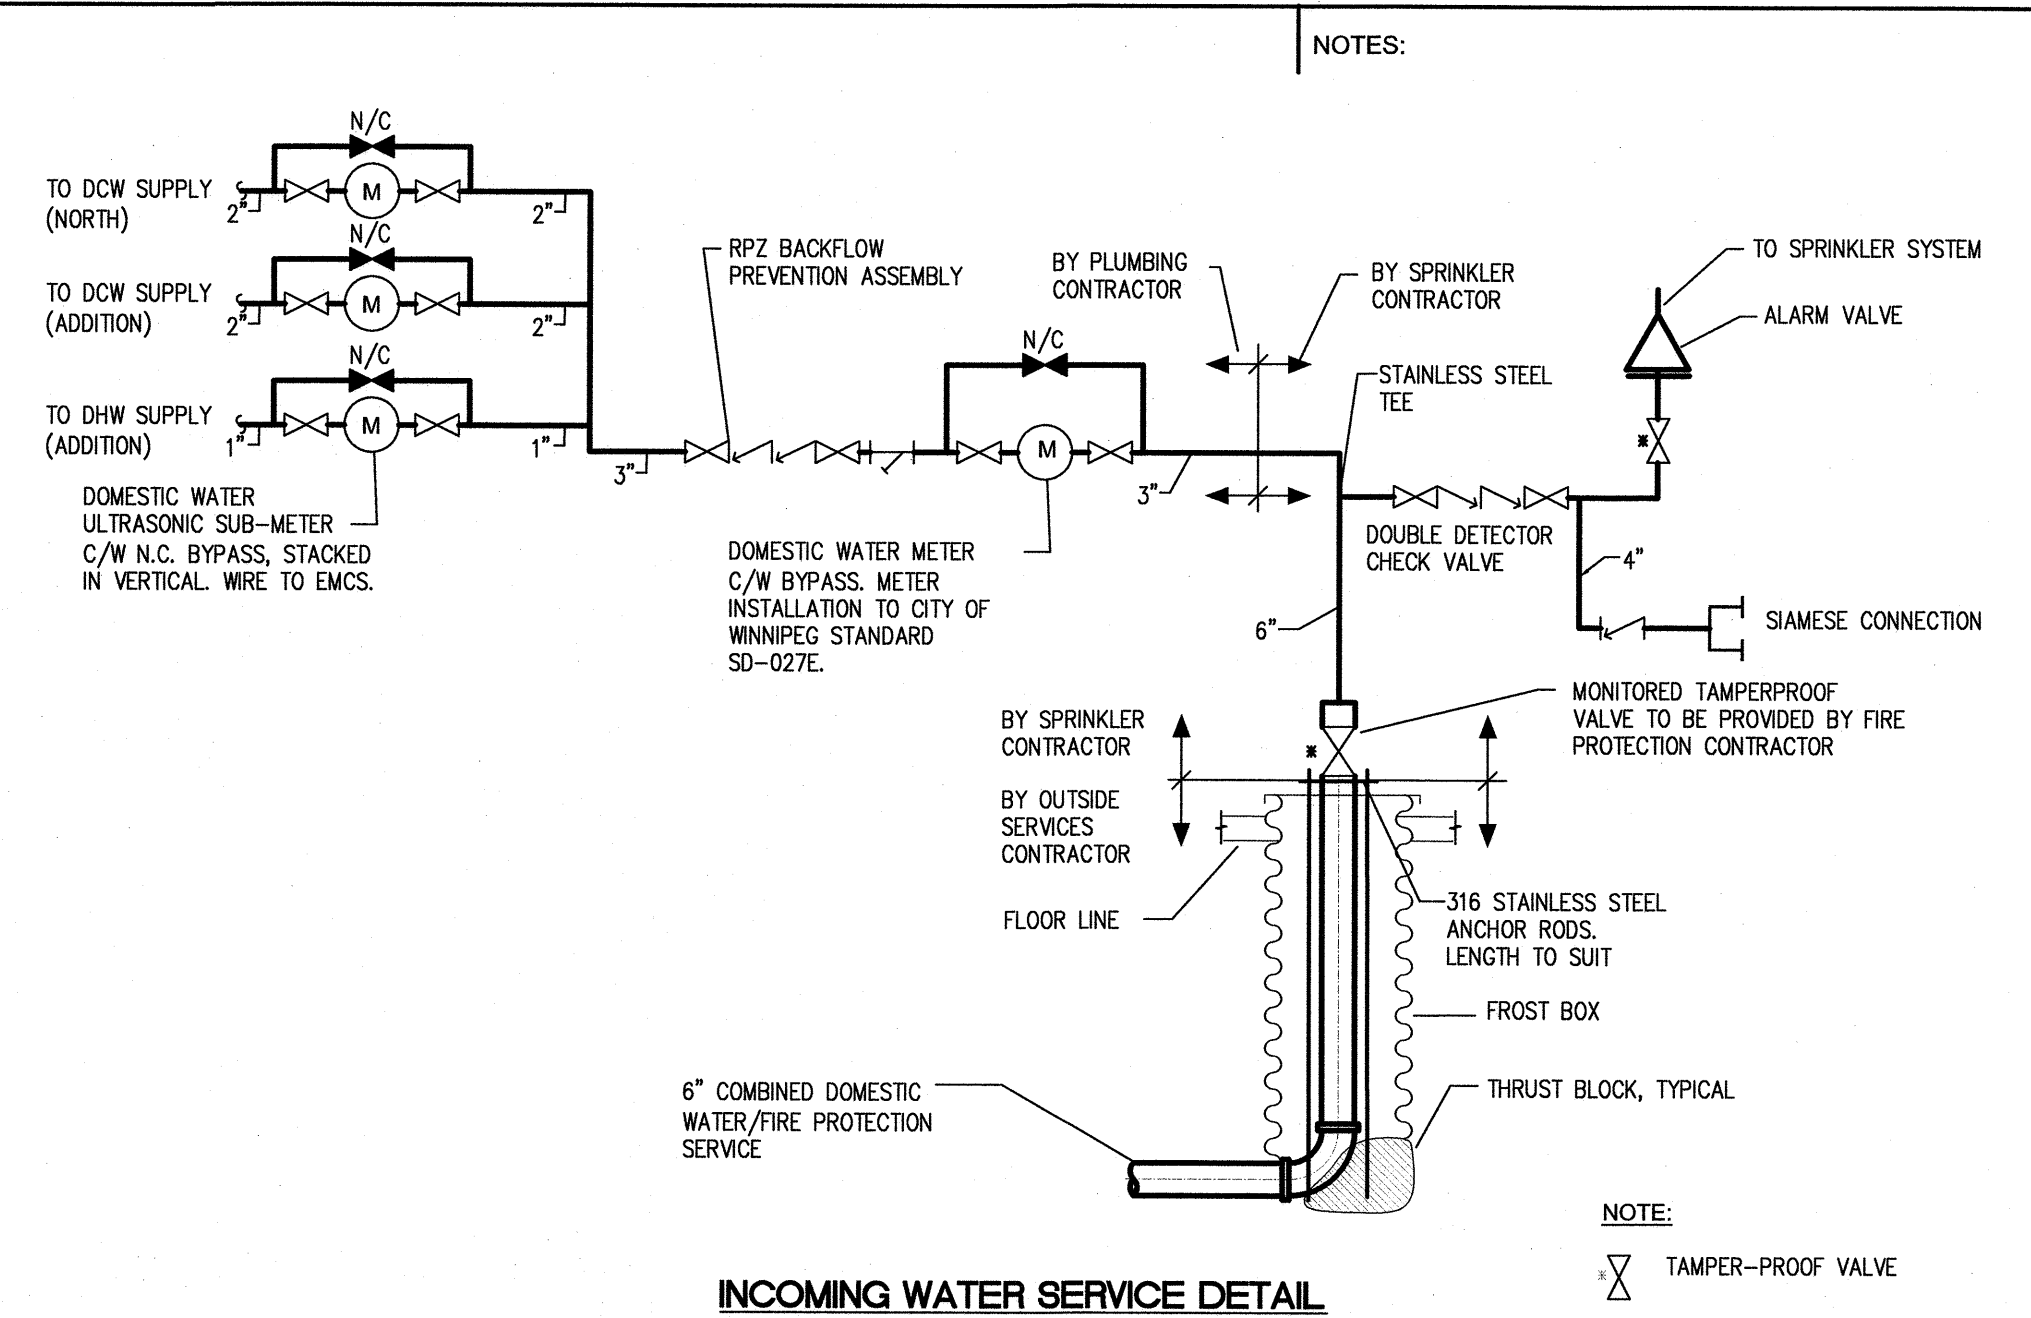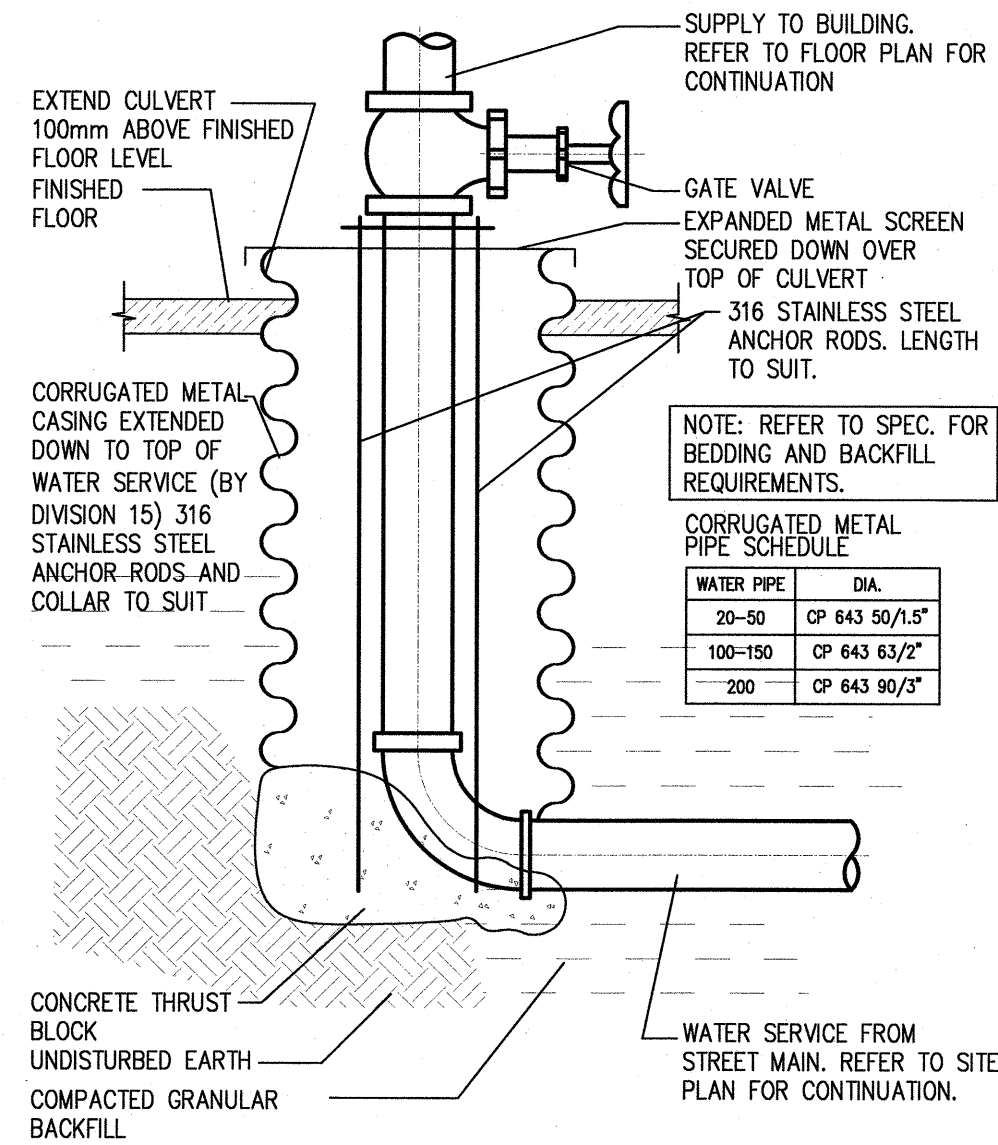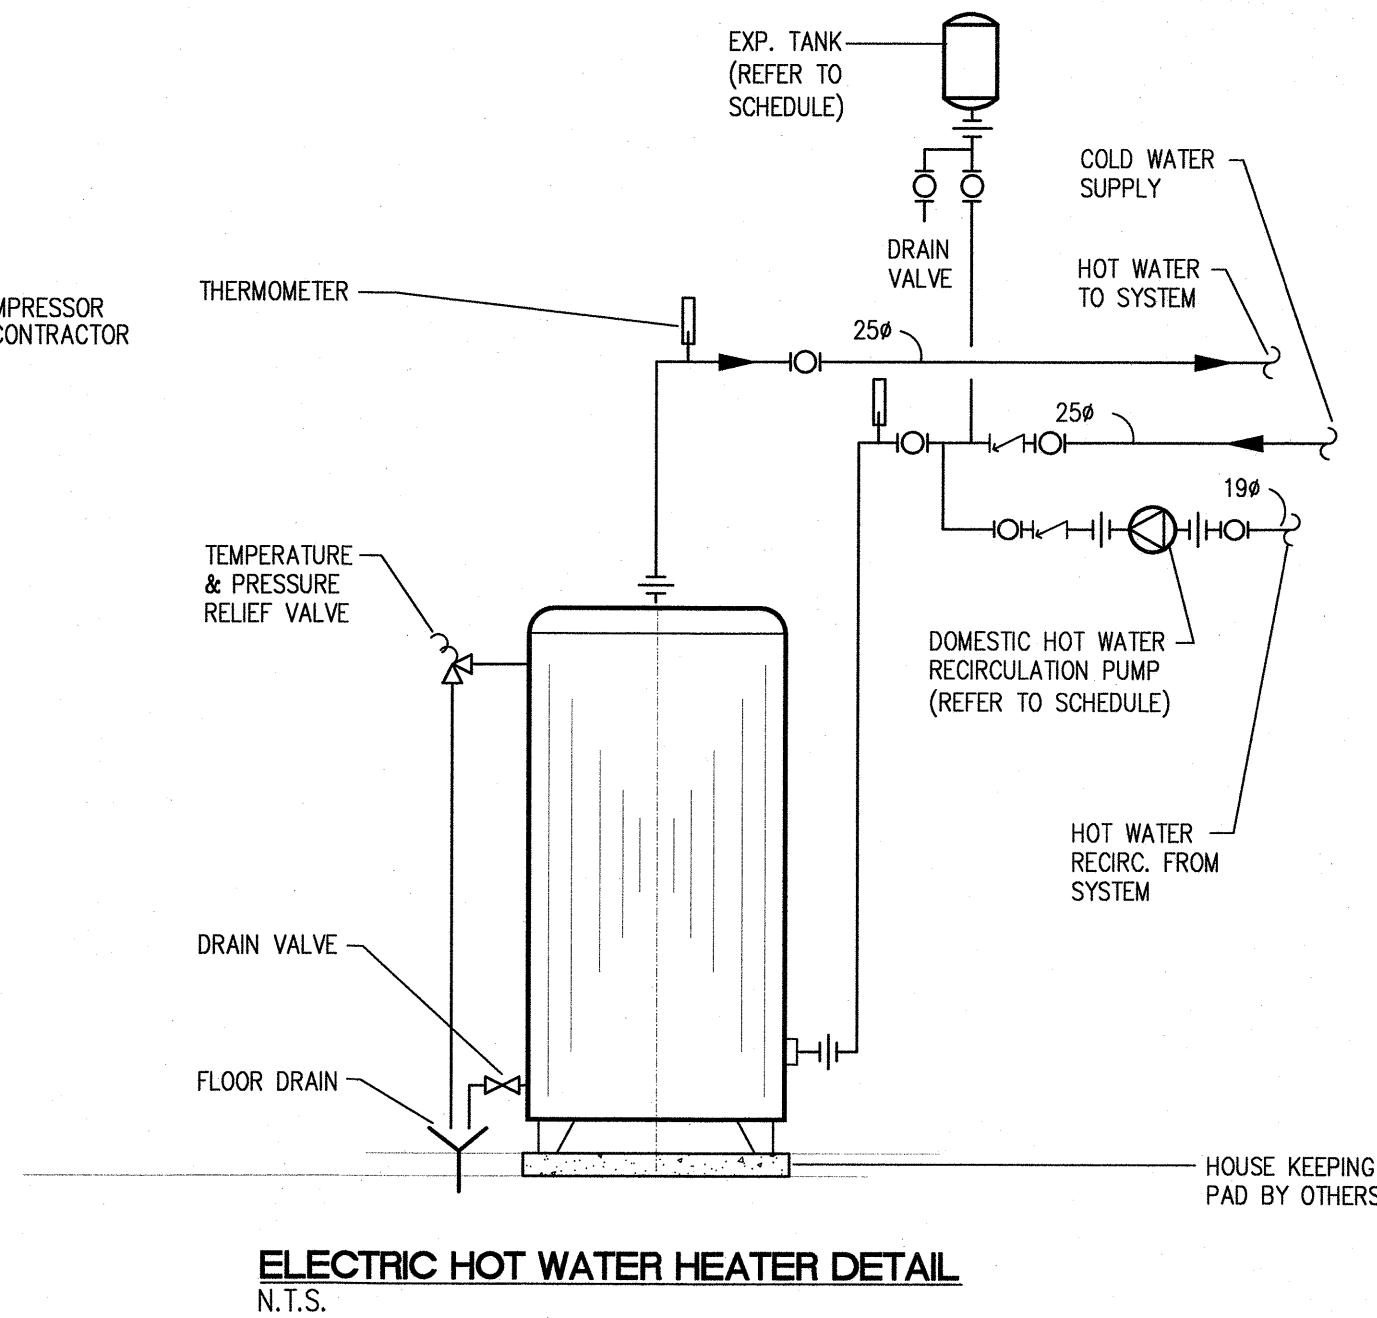

THIS DRAWING TO BE USED AS A GUIDE ONLY. SPRINKLER SYSTEM TO BE INSTALLED AS PER N.F.P.A. #13 AND IN STRICT ACCORDANCE WITH ALL LOCAL CODES AND REGULATIONS. COORDINATE ALL REQUIREMENTS WITH ALL AUTHORITIES HAVING JURISDICTION.

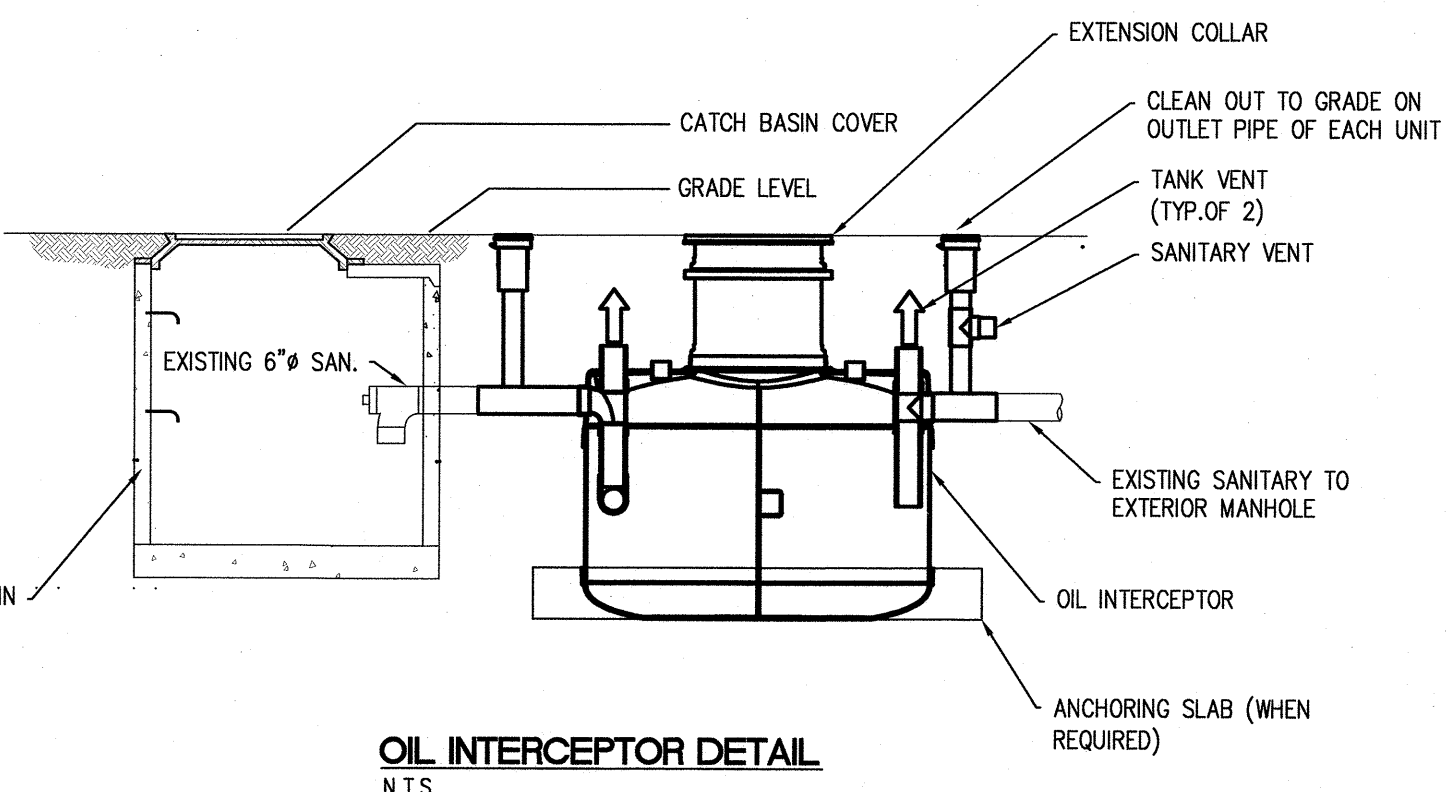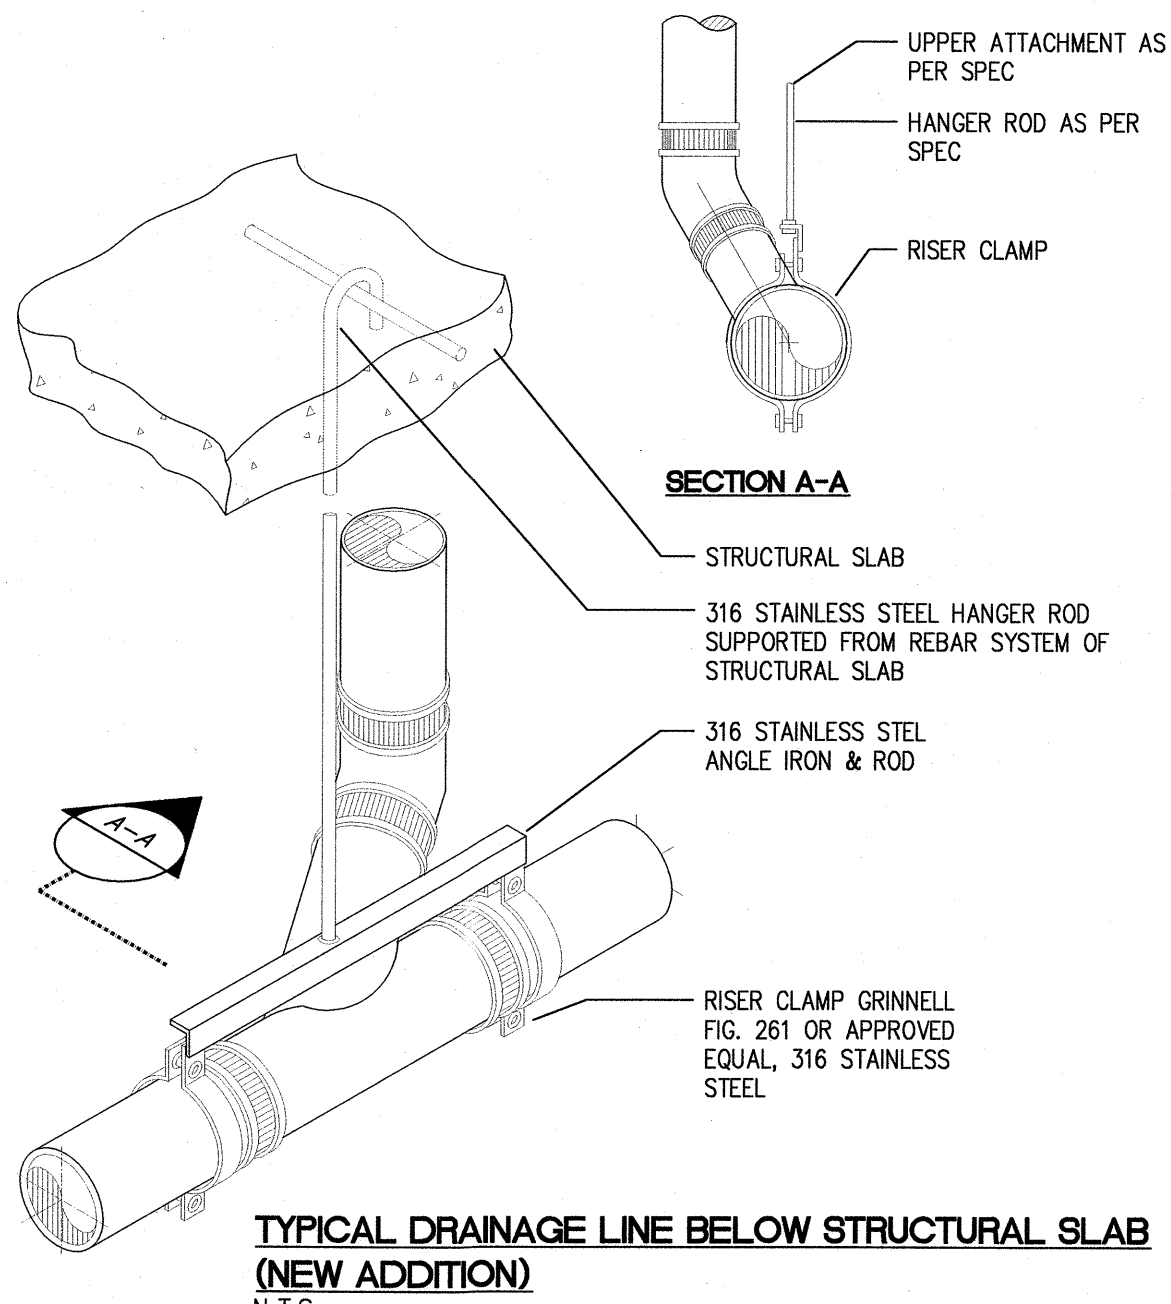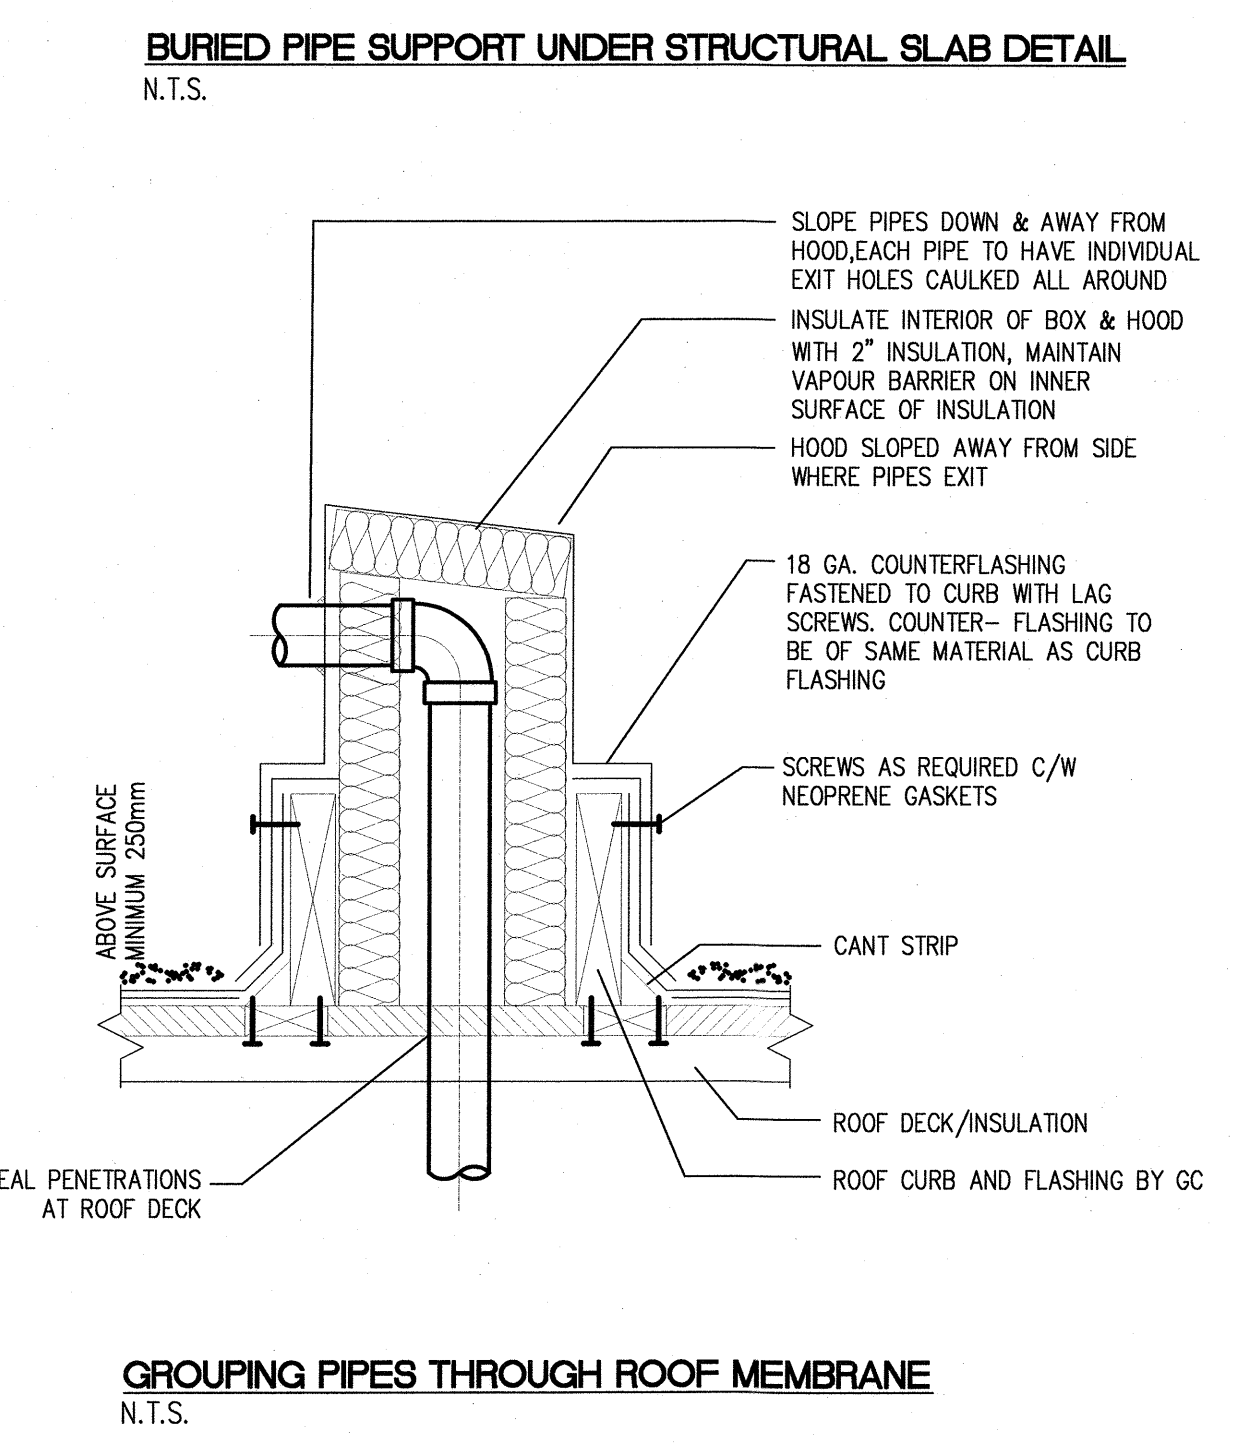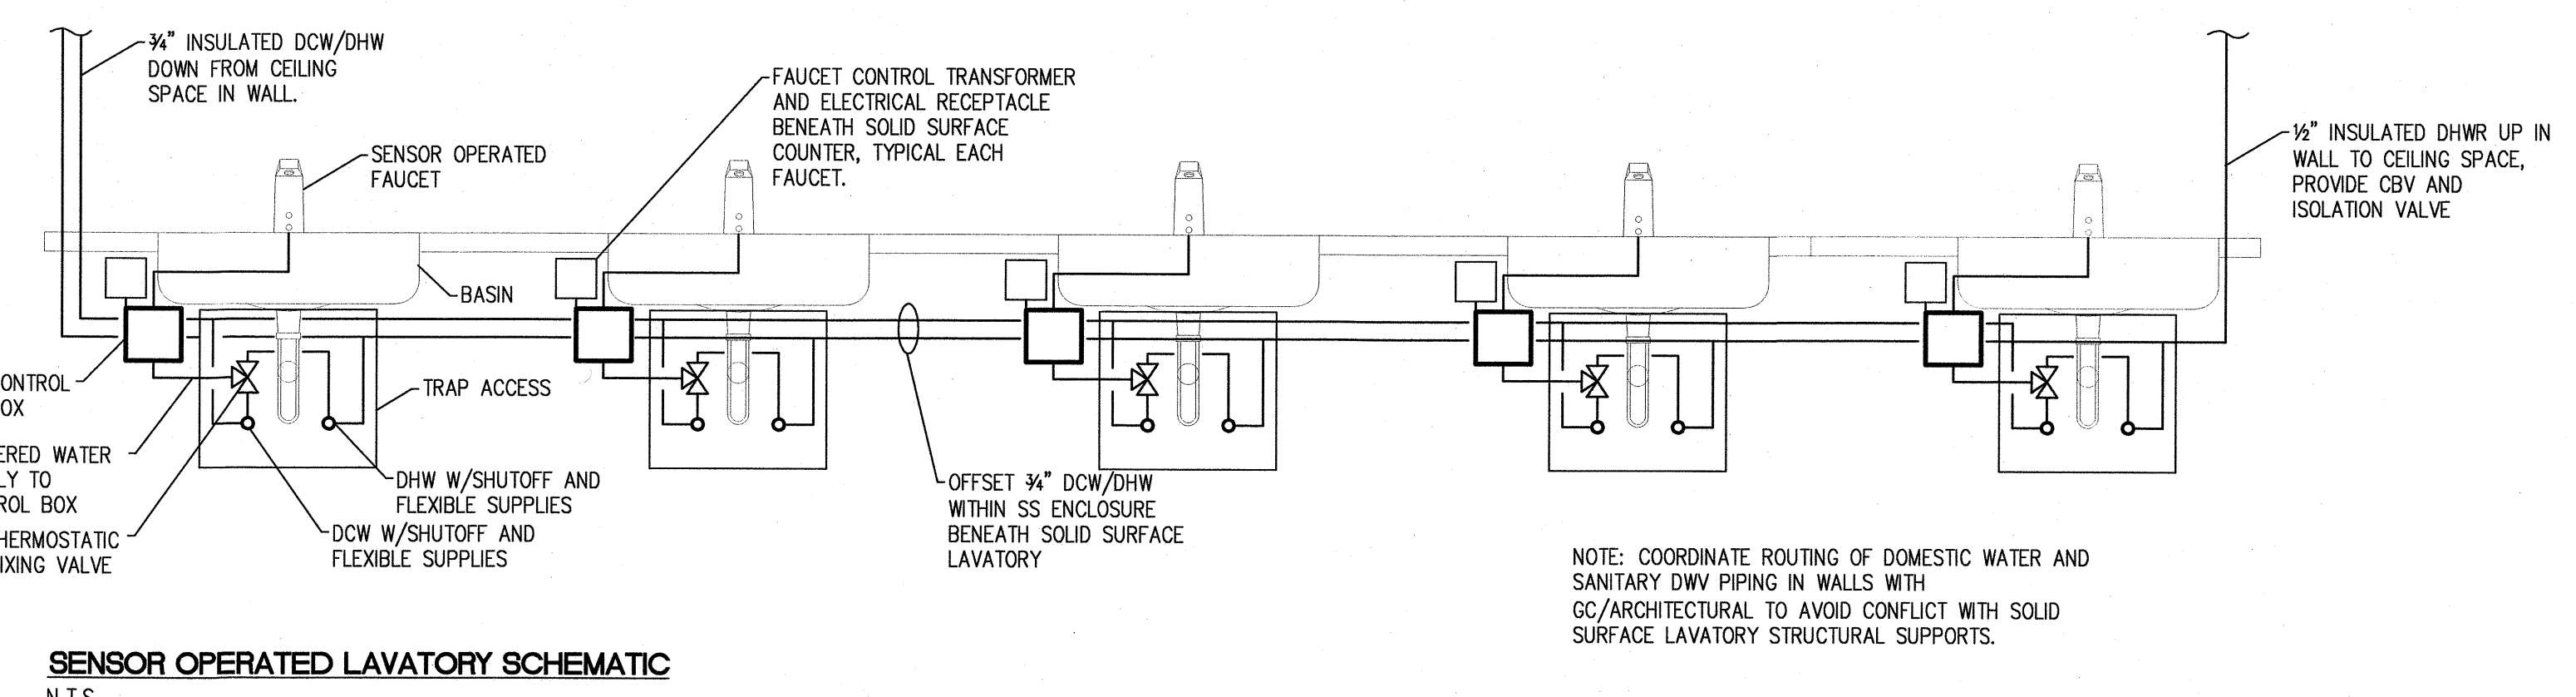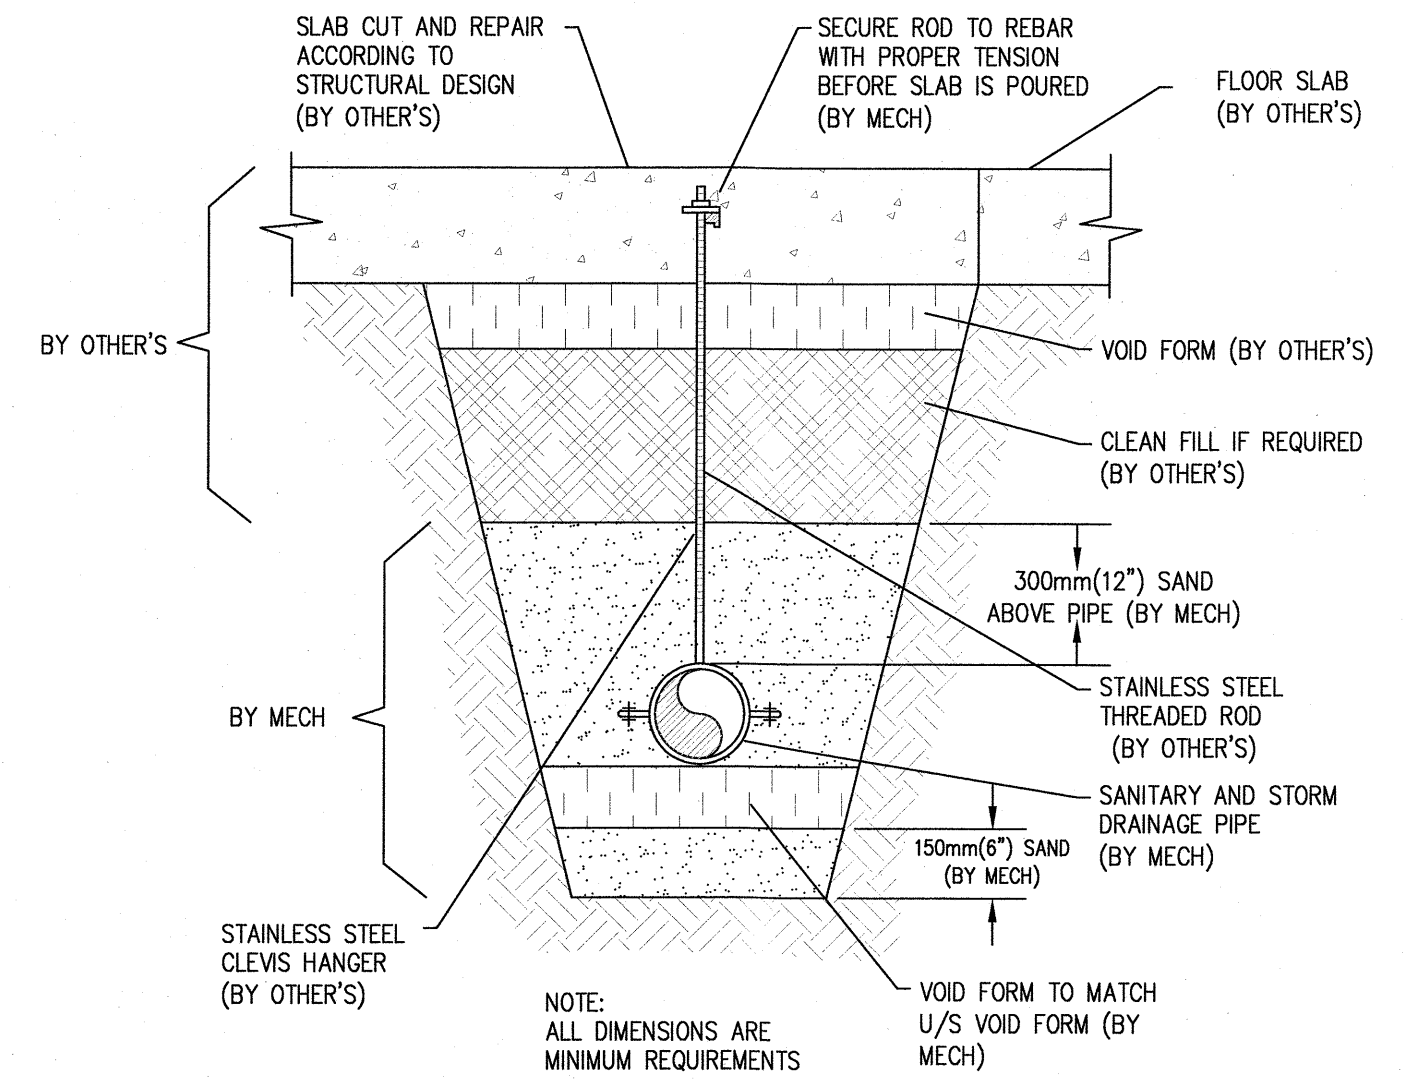

NOVA 3 NOVA 3 ENGINEERING LTD. PROFESSIONAL ENGINEERS
 201-120 FORT STREET WINNIPEG, MANITOBA R3C 1C7 TEL: (204) 943-6142 FAX: (204) 942-1276 WWW.NOVA3.CA JN: 41-193
 THIS DRAWING IS THE EXCLUSIVE PROPERTY OF NOVA 3 ENGINEERING LTD. AND MAY ONLY BE REPRODUCED WITH THE WRITTEN PERMISSION OF NOVA 3 ENGINEERING LTD.
 THE CONCEPT AND DESIGN INCORPORATED INTO THIS DRAWING ARE BASED ON INFORMATION PROVIDED BY THE CLIENT AND OTHER RELATED SOURCES. PROFESSIONAL ENGINEER ACCEPTS NO RESPONSIBILITY FOR DRAWING AND DESIGN UNLESS DRAWING IS ACCOMPANIED BY ORIGINAL SEALED LETTER OF INTENT OR EQUIVALENT ACCEPTABLE FACSIMILE. PROFESSIONAL ENGINEER ACCEPTS NO RESPONSIBILITY FOR FINAL INSTALLATION. CONFORMANCE WITHOUT ORIGINAL SEALED CERTIFICATE OF INSPECTION OR EQUIVALENT ACCEPTABLE FACSIMILE.

APEGM
 Certificate of Authorization
 Nova 3 Engineering Ltd.
 No. 962

0	ISSUED FOR CONSTRUCTION	JSD	2024.12.11
No.	REVISION/DESCRIPTION	BY	DATE



CT/JSD	JSD	JSD	JSD
DRAWN	CHECKED	DESIGNED	APPROVED
DAJ/ED4.20	TC	TC	TC

THE CITY OF WINNIPEG ASSETS and PROJECT MANAGEMENT DEPARTMENT MUNICIPAL ACCOMMODATIONS DIVISION
 PROJECT 3-65 GARRY STREET, R3C 4K4
REDEVELOPMENT OF THE OLD EXHIBITION ARENA ISSUED FOR CONSTRUCTION
 80 SINCLAIR STREET
 SHEET TITLE

MECHANICAL DETAILS

SCALE	PROJECT No.	SHEET No.
AS SHOWN	2020-136	M5.2

DRAWING SHEET SIZE: A1 (841mm x 594mm) PLOT 1:1