

LEGEND	
	WATER VALVE
	MANHOLE
	STREET/PROPERTY LIGHT
	CATCH BASIN INCHES BELOW SURFACE GRADE (BSG)
	HYDRO POLE
	HYDRO POLE W/LIGHT
	FIRE HYDRANT
	GAS METER
	GAS VALVE W/ SHUT-OFF
	WATER METER W/VALVE
	CLEAN-OUT (SEWER)
	ELECTRICITY METER
	ELECTRICAL PANEL
	LIGHTING PANEL
	COMBINED SEWER
	LAND DRAINAGE SEWER
	WASTE WATER SEWER
	SEWER MAIN-STORM RELIEF
	WATERMAIN
	NATURAL GAS LINE
	HYDRO CABLES UNDERGROUND (U/G)
	COMMUNICATION CABLES UNDERGROUND (U/G)
	SECURITY CABLES UNDERGROUND (U/G)
	IRRIGATION LINES UNDERGROUND (U/G)

THE CITY OF WINNIPEG
 PLANNING, PROPERTY AND
 DEVELOPMENT DEPARTMENT
 MUNICIPAL ACCOMMODATIONS DIVISION
 3-65 GARRY STREET, R3C 4K4

SHEET TITLE
SITE PLAN

PROJECT
CC-067,-068
RICHMOND KINGS COMMUNITY CENTRE
SITE SERVICES
 666 SILVERSTONE AVENUE

DRAWN BY:
 MPP/MCR/DTA

DESIGNED BY:


CHECKED BY:

APPROVED BY:

DATE:
 2013.10.04
 eFILE:
 0666SV.dwg

SCALE:
 N.T.S.
 PROJECT No:
 2013-093

SHEET No:
C1


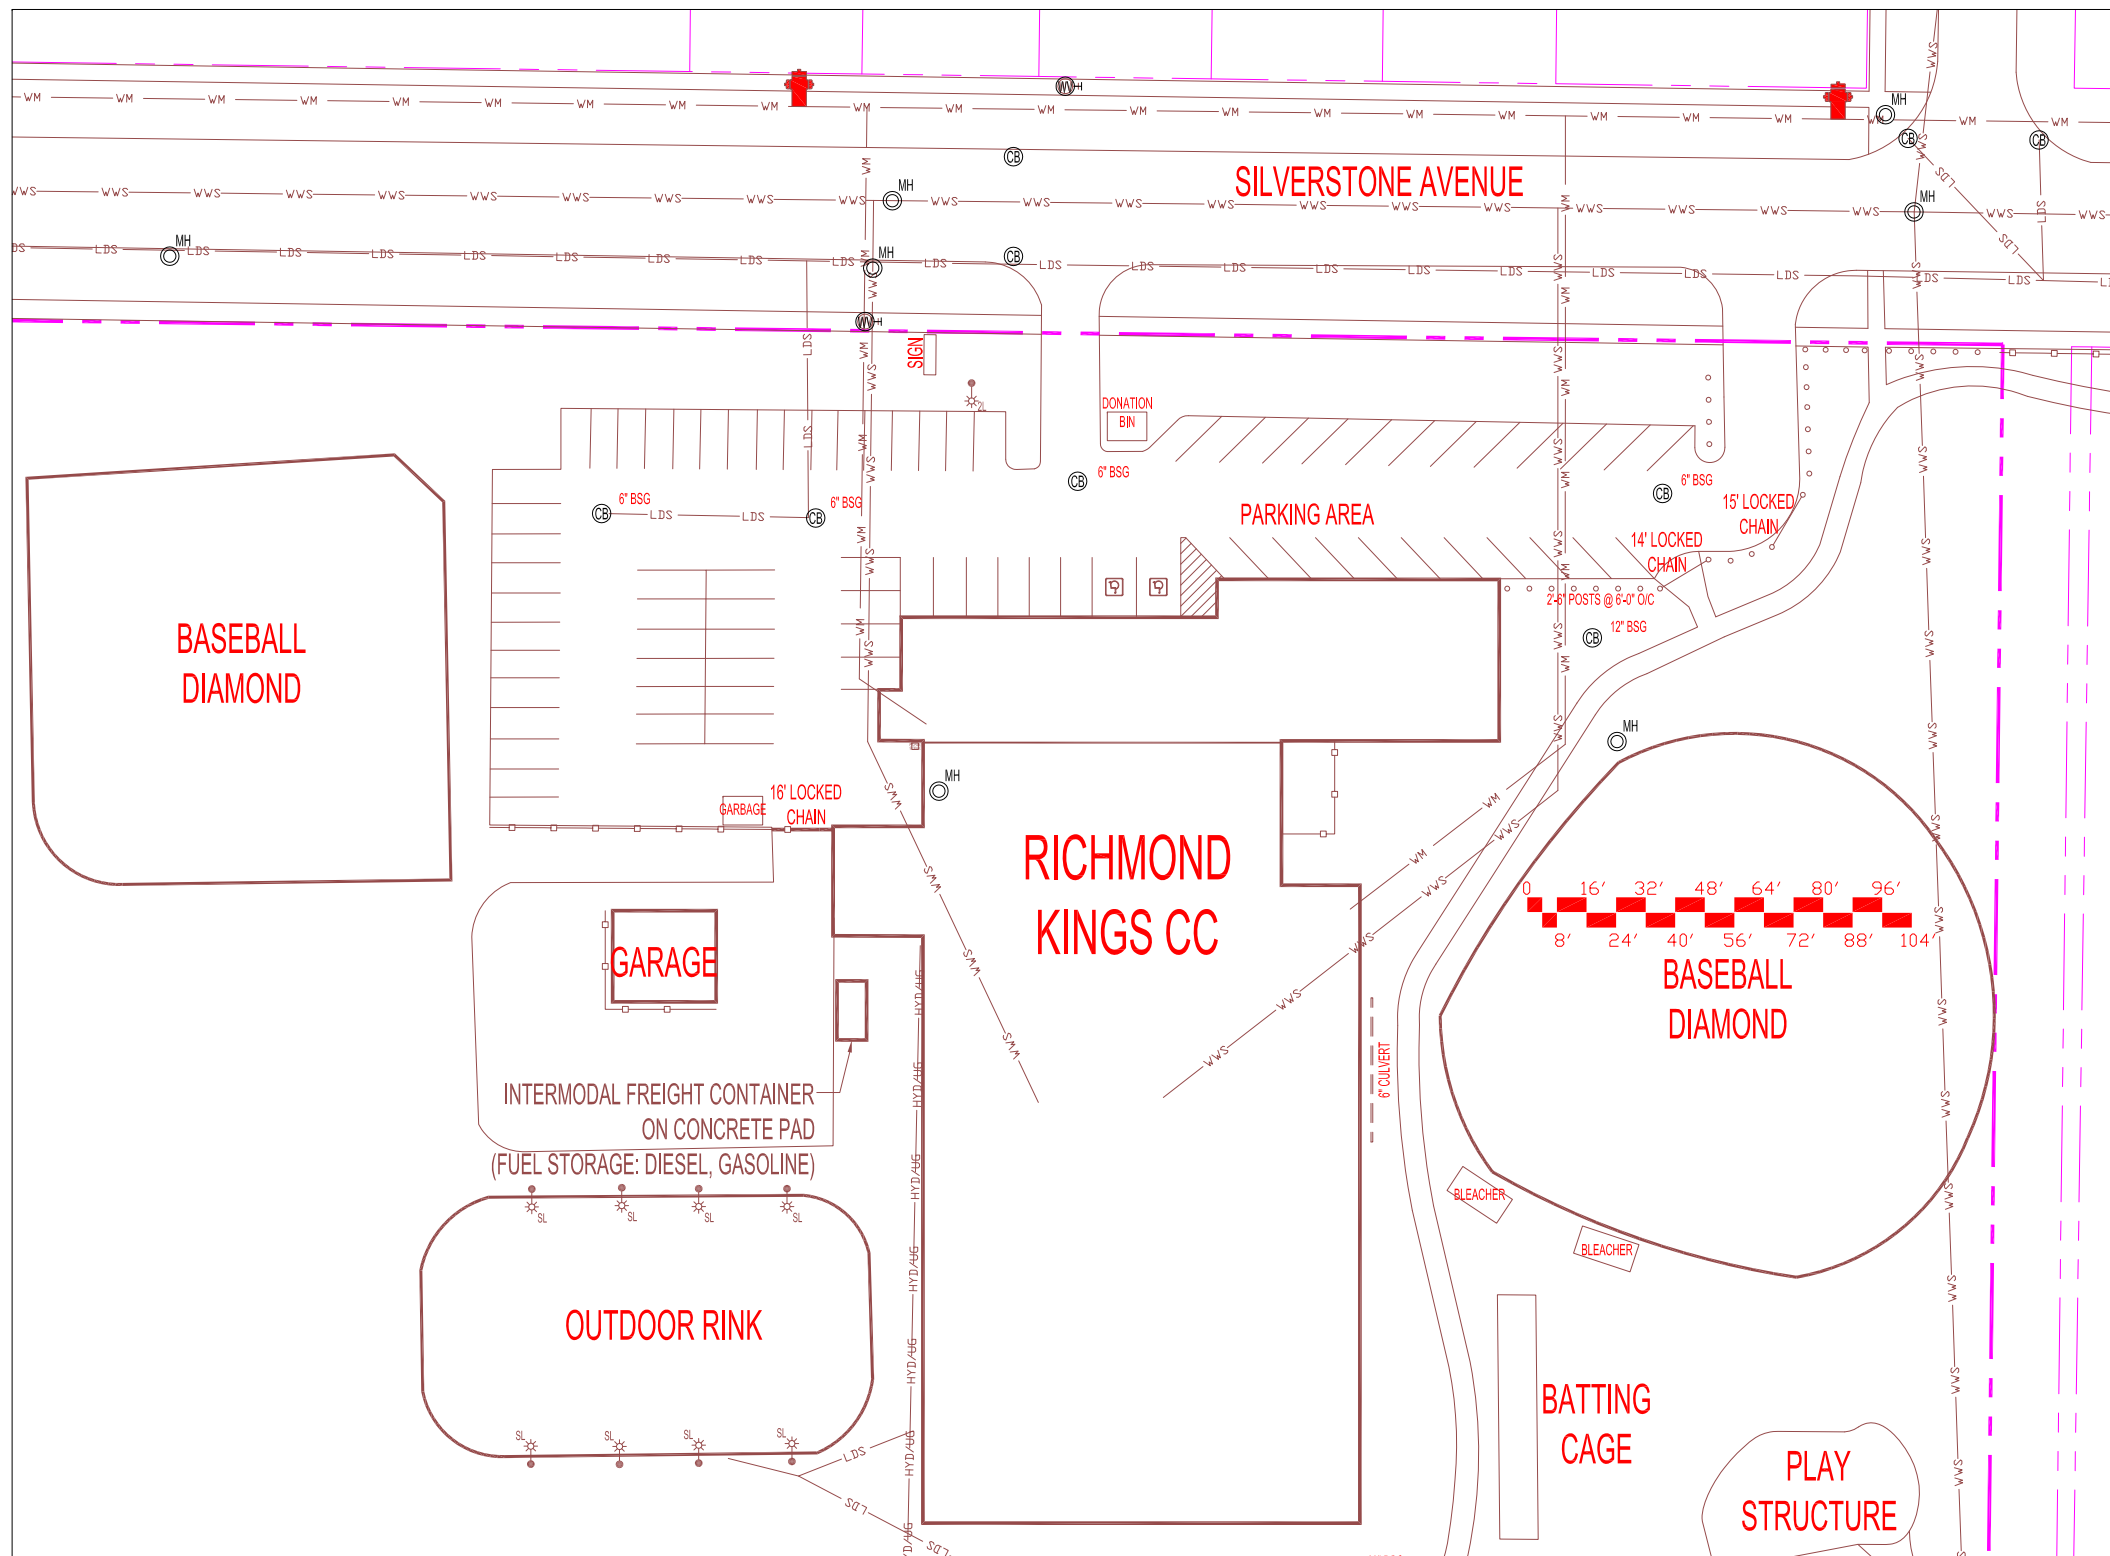



LEGEND	
	WATER VALVE
	MANHOLE
	STREET/PROPERTY LIGHT
	CATCH BASIN INCHES BELOW SURFACE GRADE (BSG)
	HYDRO POLE
	HYDRO POLE W/LIGHT
	FIRE HYDRANT
	GAS METER
	GAS VALVE W/ SHUT-OFF
	WATER METER W/VALVE
	CLEAN-OUT (SEWER)
	ELECTRICITY METER
	ELECTRICAL PANEL
	LIGHTING PANEL
	COMBINED SEWER
	LAND DRAINAGE SEWER
	WASTE WATER SEWER
	SEWER MAIN-STORM RELIEF
	WATERMAIN
	NATURAL GAS LINE
	HYDRO CABLES UNDERGROUND (U/G)
	COMMUNICATION CABLES UNDERGROUND (U/G)
	SECURITY CABLES UNDERGROUND (U/G)
	IRRIGATION LINES UNDERGROUND (U/G)

THE CITY OF WINNIPEG PLANNING, PROPERTY AND DEVELOPMENT DEPARTMENT MUNICIPAL ACCOMMODATIONS DIVISION 3-65 GARRY STREET, R3C 4K4			SHEET TITLE ENLARGED SITE PLAN		PROJECT CC-067,-068 RICHMOND KINGS COMMUNITY CENTRE SITE SERVICES 666 SILVERSTONE AVENUE	
DRAWN BY: MPP/MCR/DTA	DESIGNED BY:	CHECKED BY:	APPROVED BY:	DATE: 2013.10.04 eFILE: 0666SV.dwg	SCALE: N.T.S.	SHEET No: C2
					PROJECT No: 2013-093	



LEGEND	
	GAS METER
	GAS VALVE W/ SHUT-OFF
	WATER METER W/VALVE
	CLEAN-OUT (SEWER)
	ELECTRICITY METER
	ELECTRICAL PANEL
	LIGHTING PANEL

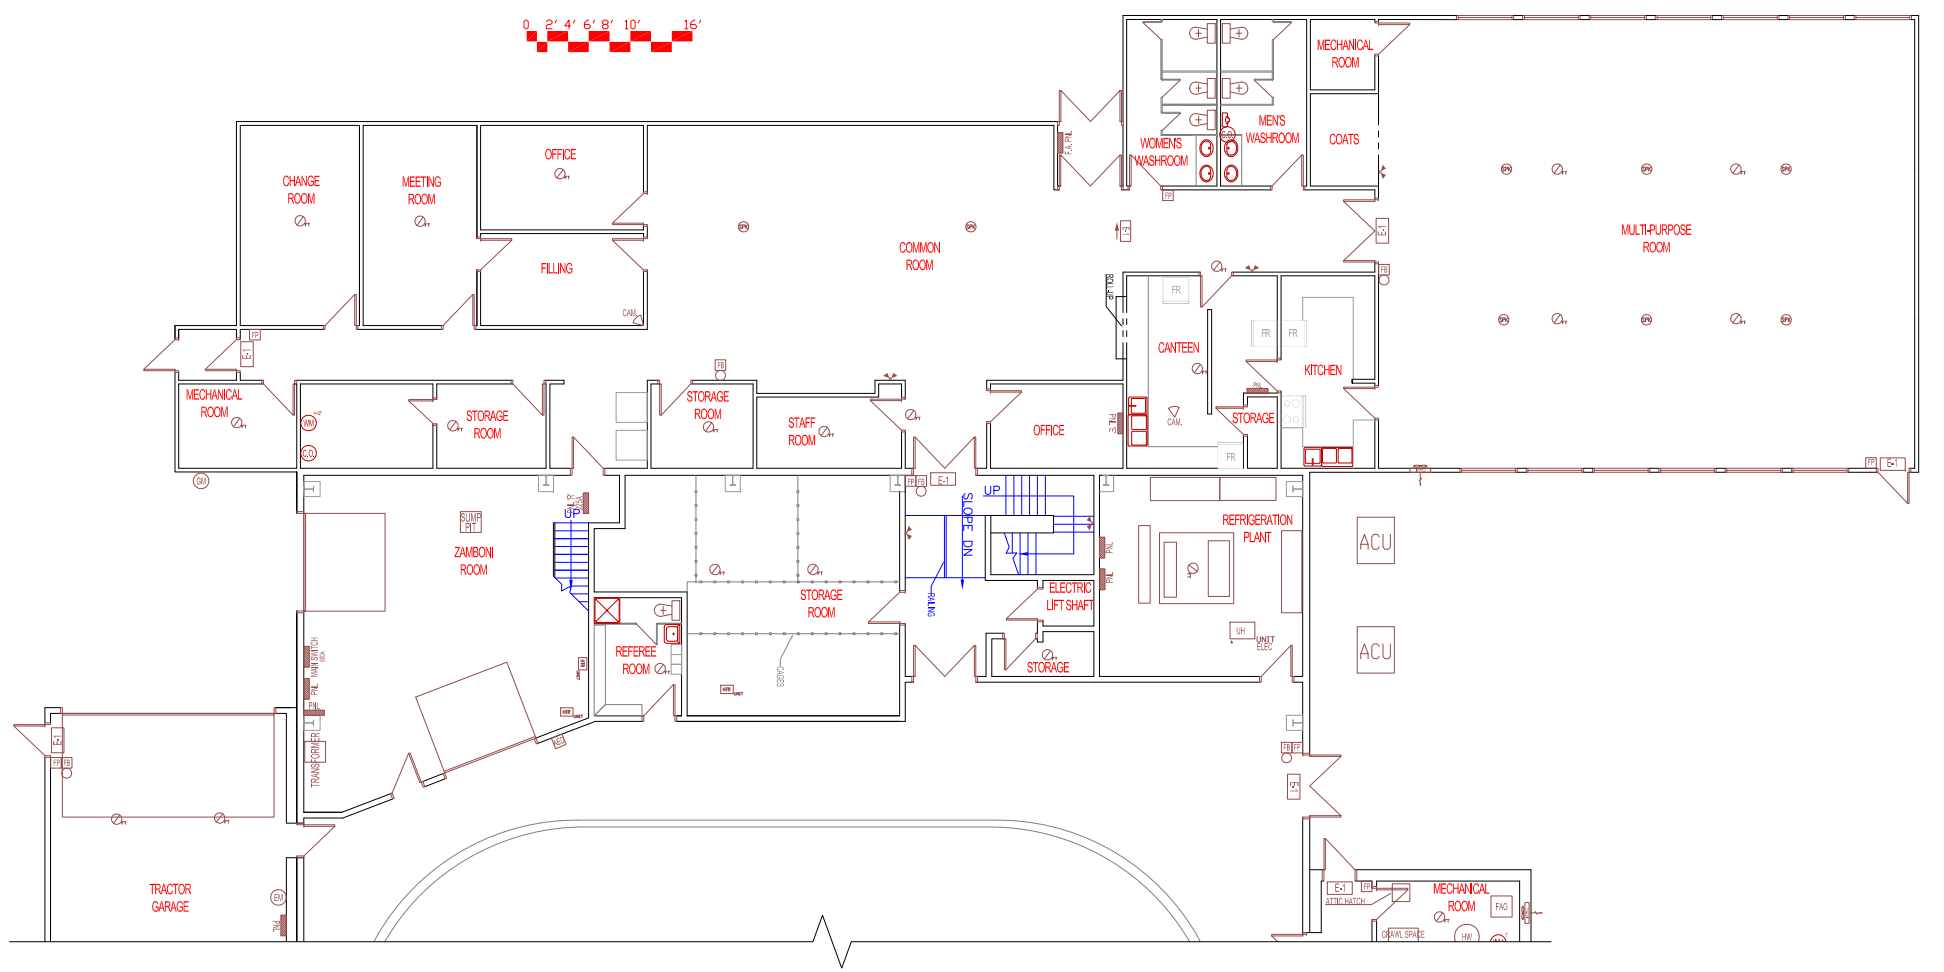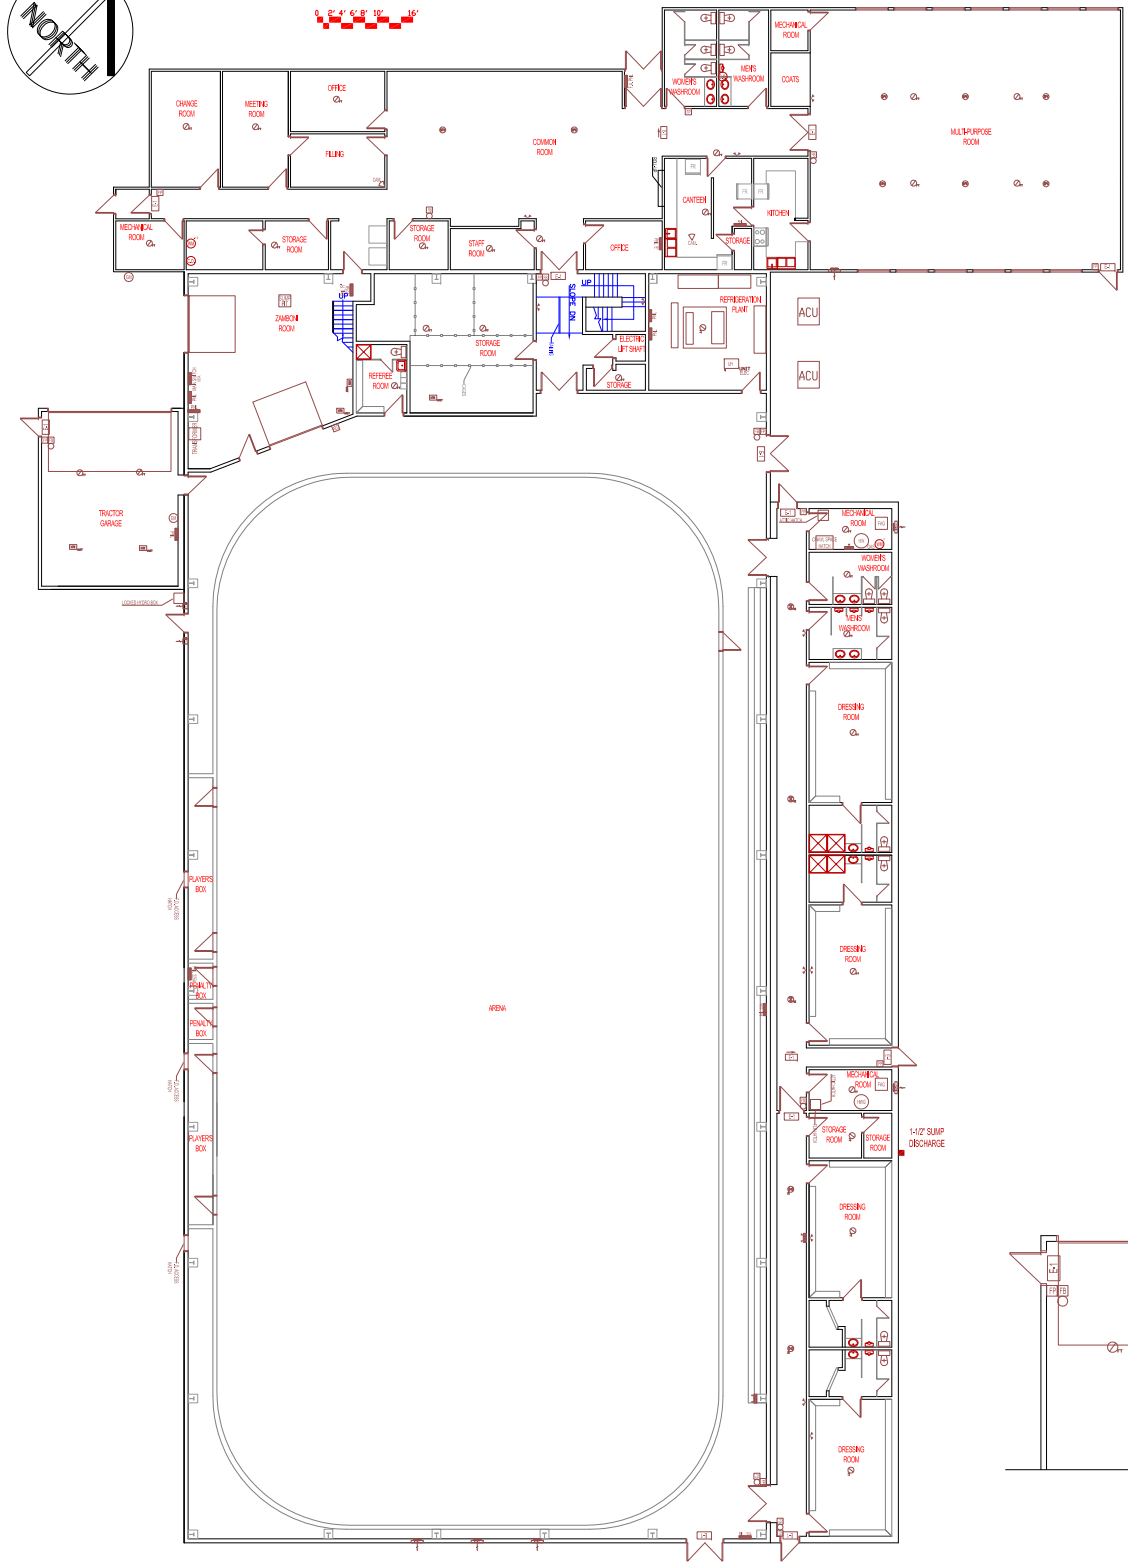


 THE CITY OF WINNIPEG
 PLANNING, PROPERTY AND
 DEVELOPMENT DEPARTMENT
 MUNICIPAL ACCOMMODATIONS DIVISION
 3-65 GARRY STREET, R3C 4K4

SHEET TITLE
MAIN FLOOR PLAN

PROJECT
RICHMOND KINGS COMMUNITY CENTRE
SITE SERVICES
 666 SILVERSTONE AVENUE
 CC-067-068

DRAWN BY:
 MPP/MCR/DTA

DESIGNED BY:

CHECKED BY:

APPROVED BY:

DATE:
 2013.10.04
 eFILE:
 0666SV.dwg

SCALE:
 N.T.S.
 PROJECT No:
 2013-093

SHEET No:
A1



LEGEND	
	GAS METER
	GAS VALVE W/ SHUT-OFF
	WATER METER W/VALVE
	CLEAN-OUT (SEWER)
	ELECTRICITY METER
	ELECTRICAL PANEL
	LIGHTING PANEL





MEZZANINE FLOOR PLAN

SCALE: 1/8"=1'-0"

THE CITY OF WINNIPEG PLANNING, PROPERTY AND DEVELOPMENT DEPARTMENT MUNICIPAL ACCOMMODATIONS DIVISION 3-65 GARRY STREET, R3C 4K4			SHEET TITLE MEZZANINE FLOOR PLAN		PROJECT RICHMOND KINGS COMMUNITY CENTRE SITE SERVICES 666 SILVERSTONE AVENUE	
DRAWN BY: MPP/MCR/DTA	DESIGNED BY:	CHECKED BY:	APPROVED BY:	DATE: 2013.10.04 eFILE: 0666SV.dwg	SCALE: N.T.S.	SHEET No: A2
				PROJECT No: 2013-093		



LEGEND	
	GAS METER
	GAS VALVE W/ SHUT-OFF
	WATER METER W/VALVE
	CLEAN-OUT (SEWER)
	ELECTRICITY METER
	ELECTRICAL PANEL
	LIGHTING PANEL

 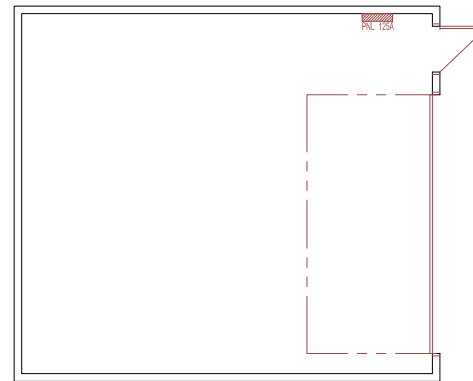

THE CITY OF WINNIPEG PLANNING, PROPERTY AND DEVELOPMENT DEPARTMENT MUNICIPAL ACCOMMODATIONS DIVISION 3-65 GARRY STREET, R3C 4K4			SHEET TITLE GARAGE FLOOR PLAN		PROJECT CC-067 RICHMOND KINGS COMMUNITY CENTRE SITE SERVICES 666 SILVERSTONE AVENUE	
DRAWN BY: MPP/MCR/DTA	DESIGNED BY:	CHECKED BY:	APPROVED BY:	DATE: 2013.10.04 eFILE: 2013-093_0666SV.dwg	SCALE: N.T.S.	SHEET No: A3
				PROJECT No: 2013-093		