


DRAWING NOTES: #

1. CONNECT NEW HEAT DETECTORS TO EXISTING DEVICES AT TOP OF STAIR.
2. CONNECT NEW HEAT DETECTORS TO EXISTING FLOOR AREA DEVICES.




Project: 241082
 Calgary: 403-235-2655
 Kelowna: 250-765-7224
 Winnipeg: 204-925-1150
 towereng.ca


These design documents are prepared solely for the use by the party with whom the design professional has entered into a contract and there are no representations of any kind made by the design professional to any party with whom the design professional has not entered into a contract. Any use of the drawing, disk or electronic data without the expressed written permission of Tower Engineering Group is strictly prohibited. The contractor is responsible to verify all dimensions with conditions on the site and report discrepancies to Tower Engineering for adjustment. All prints to be returned.

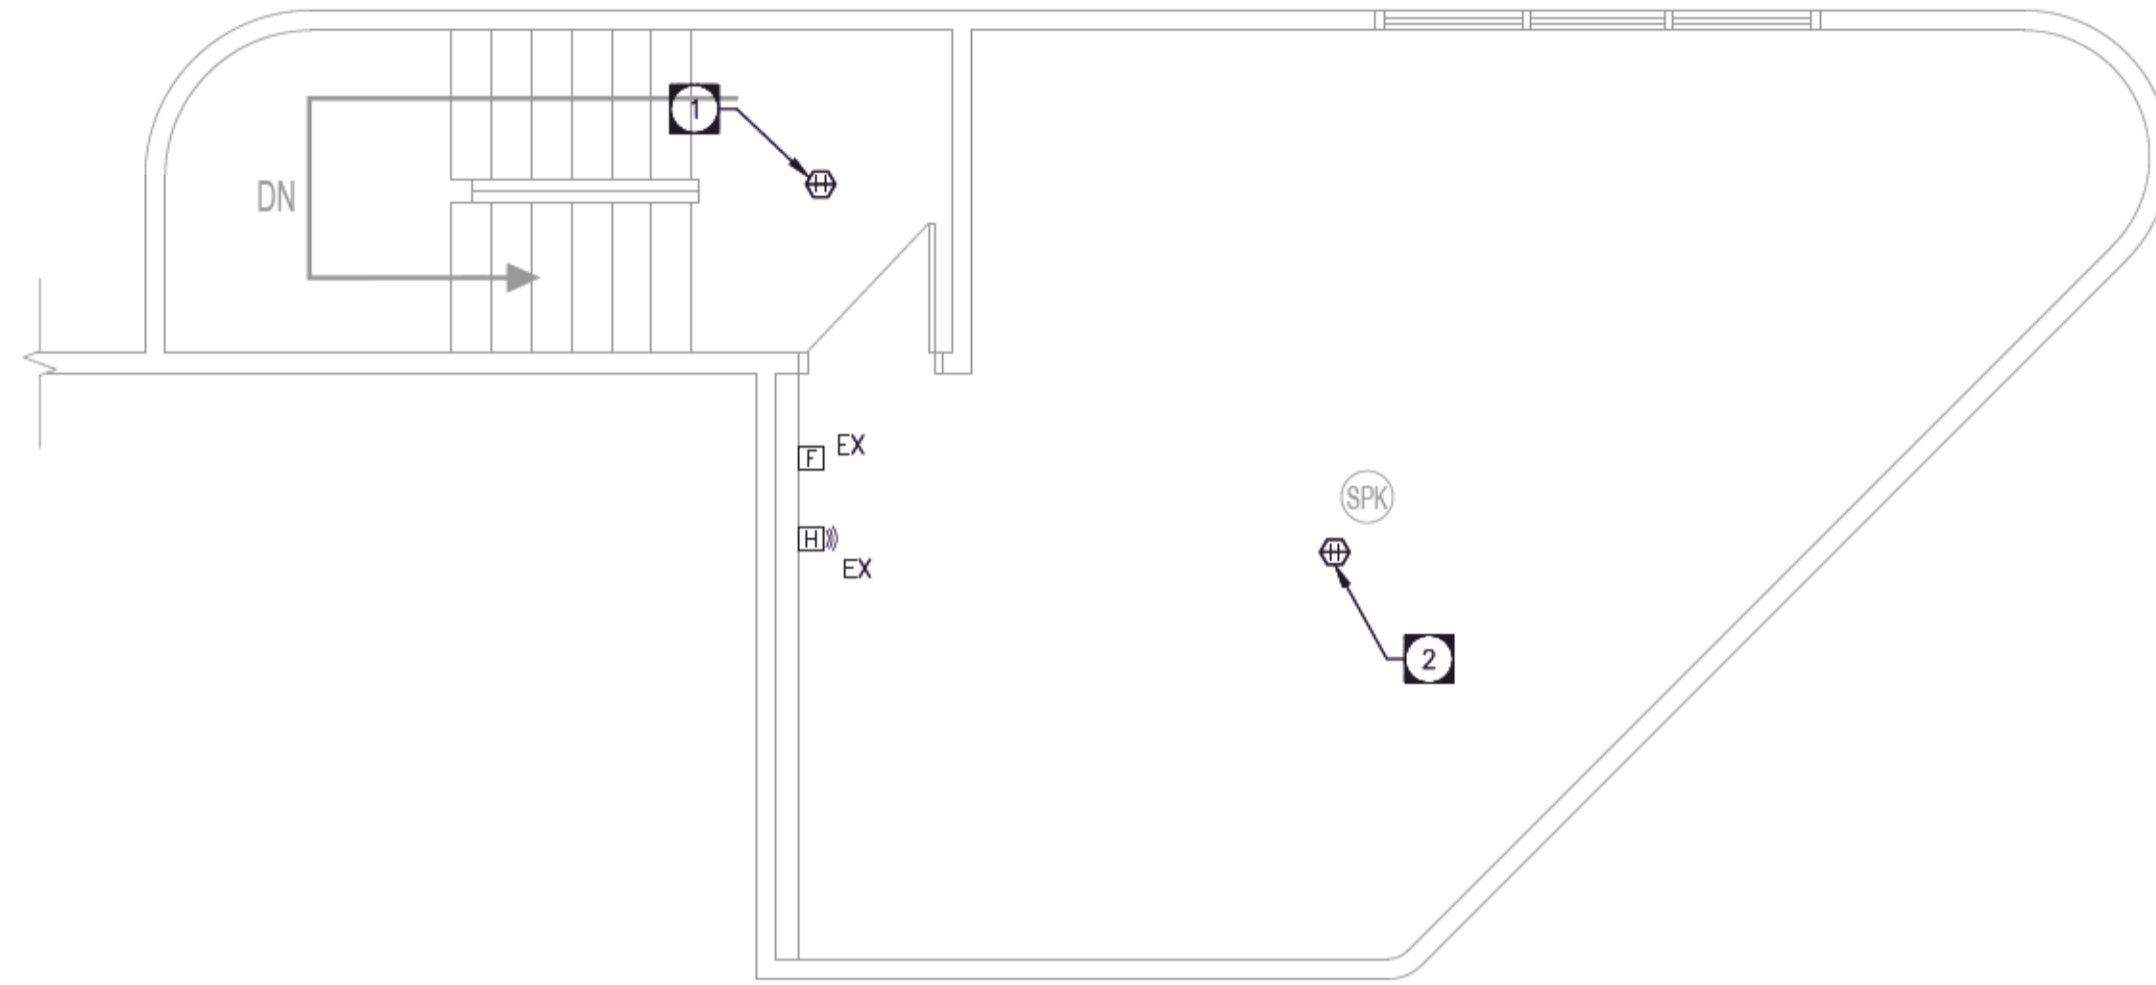


1 SECOND FLOOR-NORTH PLAN
 E1.1 SCALE: 1/4" = 1'-0"

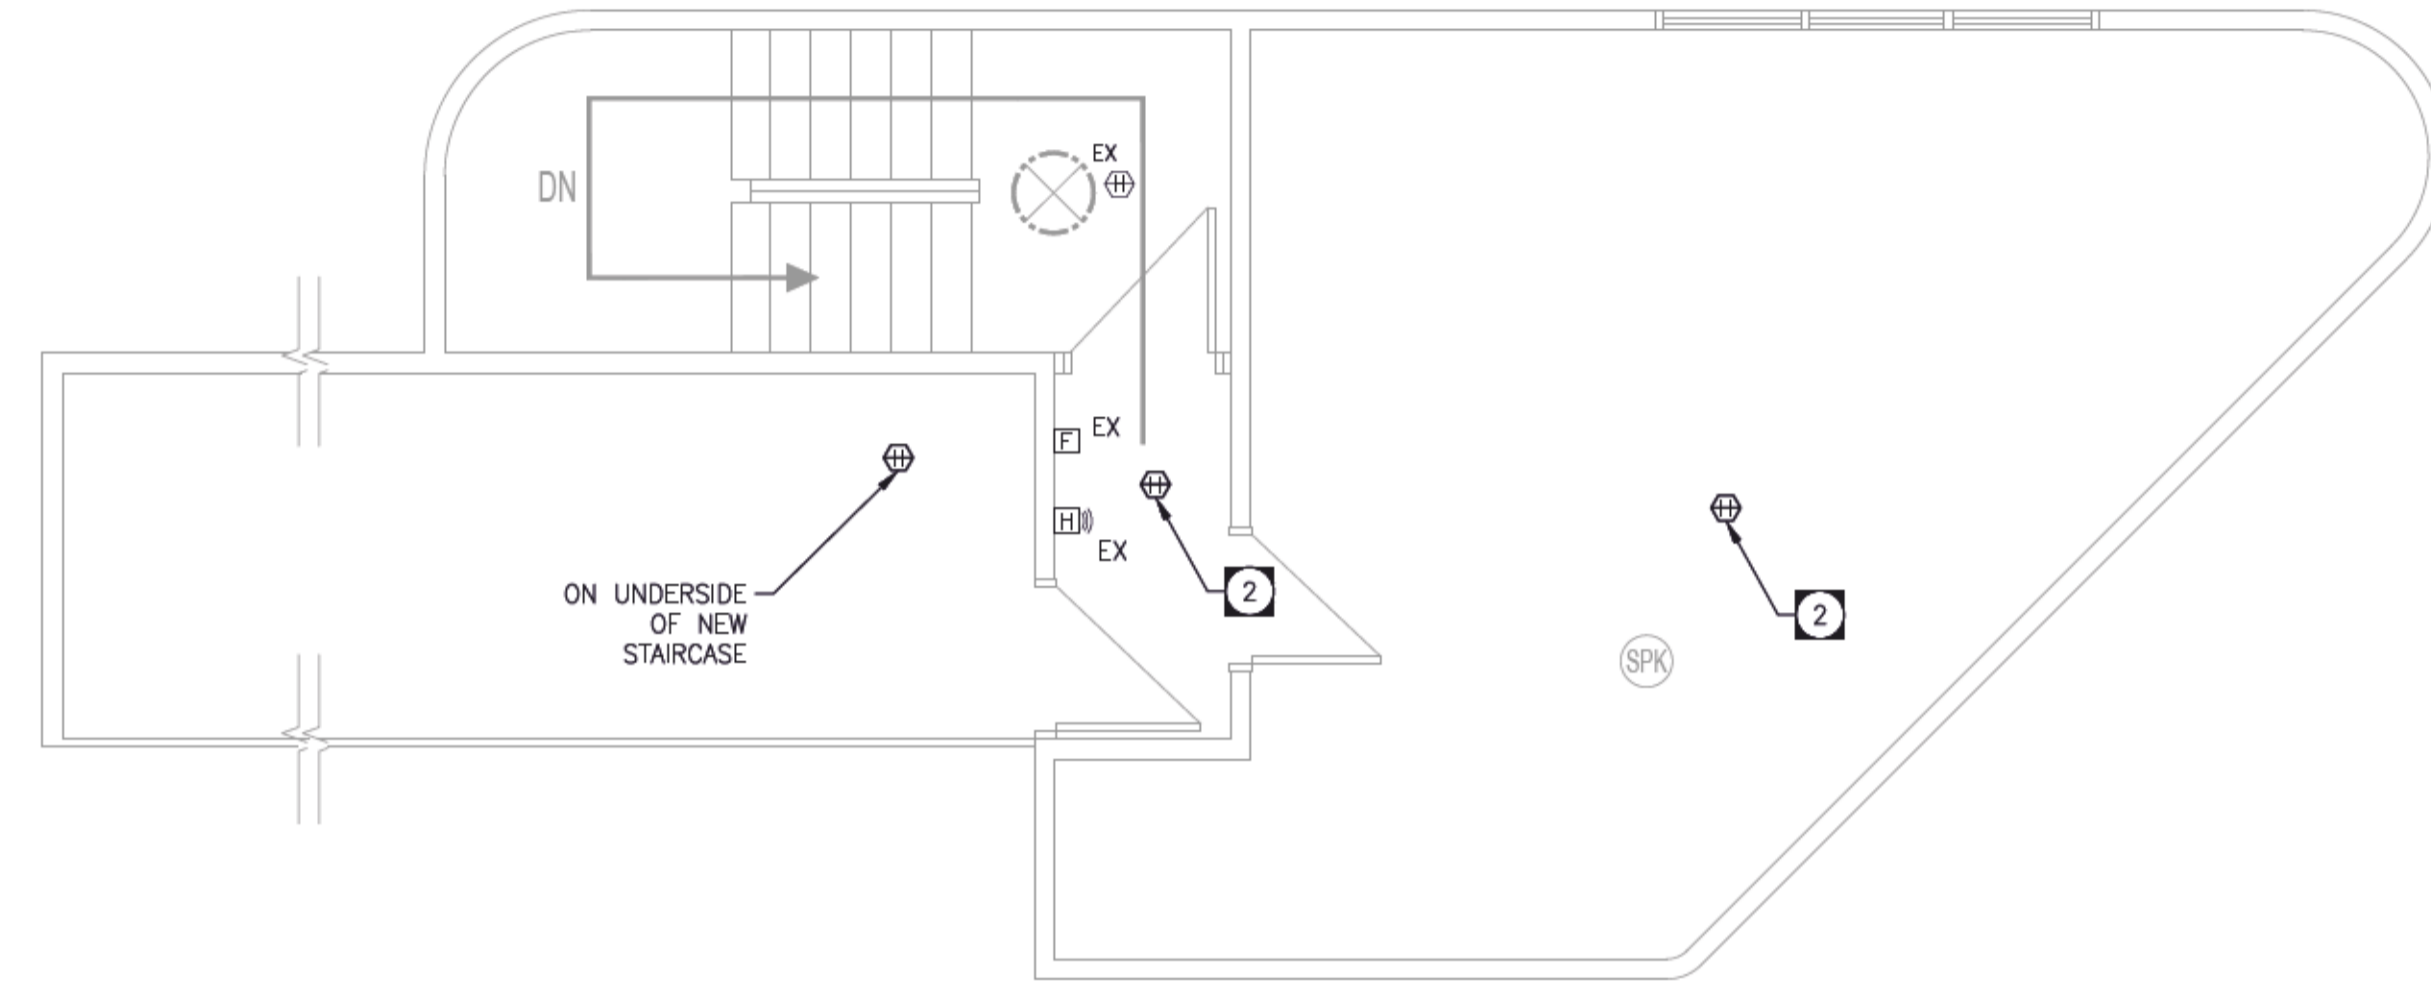

3 THIRD FLOOR-NORTH PLAN
 E1.1 SCALE: 1/4" = 1'-0"

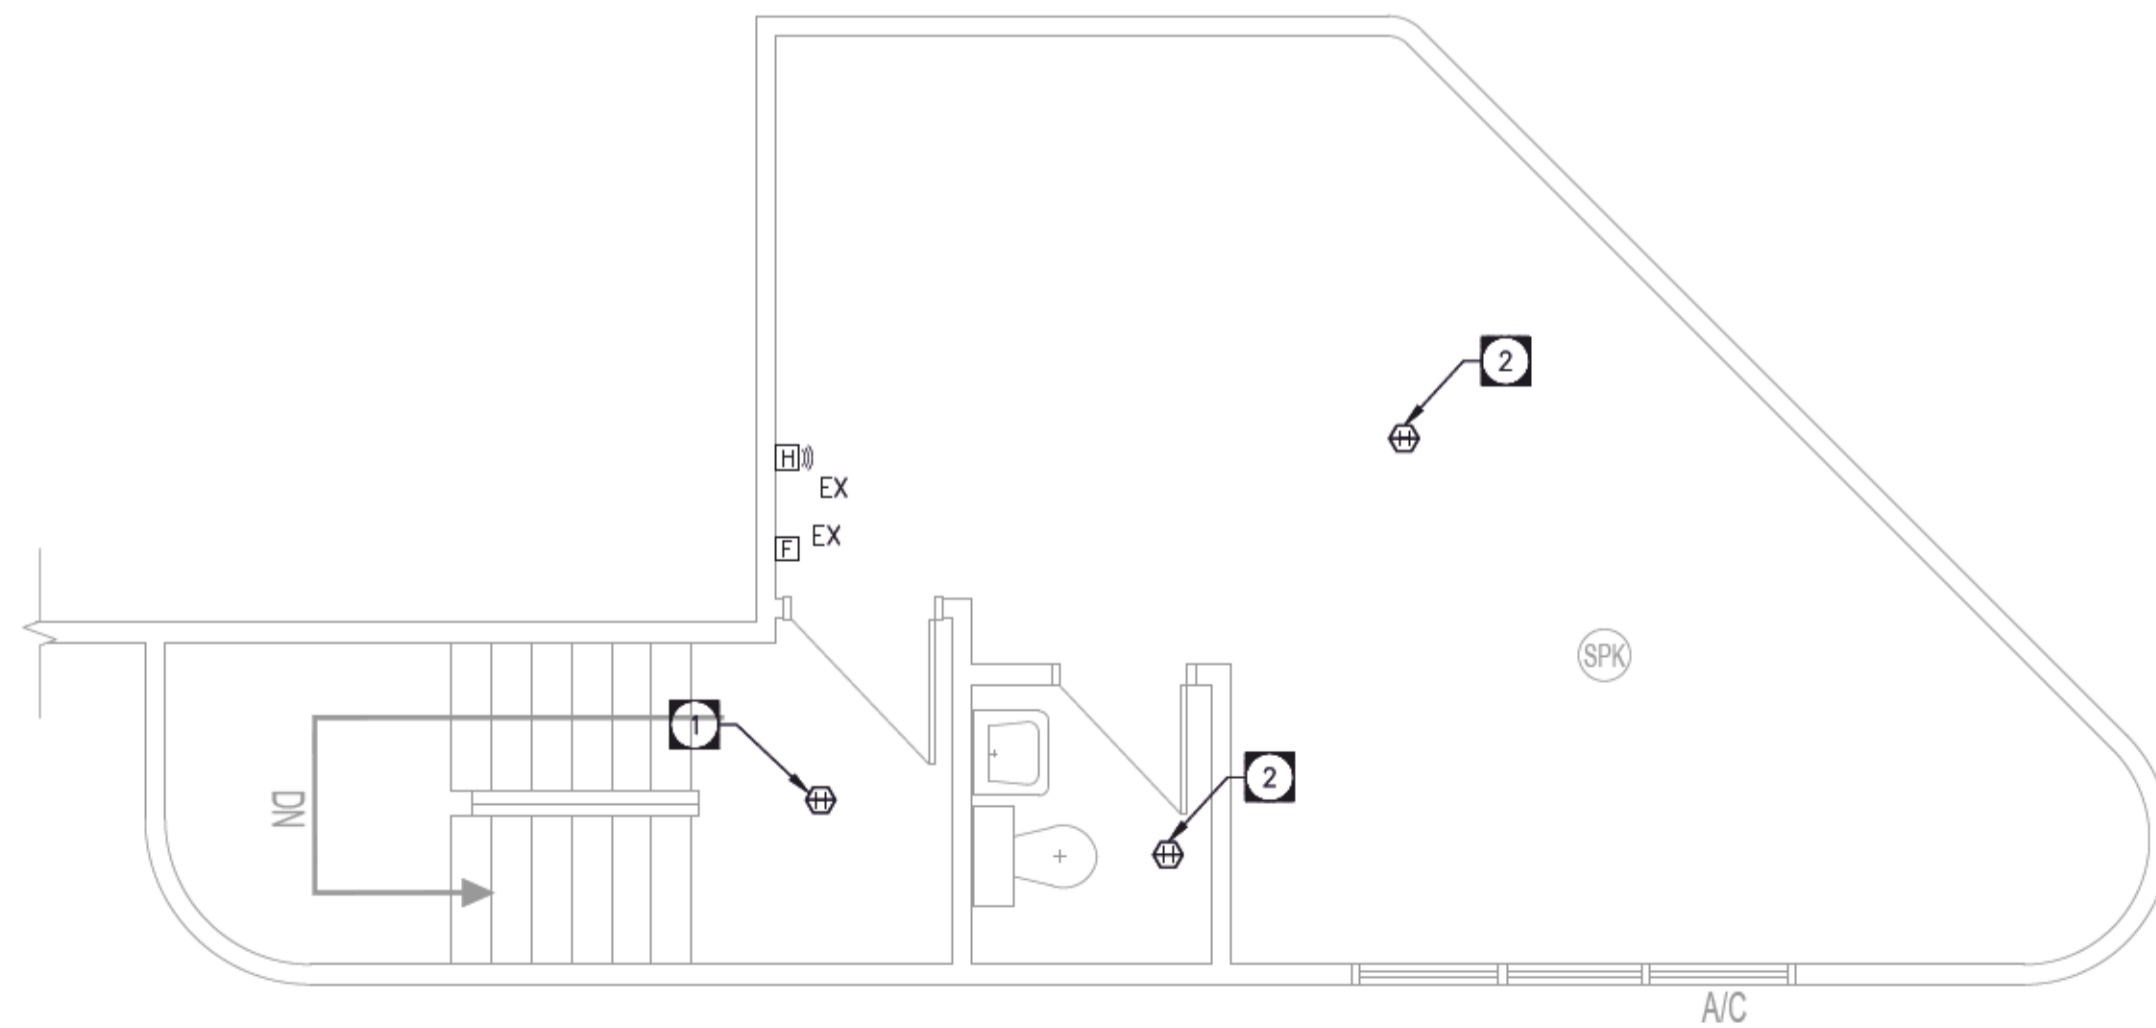

2 SECOND FLOOR-SOUTH PLAN
 E1.1 SCALE: 1/4" = 1'-0"

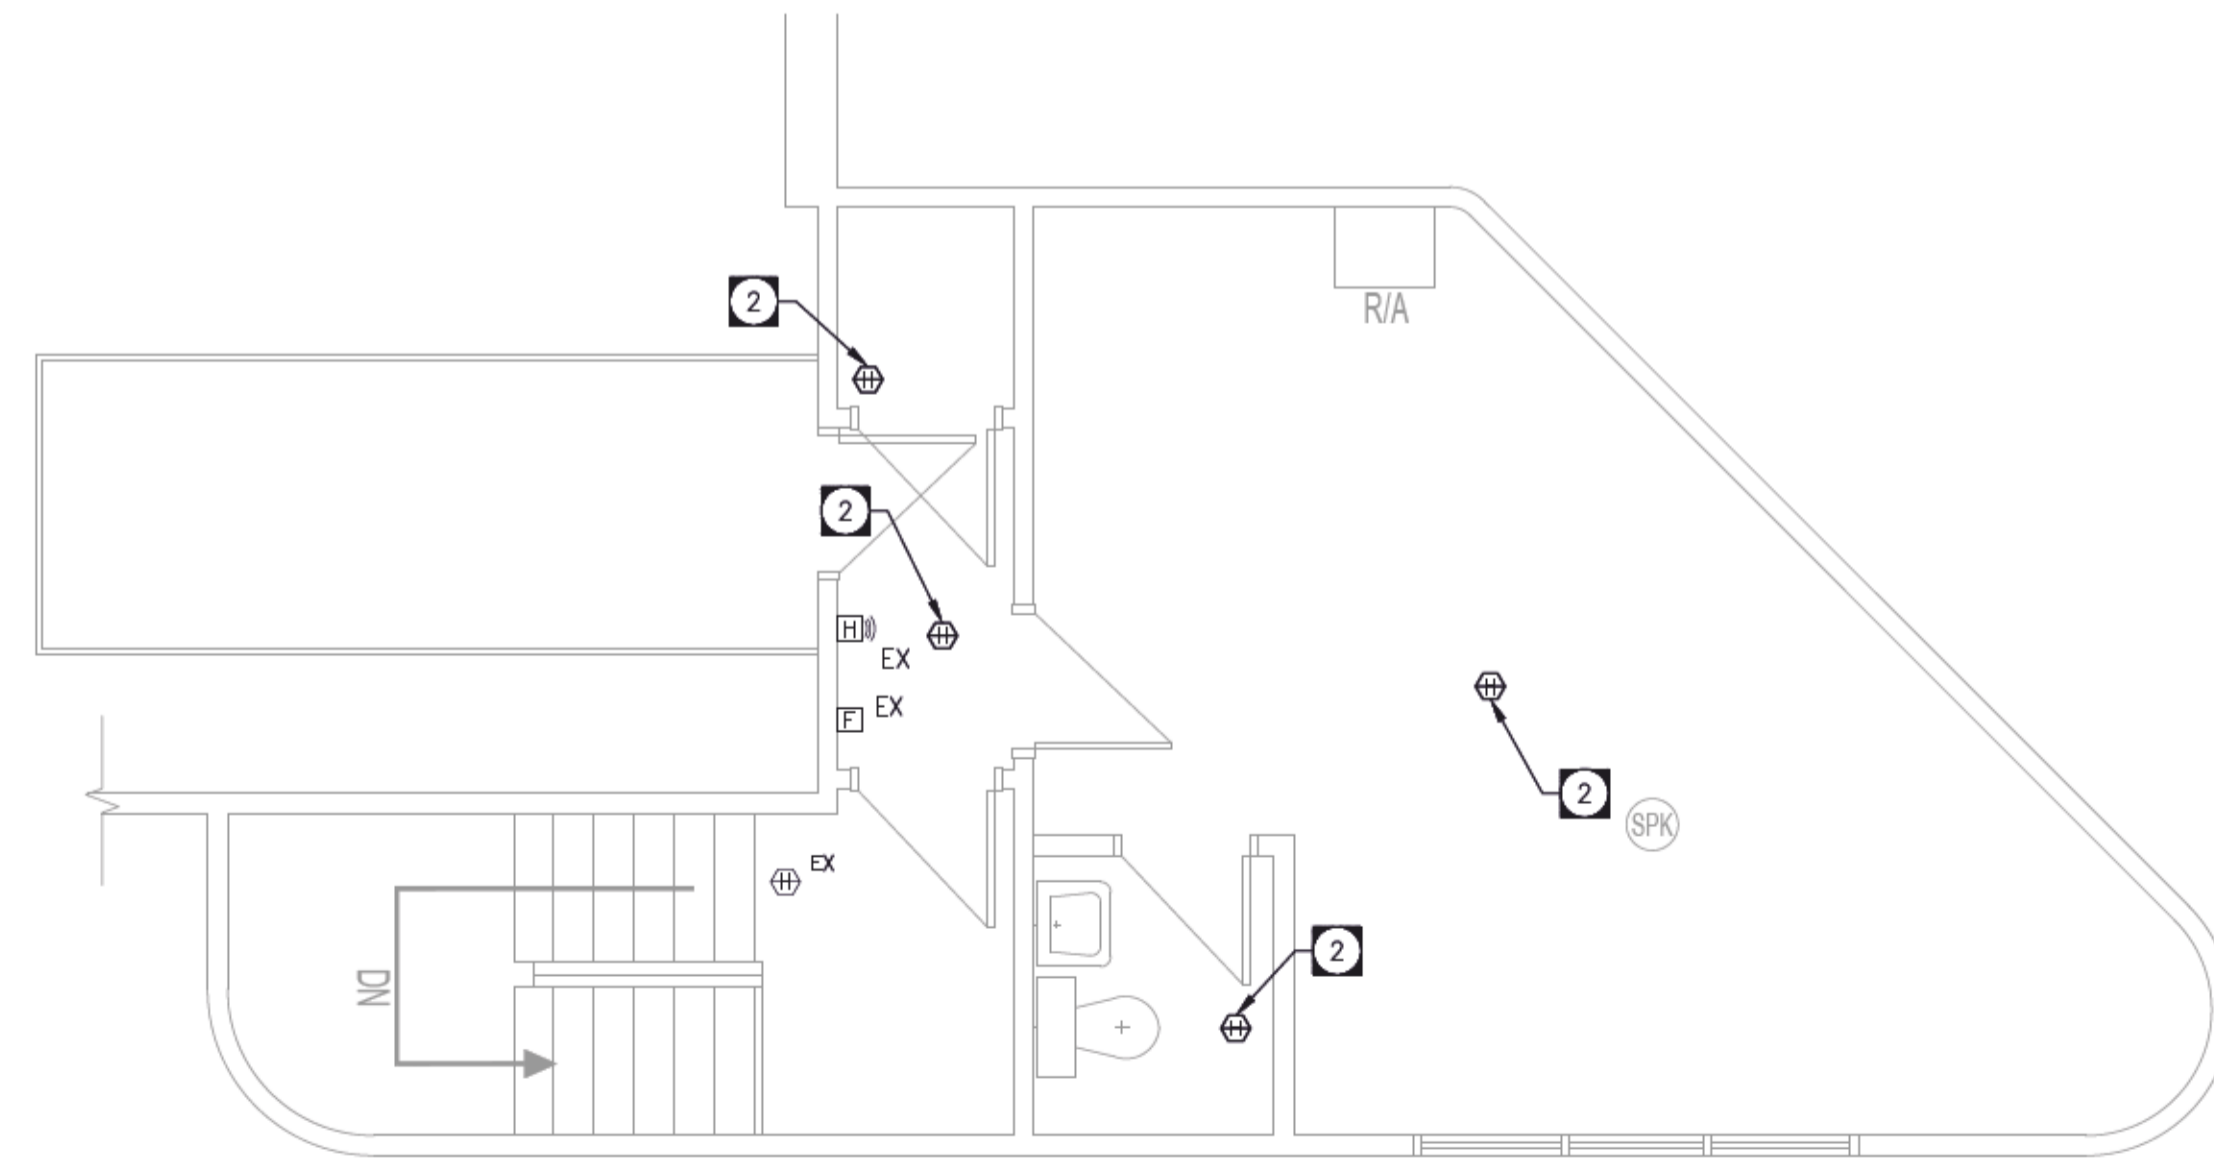

4 THIRD FLOOR-SOUTH PLAN
 E1.1 SCALE: 1/4" = 1'-0"

| No. | ISSUED FOR CONSTRUCTION | TN | 24/05/03 |
|-----|-------------------------|----|----------|
| 0 | REVISION/DESCRIPTION | BY | DATE |

| DATE | USER | CHECKED | SM | DESIGNED | TN | APPROVED | DWG |
|------------|---------------|---------|----|----------|----|----------|-----|
| 2024-XX-XX | USER APPROVAL | | | | | | |

THE CITY OF WINNIPEG
 PLANNING, PROPERTY AND
 DEVELOPMENT DEPARTMENT
 MUNICIPAL ACCOMMODATIONS DIVISION
 3-65 GARRY STREET, R3C 4K4

PROJECT
 RAINBOW STAGE
 FIRE ALARM UPGRADES

2021 MAIN ST
 SHEET TITLE
 FIRE ALARM RENO
 2ND & 3RD FLOOR PLANS

| SCALE | PROJECT No: | SHEET No: |
|----------|-------------|-----------|
| AS SHOWN | 2022-006 | E1.1 |