



LAST SAVE: 2025/04/04 12:28 PM
PATH: C:\Users\winnipeg\Documents\AECOM\City of Winnipeg - NEWPCC Upgrade 2021\Project Files\900 Design Collaboration\60861262 Primary Clarifier Upgrade\E - Electrical\DWG - DD1-0101-EMCL-P602.dwg

ELEMENTARY DIAGRAM:

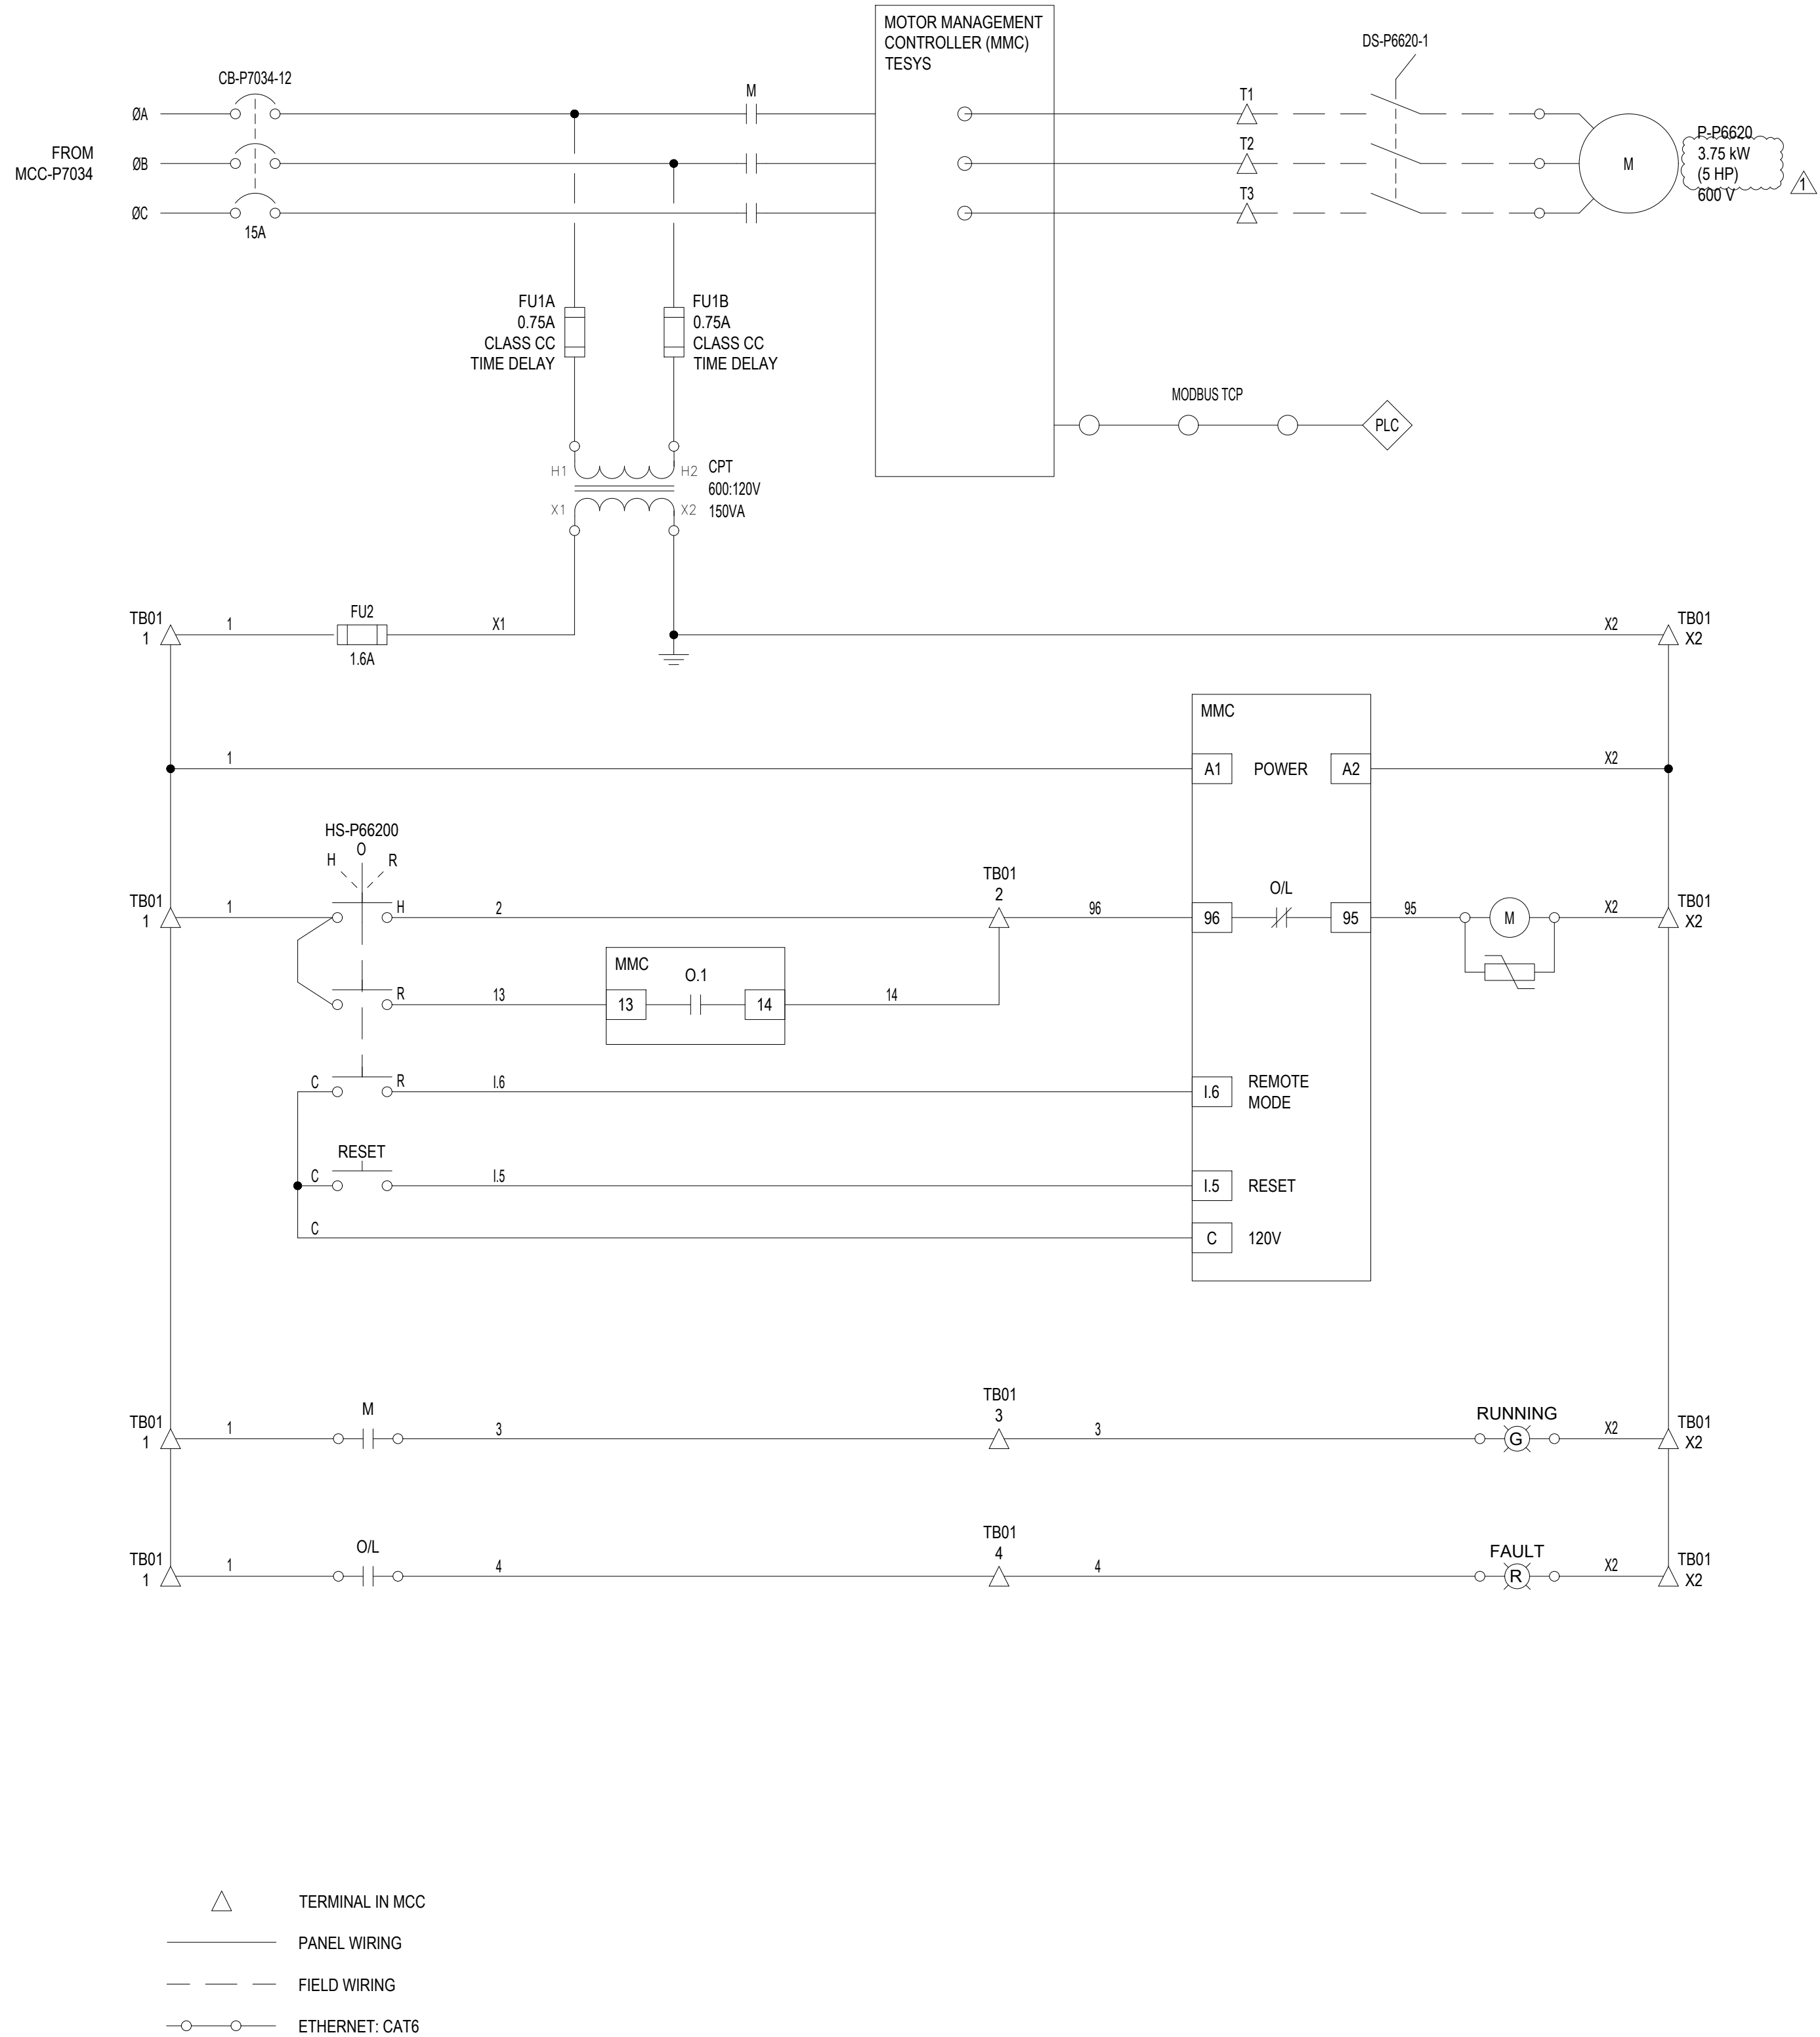

FIELD CONNECTION DIAGRAM:

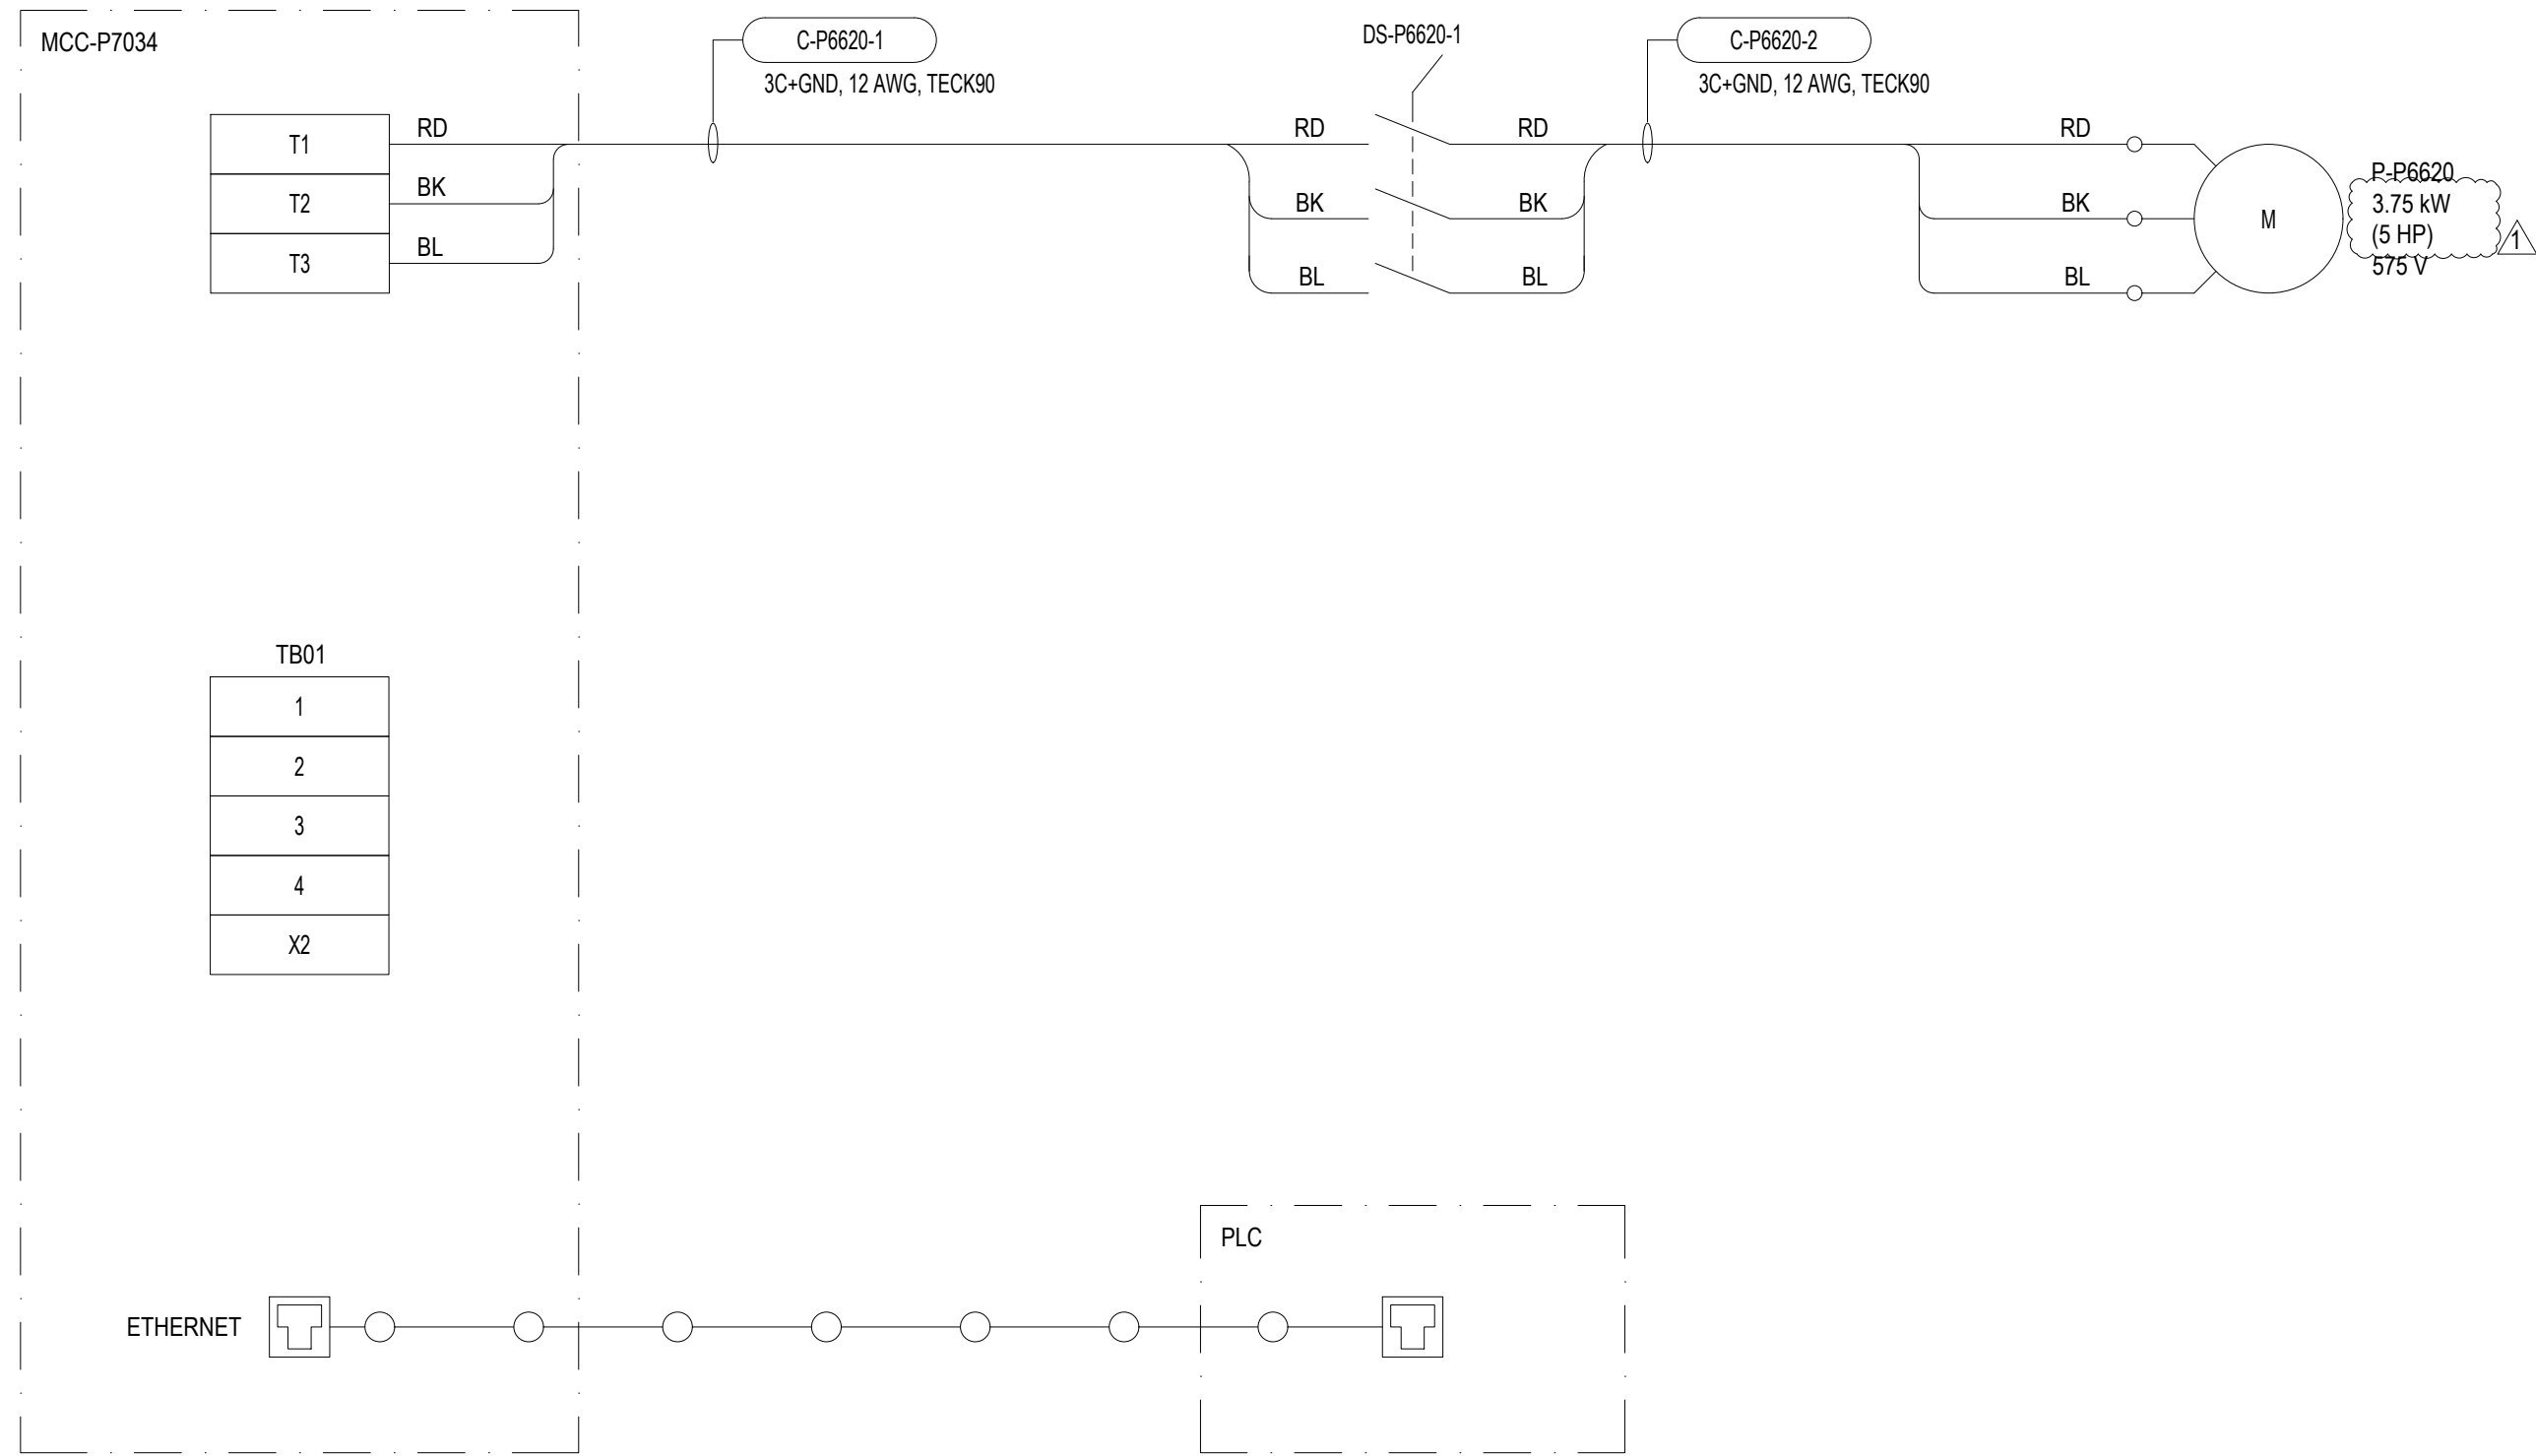

NO.	DRAWING TITLE	DRAWING NUMBER
2	SCUM DEWATERING BUILDING - MCC ELEVATION MCC-P7033 & MCC-P7034	1-0101-ECBD-P701
1	SCUM DEWATERING BUILDING - SINGLE LINE DIAGRAM MCC-P7034	1-0101-ESLD-P709
REFERENCE DRAWING		

**ENGINEERS
GEO-SCIENTISTS
MANITOBA**
Certificate of Authorization
AECOM Canada ULC
No. 4671

NO.	REVISIONS	DATE	DESIGN	CHECK
01	ISSUED FOR ADDENDUM 11	2025-04-04	TW	SB
00	ISSUED FOR TENDER	2025-01-31	JEP	SB
DESIGNED BY: JEP CHECKED BY: SB DRAWN BY: JEP APPROVED BY: NW SCALE: NONE RELEASED FOR CONSTRUCTION BY: DATE: 2020-12-09 CONSULTANT NO.: P3-E610				

ENGINEER'S SEAL			THE CITY OF WINNIPEG WATER AND WASTE DEPARTMENT		
			NORTH END SEWAGE TREATMENT PLANT PRIMARY CLARIFICATION PROJECT ELECTRICAL MOTOR STARTER SCHEMATICS HOT WATER PUMP P-P6620		
CITY DRAWING NUMBER 1-0101-EMCL-P602			SHEET 001	REV. 01	SIZE A1

TENDER NO. 721-2024