



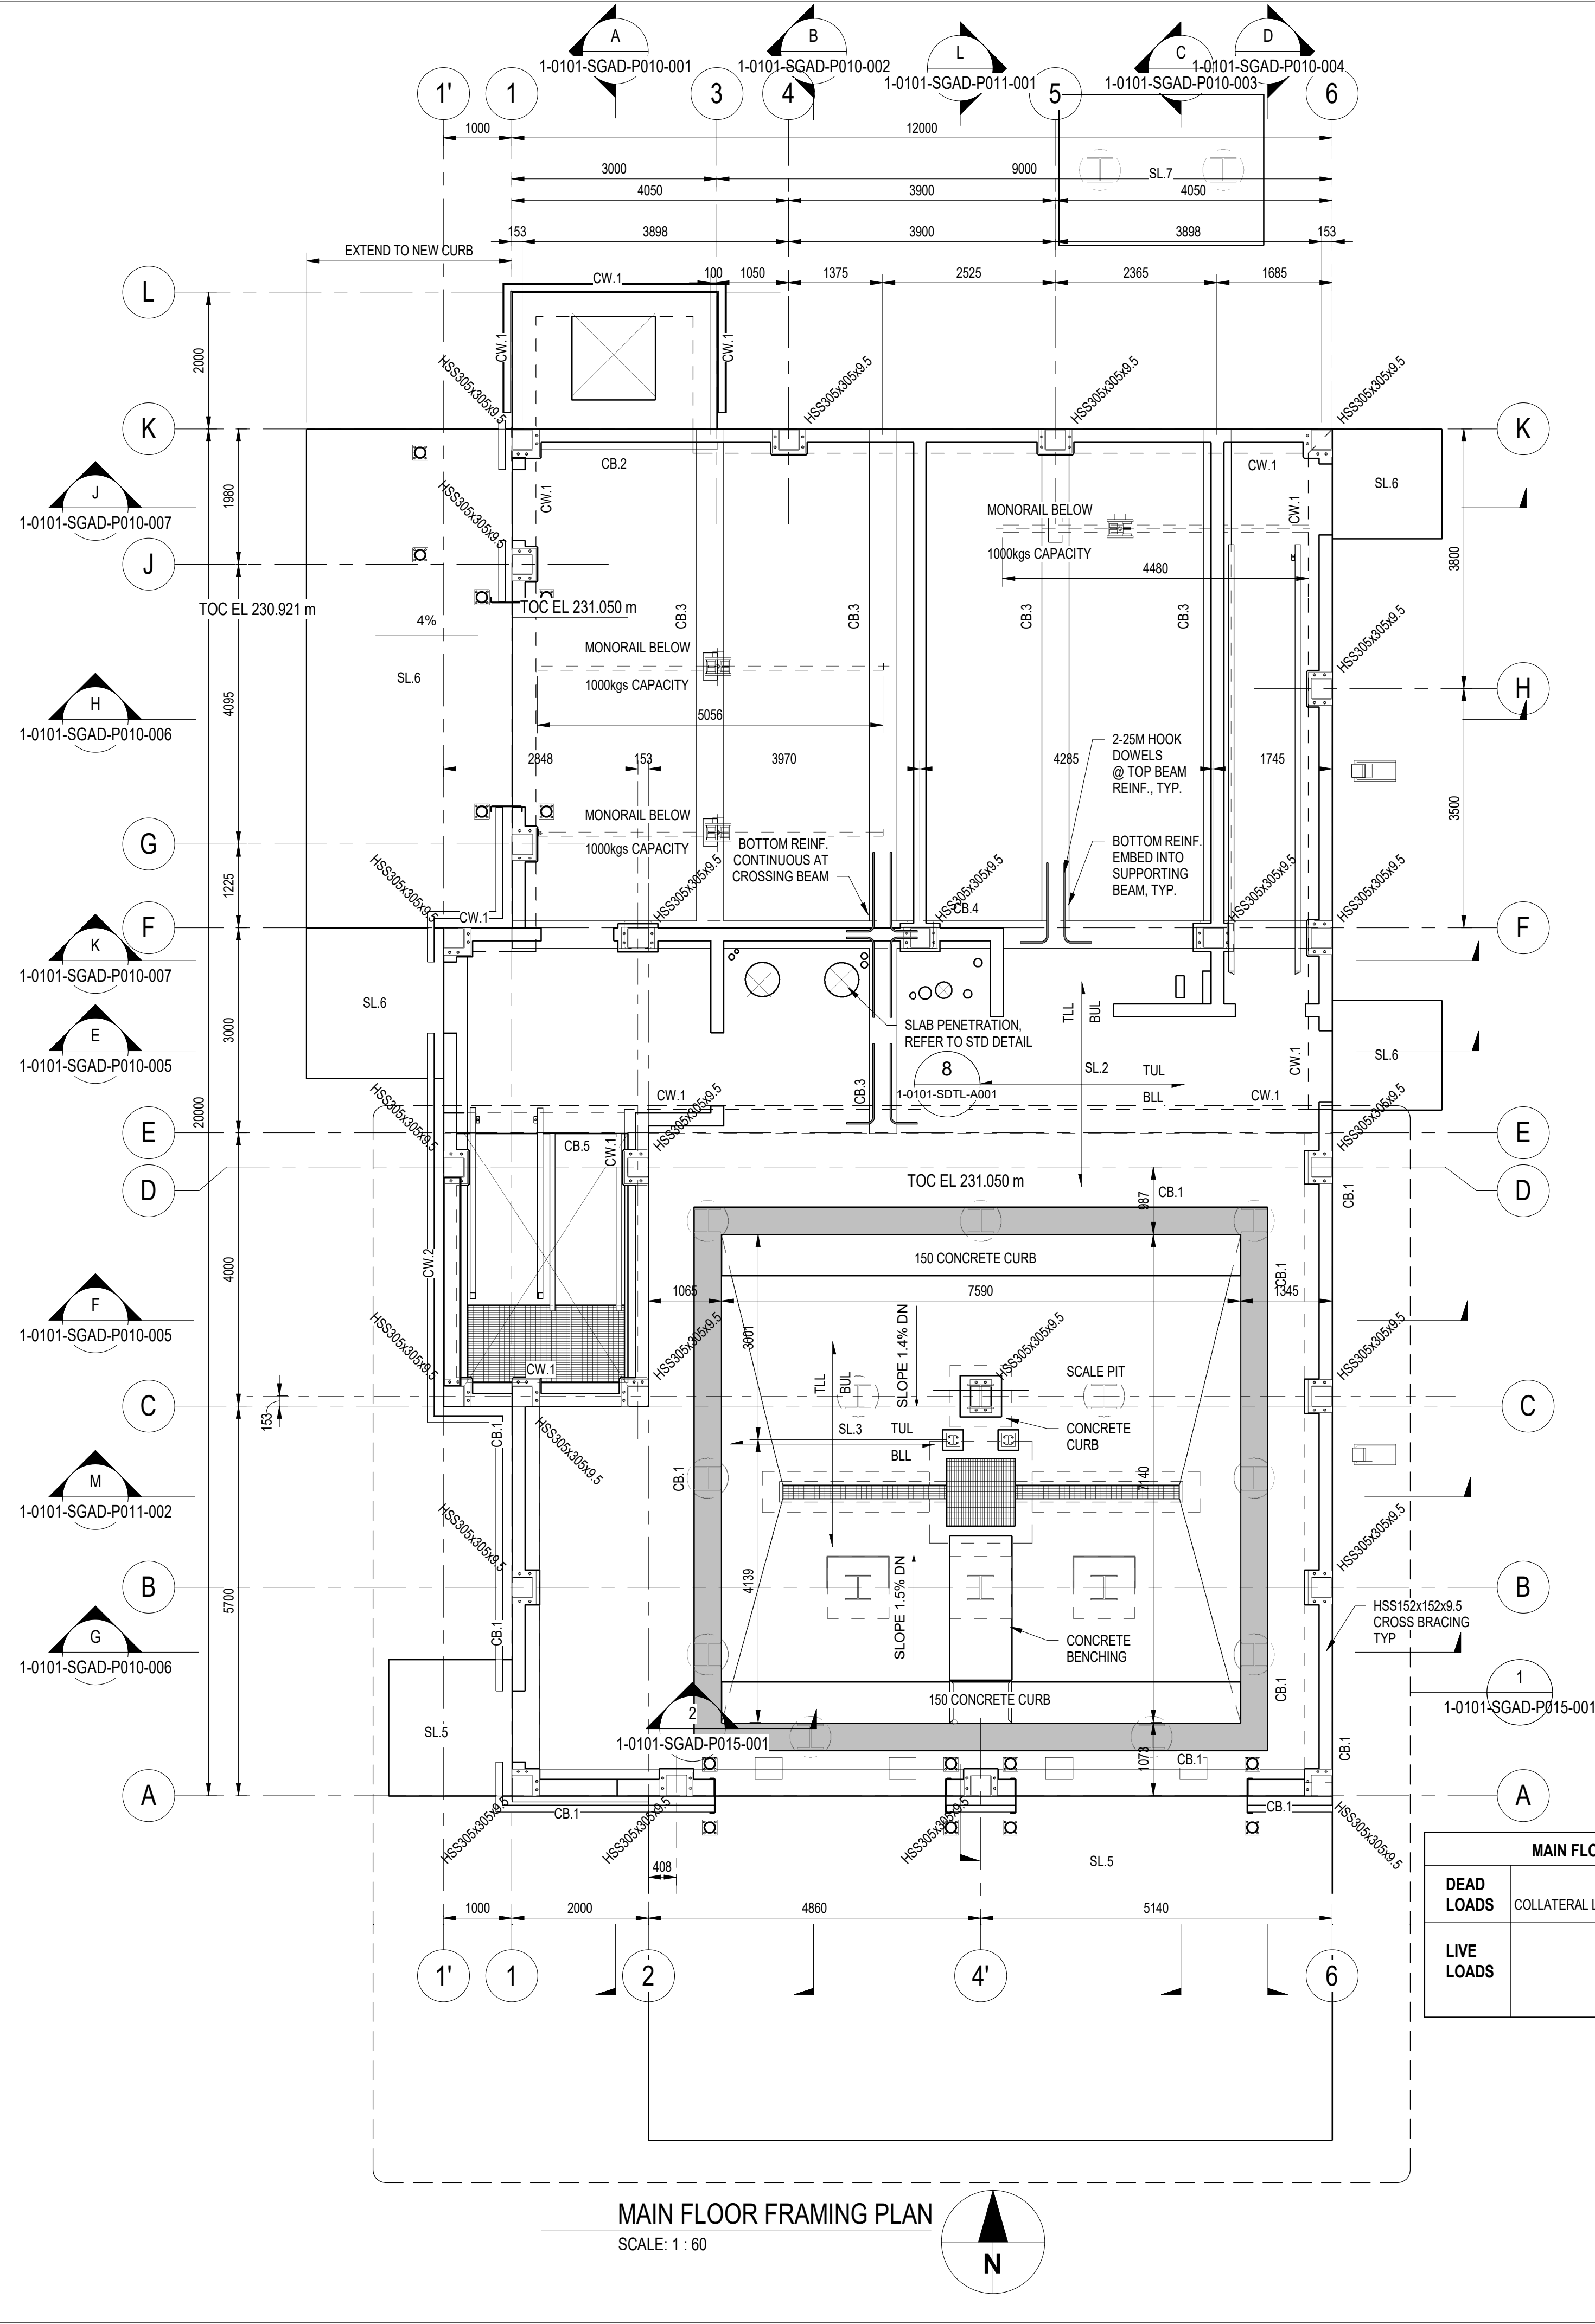

MAIN FLOOR DESIGN LOADS (UNFACTORED)		
DEAD LOADS	STRUCTURE SELF WEIGHT	2.0 kPa
	COLLATERAL LOAD (PROCESS, ELECTRICAL, MECHANICAL)	2.0 kPa
LIVE LOADS	LOADING BAY	12.0 kPa
	SCALE PIT	14.4 kPa
	POLYMER ROOM	12.0 kPa
	ELECTRICAL ROOM	7.2 kPa
	STAIRS & CHECKER PLATE	4.8 kPa

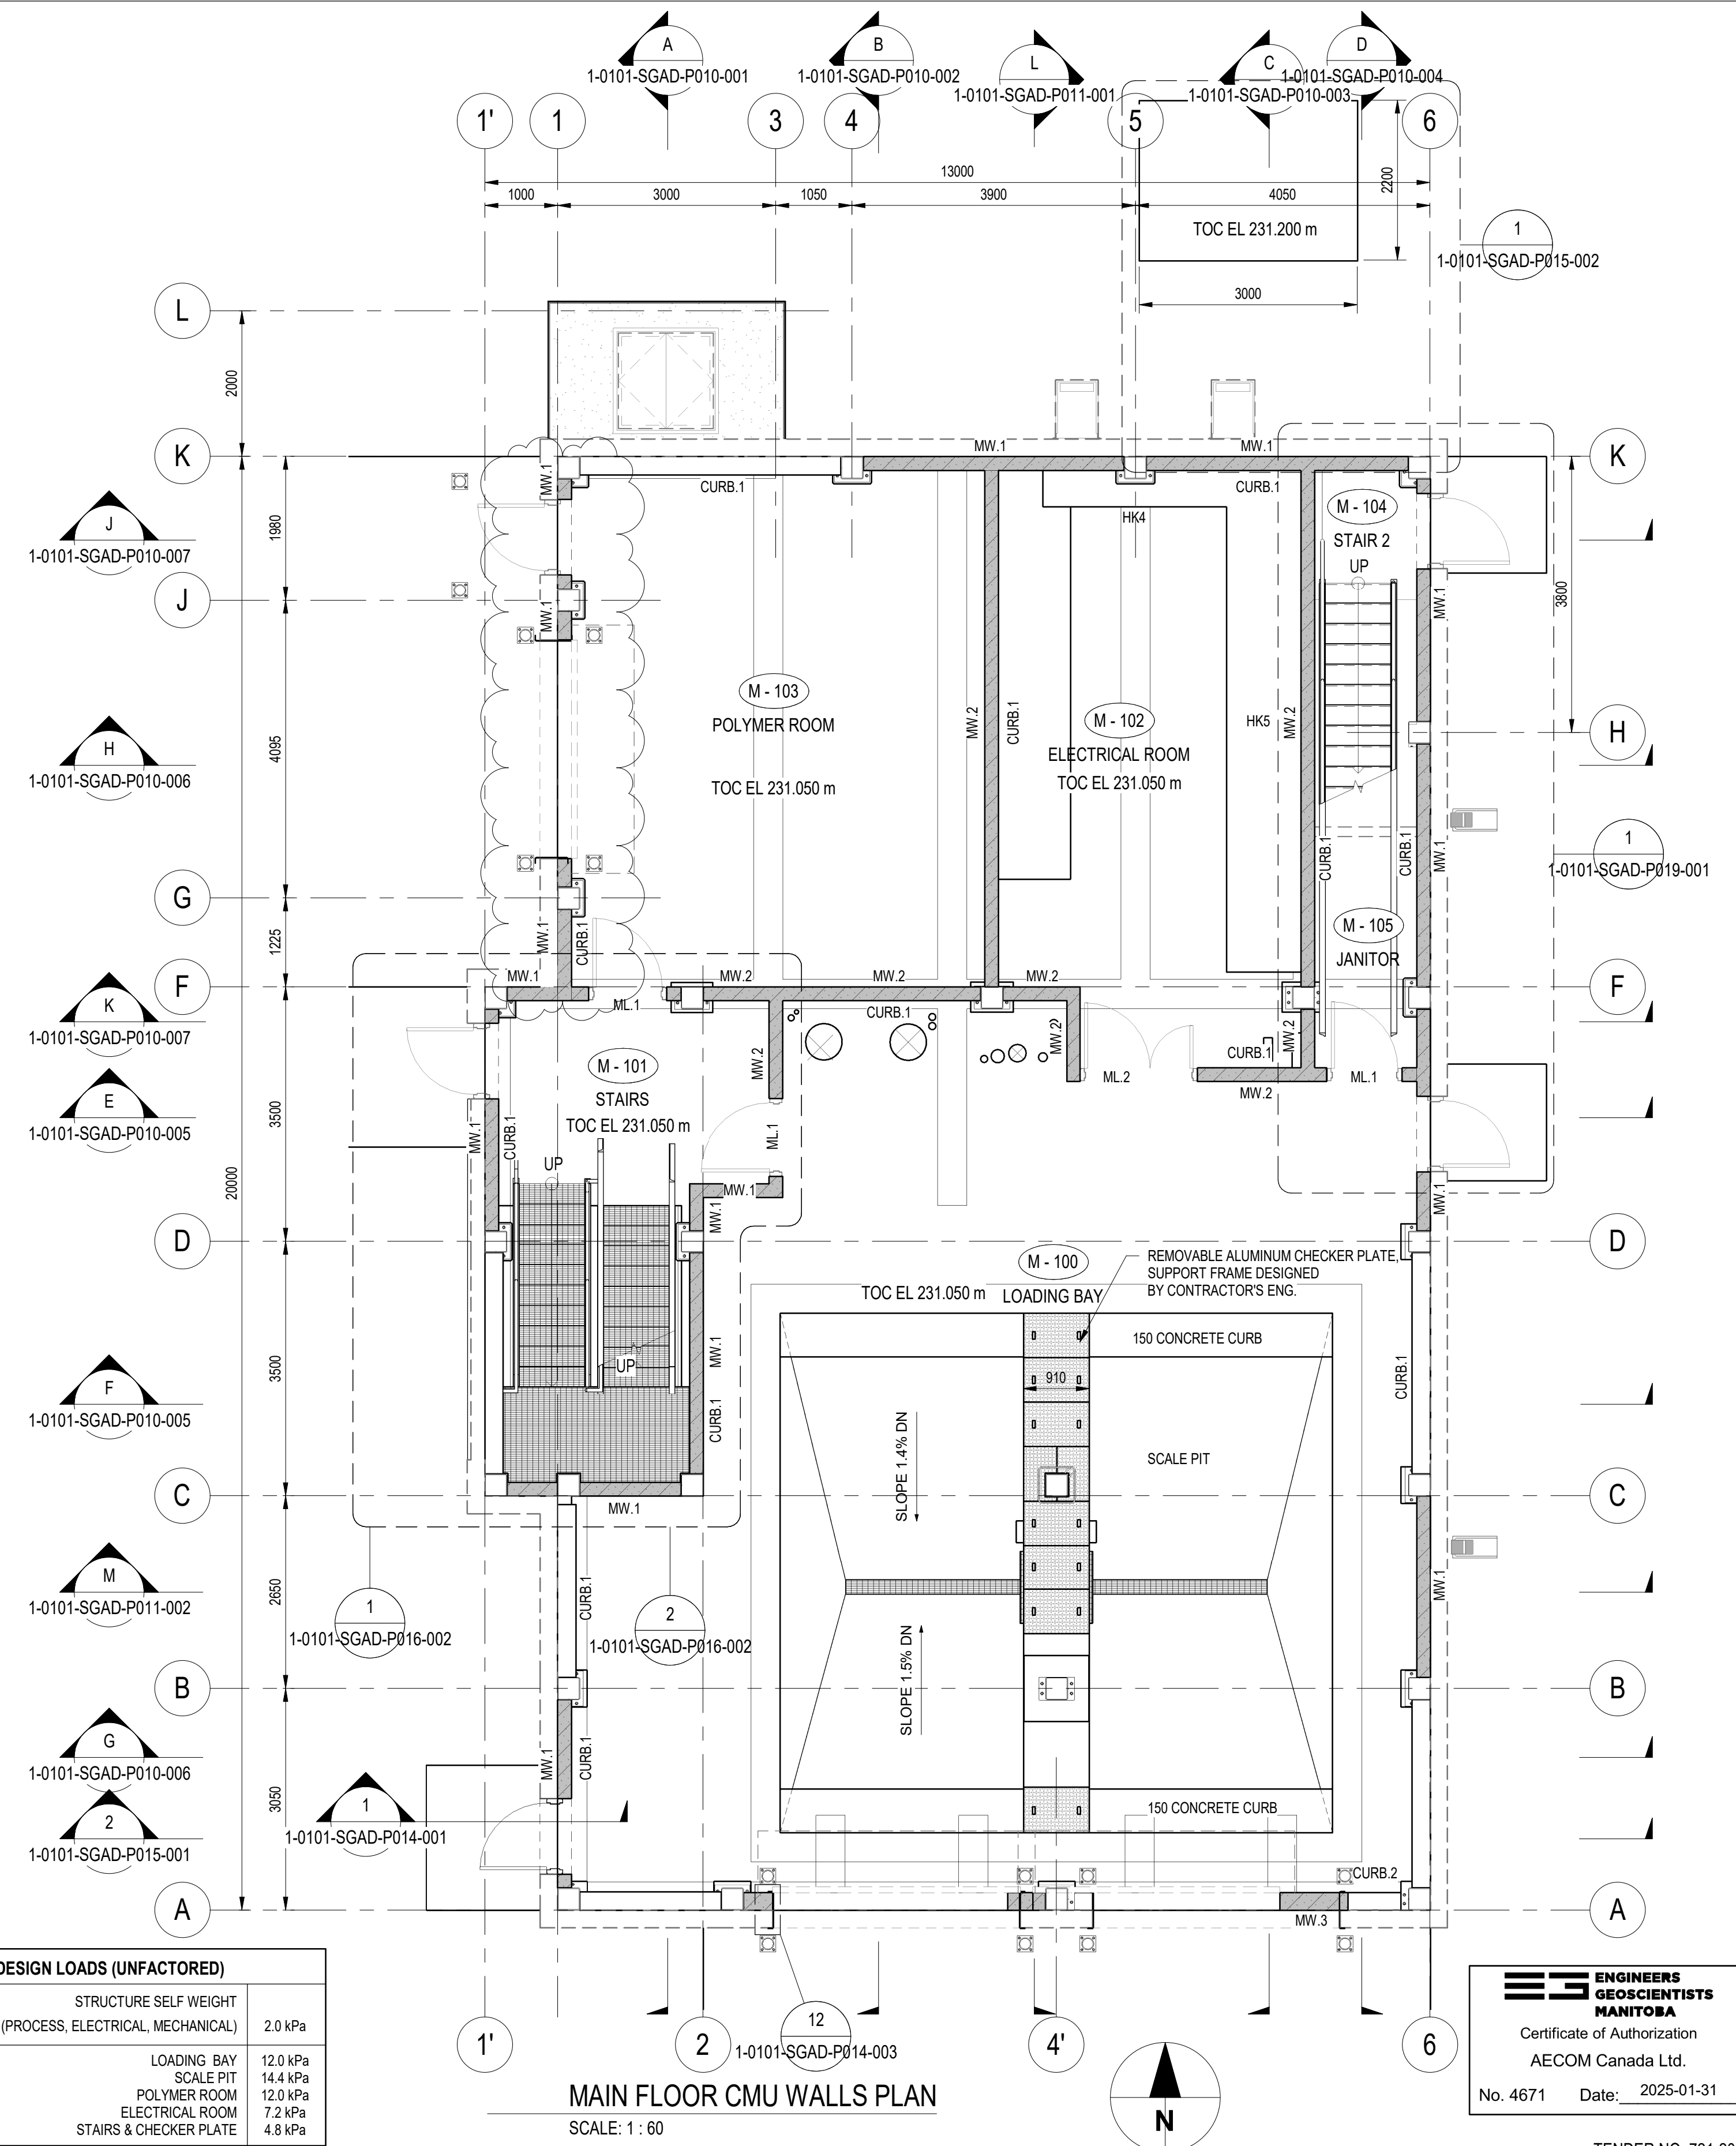

DESIGNED BY: CT				CHECKED BY: MB			
DRAWN BY: BF				APPROVED BY: NW			
SCALE: As indicated				RELEASED FOR CONSTRUCTION BY:			
DATE: 2020-12-09				DATE:			
CONSULTANT NO.: P3-S102							
01	ISSUED FOR ADDENDUM 11	2025-04-04	CT	MB			
00	ISSUED FOR TENDER	2025-01-31	CT	MB			
NO.	REVISIONS	DATE	DESIGN	CHECK			



THE CITY OF WINNIPEG
WATER AND WASTE DEPARTMENT

NORTH END SEWAGE TREATMENT PLANT
PRIMARY CLARIFICATION PROJECT
STRUCTURAL
MAIN FLOOR FRAMING PLAN
MAIN FLOOR CMU WALLS PLAN

CITY DRAWING NUMBER: 1-0101-SGAD-P002
SHEET: 001
REV: 01
SIZE: A1