

ALL SIZE - 50mm x 84mm

WALL OPENING SCHEDULE					
MARK	HEIGHT	WIDTH	ASSOCIATED LEVEL	SILL HEIGHT	REMARKS
001	150	200	B	2160	CABLE TRAY OPENING
002	150	400	B	2200	CABLE TRAY OPENING
003	120	120	B	2490	ROUND OPENING
004	120	120	B	2490	ROUND OPENING
005	100	100	B	2652	ROUND OPENING
006	100	100	B	3125	ROUND OPENING
007	100	100	B	3280	ROUND OPENING
008	120	120	B	2815	ROUND OPENING
009	100	100	B	2670	ROUND OPENING
010	180	180	B	2810	ROUND OPENING
011	420	420	B	3000	ROUND OPENING
012	420	420	B	2746	ROUND OPENING
101	4000	3400	M	0	DOOR OPENING
102	4000	3400	M	0	DOOR OPENING
103	2200	1037	M	0	DOOR OPENING
103	2200	1037	M	0	DOOR OPENING
104	2800	3000	M	0	DOOR OPENING

WALL OPENING SCHEDULE					
MARK	HEIGHT	WIDTH	ASSOCIATED LEVEL	SILL HEIGHT	REMARKS
105	2200	1037	M	0	DOOR OPENING
106	1600	2848	M	3000	WINDOW OPENING
107	2200	1037	M	0	DOOR OPENING
108	1600	2848	R	1100	WINDOW OPENING
109	2200	1037	M	0	DOOR OPENING
110	1600	2848	3	400	WINDOW OPENING
111	150	200	M	2570	CABLE TRAY OPENING
112	120	470	M	2740	CABLE TRAY OPENING
113	120	470	M	2740	FAN OPENING
114	470	470	M	2540	CABLE TRAY OPENING
115	430	430	M	2580	FAN OPENING
116	90	90	B	2165	
118	150	200	M	2200	CABLE TRAY OPENING
119	150	200	M	2365	CABLE TRAY OPENING
120	150	200	M	2365	CABLE TRAY OPENING
121	150	640	M	2965	CABLE TRAY OPENING
122	520	520	M	3080	ROUND OPENING

WALL OPENING SCHEDULE					
MARK	HEIGHT	WIDTH	ASSOCIATED LEVEL	SILL HEIGHT	REMARKS
123	550	550	M	2470	FIRE DAMPER OPENING
124	150	340	M	2850	CABLE TRAY OPENING
125	2200	1037	M	0	
126	1600	2848	M	3000	WINDOW OPENING
201	4800	1200	2	1500	WINDOW OPENING
202	800	800	2	1600	SQ. DUCT OPENING
204	1200	550	2	3100	RECT. DUCT OPENING
205	4800	1200	2	1500	WINDOW OPENING
206	800	800	2	300	SQ. DUCT OPENING
207	800	800	2	4245	SQ. DUCT OPENING
208	800	800	2	4509	SQ. DUCT OPENING
300	1600	2848	3	400	WINDOW OPENING
302	800	800	3	1600	SQ. DUCT OPENING
303	800	800	3	70	SQ. DUCT OPENING



WALL OPENING SCHEDULE					
MARK	HEIGHT	WIDTH	ASSOCIATED LEVEL	SILL HEIGHT	REMARKS
304	150	200	3	2770	CABLE TRAY OPENING
305	150	200	3	2770	CABLE TRAY OPENING
306	150	640	3	2525	CABLE TRAY OPENING
307	150	200	3	3160	CABLE TRAY OPENING
308	150	200	3	2773	CABLE TRAY OPENING
309	150	200	3	3320	CABLE TRAY OPENING
310	150	200	3	3170	CABLE TRAY OPENING
400	1600	2848	R	1100	WINDOW OPENING
402	2200	1037	R	385	DOOR OPENING

WALL OPENING SCHEDULE NOTES:

100 - 399 = OPENINGS IN NEW CMU WALLS

- REFER TO ARCHITECTURAL FOR DOOR OPENINGS.
- OPENINGS DO NOT INCLUDE SPACE FOR INSTALLATION. PROVIDE ROUGH OPENING TO MANUFACTURER'S RECOMMENDATIONS.
- ALL MECHANICAL OPENINGS TO BE VERIFIED WITH MECHANICAL DRAWINGS.
- GALV. LOOSE LAID L89x89x6.4 ANGLES FOR VENEER SUPPORT ABOVE VENEER OPENINGS (U/N OTHERWISE).

NOTE:
FOUNDATION INSULATION NOT SHOWN FOR CLARITY.
REFER TO ARCHITECTURAL DRAWINGS FOR DETAILS

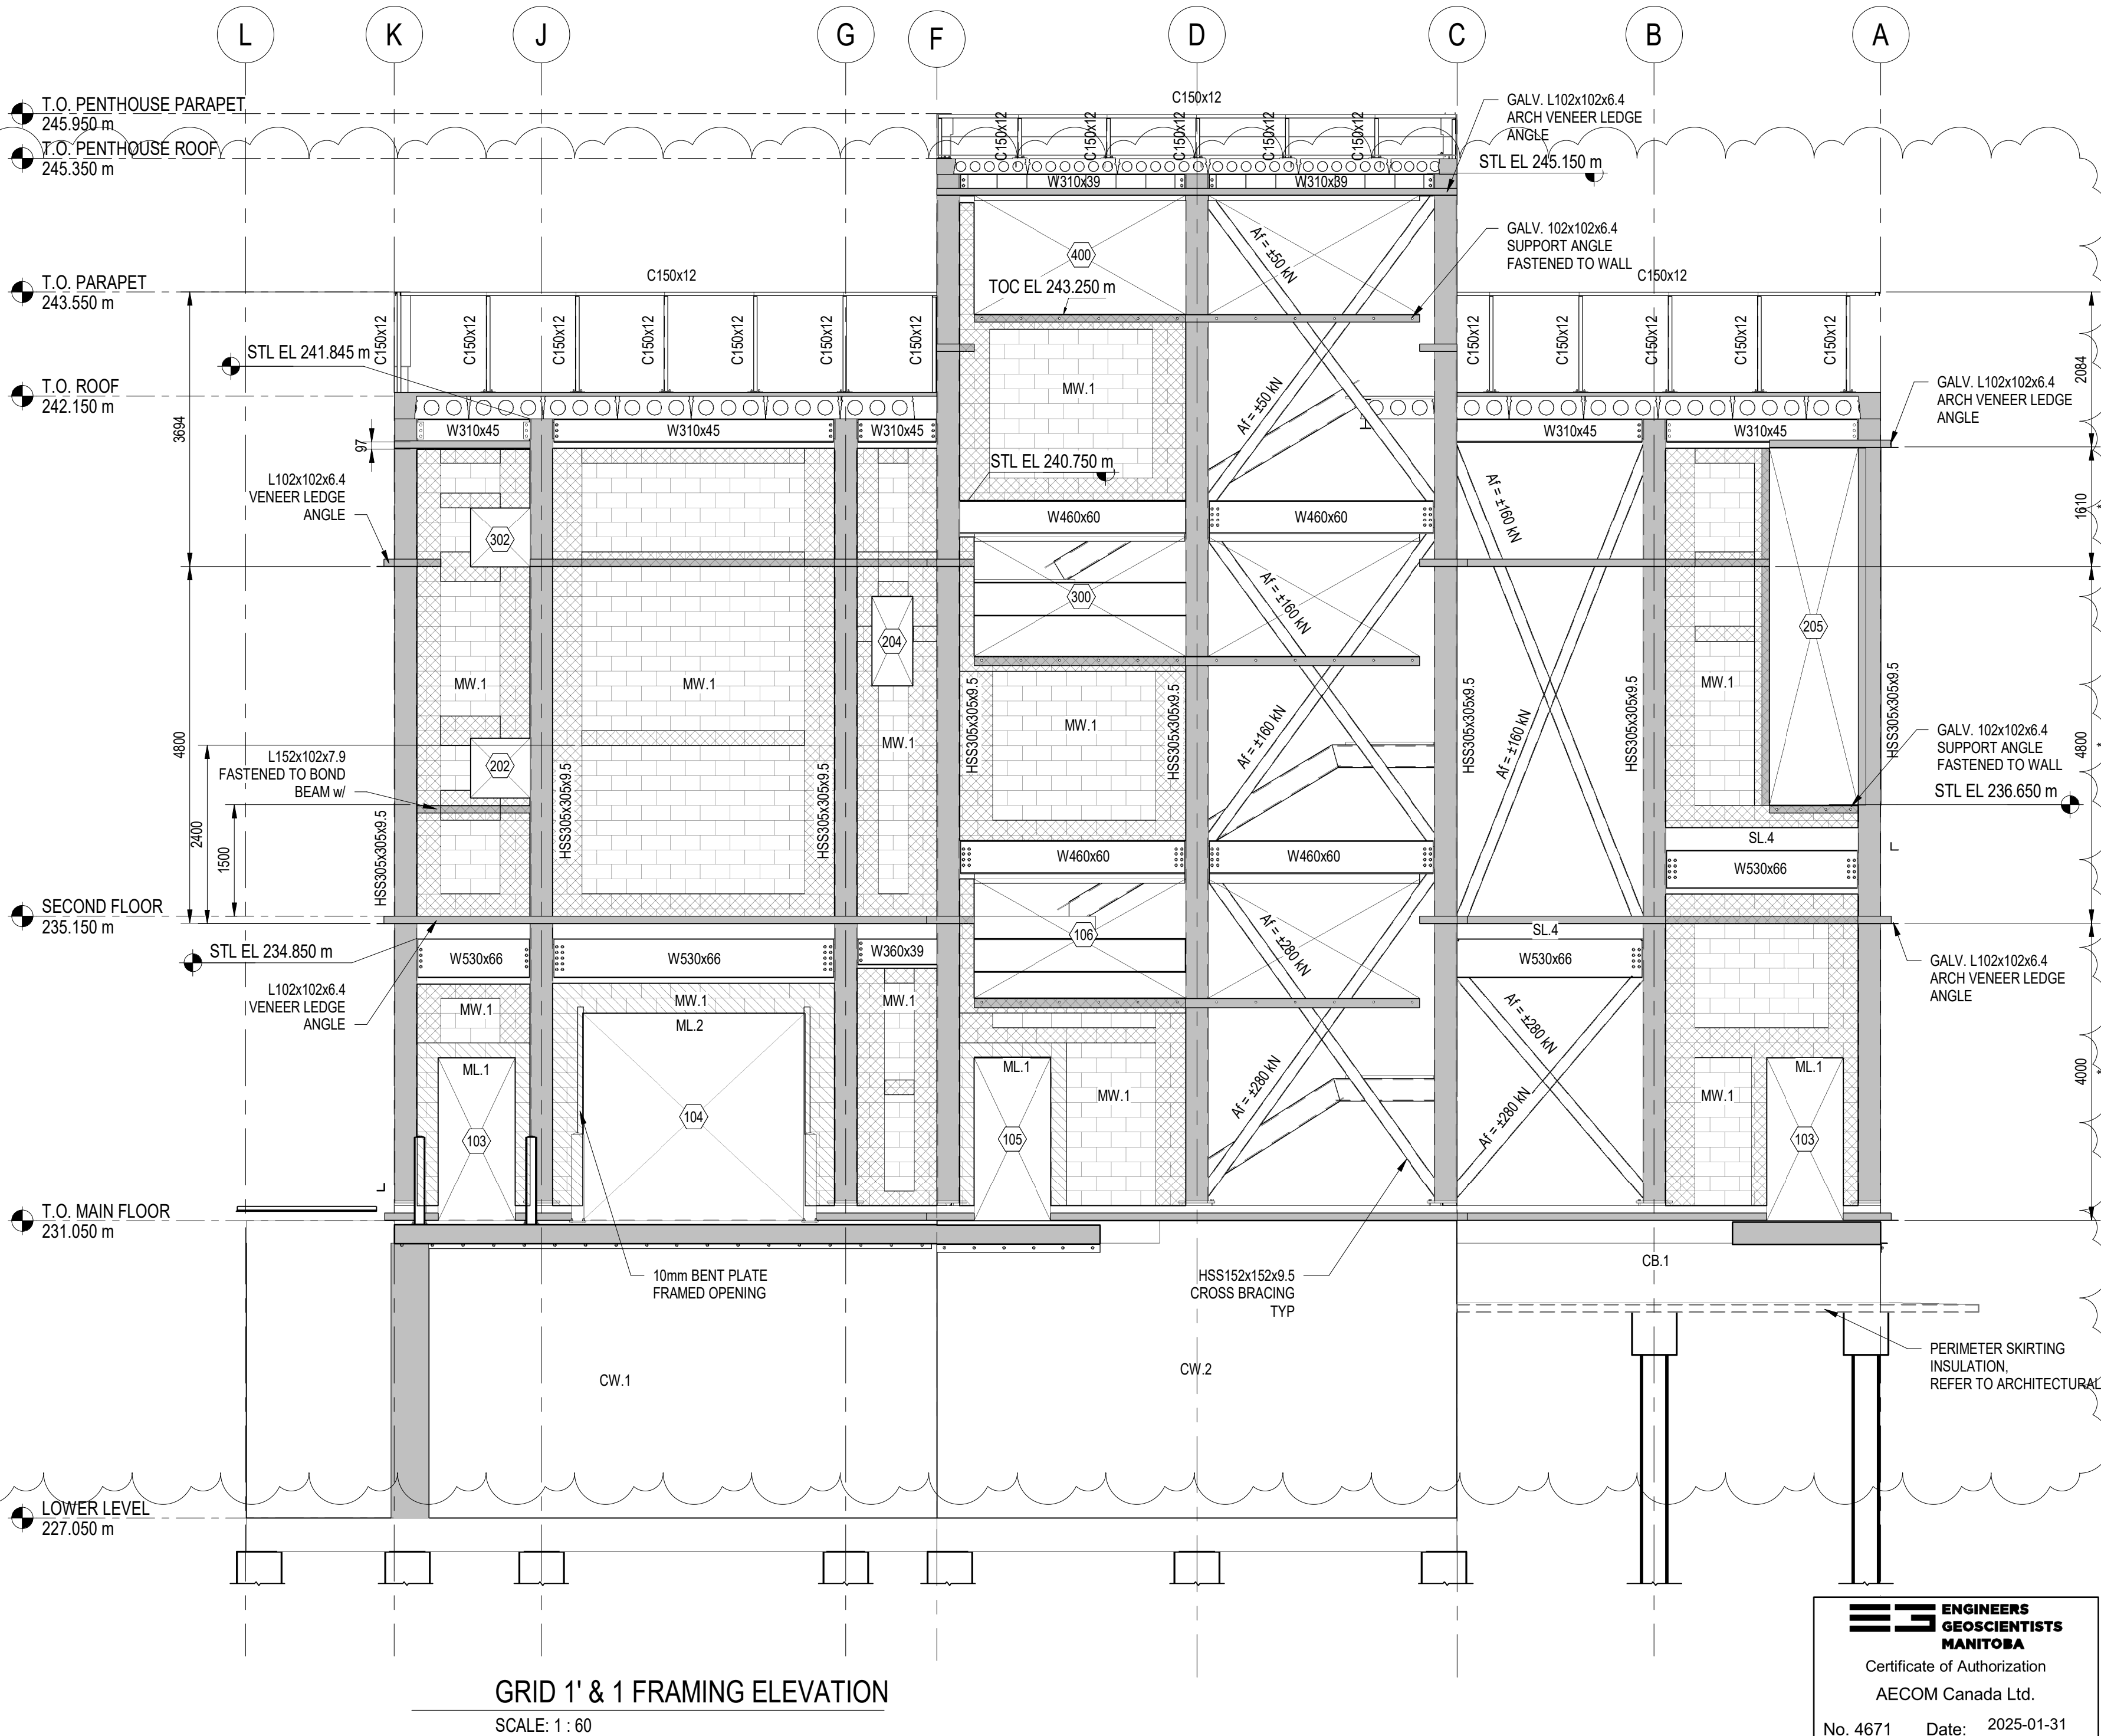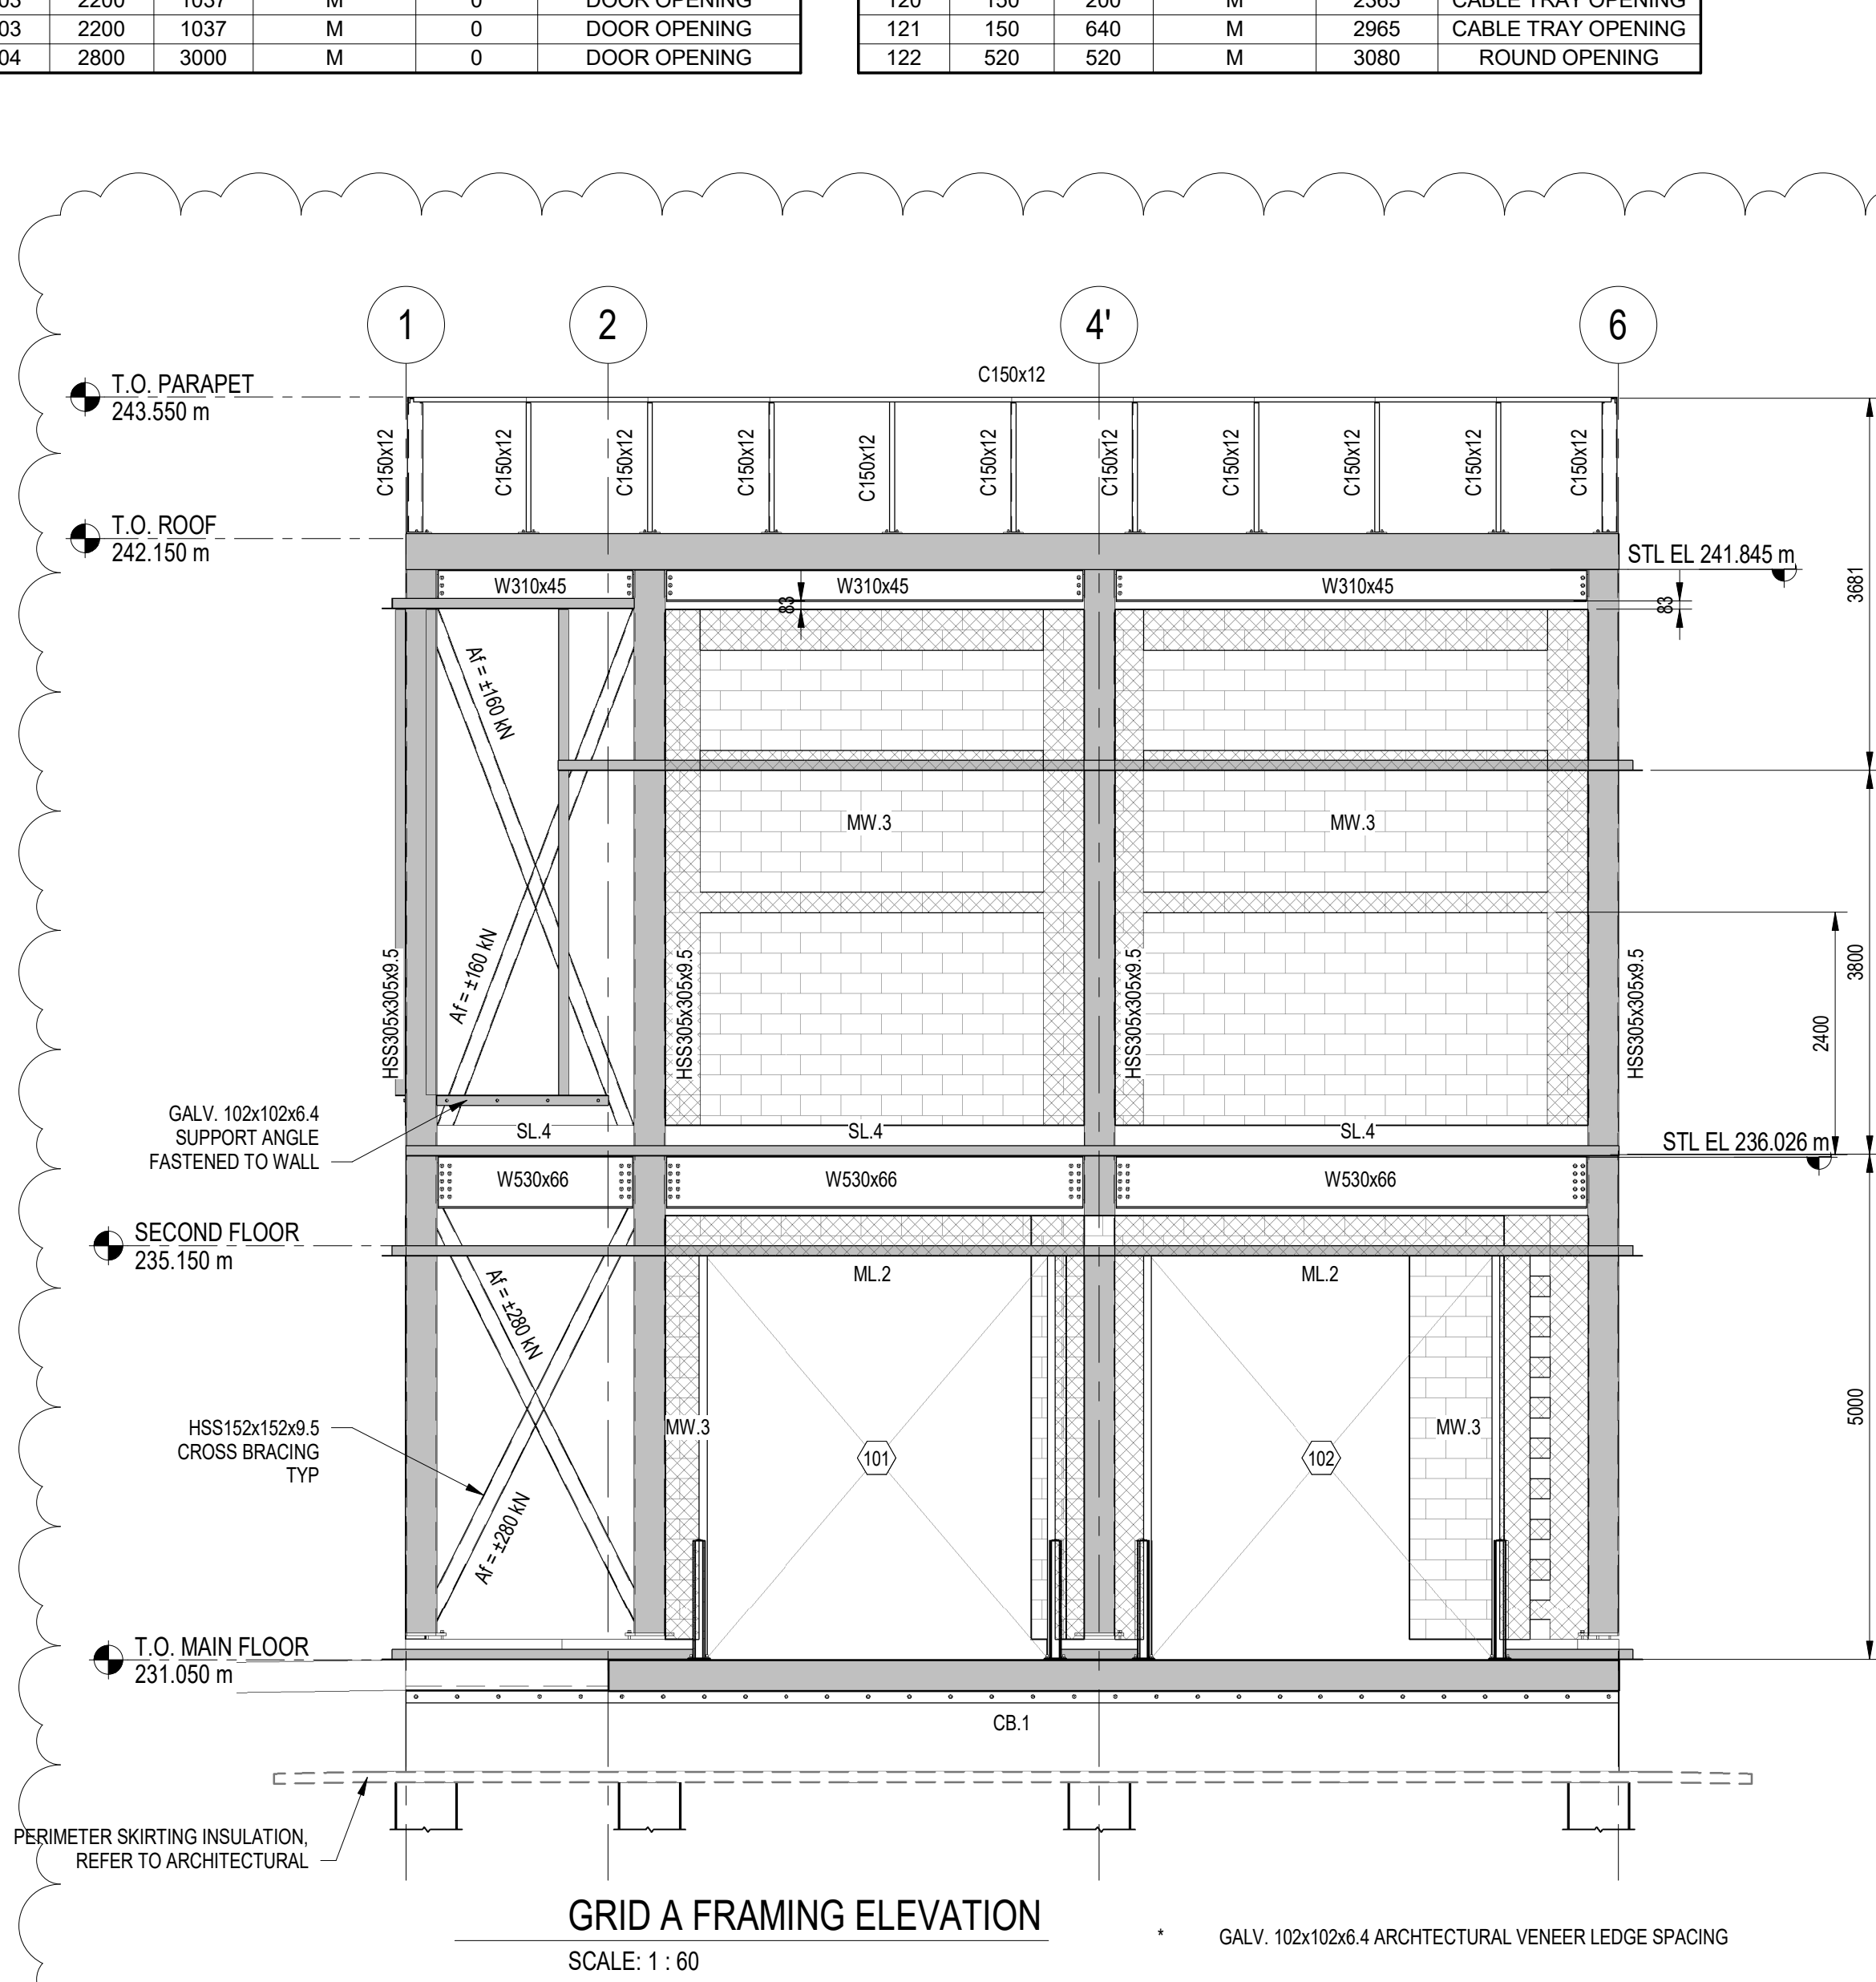

LAST SAVE: 2025-04-07 3:56:01 PM
PATH: \\B:\380\City of Winnipeg - NEWPCC Upgrades 2021\66861262-ACM-P3-D-B_V21.rvt

REFERENCE DRAWINGS STRUCTURAL	
DWG NO.	REFERENCE DRAWING TITLE
1-0101-BSCH-P001-001	SCHEDULES
1-0101-BSCH-P001-002	SCHEDULES
1-0101-SAAA-A002-001	GENERAL NOTES
1-0101-SDTL-A001-001	STANDARD DETAILS
1-0101-SDTL-A001-002	STANDARD DETAILS
1-0101-SDTL-A001-003	STANDARD DETAILS
1-0101-SDTL-A002-001	STANDARD DETAILS
1-0101-SFDW-P001-001	PIILING PLAN
1-0101-SGAD-A020-001	STAIR 2 SECTION
1-0101-SGAD-A021-001	MONORAIL DETAILS
1-0101-SGAD-P001-001	LOWER LEVEL PLAN
1-0101-SGAD-P002-001	MAIN FLOOR FRAMING PLAN MAIN FLOOR CMU WALLS PLAN
1-0101-SGAD-P003-001	SECOND FLOOR FRAMING PLAN SECOND FLOOR CMU WALLS PLAN
1-0101-SGAD-P004-001	MECHANICAL PLATFORM FRAMING

REFERENCE DRAWINGS STRUCTURAL	
DWG NO.	REFERENCE DRAWING TITLE
1-0101-SGAD-P005-001	ROOF FRAMING PLAN PENTHOUSE FRAMING PLAN
1-0101-SGAD-P006-001	PENTHOUSE FRAMING PLAN
1-0101-SGAD-P007-001	FRAMING ELEVATIONS
1-0101-SGAD-P007-002	FRAMING ELEVATIONS
1-0101-SGAD-P007-003	FRAMING ELEVATIONS
1-0101-SGAD-P010-001	SECTIONS
1-0101-SGAD-P010-002	SECTION
1-0101-SGAD-P010-003	SECTION
1-0101-SGAD-P010-004	SECTIONS
1-0101-SGAD-P010-005	SECTIONS
1-0101-SGAD-P010-006	SECTIONS
1-0101-SGAD-P010-007	SECTIONS
1-0101-SGAD-P011-001	SECTIONS
1-0101-SGAD-P011-002	SECTIONS

REFERENCE DRAWINGS STRUCTURAL	
DWG NO.	REFERENCE DRAWING TITLE
1-0101-SGAD-P012-001	WALL SECTIONS
1-0101-SGAD-P014-001	DETAILS
1-0101-SGAD-P014-002	DETAILS
1-0101-SGAD-P014-003	DETAILS
1-0101-SGAD-P015-001	EMBED WEAR PLATES
1-0101-SGAD-P015-002	DETAILS
1-0101-SGAD-P016-001	STAIR 1 PLANS
1-0101-SGAD-P016-002	STAIR 1 PLANS
1-0101-SGAD-P016-003	STAIR 1 PLANS
1-0101-SGAD-P016-004	STAIR 1 PLANS
1-0101-SGAD-P017-001	STAIR 1 SECTIONS
1-0101-SGAD-P018-001	STAIR DETAILS
1-0101-SGAD-P019-001	STAIR 2 PLANS
1-0101-SSCH-A001-001	SCHEDULES

DESIGNED BY: CT				CHECKED BY: MB			
DRAWN BY: BF				APPROVED BY: NW			
SCALE: As indicated				RELEASED FOR CONSTRUCTION BY:			
DATE: 2020-12-09				DATE:			
CONSULTANT NO.: P3-S200							
01	ISSUED FOR ADDENDUM 11	2025-04-04	CT	MB			
00	ISSUED FOR TENDER	2025-01-31	CT	MB			
NO.	REVISIONS	DATE	DESIGN	CHECK			

ENGINEER'S SEAL				TENDER NO. 721-2024			
THE CITY OF WINNIPEG WATER AND WASTE DEPARTMENT				NORTH END SEWAGE TREATMENT PLANT PRIMARY CLARIFICATION PROJECT STRUCTURAL FRAMING ELEVATIONS			
CITY DRAWING NUMBER 1-0101-SGAD-P007				SHEET 001			
				REV. 01			
				SIZE A1			